 


1 FIRE ALARM TERMINAL CABINET WITHIN 2-HR RATED SHAFT ACCESSIBLE VIA 2-HR RATED ACCESS PANEL. COORDINATE INSTALLATION AND ACCESS WITH DIVISION 26.

159 South Jackson St, Suite 600
Seattle, Washington 98104 USA
+1 206 624 5670 olsonkundig.com

project:
SOMMET BLANC - AB
DEER VALLEY, UTAH



White Summit Development, LLC
PO Box 980022
Park City, Utah 84098

Acoustic Consultant
BRC Acoustics
1932 1st Ave, Suite 620
Seattle, WA 98101

Pool Consultant
Cloward H2O
2696 N University Ave, Suite 290
Provo, UT 84604

Landscape Architect
EPG Design
6949 South High Tech Drive, Suite 100
Midvale, Utah 84047

Specifications Writer
Friday Group
88 Mainelli Road
Middlebury, VT

Code Consultant
Holmes
600 1st Avenue, Suite 200A
Seattle, WA 98104

Fire Protection Engineer
Jensen Hughes
One Research Drive, Suite 305C
Westborough, MA 01581

Vertical Transportation Consultant
Lerch Bates
19515 North Creek Parkway, Suite 300
Bothell, WA 98011

Structural Engineer
Magnusson Klemencic Associates
1301 5th Ave, Suite 3200
Seattle, WA 98101

Lighting Designer
O-
1319 SE MLK Blvd, Suite 210
Portland, Oregon 97219

Building Envelope Consultant
RDH
2101 N 34th St
Seattle, WA 98103

Accessibility Consultant
Studio Pacifica
2144 Westlake Ave N, Suite F
Seattle, WA 98109

MEP Engineer
WSP USA
1001 Fourth Ave., Suite 3100
Seattle, WA 98154

principal architect _____
project manager JCC
drawn by CRB SMK

checked by Checker
job no. 20052

revisions:


[illegible]

no. date

ISSUE FOR
CONSTRUCTION
11/18/2022

FIRE ALARM PLAN -
TOWER B - LVL 3


FA2.2B.13

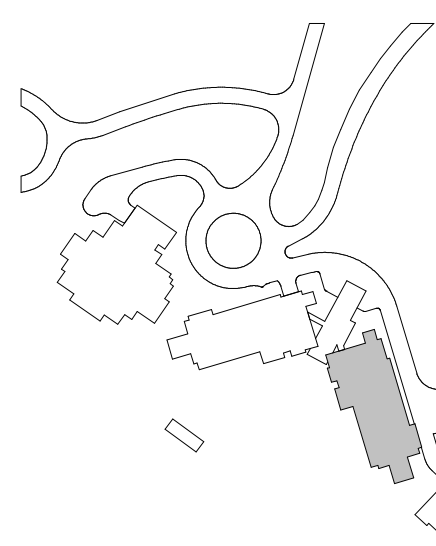

- 159 South Jackson St, Suite 600
Seattle, Washington 98104 USA
+1 206 624 5670 olsonkundig.com

Olson Kundig

 project:
SOMMET BLANC - AB
DEER VALLEY, UTAH



White Summit Development, LLC
PO Box 980022
Park City, Utah 84098

Acoustic Consultant
BRC Acoustics
1932 1st Ave. Suite 1

Seattle, WA 98101

Pool Consultant
Cloward H2O
2696 N University Ave, Suite 290
Provo, UT 84604

Landscape Architect
EPG Design
6949 South High Tech Drive, Suite 100
Midvale, Utah 84047

Specifications Writer
Friday Group
88 Mainelli Road
Middlebury, VT

Code Consultant
Holmes
600 1st Avenue, Suite 200A
Seattle, WA 98104

Fire Protection Engineer
Jensen Hughes
One Research Drive, Suite 3050
Westborough, MA 01581

Vertical Transportation Consultant
Lerch Bates
19515 North Creek Parkway, Suite 300
Bothell, WA 98011

Structural Engineer
Magnusson Klemencic Associates
1301 5th Ave, Suite 3200
Seattle, WA 98101

Lighting Designer
O-
1319 SE MLK Blvd, Suite 210
Portland, Oregon 97219

Building Envelope Consultant
RDH
2101 N 34th St
Seattle, WA 98103

Accessibility Consultant
Studio Pacifica
2144 Westlake Ave N, Suite F
Seattle, WA 98109

MEP Engineer
WSP USA
1001 Fourth Ave., Suite 3100
Seattle, WA 98154

principal architect_____

project manager: JOC
drawn by: CRB, SMK

checked by Checker
job no. 20052

date 11/18/2022

revisions:


no. date _____

ISSUE FOR CONSTRUCTION

11/18/2022

FIRE ALARM PLAN -
TOWER B - LVL 4

FA2.2B.14

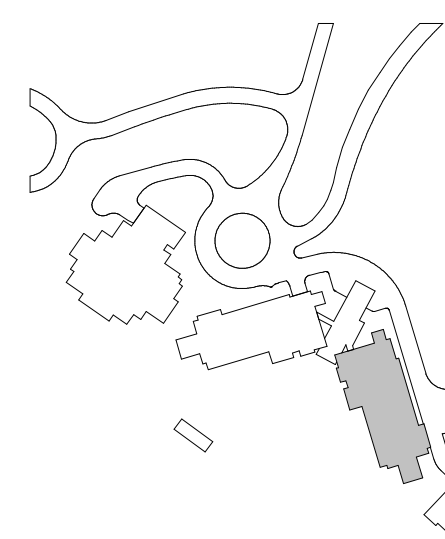

- Reserved for permit stamp

159 South Jackson St, Suite 800
Seattle, Washington 98104 USA
+1 206 624 5670 osonkund@gmail.com

Olson Kundig

project:
SOMMET BLANC - AB
DEER VALLEY, UTAH

White Summit Development, LLC
PO Box 980022
Park City, Utah 84098

Acoustic Consultant
BRC Acoustics
1932 1st Ave, Suite 620
Seattle, WA 98101

Pool Consultant
Cloward H2O
2696 N University Ave, Suite 290
Provo, UT 84604

Landscape Architect
EPG Design
6949 South High Tech Drive, Suite 100
Midvale, Utah 84047

Specifications Writer
Friday Group
88 Mainelli Road
Middlebury, VT

Code Consultant
Holmes
600 1st Avenue, Suite 200A
Seattle, WA 98104

Fire Protection Engineer
Jensen Hughes
One Research Drive, Suite 3050
Westborough, MA 01581

Vertical Transportation Consultant
Lerch Bates
19515 North Creek Parkway, Suite 300
Bothell, WA 98011

Structural Engineer
Magnusson Klemencic Associates
1301 5th Ave, Suite 3200
Seattle, WA 98101

Lighting Designer
O.
1319 SE MLK Blvd, Suite 210
Portland, Oregon 97219

Building Envelope Consultant
RDH
2101 N 34th St
Seattle, WA 98103

Accessibility Consultant
Studio Pacifica
2144 Westlake Ave N, Suite F
Seattle, WA 98109

MEP Engineer
WSP USA
1001 Fourth Ave., Suite 3100
Seattle, WA 98154

principal architect _____
project manager: JCC _____
drawn by: CRB, SMK _____

checked by: Checker
job no. 20052

revisions:


[illegible]

no. date

ISSUE FOR
CONSTRUCTION
11/18/2022

FIRE ALARM PLAN -
TOWER B - LVL 5

FA2.2B.15

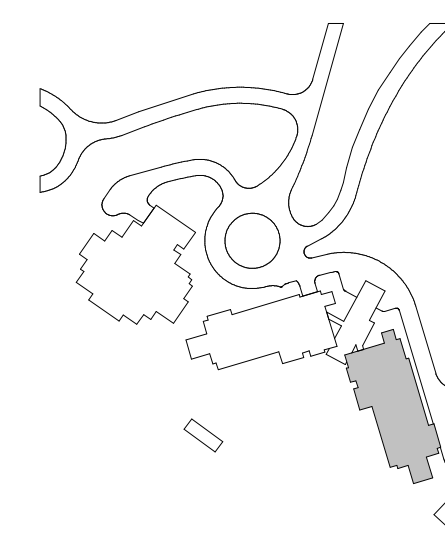

1 FIRE ALARM TERMINAL CABINET WITHIN 2-HR RATED SHAFT ACCESSIBLE VIA 2-HR RATED ACCESS PANEL. COORDINATE INSTALLATION AND ACCESS WITH DIVISION 26.

159 South Jackson St., Suite 600
Seattle, Washington 98104 USA
+1 206 624 5670 olsonkundig.com

project: **SOMMET BLANC - AB**
DEER VALLEY, UTAH

Acoustic Consultant

BRC Acoustics
1932 1st Ave, Suite 620
Seattle, WA 98101

Pool Consultant

Cloward H20
2696 N University Ave, Suite 290
Provo, UT 84604

Landscape Architect

EPG Design
8949 South High Tech Drive, Suite 100
Midvale, Utah 84047

Specifications Writer

Friday Group
88 Mainelli Road
Middlebury, VT

Code Consults

Holmes
800 1st Avenue, Suite 200A
Seattle, WA 98104

Fire Protection Engineer

Jensen Hughes
One Research Drive, Suite 305C
Westborough, MA 01581

Vertical Transportation Consultant

Lerch Bates
19515 North Creek Parkway, Suite 304
Bothell, WA 98011

Structural Engineer

Magnusson Klemencic Associate
1301 5th Ave, Suite 3200
Seattle, WA 98101

Lighting Design

1319 SE MLK Blvd, Suite 210
Portland, Oregon 97219

Building Envelope Consultant
RDH

Seattle, WA 98103

Studio Pacifica
2144 Westlake Ave N, Suite F
Seattle, WA 98109

MEP Engineer
WSP USA

principal architect _____
project manager JCC _____

University _____

job no. 20052
date 11/18/2022

revisions:


no. date b

ISSUE FOR
CONSTRUCTION

11/18/2022

FIRE ALARM PLAN -
TOWER B - LVL 6

FA2.2B.16

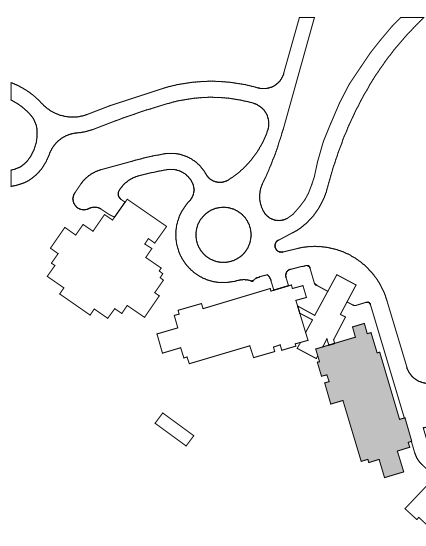


- KEYNOTES
- 1 FIRE ALARM TERMINAL CABINET WITHIN 2-HR RATED SHUT ACCESSIBLE VIA 2-HR RATED ACCESS PANEL COORDINATE INSTALLATION AND ACCESS WITH DIVISION 28
 - 2 2-HR UL LISTED RATED COAXIAL CARLING SYSTEM FROM RGA TO 2-HR RATED CLOSET COAXIAL BACKBONE TO BE INSTALLED IN 2-HR CLOSET NEXT TO FIRE ALARM RISER WITH SHUTTERS AT EACH LEVEL ACCESSIBLE FROM SAME ACCESS PANEL PROVIDED FOR RATO ACCESS
 - 3 STAR SPEAKER FOR MANUAL PAGING CONNECTED TO DEDICATED CIRCUIT

Reserved for permit stamp

100 South Jackson St, Suite 600
Seattle, Washington 98104 USA
+1 206 834 2870 olsonkundig.com

Olson Kundig

 project
SOMMET BLANC - AB
DEER VALLEY, UTAH



White Summit Development, LLC
PO Box 980022
Park City, Utah 84098

Acoustic Consultant
BRC Acoustics
1932 1st Ave, Suite 620
Seattle, WA 98101

Pool Consultant
Cloward H2O
2696 N University Ave, Suite 290
Provo, UT 84604

Landscape Architect
EPG Design
6949 South High Tech Drive, Suite 100
Midvale, Utah 84047

Specifications Writer
Friday Group
86 Mainelli Road
Middlebury, VT

Code Consultant
Holmes
600 1st Avenue, Suite 200A
Seattle, WA 98104

Fire Protection Engineer
Jensen Hughes
One Research Drive, Suite 305C
Westborough, MA 01581

Vertical Transportation Consultant
Larch Bates
19515 North Creek Parkway, Suite 304
Bothell, WA 98011

Structural Engineer
Magnusson Klemencic Associates
1301 5th Ave, Suite 3200
Seattle, WA 98101

Lighting Designer
O
1319 SE MLK Blvd, Suite 210
Portland, Oregon 97219

Building Envelope Consultant
RDH
2101 N 34th St
Seattle, WA 98103

Accessibility Consultant
Studio Pacifica
2144 Westlake Ave N, Suite F
Seattle, WA 98109

MEP Engineer
WSP USA
1001 Fourth Ave., Suite 3100
Seattle, WA 98154

principal architect _____
project manager _____ JCC
drawn by _____ CRB_SMK
checked by _____ Checker
job no. _____ 2052
date _____ 11/18/2022


revisions:

no. _____ date _____ by _____


ISSUE FOR
CONSTRUCTION
11/18/2022

FIRE ALARM PLAN -
TOWER B - LVL 7

FA2.2B.17

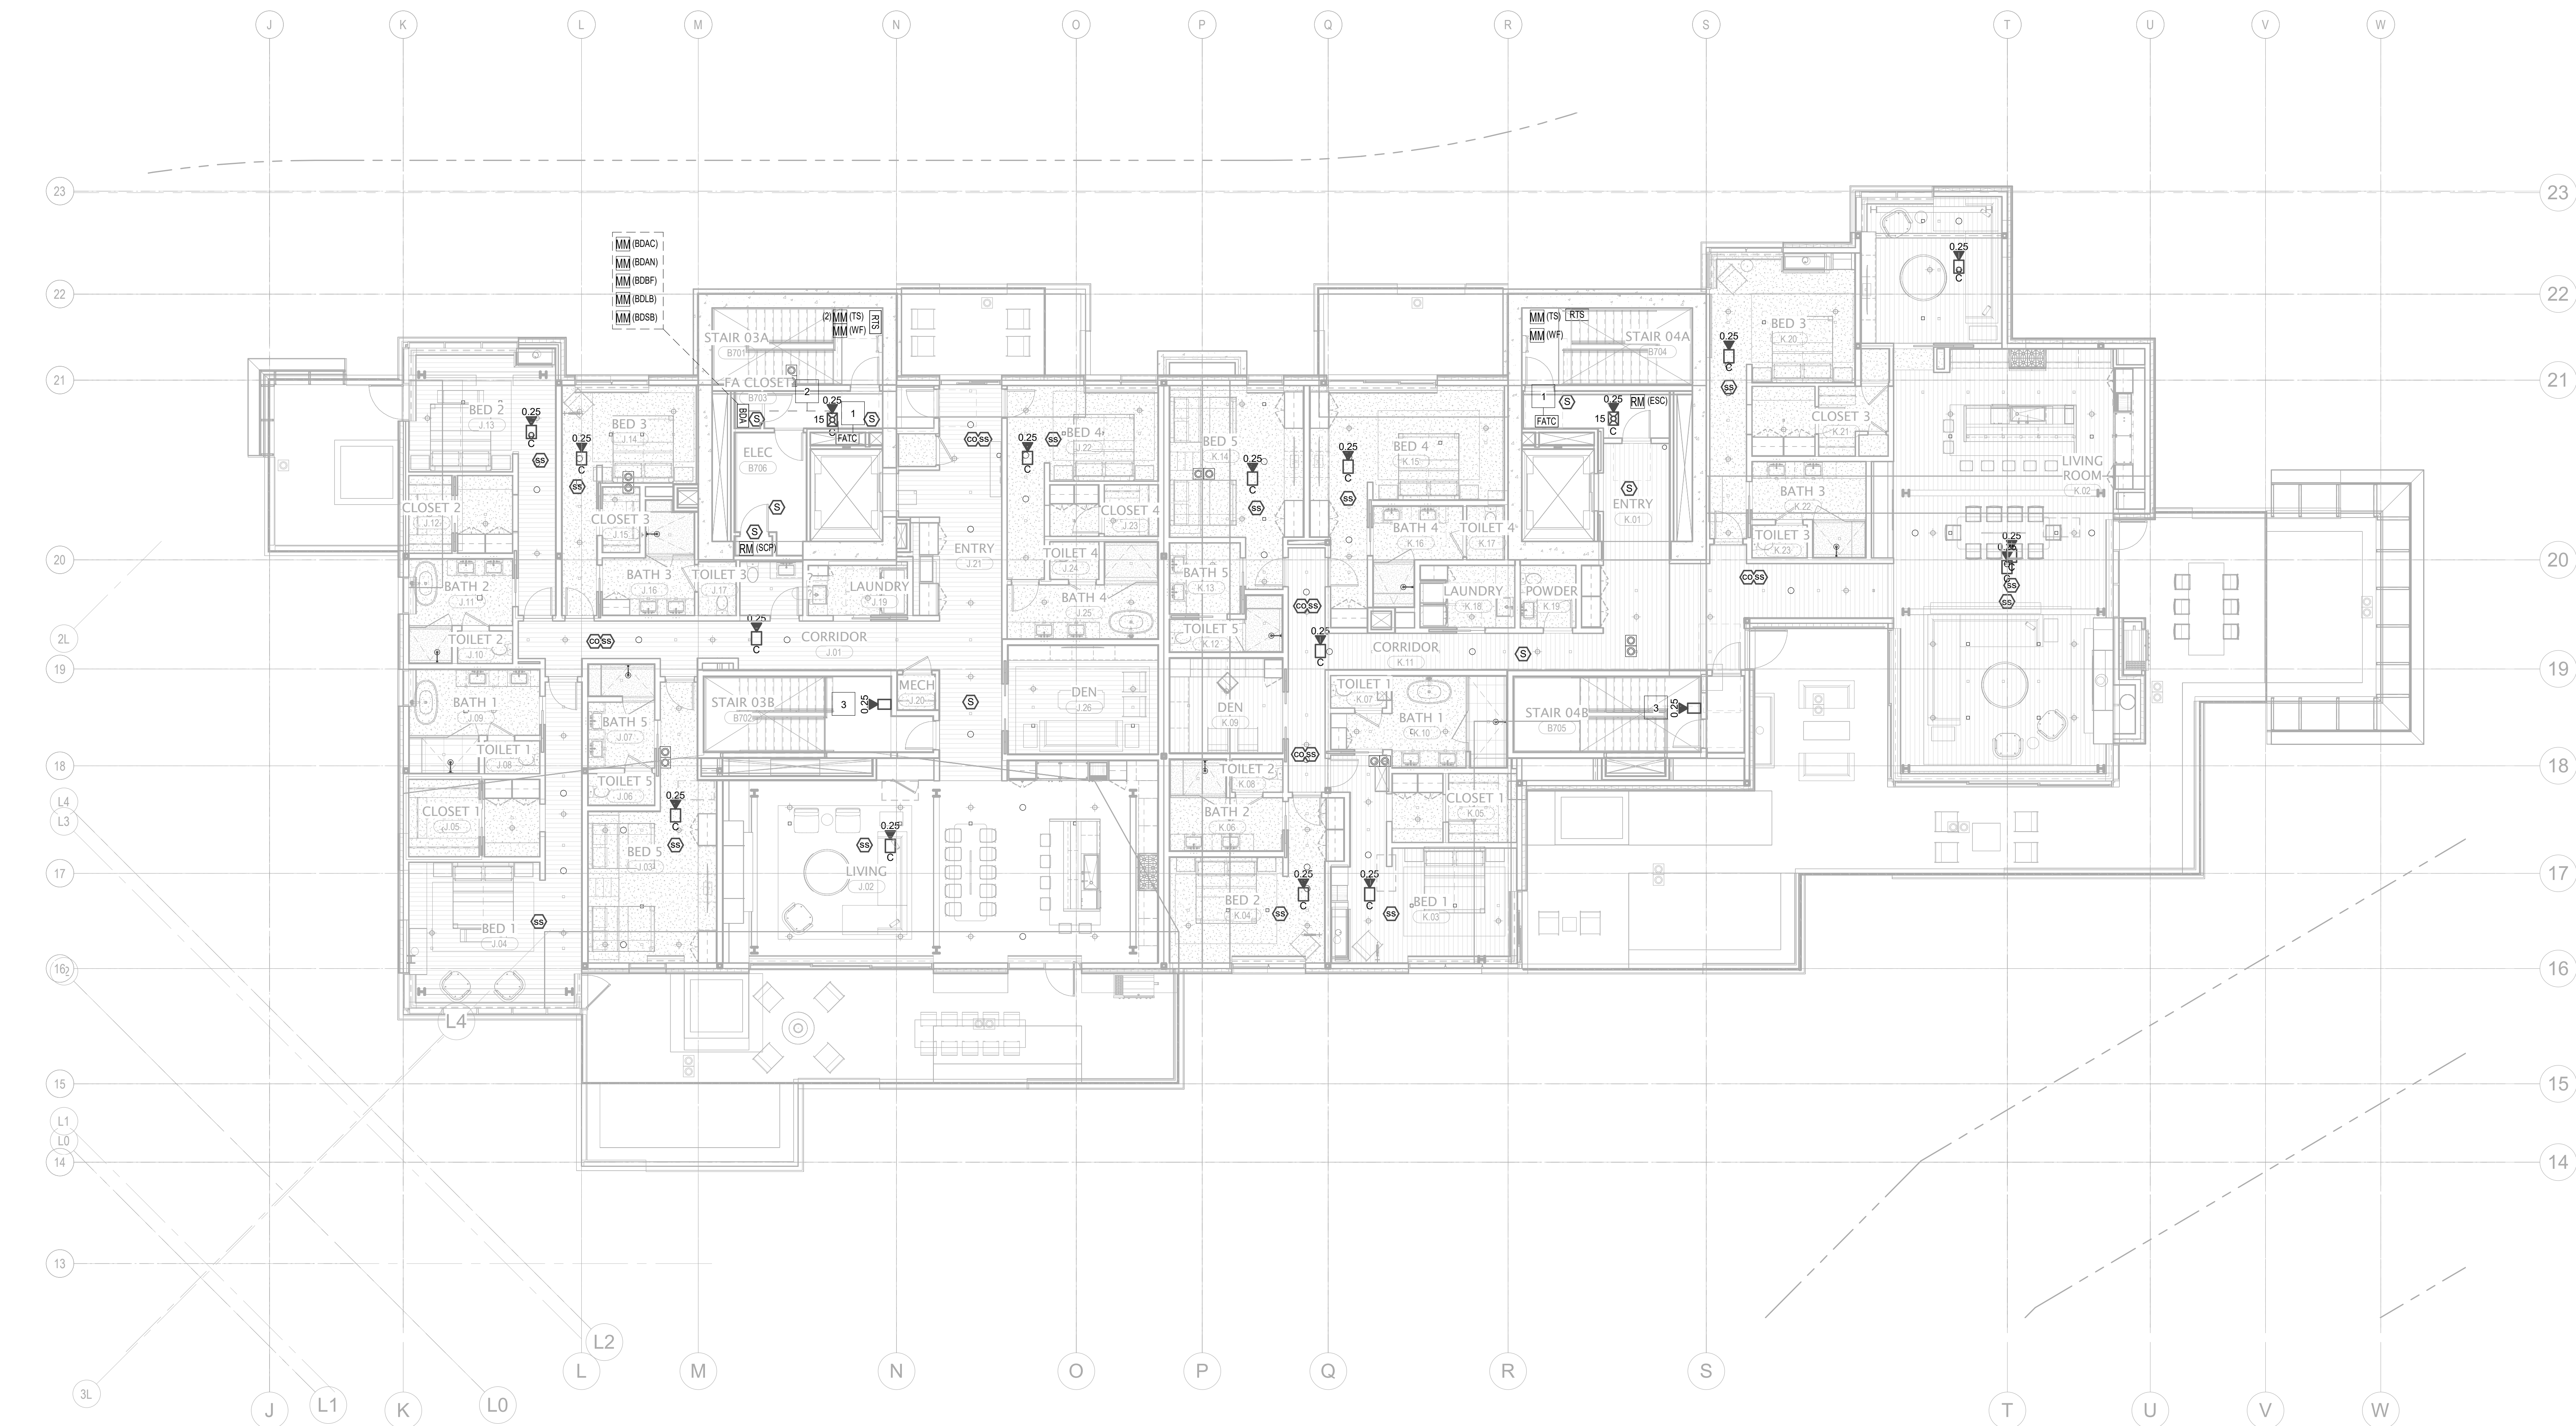

1 TOWER B - LEVEL 7 - FA
1/8" = 1'-0"

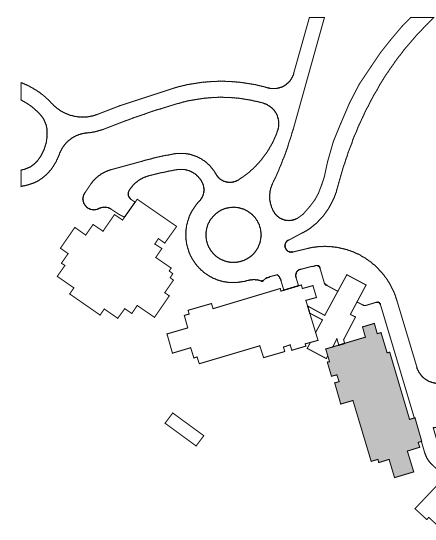

- [illegible]

FA2.2B.R