


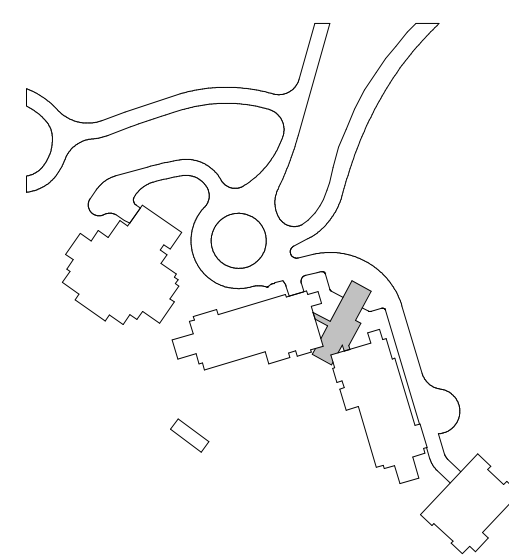

FA2.2AB.11



 
- KEYNOTES:
- 1 FIRE ALARM TERMINAL CABINET EXPOSED.
 - 2 STAR SPEAKER FOR MANUAL PAGING CONNECTED TO DEDICATED CIRCUIT.

Reserved for permit stamp

100 South Jackson St., Suite 600
Seattle, Washington 98104 USA
+1 206 834 2870 olsonkundig.com

Olson Kundig

project
SOMMET BLANC - AB
DEER VALLEY, UTAH



White Summit Development, LLC
PO Box 980022
Park City, Utah 84098

Acoustic Consultant
BRC Acoustics
1932 1st Ave, Suite 620
Seattle, WA 98101

Pool Consultant
Cloward H2O
2696 N University Ave, Suite 290
Provo, UT 84604

Landscape Architect
EPG Design
6948 South High Tech Drive, Suite 100
Midvale, Utah 84047

Specifications Writer
Friday Group
86 Mainelli Road
Middlebury, VT

Code Consultant
Holmes
600 1st Avenue, Suite 200A
Seattle, WA 98104

Fire Protection Engineer
Jensen Hughes
One Research Drive, Suite 305C
Westborough, MA 01581

Vertical Transportation Consultant
Larch Bates
19515 North Creek Parkway, Suite 304
Bothell, WA 98011

Structural Engineer
Magnusson Klemencic Associates
1301 5th Ave, Suite 3200
Seattle, WA 98101

Lighting Designer
O
1319 SE MLK Blvd, Suite 210
Portland, Oregon 97219

Building Envelope Consultant
RDH
2101 N 34th St
Seattle, WA 98103

Accessibility Consultant
Studio Pacifica
2144 Westlake Ave N, Suite F
Seattle, WA 98109

MEP Engineer
WSP USA
1001 Fourth Ave., Suite 3100
Seattle, WA 98154

principal architect_____
project manager____JCC_____
drawn by____CRB_SMM_____
checked by____Checker_____
job no. 2052
date 11/18/2022


revisions:

no.____date____by____


ISSUE FOR
CONSTRUCTION
11/18/2022

FIRE ALARM PLAN -
TOWER B - LVL B1


FA2.2B.01

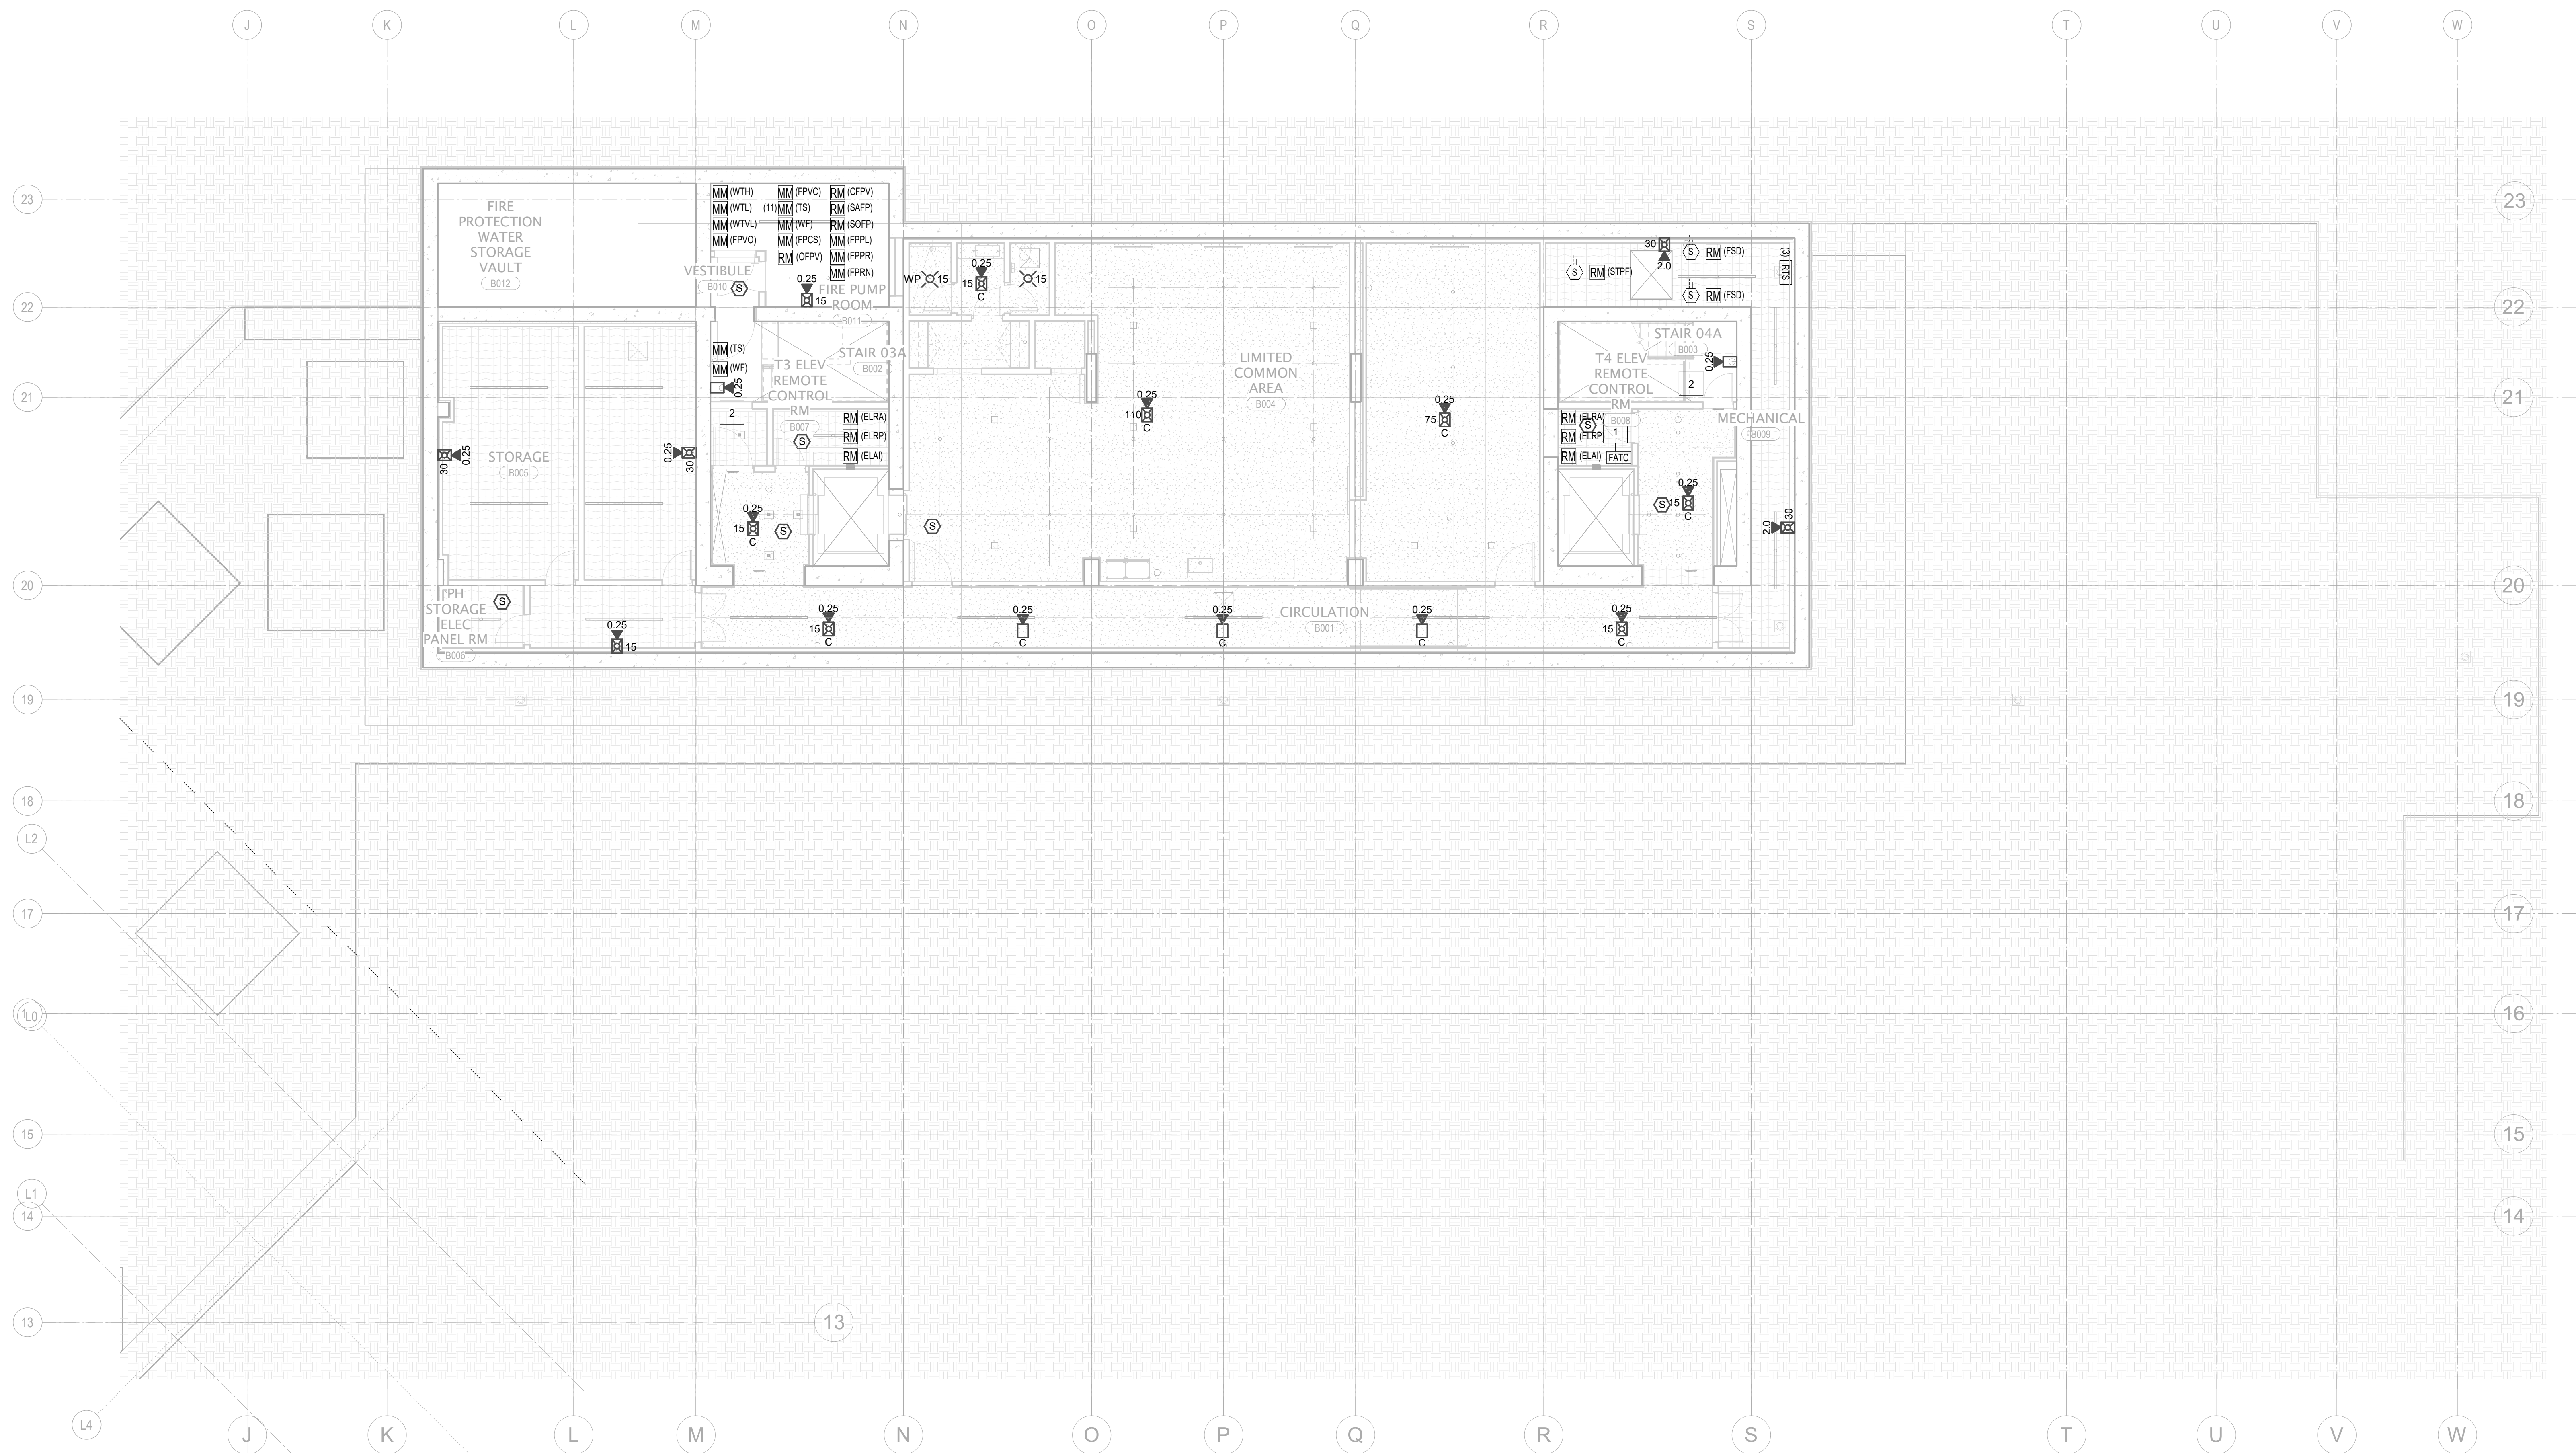

1 TOWER B - LEVEL B1 - FA
1/8" = 1'-0"

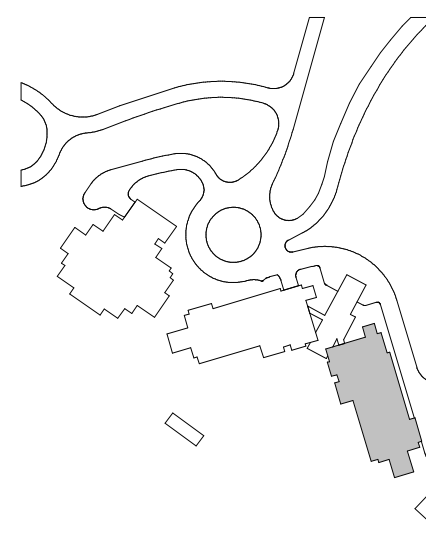

- KEYNOTES:
- 1 FIRE ALARM TERMINAL CABINET WITHIN 2-HR RATED SHAFT ACCESSIBLE VIA 2-HR RATED ACCESS PANEL. COORDINATE INSTALLATION AND ACCESS WITH DIVISION 26. TRANSITION FROM 2-HR GC TO FPL CABLE IN ENT AT THIS POINT.
 - 2 2-HR OLC SLC AND NAC FROM FCC TO 2-HR RATED SHAFT. ROUTING SHOWN FOR CONCEPTUAL PURPOSES ONLY.
 - 3 DEDICATED SPEAKER CIRCUIT (2-HR OLC) TO STAIR SPEAKERS. TRANSITION TO FPL IN ENT AT FIRST DEVICE.

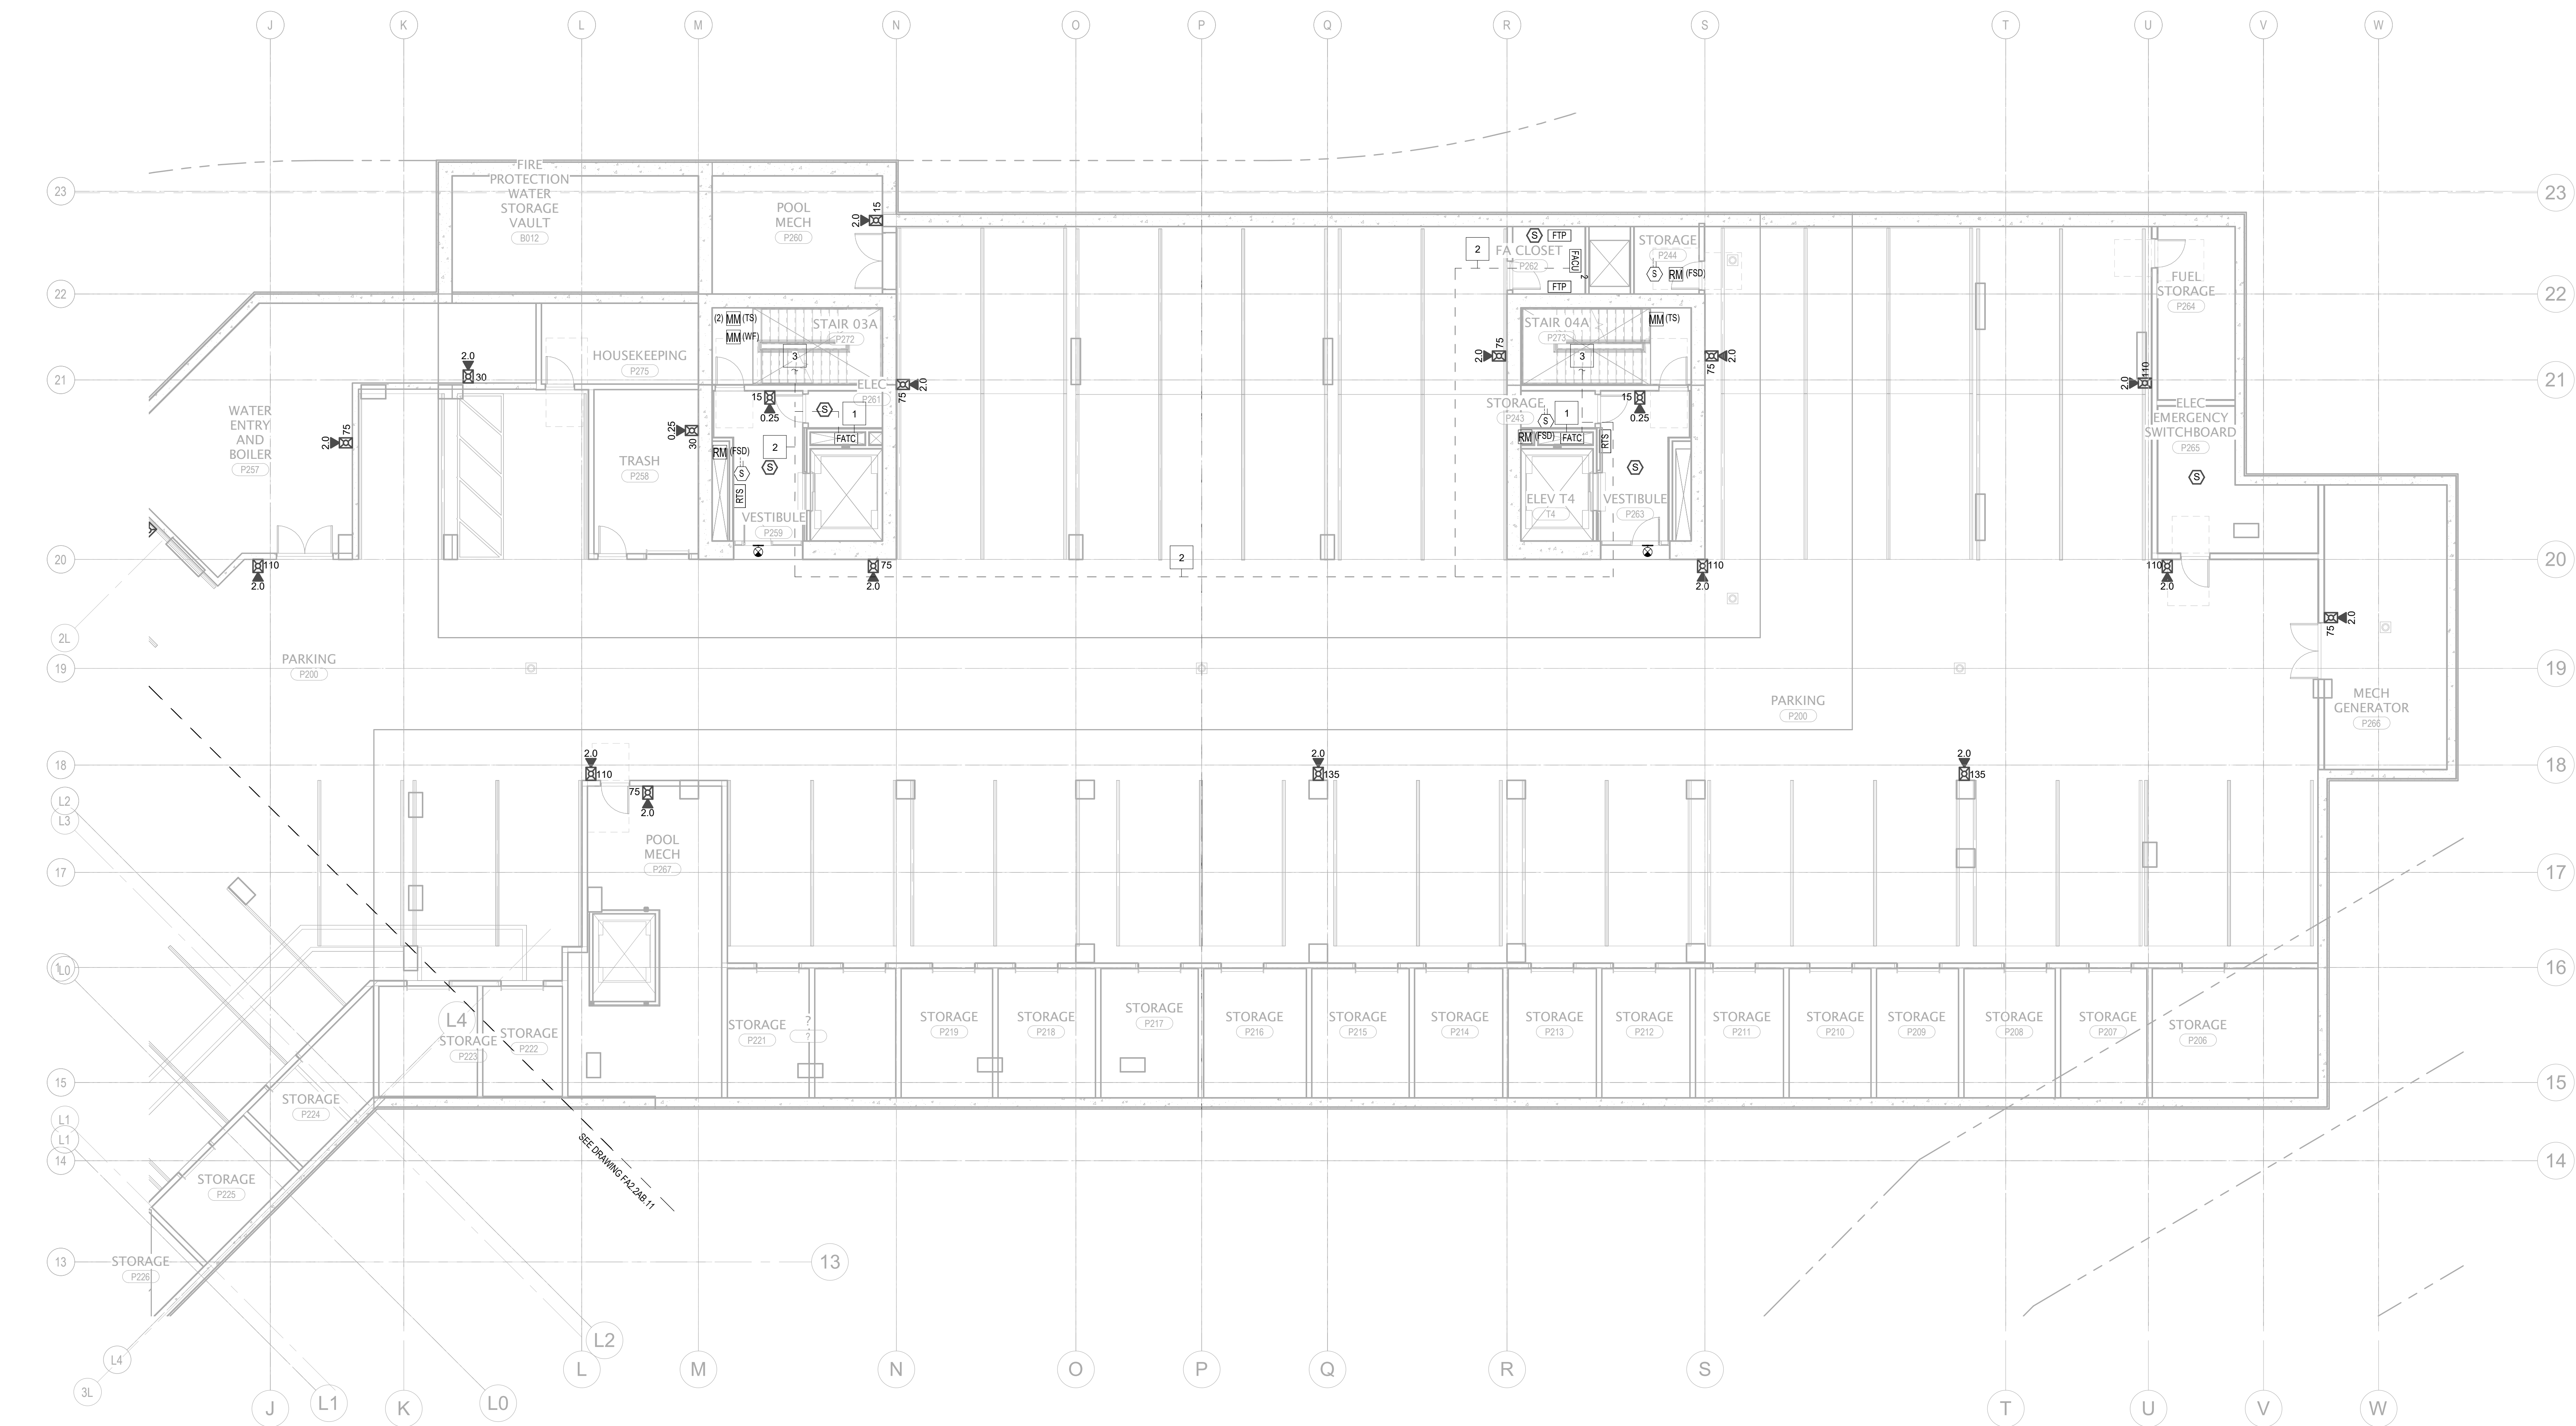

1 TOWER B - PARKING LEVEL 2 - FA
1/8" = 1'-0"

100 South Jackson St., Suite 600
Seattle, Washington 98104 USA
+1 206 834 2870 olsonkundig.com

Olson Kundig

project
SOMMET BLANC - AB
DEER VALLEY, UTAH

White Summit Development, LLC
PO Box 980022
Park City, Utah 84098

Acoustic Consultant
BRC Acoustics
1932 1st Ave., Suite 620
Seattle, WA 98101

Pool Consultant
Cloward H2O
2696 N University Ave., Suite 290
Provo, UT 84604

Landscape Architect
EPG Design
6948 South High Tech Drive, Suite 100
Midvale, Utah 84047

Specifications Writer
Friday Group
86 Mainelli Road
Middlebury, VT

Code Consultant
Holmes
600 1st Avenue, Suite 200A
Seattle, WA 98104

Fire Protection Engineer
Jensen Hughes
One Research Drive, Suite 305C
Westborough, MA 01581

Vertical Transportation Consultant
Larch Bates
19515 North Creek Parkway, Suite 304
Bothell, WA 98011

Structural Engineer
Magnusson Klemencic Associates
1301 5th Ave., Suite 3200
Seattle, WA 98101

Lighting Designer
O
1319 SE MLK Blvd, Suite 210
Portland, Oregon 97219

Building Envelope Consultant
RDH
2101 N 34th St
Seattle, WA 98103

Accessibility Consultant
Studio Pacifica
2144 Westlake Ave N, Suite F
Seattle, WA 98109

MEP Engineer
WSP USA
1001 Fourth Ave., Suite 3100
Seattle, WA 98154

principal architect _____
project manager _____ JCC
drawn by _____ CRB, SMR
checked by _____ Checker
job no. _____ 2052
date _____ 11/18/2022


revisions:

no. _____ date _____ by _____

ISSUE FOR
CONSTRUCTION
11/18/2022

FIRE ALARM PLAN -
TOWER B - LVL P2

FA2.2B.02

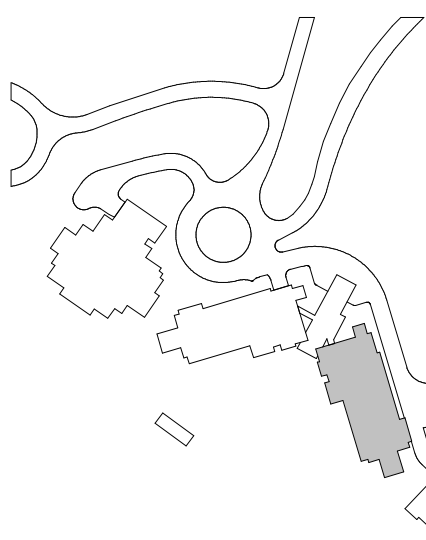


- | | KEYNOTES: |
|---|---|
| 1 | FIRE ALARM TERMINAL CABINET WITHIN 24HR RATED SHAFT ACCESSIBLE VIA 24HR RATED ACCESS PANEL. COORDINATE INSTALLATION AND ACCESS WITH DIVISION 28. |
| 2 | NO FATC THIS LEVEL. |
| 3 | ACCESSORY CABINET ENCLOSURE FOR SMOKE CONTROL FAN INTERFACE LOCATED IN 2HR RATED ENCLOSURE ADJACENT TO FAN VFD (FOR FANS SPF-S-P1-1 THRU SPF-S-P1-4). REFER TO DETAIL 5.0 ON FAT01 FOR ADDITIONAL INFORMATION. MODULES SHALL BE CONNECTED TO 24HR DEDICATED SLC FROM BUILDING B FACU. |
| 4 | STAIR PRESSURIZATION FAN DUCT DETECTOR. |

Reserved for permit stamp	
---------------------------	--

159 South Jackson St, Suite 800
Seattle, Washington 98104 USA
+1 206 624 5670 olsonkundig.com

Olson Kundig

 SOMMET BLANC - AB
DEER VALLEY, UTAH



White Summit Development, LLC
PO Box 980022
Park City, Utah 84098

Acoustic Consultant
BRC Acoustics
1932 1st Ave, Suite 620
Seattle, WA 98101

Pool Consultant
Cloward H2O
2696 N University Ave, Suite 290
Provo, UT 84604

Landscape Architect
EPG Design
6949 South High Tech Drive, Suite 100
Midvale, Utah 84047

Specifications Writer
Friday Group
88 Mainelli Road
Middlebury, VT

Code Consultant
Holmes
600 1st Avenue, Suite 200A
Seattle, WA 98104

Fire Protection Engineer
Jensen Hughes
One Research Drive, Suite 305C
Westborough, MA 01581

Vertical Transportation Consultant
Lerch Bates
19515 North Creek Parkway, Suite 304
Bothell, WA 98011

Structural Engineer
Magnusson Klemencic Associates
1301 5th Ave, Suite 3200
Seattle, WA 98101

Lighting Designer
O-
1319 SE MLK Blvd, Suite 210
Portland, Oregon 97219

Building Envelope Consultant
RDH
2101 N 34th St
Seattle, WA 98103

Accessibility Consultant
Studio Pacifica
2144 Westlake Ave N, Suite F
Seattle, WA 98109

MEP Engineer
WSP USA
1001 Fourth Ave., Suite 3100
New York, NY 10017-2499
Tel: 212 512 2000
Fax: 212 512 2001
E-mail: usa@wsp.com
Web: www.wsp.com

principal architect _____
project manager JCC _____
drawn by CRB, SMK _____

checked by Checker _____
job no. 20052
date 11/18/2022

[illegible]



no. date by

ISSUE FOR
CONSTRUCTION

11/18/2022

FIRE ALARM PLAN -
TOWER B - LVL P1

FA2.2B.03

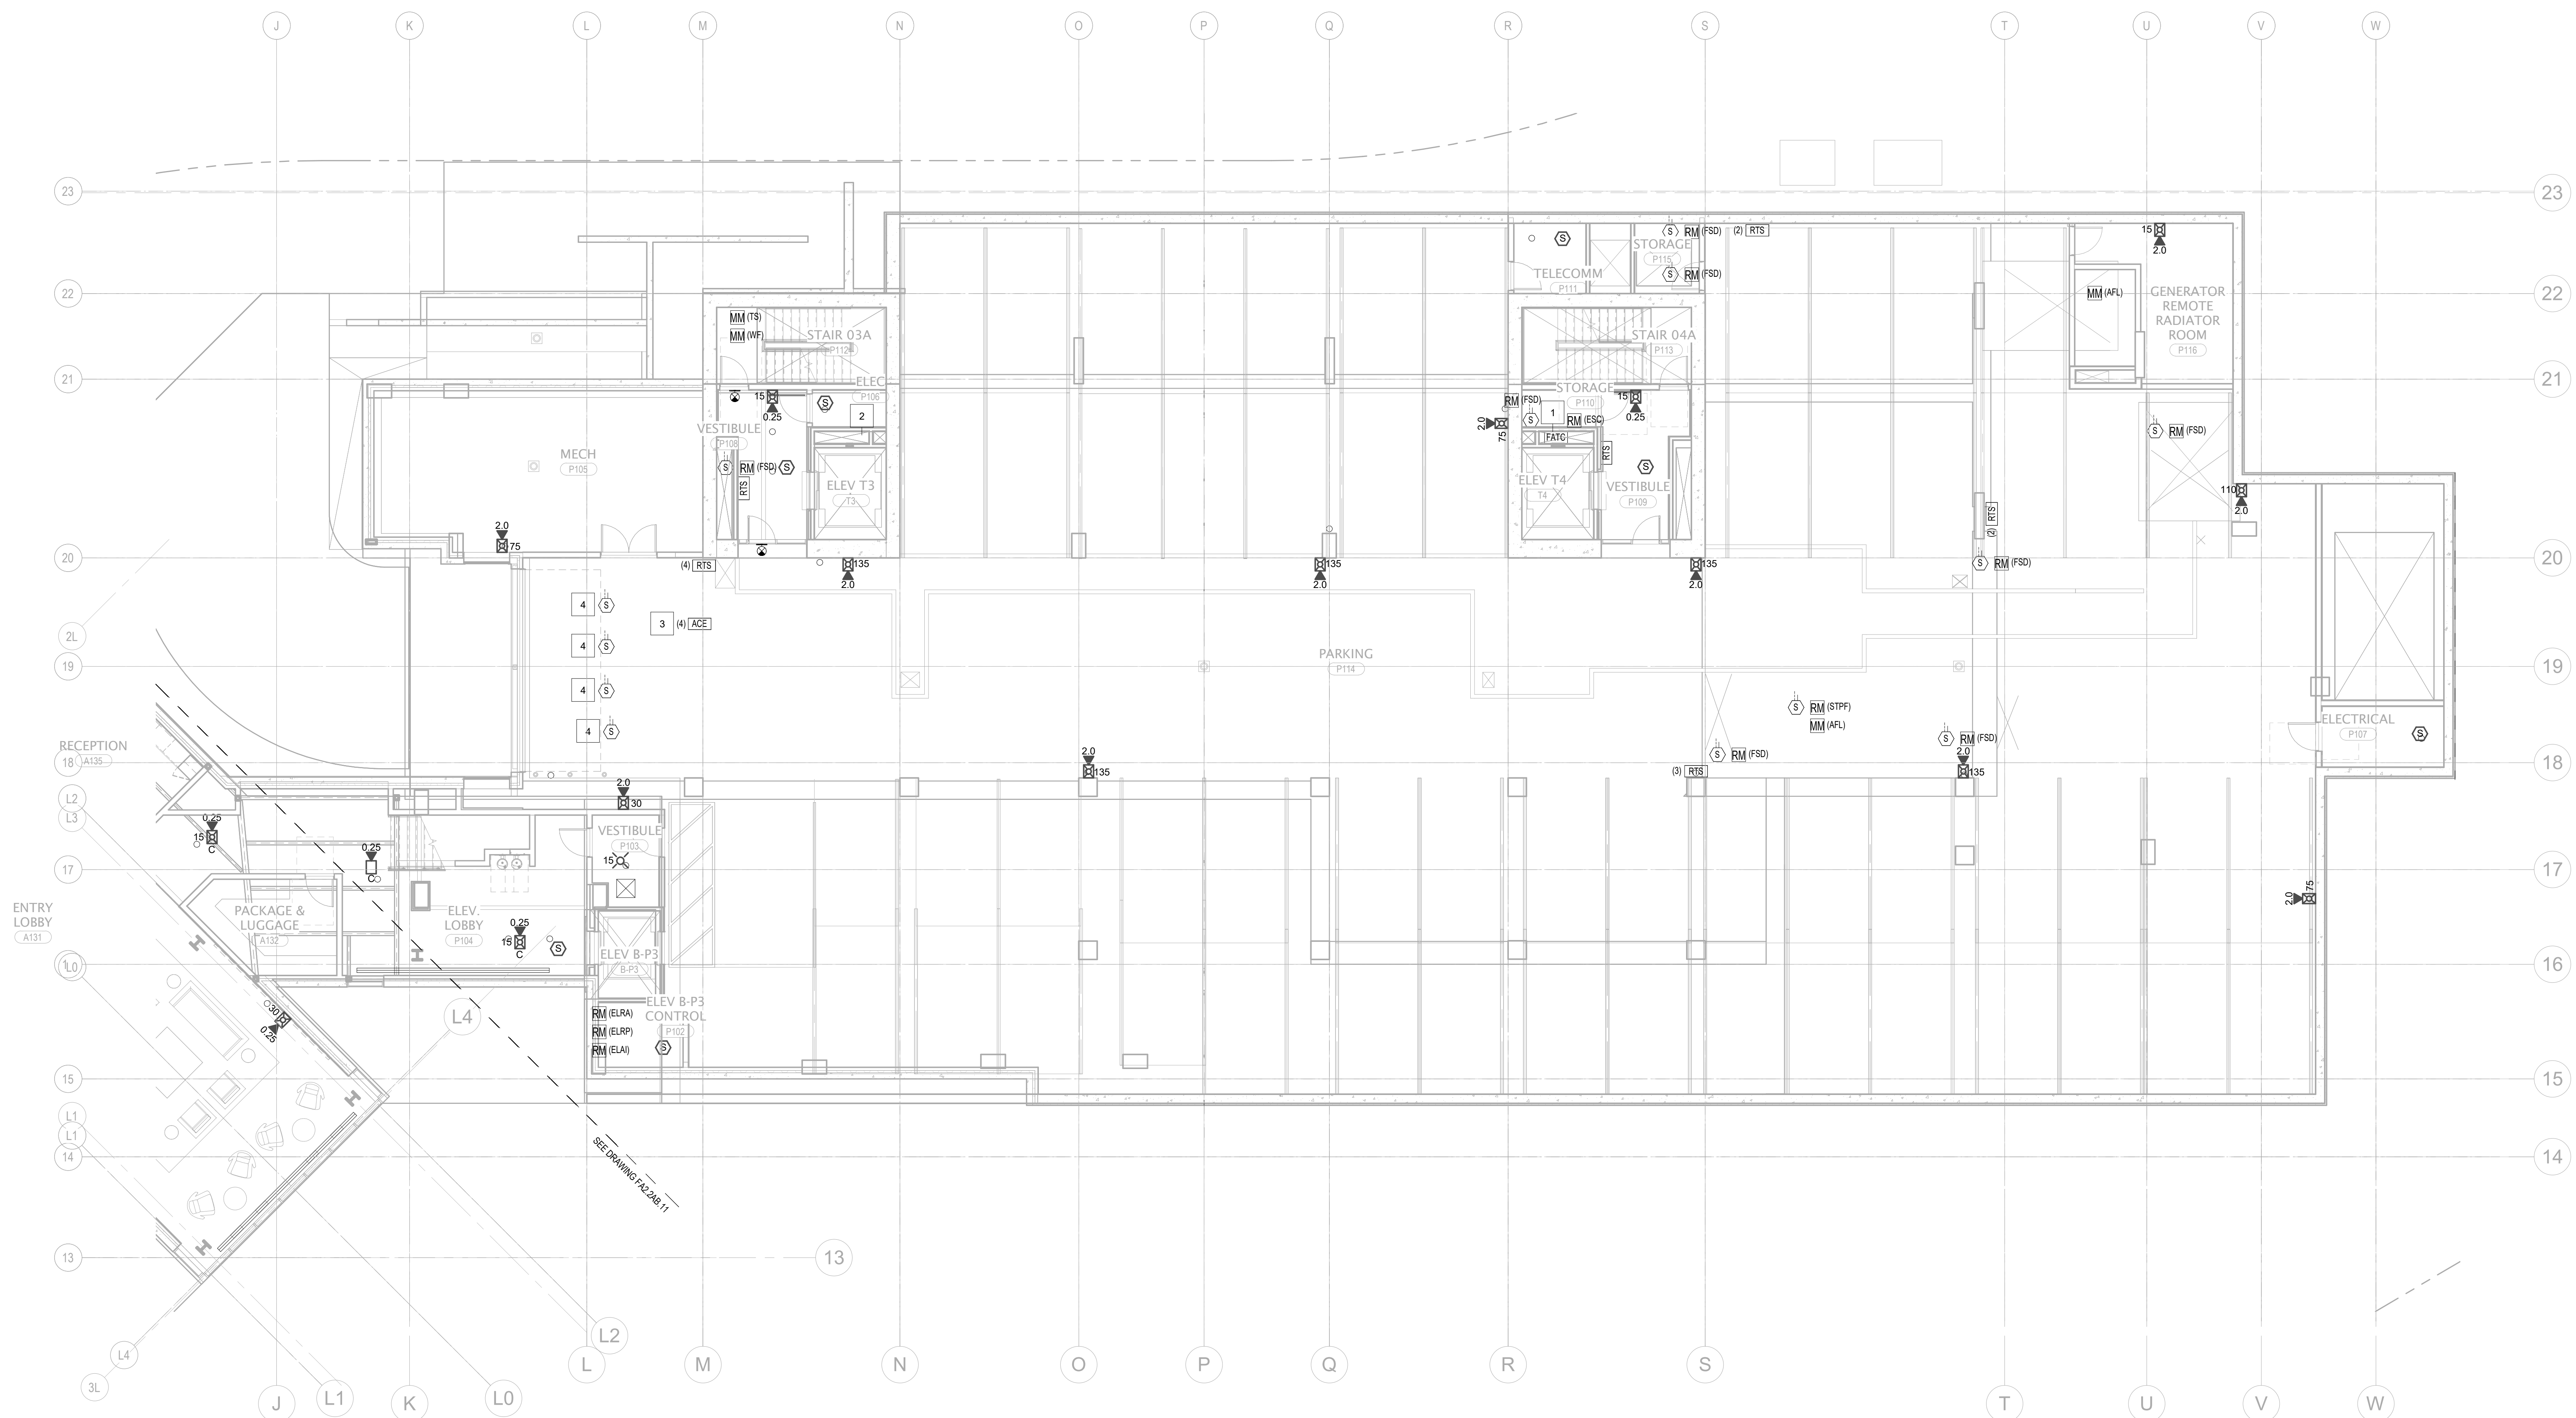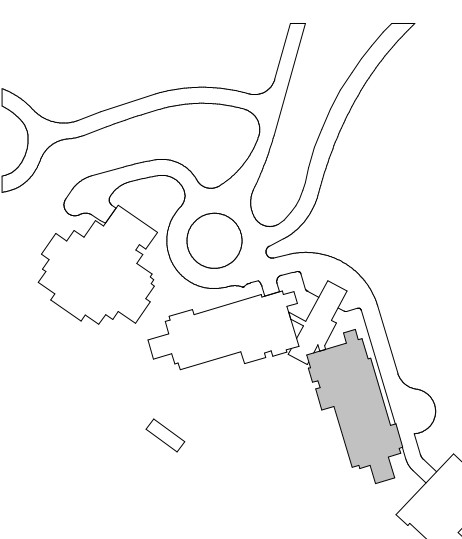

1 TOWER B - PARKING LEVEL 1 - FA
1/8" = 1'-0"

11/18/2022

- Reserved for permit stamp

159 South Jackson St, Suite 600
Seattle, Washington 98104 USA
+1 206 624 5670 olsonkundig.com

Olson Kundig

project:
SOMMET BLANC - AB
DEER VALLEY, UTAH

White Summit Development, LLC
PO Box 980022
Park City, Utah 84098

Acoustic Consultant
BRC Acoustics
1932 1st Ave, Suite 6
Seattle, WA 98101

Pool Consultant
Cloward H20
2696 N University Ave, Suite 290
Provo, UT 84604

Landscape Architect
EPG Design
6949 South High Tech Drive, Suite 100
Midvale, Utah 84047

Specifications Writer
Friday Group
88 Mainelli Road
Middlebury, VT

Code Consultant
Holmes
600 1st Avenue, Suite 200A
Seattle, WA 98104

Fire Protection Engineer
Jensen Hughes
One Research Drive, Suite 305C
Westborough, MA 01581

Vertical Transportation Consultant
Lerch Bates
19515 North Creek Parkway, Suite 300
Bothell, WA 98011

Structural Engineer
Magnusson Klemencic Associates
1301 5th Ave, Suite 3200
Seattle, WA 98101

Lighting Designer
O-
1319 SE MLK Blvd, Suite 210
Portland, Oregon 97219

Building Envelope Consultant
RDH
2101 N 34th St
Seattle, WA 98103

Accessibility Consultant
Studio Pacifica
2144 Westlake Ave N, Suite F
Seattle, WA 98109

MEP Engineer
WSP USA
1001 Fourth Ave., Suite 3100
Seattle, WA 98154

principal architect _____
project manager JCC
drawn by CRB, SMK
checked by Checker
job no. 20052
date 11/18/2022

revisions:


no. date b

ISSUE FOR

11/18/2022

FIRE ALARM PLAN -
TOWER B - LVL 1


FA2.2B.11

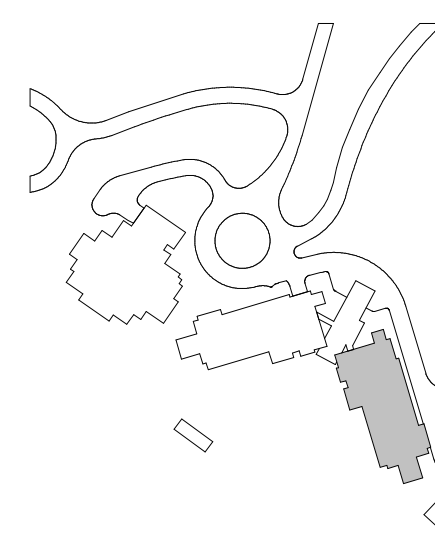

- 159 South Jackson St, Suite 600
Seattle, Washington 98104 USA
+1 206 624 5670 olsonkundig.com

Olson Kundig

 project:
SOMMET BLANC - AB
DEER VALLEY, UTAH



White Summit Development, LLC
PO Box 980022
Park City, Utah 84098

Acoustic Consultant
BRC Acoustics
1932 1st Ave, Suite 6
Seattle, WA 98101

Pool Consultant
Cloward H2O
2696 N University Ave, Suite 290
Provo, UT 84604

Landscape Architect
EPG Design
6949 South High Tech Drive, Suite 100
Midvale, Utah 84047

Specifications Writer
Friday Group
88 Mainelli Road
Middlebury, VT

Code Consultant
Holmes
600 1st Avenue, Suite 200A
Seattle, WA 98104

Fire Protection Engineer
Jensen Hughes
One Research Drive, Suite 3050
Westborough, MA 01581

Vertical Transportation Consultant
Lerch Bates
19515 North Creek Parkway, Suite 304
Bothell, WA 98011

Structural Engineer
Magnusson Klemencic Associates
1301 5th Ave, Suite 3200
Seattle, WA 98101

Lighting Designer
O-
1319 SE MLK Blvd, Suite 210
Portland, Oregon 97219

Building Envelope Consultant
RDH
2101 N 34th St
Seattle, WA 98103

Accessibility Consultant
Studio Pacifica
2144 Westlake Ave N, Suite F
Seattle, WA 98109

MEP Engineer
WSP USA
1001 Fourth Ave., Suite 3100
Seattle, WA 98154

principal architect _____
project manager JCC
drawn by CRB, SMK

checked by Checker
job no. 20052
date 11/18/2022

revisions:


no. date by

ISSUE FOR

11/18/2022

FIRE ALARM PLAN -
TOWER B - LVL 2

FA2.2B.12

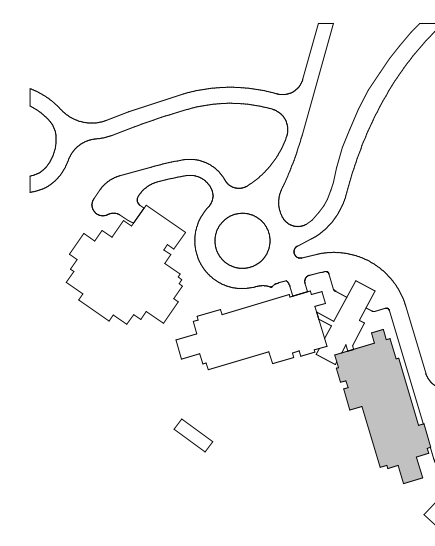

1 TOWER B - LEVEL 2 - FA
1/8" = 1'-0"