

 
- KEYNOTES:
- 1 FIRE ALARM TERMINAL CABINET WITHIN 2-HR RATED SHUT ACCESSIBLE VIA 2-HR RATED ACCESS PANEL. COORDINATE INSTALLATION AND ACCESS WITH DIVISION 26. TERMINAL CABINET SERVES LEVEL 4 AND LEVEL 5.
 - 2 STAR SPEAKER FOR MANUAL PAGING CONNECTED TO DEDICATED CIRCUIT.

Reserved for permit stamp

100 South Jackson St., Suite 600
Seattle, Washington 98104 USA
+1 206 834 2870 olsonkundig.com

Olson Kundig

project
SOMMET BLANC - AB
DEER VALLEY, UTAH



White Summit Development, LLC
PO Box 980022
Park City, Utah 84098

Acoustic Consultant
BRC Acoustics
1932 1st Ave, Suite 620
Seattle, WA 98101

Pool Consultant
Cloward H2O
2696 N University Ave, Suite 290
Provo, UT 84604

Landscape Architect
EPG Design
6948 South High Tech Drive, Suite 100
Midvale, Utah 84047

Specifications Writer
Friday Group
86 Mainell Road
Middlebury, VT

Code Consultant
Holmes
600 1st Avenue, Suite 200A
Seattle, WA 98104

Fire Protection Engineer
Jensen Hughes
One Research Drive, Suite 305C
Westborough, MA 01581

Vertical Transportation Consultant
Larch Bates
19515 North Creek Parkway, Suite 304
Bothell, WA 98011

Structural Engineer
Magnusson Klemencic Associates
1301 5th Ave, Suite 3200
Seattle, WA 98101

Lighting Designer
O-
1319 SE MLK Blvd, Suite 210
Portland, Oregon 97219

Building Envelope Consultant
RDH
2101 N 34th St
Seattle, WA 98103

Accessibility Consultant
Studio Pacifica
2144 Westlake Ave N, Suite F
Seattle, WA 98109

MEP Engineer
WSP USA
1001 Fourth Ave., Suite 3100
Seattle, WA 98154

principal architect: _____
project manager: JCC
drawn by: CRB, SMW
checked by: Checker
job no.: 2052
date: 11/18/2022

revisions:

no. _____ date _____ by _____


ISSUE FOR
CONSTRUCTION
11/18/2022

FIRE ALARM PLAN -
TOWER A - LVL 4

FA2.2A.14



1 TOWER A - LEVEL 4 - FA
1/8" = 1'-0"

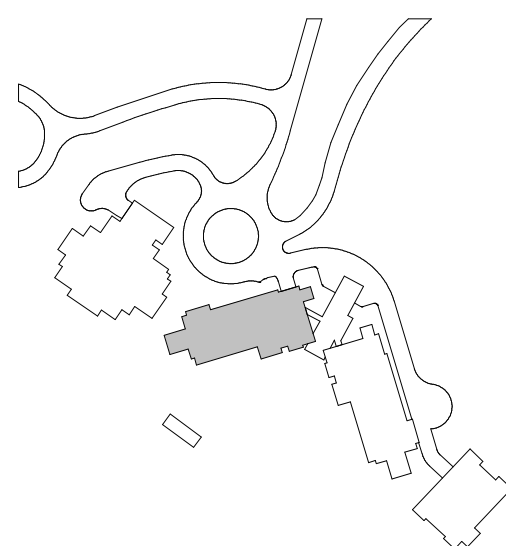


- KEYNOTES:
- 1 FIRE ALARM TERMINAL, CABINET WITHIN 2-HR RATED SHUT ACCESSIBLE VIA 2-HR RATED ACCESS PANEL. COORDINATE INSTALLATION AND ACCESS WITH DIVISION 25.
 - 2 STAR SPEAKER FOR MANUAL PAGING CONNECTED TO DEDICATED CIRCUIT.

Reserved for permit stamp

109 South Jackson St., Suite 600
Seattle, Washington 98104 USA
+1 206 834 2877 olsonkundig.com

Olson Kundig

 project
SOMMET BLANC - AB
DEER VALLEY, UTAH



White Summit Development, LLC
PO Box 980022
Park City, Utah 84098

Acoustic Consultant
BRC Acoustics
1932 1st Ave, Suite 620
Seattle, WA 98101

Pool Consultant
Cloward H2O
2698 N University Ave, Suite 290
Provo, UT 84604

Landscape Architect
EPG Design
6948 South High Tech Drive, Suite 100
Midvale, Utah 84047

Specifications Writer
Friday Group
86 Mainelli Road
Middlebury, VT

Code Consultant
Holmes
600 1st Avenue, Suite 200A
Seattle, WA 98104

Fire Protection Engineer
Jensen Hughes
One Research Drive, Suite 305C
Westborough, MA 01581

Vertical Transportation Consultant
Larch Bates
19515 North Creek Parkway, Suite 304
Bothell, WA 98011

Structural Engineer
Magnusson Klemencic Associates
1301 5th Ave, Suite 3200
Seattle, WA 98101

Lighting Designer
O
1319 SE MLK Blvd, Suite 210
Portland, Oregon 97219

Building Envelope Consultant
RDH
2101 N 34th St
Seattle, WA 98103

Accessibility Consultant
Studio Pacifica
2144 Westlake Ave N, Suite F
Seattle, WA 98109

MEP Engineer
WSP USA
1001 Fourth Ave., Suite 3100
Seattle, WA 98154

principal architect _____
project manager _____ JCC
drawn by _____ CRB_SMM
checked by _____ Checker
job no. _____ 2052
date _____ 11/18/2022



revisions:

no. _____ date _____ by _____

ISSUE FOR
CONSTRUCTION
11/18/2022

FIRE ALARM PLAN -
TOWER A - LVL 5

FA2.2A.15

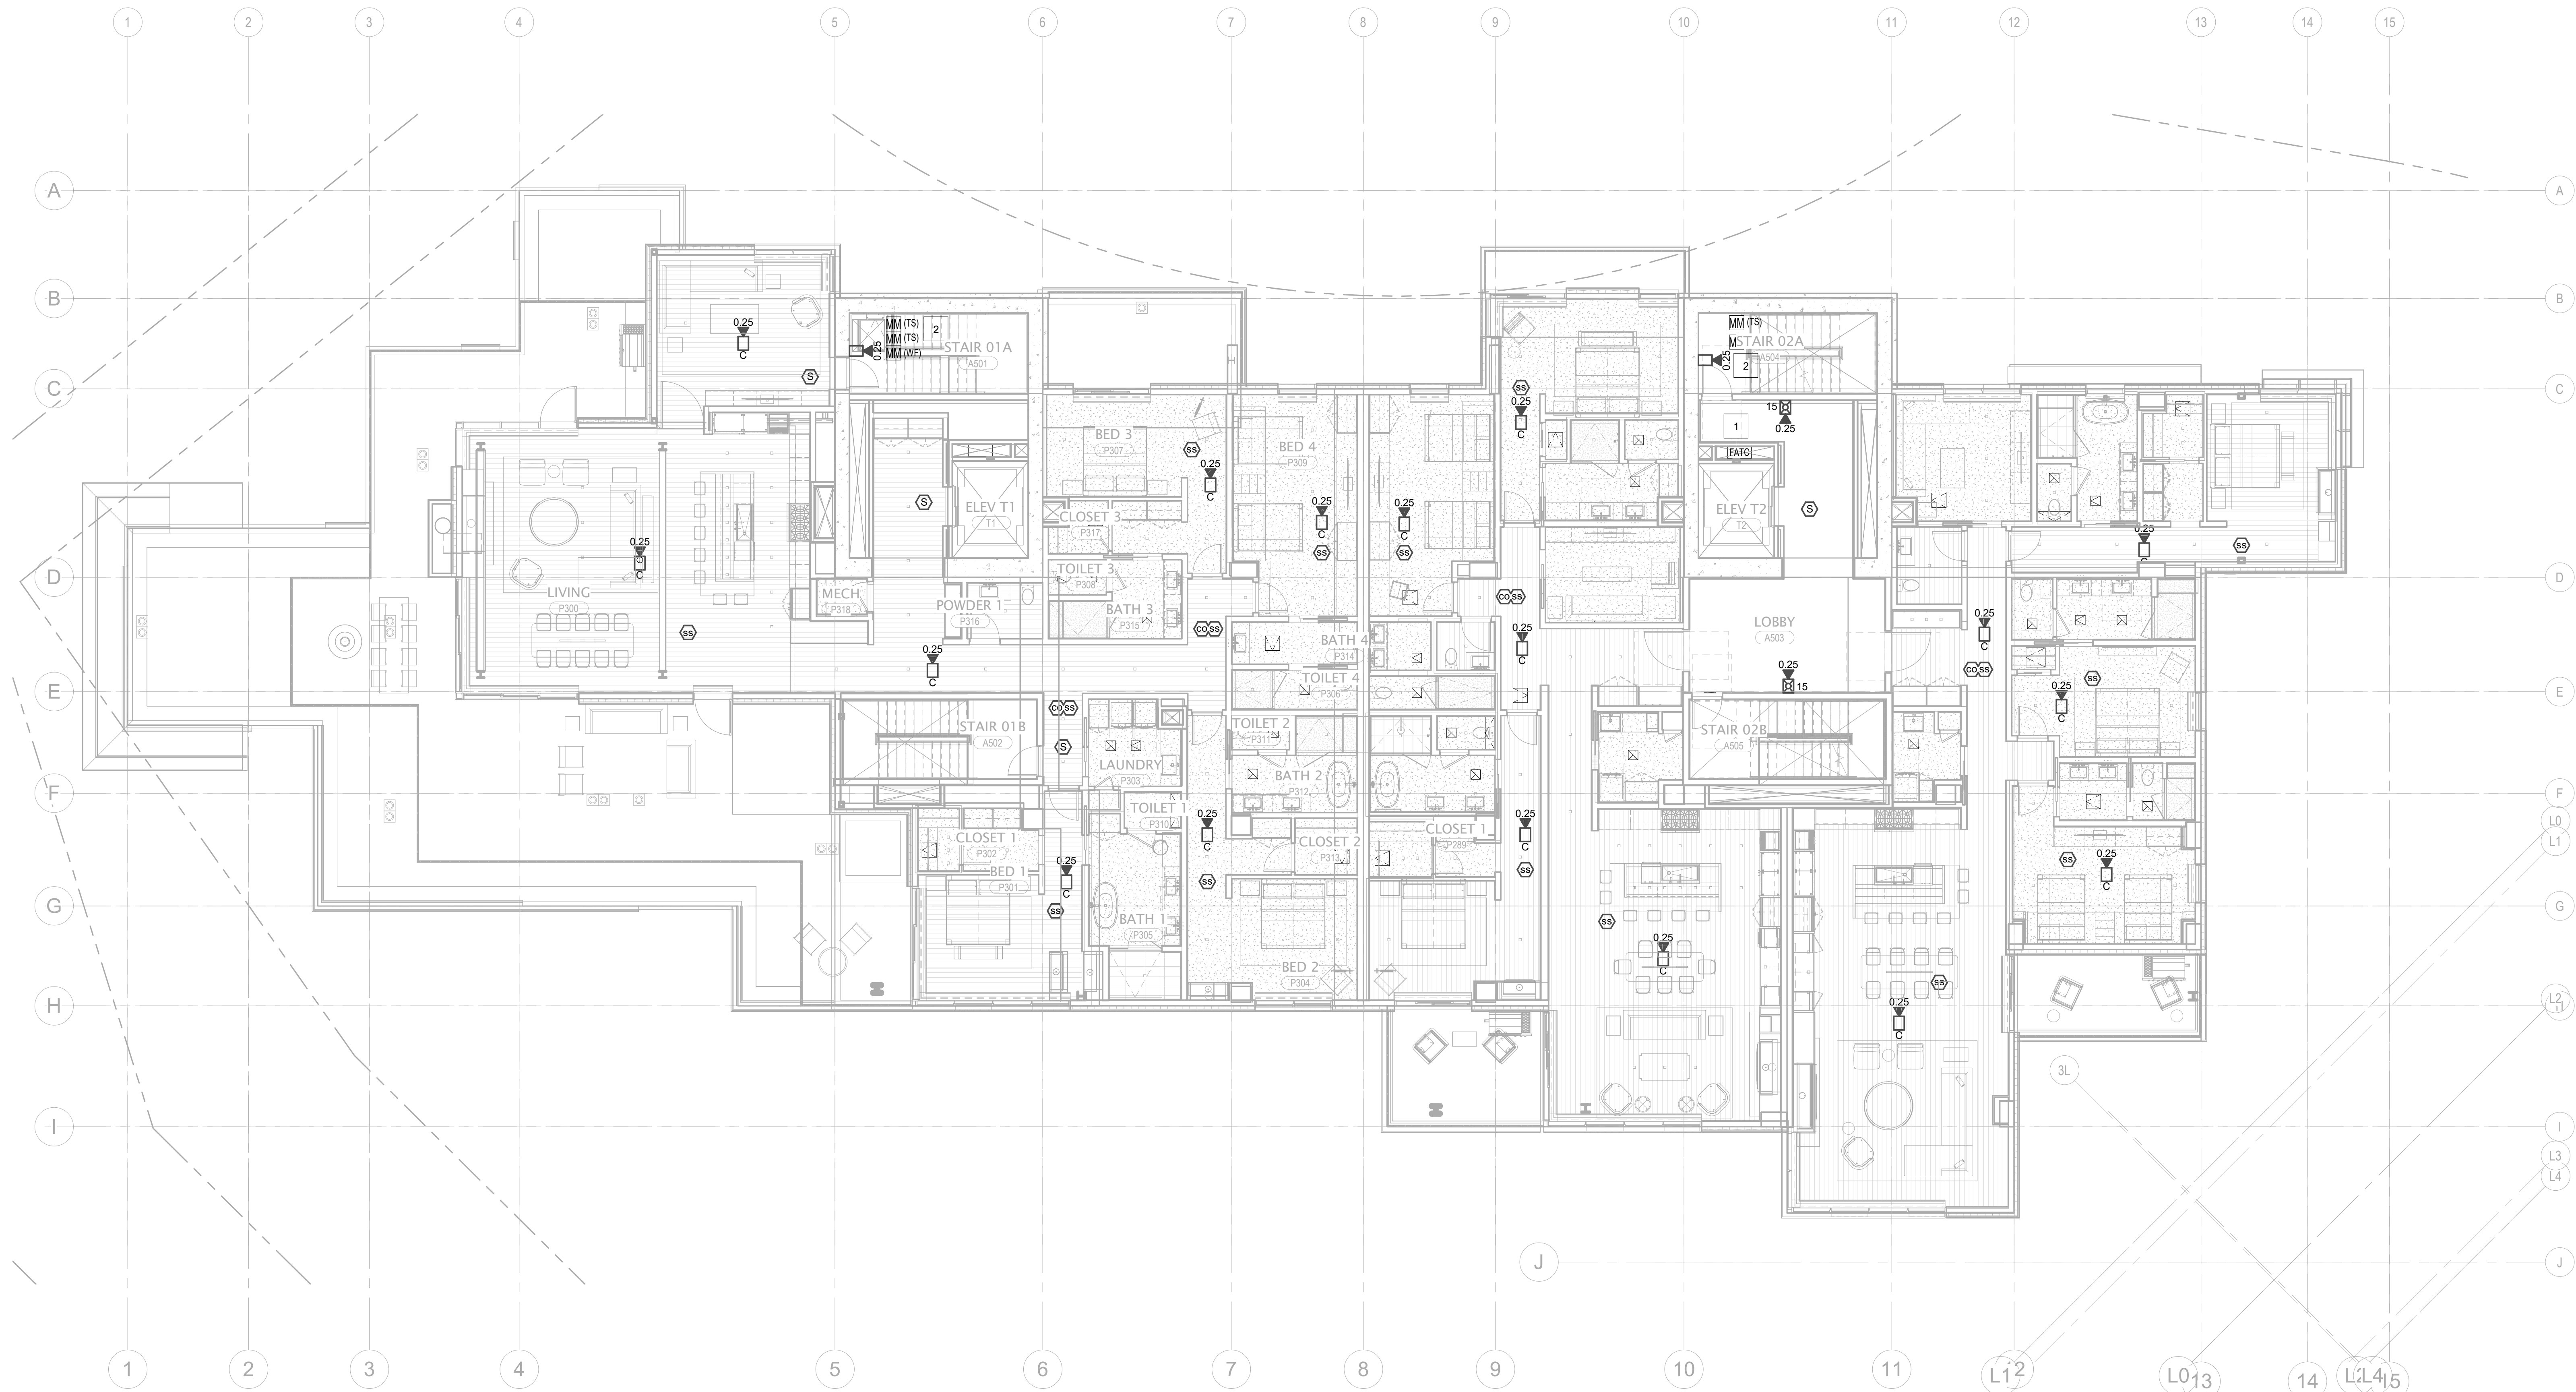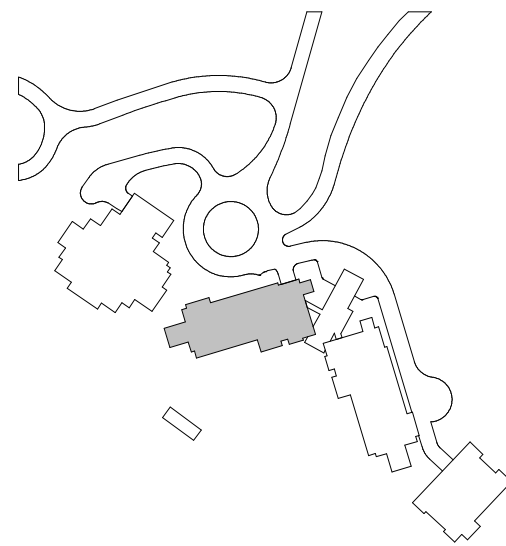

1 TOWER A - LEVEL 5 - FA
1/8" = 1'-0"

 
- KEYNOTES:
- 1 FIRE ALARM TERMINAL CABINET WITHIN 2-HR RATED SHUT ACCESSIBLE VIA 2-HR RATED ACCESS PANEL COORDINATE INSTALLATION AND ACCESS WITH DIVISION 26
 - 2 2-HR UL LISTED RATED CONDUIT CABLE SYSTEM FROM BGA TO 2-HR RATED CLOSET, CONDUIT BACKSPOKE TO BE INSTALLED IN 2-HR CLOSET NEXT TO FIRE ALARM RISSER WITH EX-UTTERS AT EACH LEVEL, ACCESSIBLE FROM SAME ACCESS PANEL PROVIDED FOR FATIO ACCESS.

Reserved for permit stamp

109 South Jackson St, Suite 600
Seattle, Washington 98104 USA
+1 206 824 2877 olsonkundig.com

Olson Kundig

project
SOMMET BLANC - AB
DEER VALLEY, UTAH



White Summit Development, LLC
PO Box 980022
Park City, Utah 84098

Acoustic Consultant
BRC Acoustics
1932 1st Ave, Suite 620
Seattle, WA 98101

Pool Consultant
Cloward H2O
2696 N University Ave, Suite 290
Provo, UT 84604

Landscape Architect
EPG Design
6948 South High Tech Drive, Suite 100
Midvale, Utah 84047

Specifications Writer
Friday Group
86 Mainelli Road
Middlebury, VT

Code Consultant
Holmes
600 1st Avenue, Suite 200A
Seattle, WA 98104

Fire Protection Engineer
Jensen Hughes
One Research Drive, Suite 305C
Westborough, MA 01581

Vertical Transportation Consultant
Larch Bates
19515 North Creek Parkway, Suite 304
Bothell, WA 98011

Structural Engineer
Magnusson Klemencic Associates
1301 5th Ave, Suite 3200
Seattle, WA 98101

Lighting Designer
O
1319 SE MLK Blvd, Suite 210
Portland, Oregon 97219

Building Envelope Consultant
RDH
2101 N 34th St
Seattle, WA 98103

Accessibility Consultant
Studio Pacifica
2144 Westlake Ave N, Suite F
Seattle, WA 98109

MEP Engineer
WSP USA
1001 Fourth Ave., Suite 3100
Seattle, WA 98154

principal architect

project manager

drawn by

checked by

job no.

date

revisions:

11/18/2022

no. date by

ISSUE FOR CONSTRUCTION


11/18/2022


FIRE ALARM PLAN -
TOWER A - LVL 6

FA2.2A.16




1 TOWER A - LEVEL 6 - FA
1/8" = 1'-0"

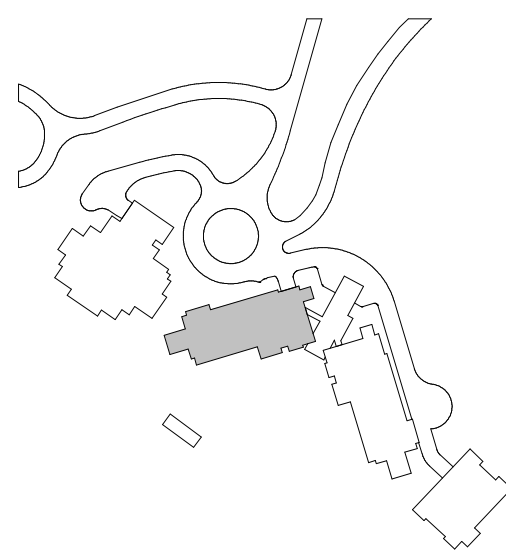


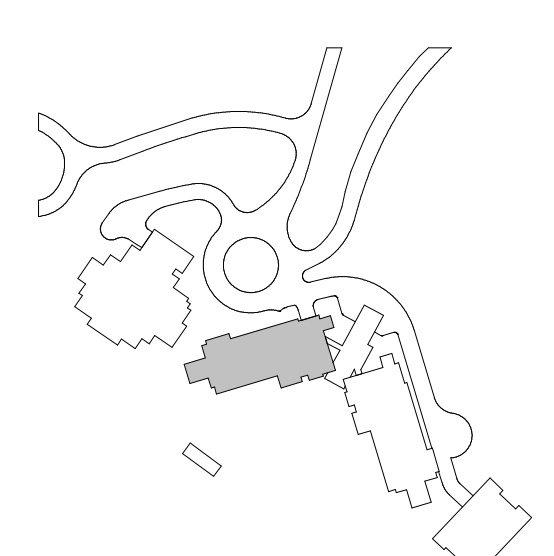

FA2.2A.R

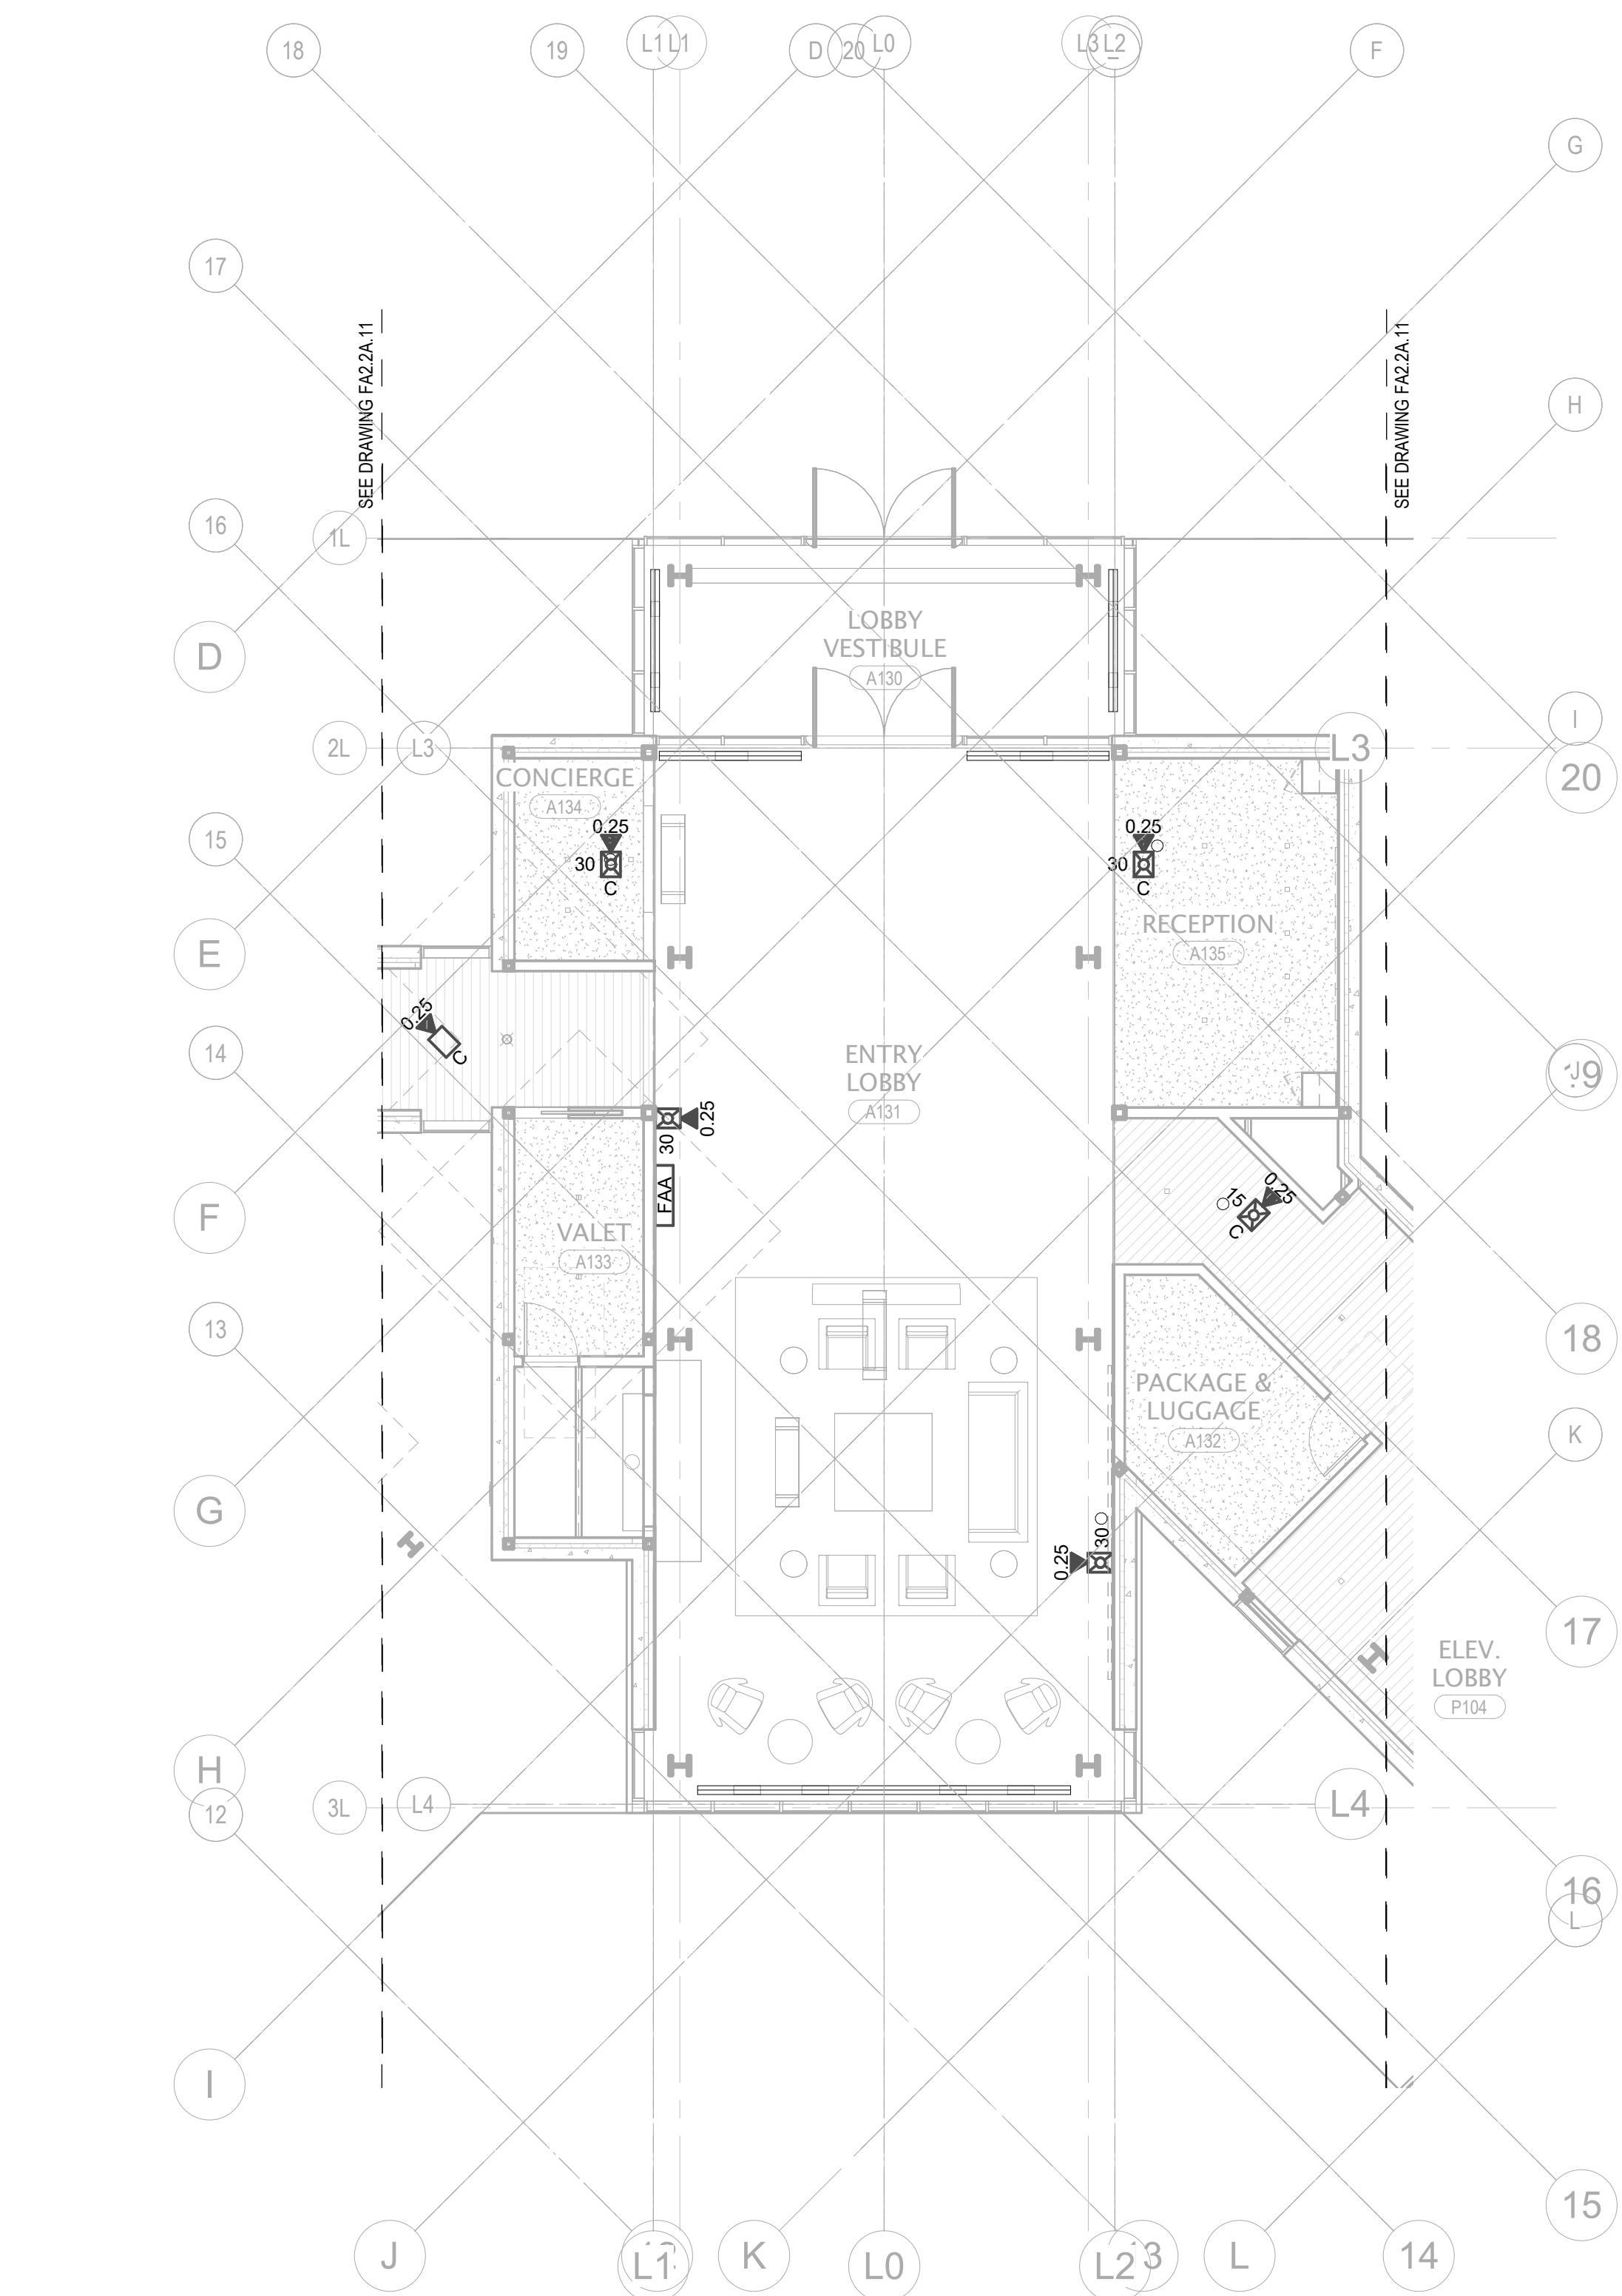


1 TOWER AB - LOBBY - LEVEL 1 - FA
1/8" = 1'-0"

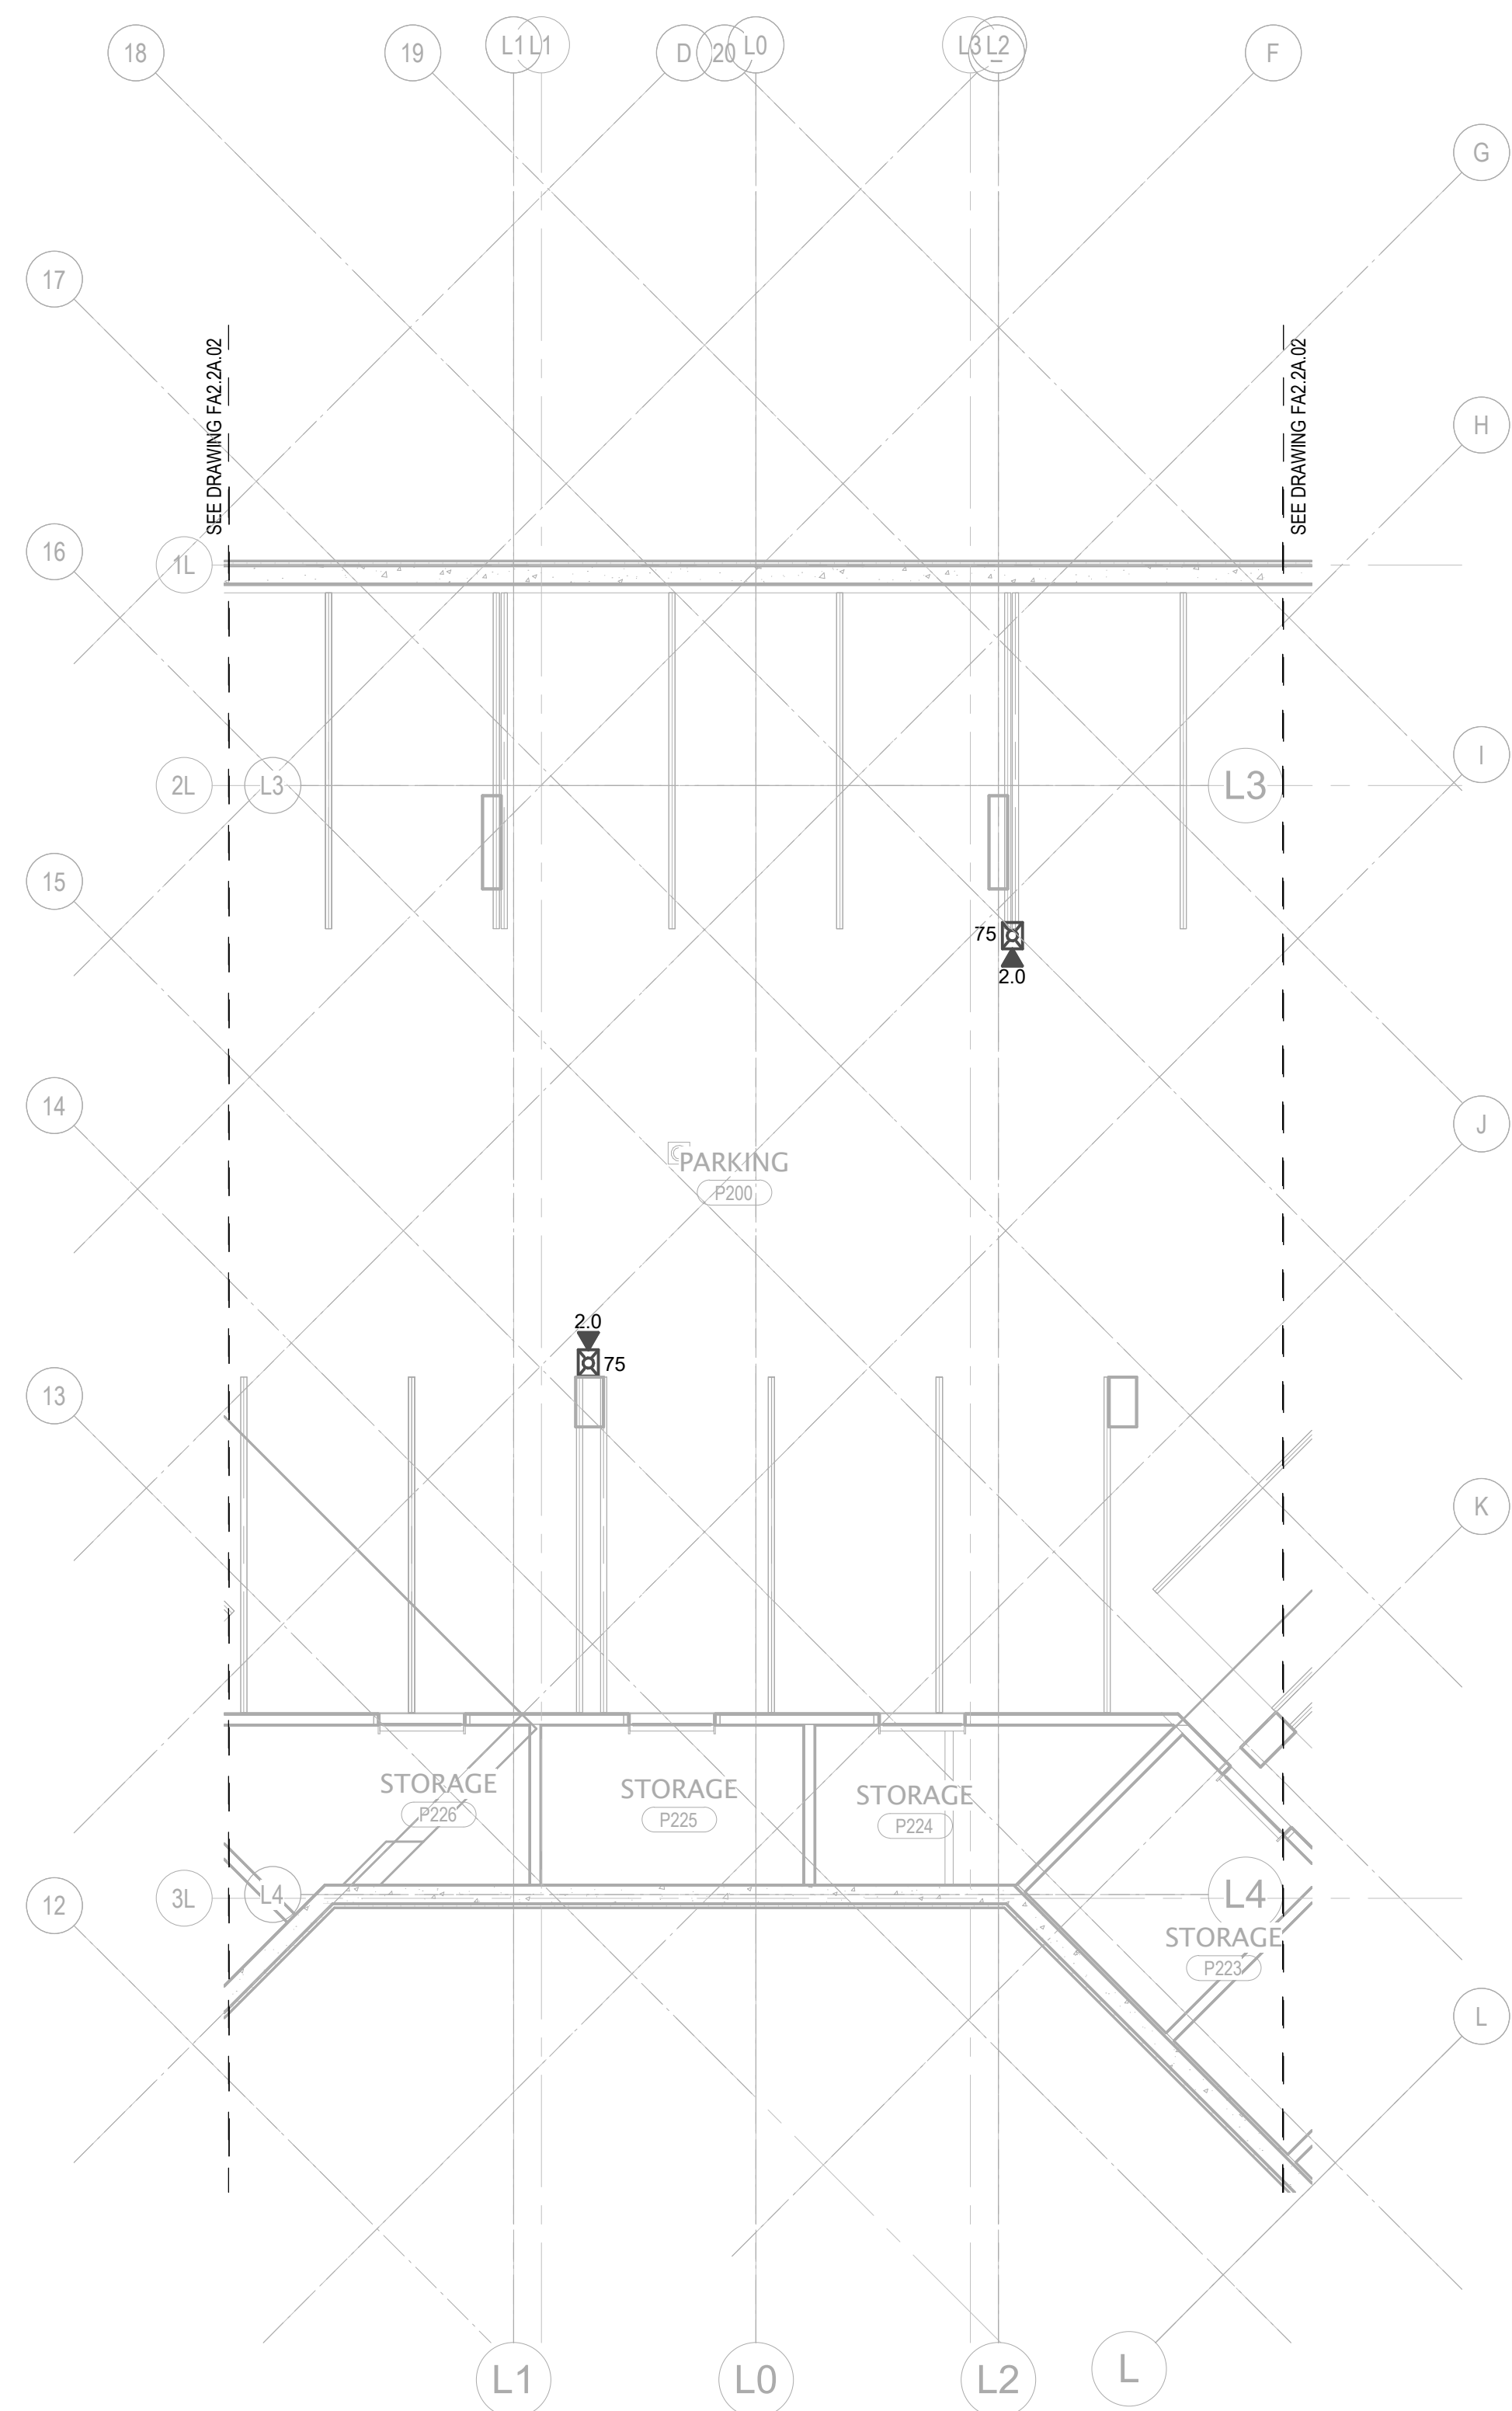

2 TOWER AB - LOBBY - PARKING LEVEL 2 - FA
1/8" = 1'-0"

GENERAL NOTE:
PROVIDE EQUIPMENT SYNC CIRCUITS ETC. IN ORDER
TO ENSURE AUDIBLE / VISUAL NOTIFICATION
APPLIANCES AT THESE TWO LEVELS OPERATE IN
SYNCHRONIZATION.

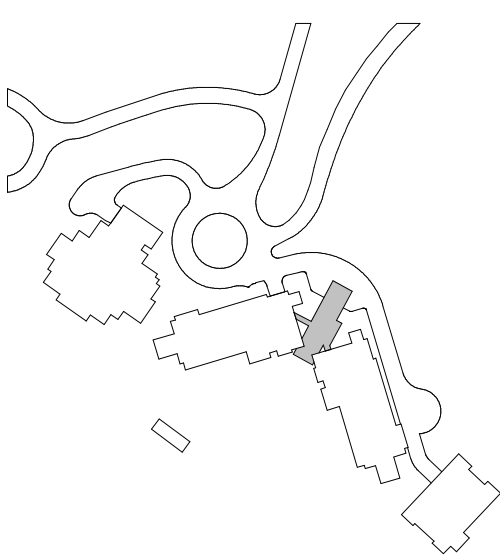


Reserved for permit stamp

100 South Jackson St., Suite 600
Seattle, Washington 98104 USA
+1 206 834 2870 olsonkundig.com

Olson Kundig

 project
SOMMET BLANC - AB
DEER VALLEY, UTAH



White Summit Development, LLC
PO Box 980022
Park City, Utah 84098

Acoustic Consultant
BRC Acoustics
1932 1st Ave., Suite 620
Seattle, WA 98101

Pool Consultant
Cloward H2O
2696 N University Ave., Suite 290
Provo, UT 84604

Landscape Architect
EPG Design
6948 South High Tech Drive, Suite 100
Midvale, Utah 84047

Specifications Writer
Friday Group
86 Mainelli Road
Middlebury, VT

Code Consultant
Holmes
600 1st Avenue, Suite 200A
Seattle, WA 98104

Fire Protection Engineer
Jensen Hughes
One Research Drive, Suite 305C
Westborough, MA 01581

Vertical Transportation Consultant
Larch Bates
19515 North Creek Parkway, Suite 304
Bothell, WA 98011

Structural Engineer
Magnusson Klemencic Associates
1301 5th Ave., Suite 3200
Seattle, WA 98101

Lighting Designer
O-
1319 SE MLK Blvd., Suite 210
Portland, Oregon 97219

Building Envelope Consultant
RDH
2101 N 34th St
Seattle, WA 98103

Accessibility Consultant
Studio Pacifica
2144 Westlake Ave N, Suite F
Seattle, WA 98109

MEP Engineer
WSP USA
1001 Fourth Ave., Suite 3100
Seattle, WA 98154

principal architect

project manager

checked by

job no.

date

revisions:

no.

date

by

ISSUE FOR
CONSTRUCTION

11/18/2022

FIRE ALARM PLAN -

TOWER AB - LOBBY

FA2.2AB.11