

1

159 South Jackson St, Suite 800
Seattle, Washington 98104 USA
+1 206 624 5670 olsonlundig.com

Olson Kundig

project;
SOMMET BLANC - C
DEER VALLEY, UTAH

PO Box 980022
Park City, Utah 84098

Ave, Suite 620
 U.S. 02104

Sultan

Questions V

resultant

Section 5

transpo

Engine

Design

Envelope

ity Co.

linear

local acc

check


18:

late—


1/18/2022

ALARM PLAN -
ER C - PARKING

FA2.2C.01

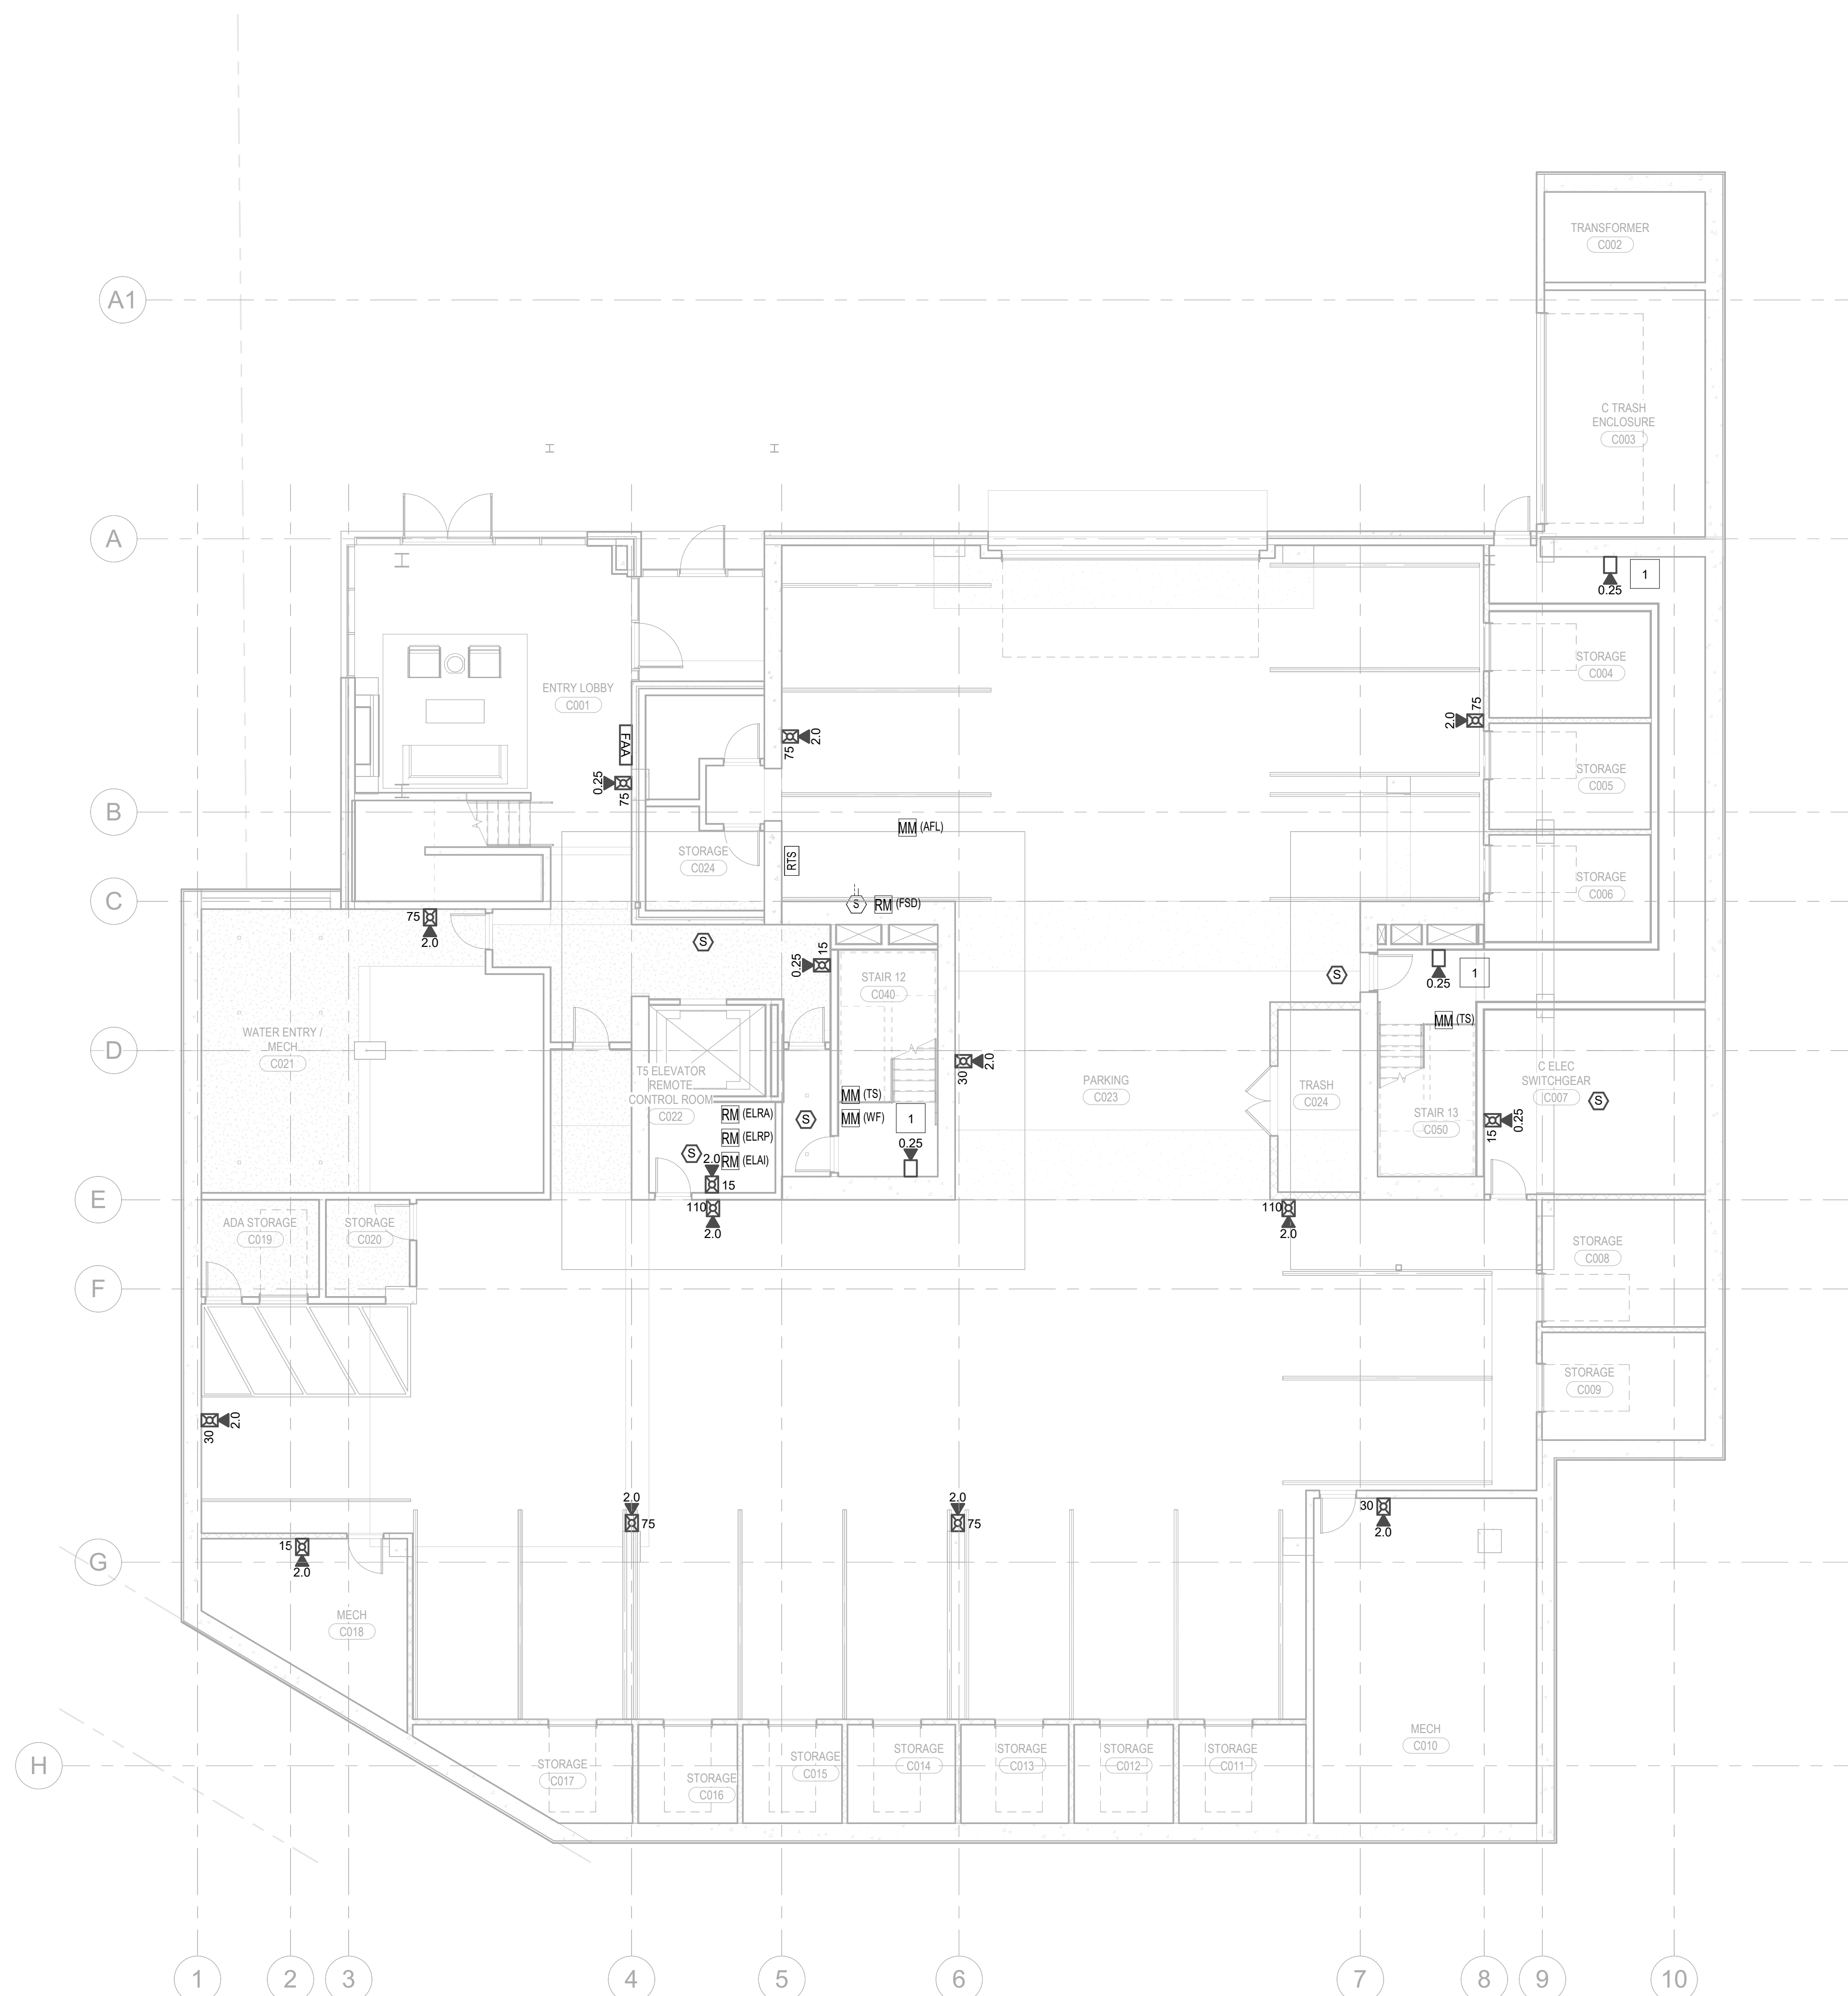

1

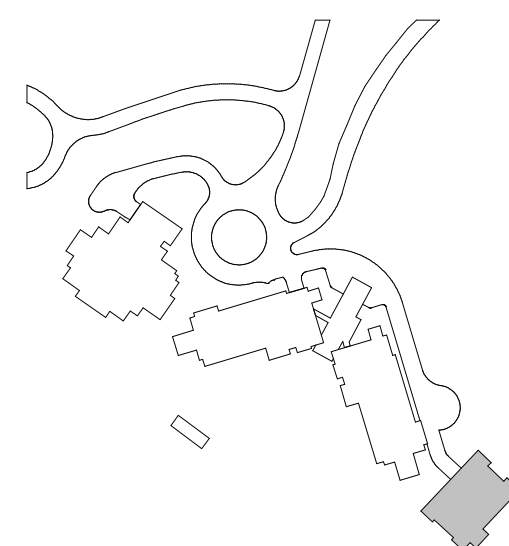

- KEYNOTES:**

 - 1 2-HR CIC, SLC, AND NAC FROM FCC TO 2-HR RATED SHAFT, ROUTING SHOWN FOR CONCEPTUAL PURPOSES ONLY.
 - 2 FIRE ALARM TERMINAL CABINET WITHIN 2-HR RATED SHAFT ACCESSIBLE VIA 2-HR RATED ACCESS PANEL. COORDINATE INSTALLATION AND ACCESS WITH DIVISION 26. TRANSITION FROM 2-HR CIC TO FPL CABLE IN EMT AT THIS POINT.
 - 3 DEDICATED SPEAKER CIRCUIT (2-HR CIC) TO STAIR SPEAKERS; TRANSITION TO FPL IN EMT AT FIRST DEVE.

Reserved for permit stamp

159 South Jackson St, Suite 600
Seattle, Washington 98104 USA
+1 206 624 5670 olsonkundig.com

Olson Kundig

project:
SOMMET BLANC - C
DEER VALLEY, UTAH

White Summit Development, LLC
PO Box 980022
Park City, Utah 84098

Acoustic Consultant
BRC Acoustics
1932 1st Ave, Suite 620
Seattle, WA 98101

Pool Consultant
Cloward H2O
2696 N University Ave, Suite 290
Provo, UT 84604

Landscape Architect
EPG Design
8949 South High Tech Drive, Suite 100
Midvale, Utah 84047

Specifications Writer
Friday Group
88 Mainelli Road
Middlebury, VT

Code Consultant
Holmes
800 1st Avenue, Suite 200A
Seattle, WA 98104

Fire Protection Engineer
Jensen Hughes
One Research Drive, Suite 305C
Westborough, MA 01581

Vertical Transportation Consultant
Lerch Bates
19515 North Creek Parkway, Suite 304
Bothell, WA 98011

Structural Engineer
Magnusson Klemencic Associates
1301 5th Ave, Suite 3200
Seattle, WA 98101

Lighting Designer
O-
 1319 SE MLK Blvd, Suite 210
 Portland, Oregon 97219

Building Envelope Consultant
RDH
2101 N 34th St
Seattle, WA 98103

Studio Pacifica
2144 Westlake Ave N, Suite F
Seattle, WA 98109

WSP USA
1001 Fourth Ave., Suite 3100
Seattle, WA 98154

principal architect TR
project manager JCC
drawn by CRB, SMK

checked by Checker
job no. 20052
date 11/18/2022

revisions.


no. date _____ by _____

ISSUE FOR
CONSTRUCTION


11/18/2022

FIRE ALARM PLAN -
TOWER C - LEVEL 1

FA2.2C.11

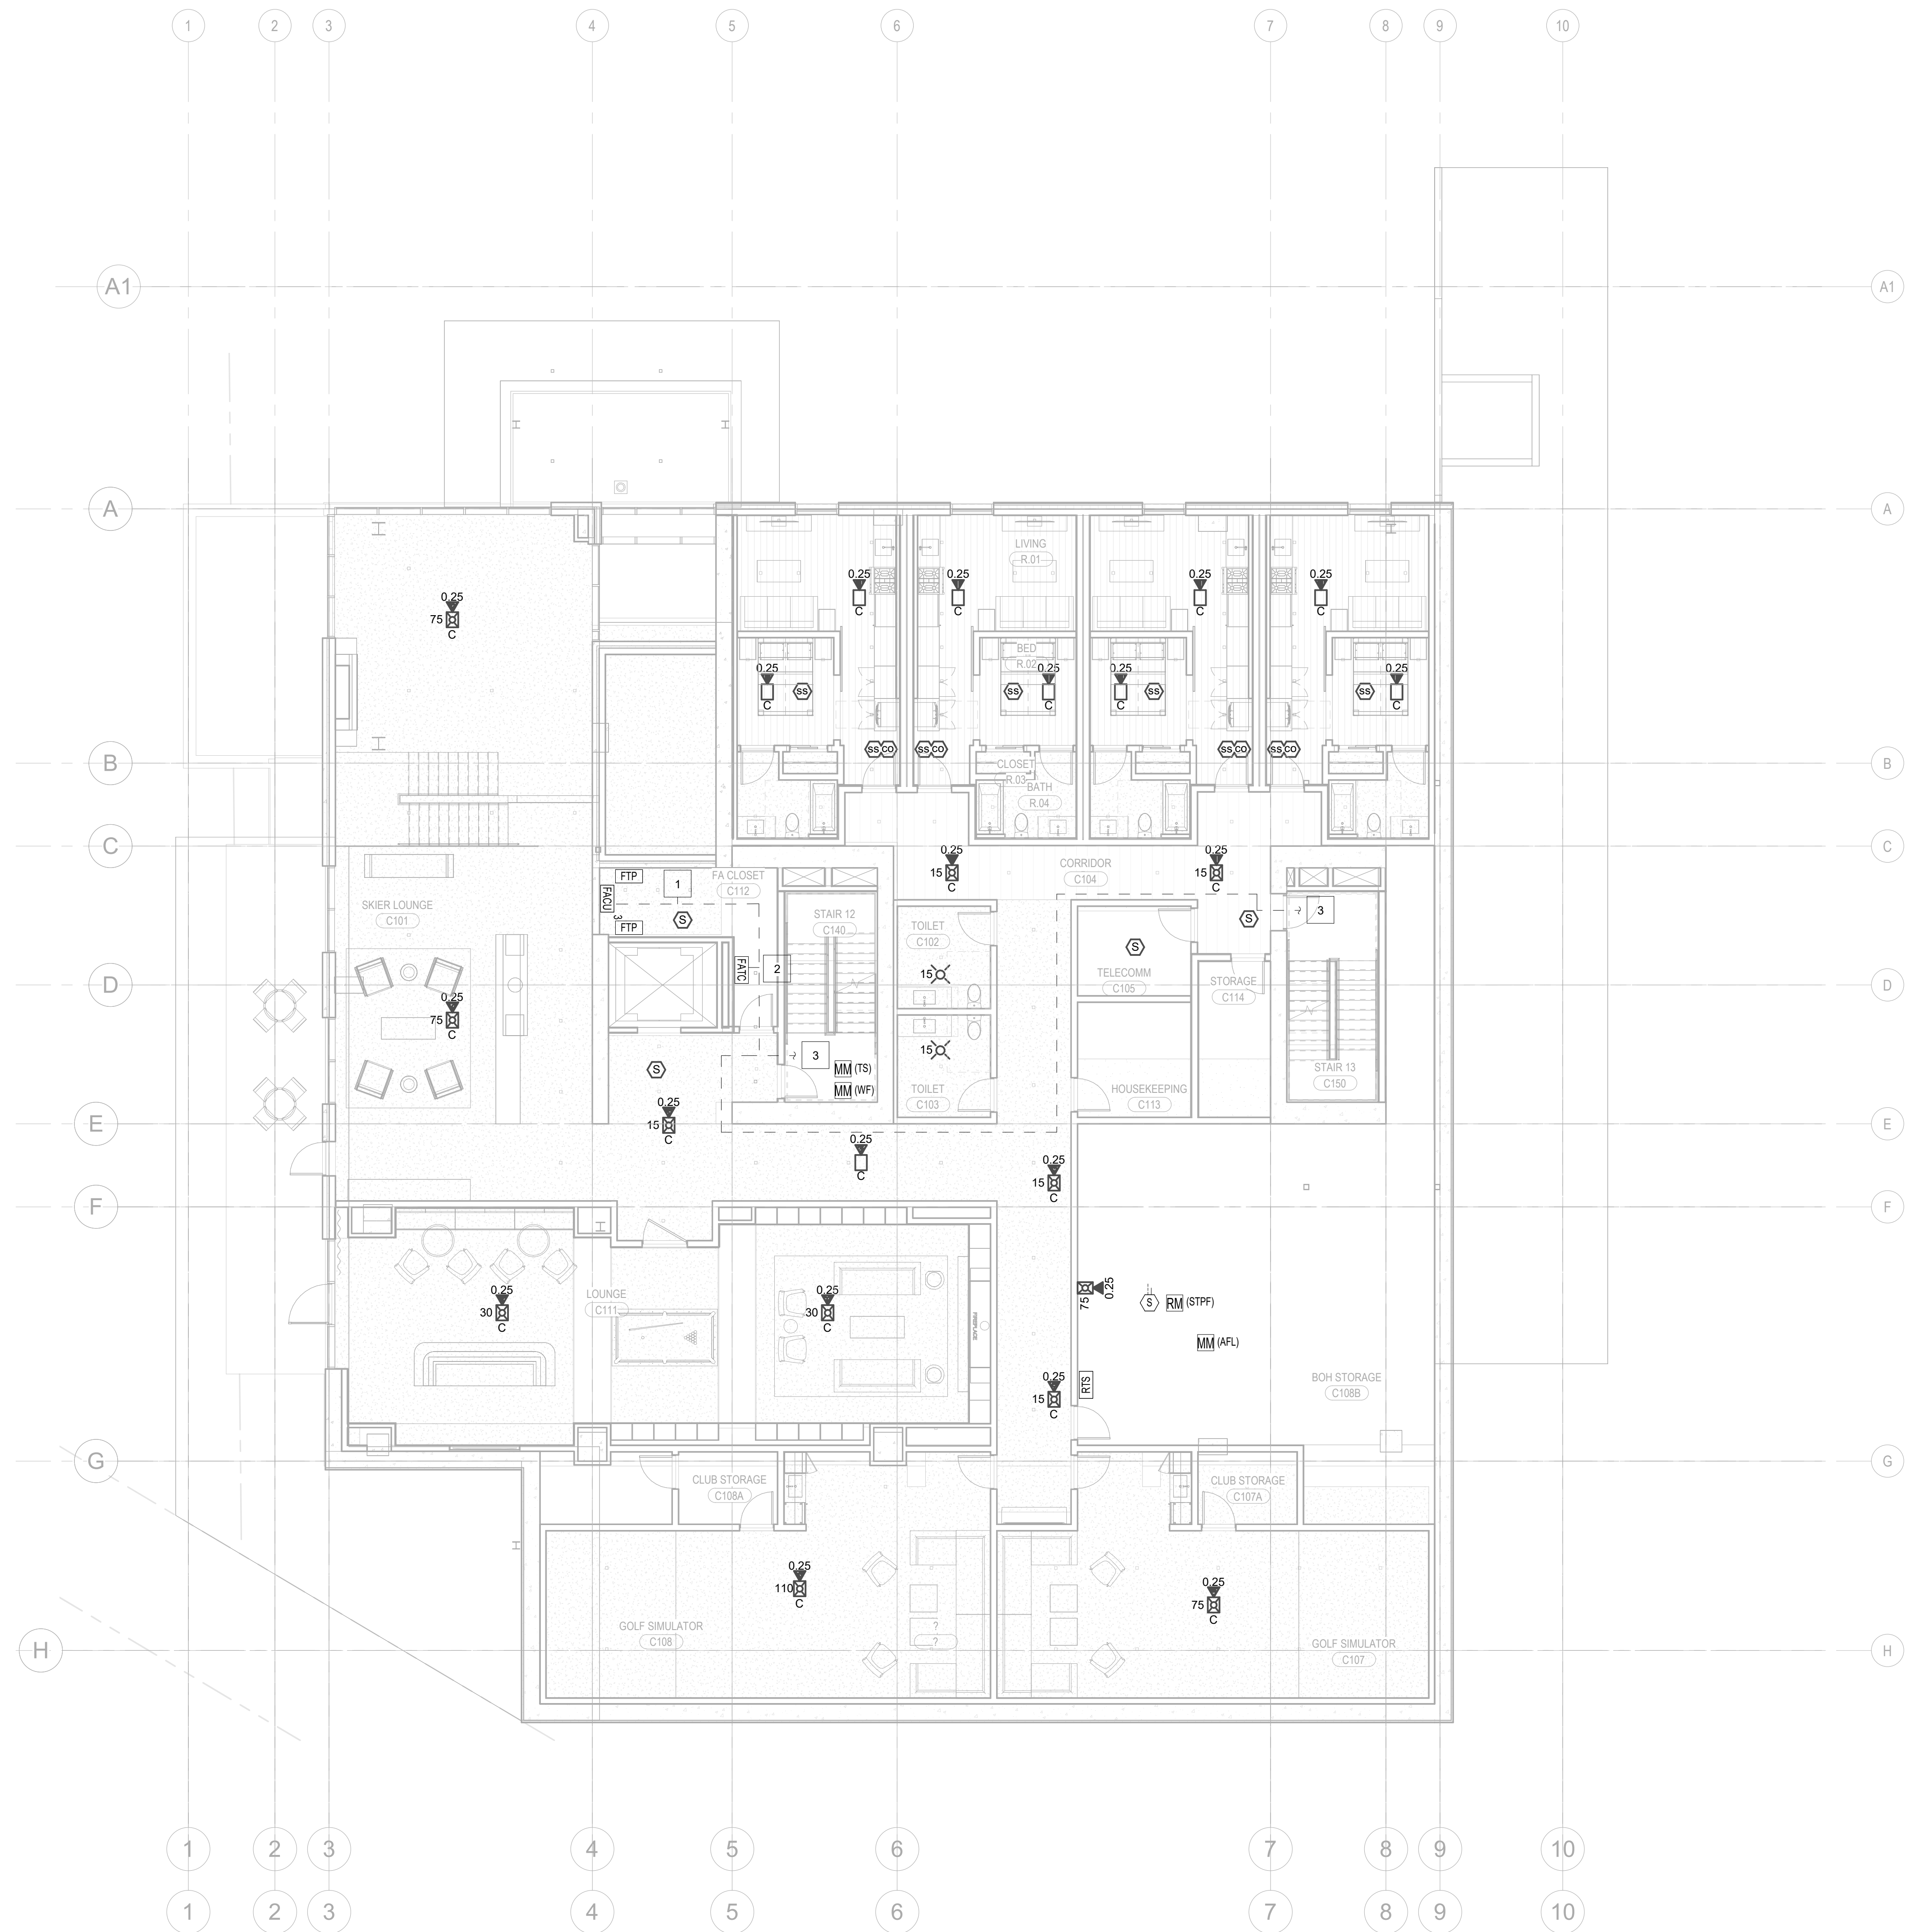

1 LEVEL 1 - FA
1/8" = 1'-0"

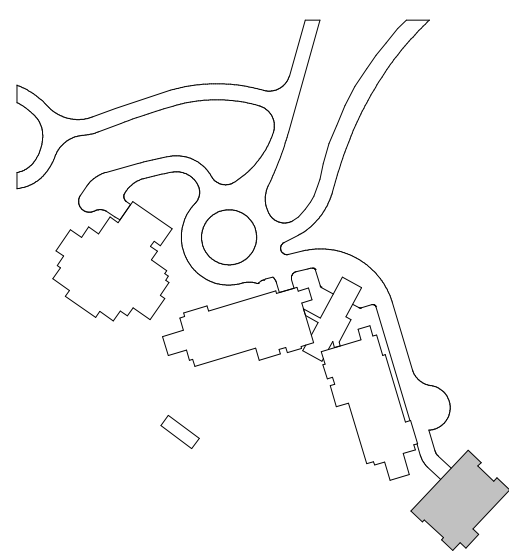

1

159 South Jackson St, Suite 800
Seattle, Washington 98104 USA
+1 206 624 5670 olsonkunding.com

Olson Kundig

project:
SOMMET BLANC - C
DEER VALLEY, UTAH

PO Box 980022
Park City, Utah 84098

Ave, Suite 620
LA 00104

Sultan

Arch

Questions V

Results

Section 5

transpo

Engine

Design

Envelope

ity Co

inner

pal arc



check

no. date b

ISSUE FOR CONSTRUCTION

ER C - LEVEL 2

FA2.2C.12

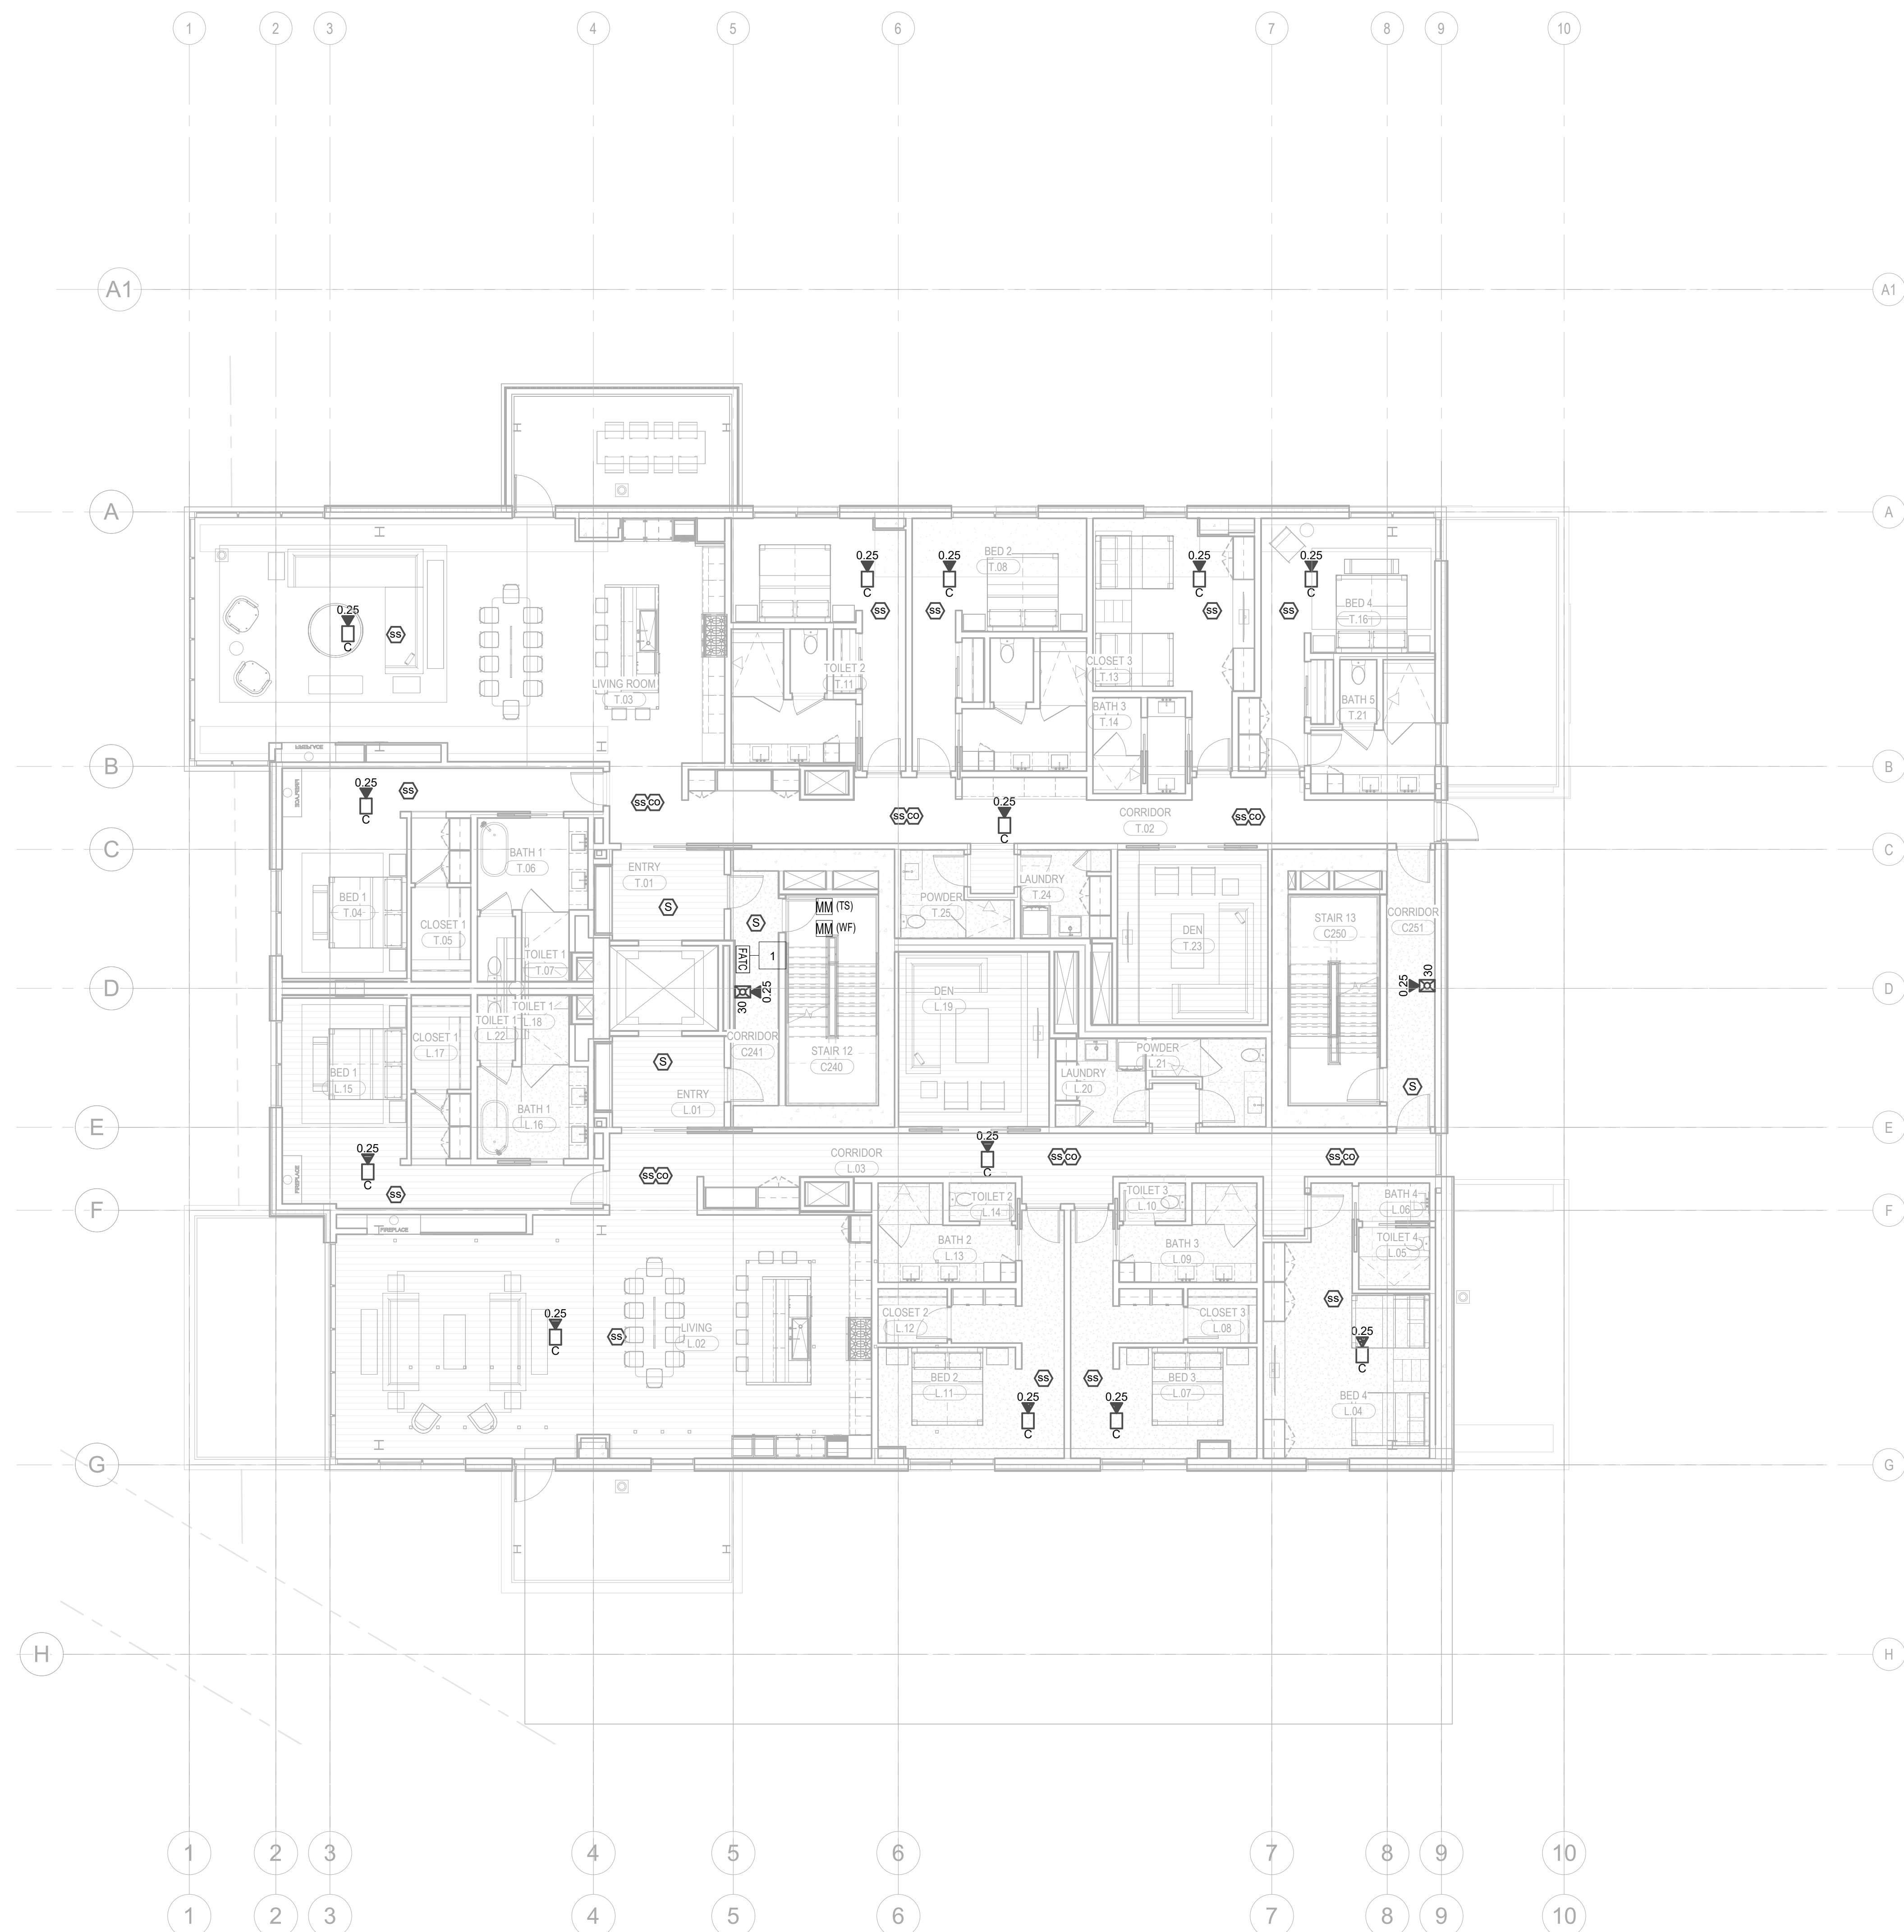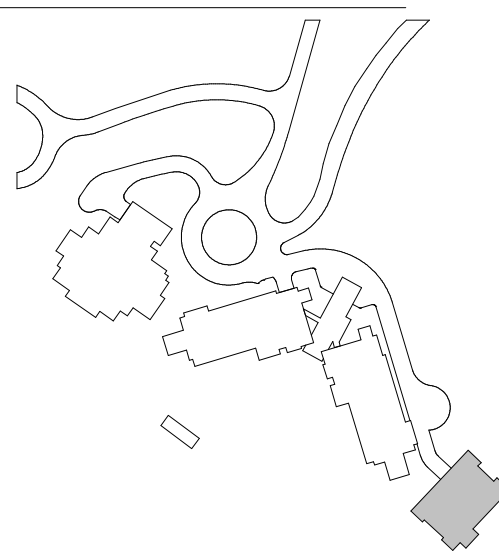

1


- KEYNOTES:**
- | | |
|---|--|
| 1 | FIRE ALARM TERMINAL CABINET WITHIN 2-HR RATED SHAFT ACCESSIBLE VIA 2-HR RATED ACCESS PANEL. COORDINATE INSTALLATION AND ACCESS WITH DIVISION 26. |
| 2 | STAIR SPEAKER FOR MANUAL PAGING CONNECTED TO DEDICATED CIRCUIT. |

Reserved for permit stamp

159 South Jackson St., Suite 600
Seattle, Washington 98104 USA
+1 206 624 5670 dis@nikundig.com

Olson Kundig

 SOMMET BLANC - C
DEER VALLEY, UTAH



White Summit Development, LLC
PO Box 980022
Park City, Utah 84098

Acoustic Consultant
BRC Acoustics
1932 1st Ave, Suite 620
Seattle, WA 98101

Pool Consultant
Cloward H2O
2696 N University Ave, Suite 290
Provo, UT 84604

Landscape Architect
EPG Design
8949 South High Tech Drive, Suite 100
Midvale, Utah 84047

Specifications Writer
Friday Group
88 Mainelli Road
Middlebury, VT

Code Consultant
Holmes
800 1st Avenue, Suite 200A
Seattle, WA 98104

Fire Protection Engineer
Jensen Hughes
One Research Drive, Suite 305C
Waltham, MA 01581

Vertical Transportation Consultant
Lerch Bates
19515 North Creek Parkway, Suite 304
Redmond, WA 98014

Structural Engineer
Magnusson Klemencic Associates
1301 5th Ave, Suite 3200
Bos. W. MA 02104

Lighting Designer
O.
1319 SE MLK Blvd, Suite 210

Building Envelope Consultant
RDH
2101 N 34th St

Accessibility Consultant
Studio Pacifica
2144 Westlake Ave N, Suite F

MEP Engineer
WSP USA
1001 Fourth Ave., Suite 3100

principal architect TK
project manager JCC
drawn by CRB, SMK
checked by Checker
job no. 20052
date 11/18/2022

[illegible]



no. date by

ISSUE FOR
CONSTRUCTION

1/18/2022

FIRE ALARM PLAN -
TOWER C - LEVEL 3

FA2.2C.13

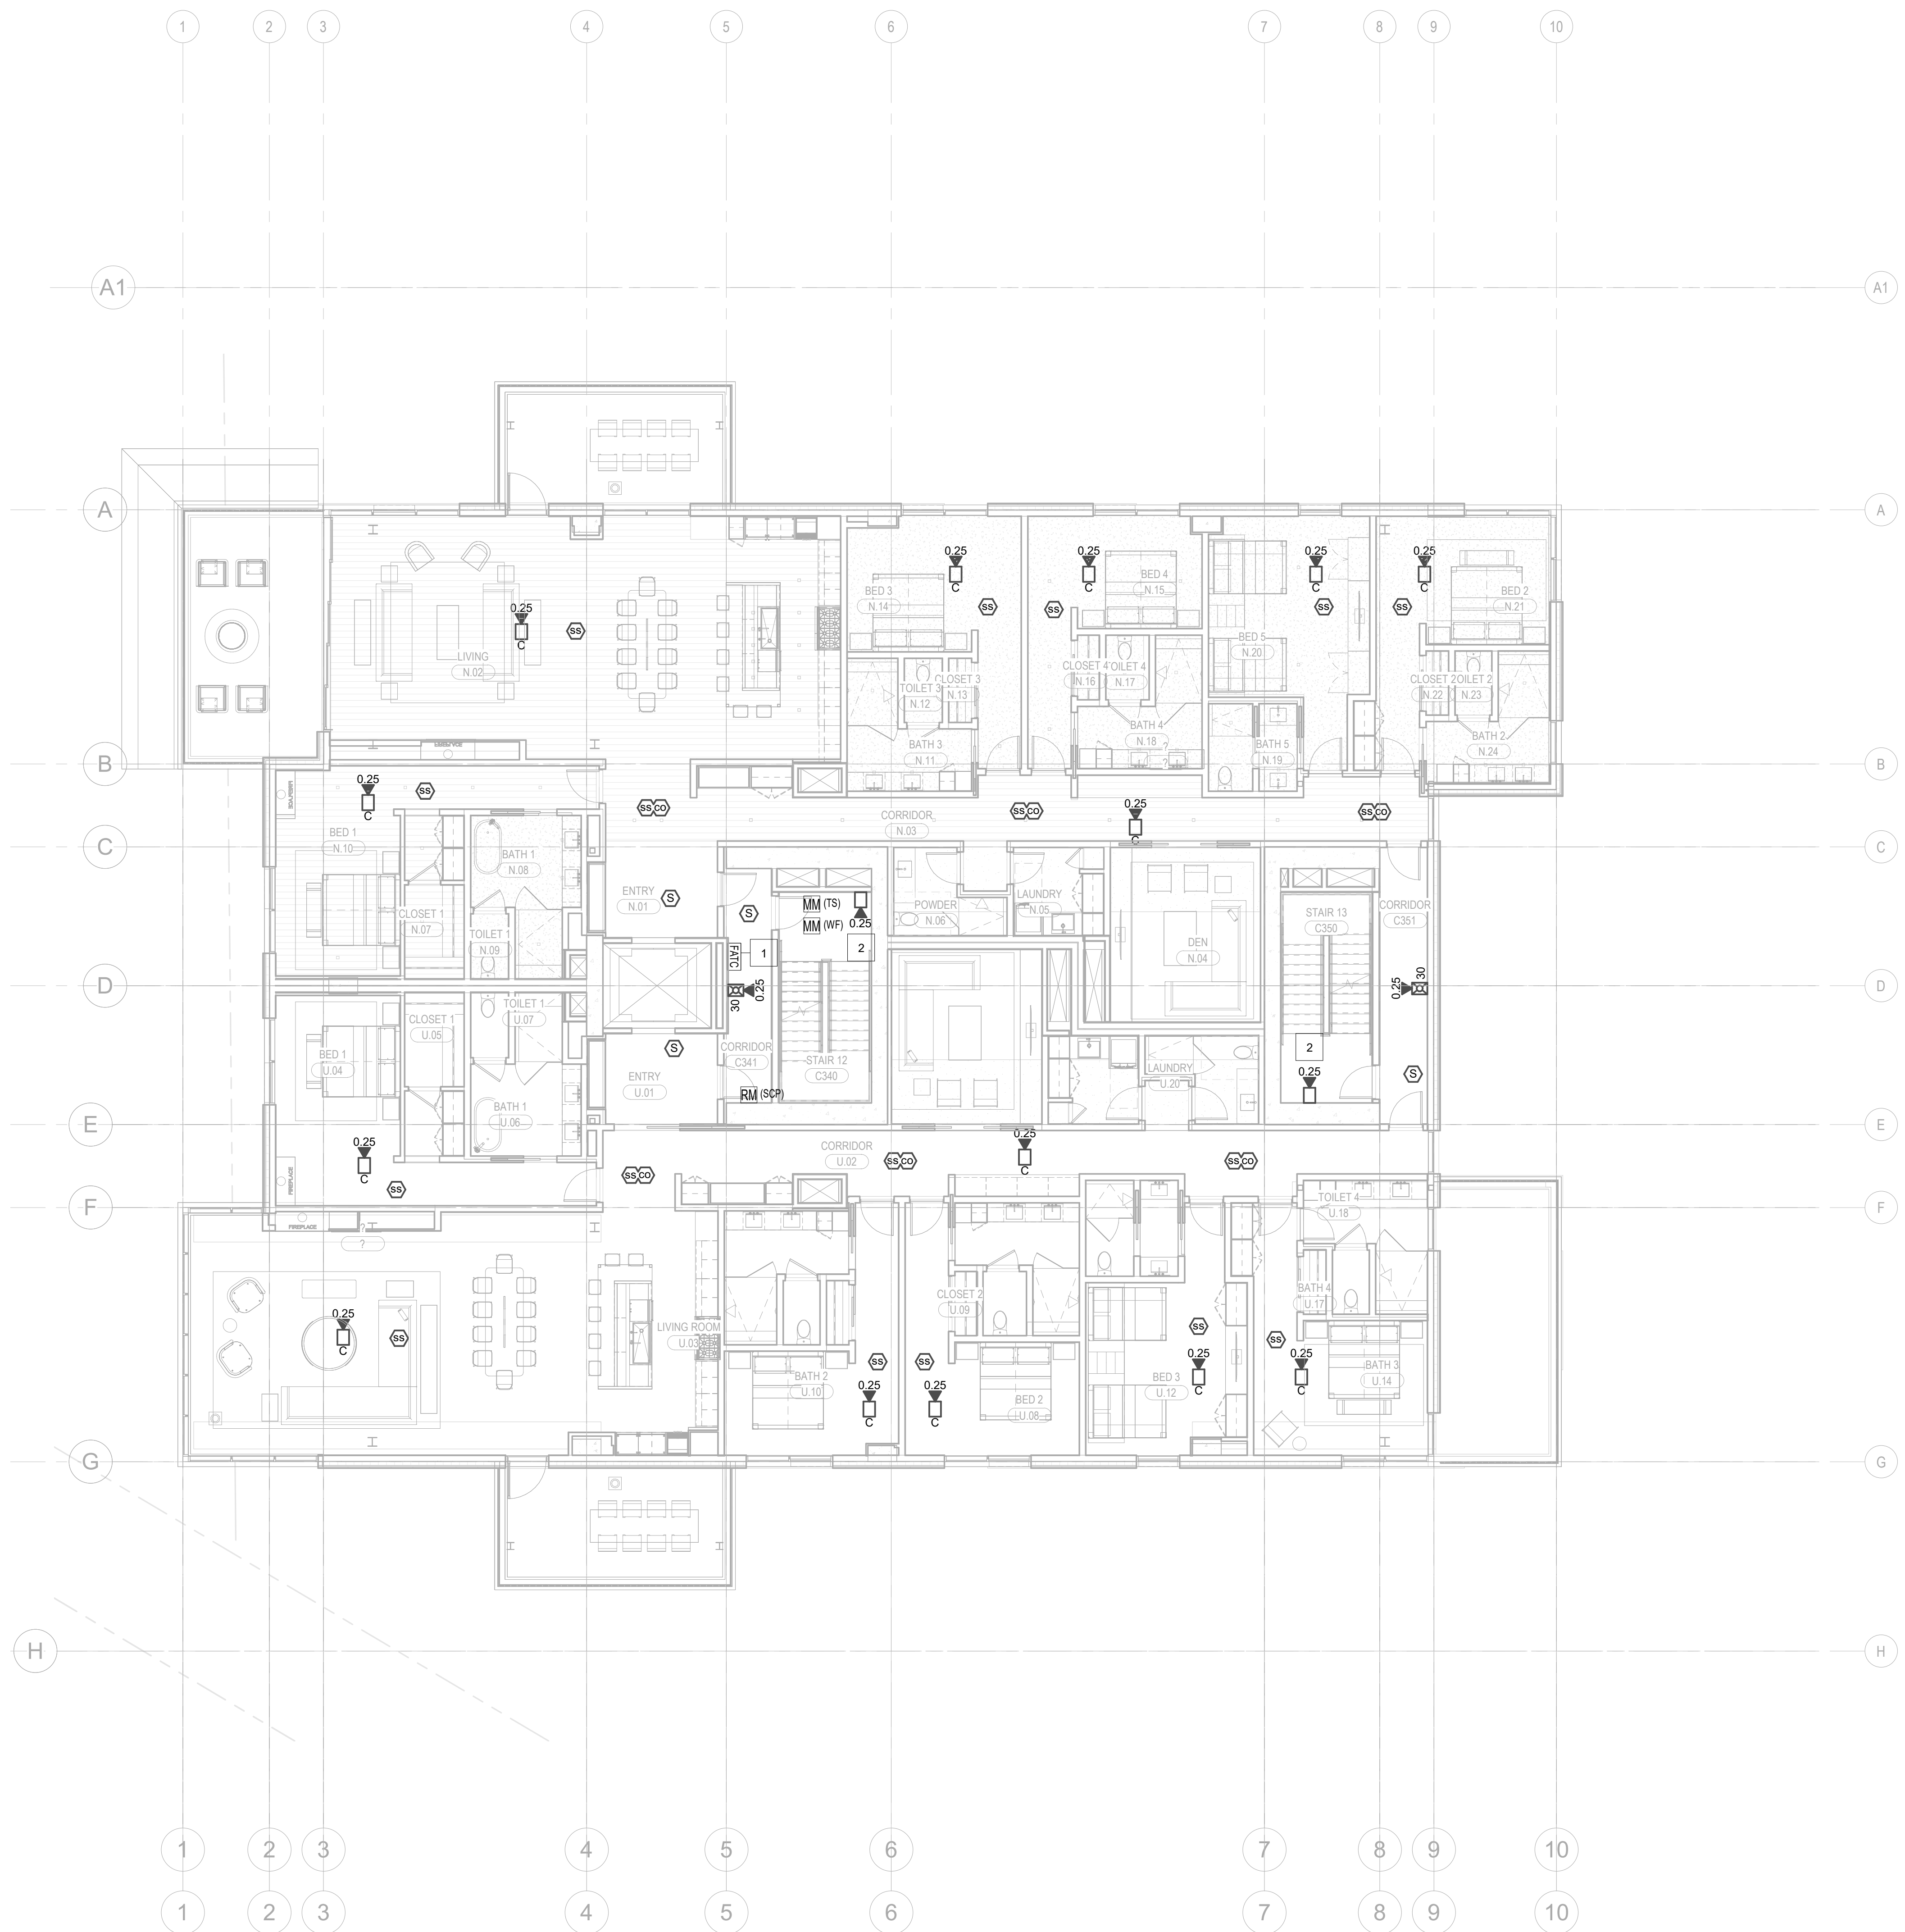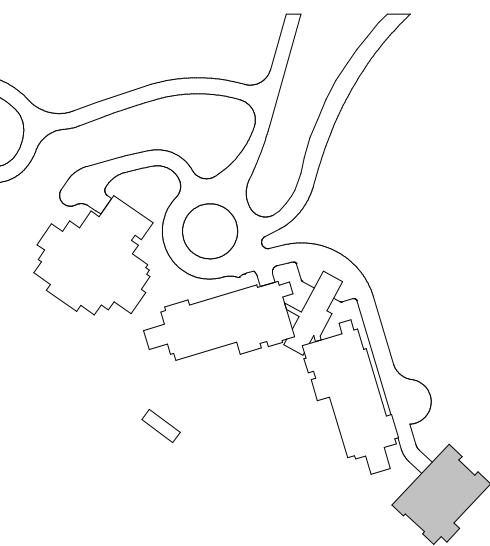

1 LEVEL 3 - FA
1/8" = 1'-0"

1

FIRE ALARM TERMINAL CABINET WITHIN 2-HR RATED SHAFT ACCESSIBLE VIA 2-HR RATED ACCESS PANEL. COORDINATE INSTALLATION AND ACCESS WITH DIVISION 26.

Reserved for permit stamp

159 South Jackson St, Suite 800
Seattle, Washington 98104 USA
+1 206 624 5670 olsonkundig.com

Olson Kundig

project:
SOMMET BLANC - C
DEER VALLEY, UTAH

White Summit Development, LLC
PO Box 980022
Park City, Utah 84098

Acoustic Consultant
BRC Acoustics
1932 1st Ave, Suite 620
Seattle, WA 98101

Pool Consultant
Cloward H2O
2696 N University Ave, Suite 290
Provo, UT 84604

Landscape Architect
EPG Design
6949 South High Tech Drive, Suite 100
Midvale, Utah 84047

Specifications Writer
Friday Group
88 Mainelli Road
Middlebury, VT

Code Consultant
Holmes
600 1st Avenue, Suite 200A
Seattle, WA 98104

Fire Protection Engineer
Jensen Hughes
One Research Drive, Suite 305C
Westborough, MA 01581

Vertical Transportation Consultant
Lerch Bates
19515 North Creek Parkway, Suite 304
Bothell, WA 98011

Structural Engineer
Magnusson Klemencic Associates
1301 5th Ave, Suite 3200
Seattle, WA 98101

Lighting Designer
O-
1319 SE MLK Blvd, Suite 210
Portland, Oregon 97219

Building Envelope Consultant
RDH
2101 N 34th St
Seattle, WA 98103

Studio Pacifica
2144 Westlake Ave N, Suite F
Seattle, WA 98109

WSP USA
1001 Fourth Ave., Suite 3100
Seattle, WA 98154

principal architect: TR
project manager: JCC
drawn by: CRB, SM

checked by Checker
job no. 20052
date 11/18/20


revisions:

NO. 0308

ISSUE FOR
CONSTRUCTION
11/18/2022

FIRE ALARM PLAN
TOWER C - LEVEL

FA2.2C.14

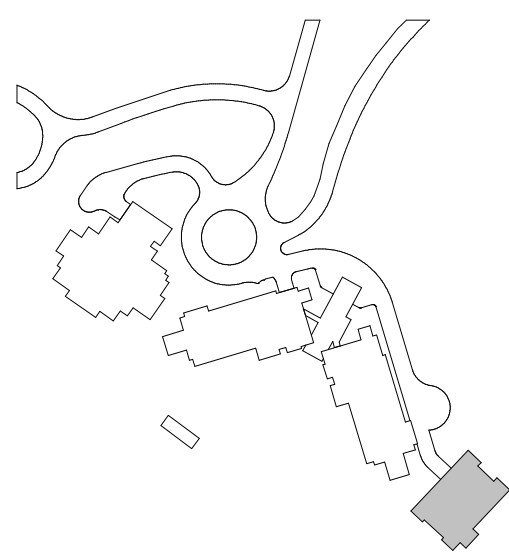

1

FIRE ALARM TERMINAL CABINET WITHIN 2-HR RATED SHAFT ACCESSIBLE VIA 2-HR RATED ACCESS PANEL. COORDINATE INSTALLATION AND ACCESS WITH DIVISION 26.

159 South Jackson St., Suite 800
Seattle, Washington 98104 USA
+1 206 624 5670 olsonkundig.com

Olson Kundig

project:
SOMMET BLANC - C
DEER VALLEY, UTAH

White Summit Development, LLC
PO Box 980022
Park City, Utah 84098

Acoustic Consultant
BRC Acoustics
1932 1st Ave, Suite 620
Seattle, WA 98101

Pool Consultant
Cloward H2O
2696 N University Ave, Suite 290
Provo, UT 84604

Landscape Architect
EPG Design
6949 South High Tech Drive, Suite 100
Midvale, Utah 84047

Specifications Writer
Friday Group
88 Mainelli Road
Middlebury, VT

Code Consultant
Holmes
600 1st Avenue, Suite 200A
Seattle, WA 98104

Fire Protection Engineer
Jensen Hughes
One Research Drive, Suite 305C
Westborough, MA 01581

Vertical Transportation Consultant
Lerch Bates
19515 North Creek Parkway, Suite 304
Bothell, WA 98011

Structural Engineer
Magnusson Klemencic Associates
1301 5th Ave, Suite 3200
Seattle, WA 98101

Lighting Designer
O-
1319 SE MLK Blvd, Suite 210
Portland, Oregon 97219

Building Envelope Consultant
RDH
2101 N 34th St
Seattle, WA 98103

Studio Pacifica
2144 Westlake Ave N, Suite F
Seattle, WA 98109

WSP USA
1001 Fourth Ave., Suite 3100
Seattle, WA 98154

principal architect: TR
project manager: JCC
drawn by: CRB, SMK

checked by: Checker
job no. 20052
date 11/18/2022

revisions:



no. 6808 by

ISSUE FOR
CONSTRUCTION

11/18/2022

FIRE ALARM PLAN -
TOWER C - LEVEL 5

FA2.2C.15

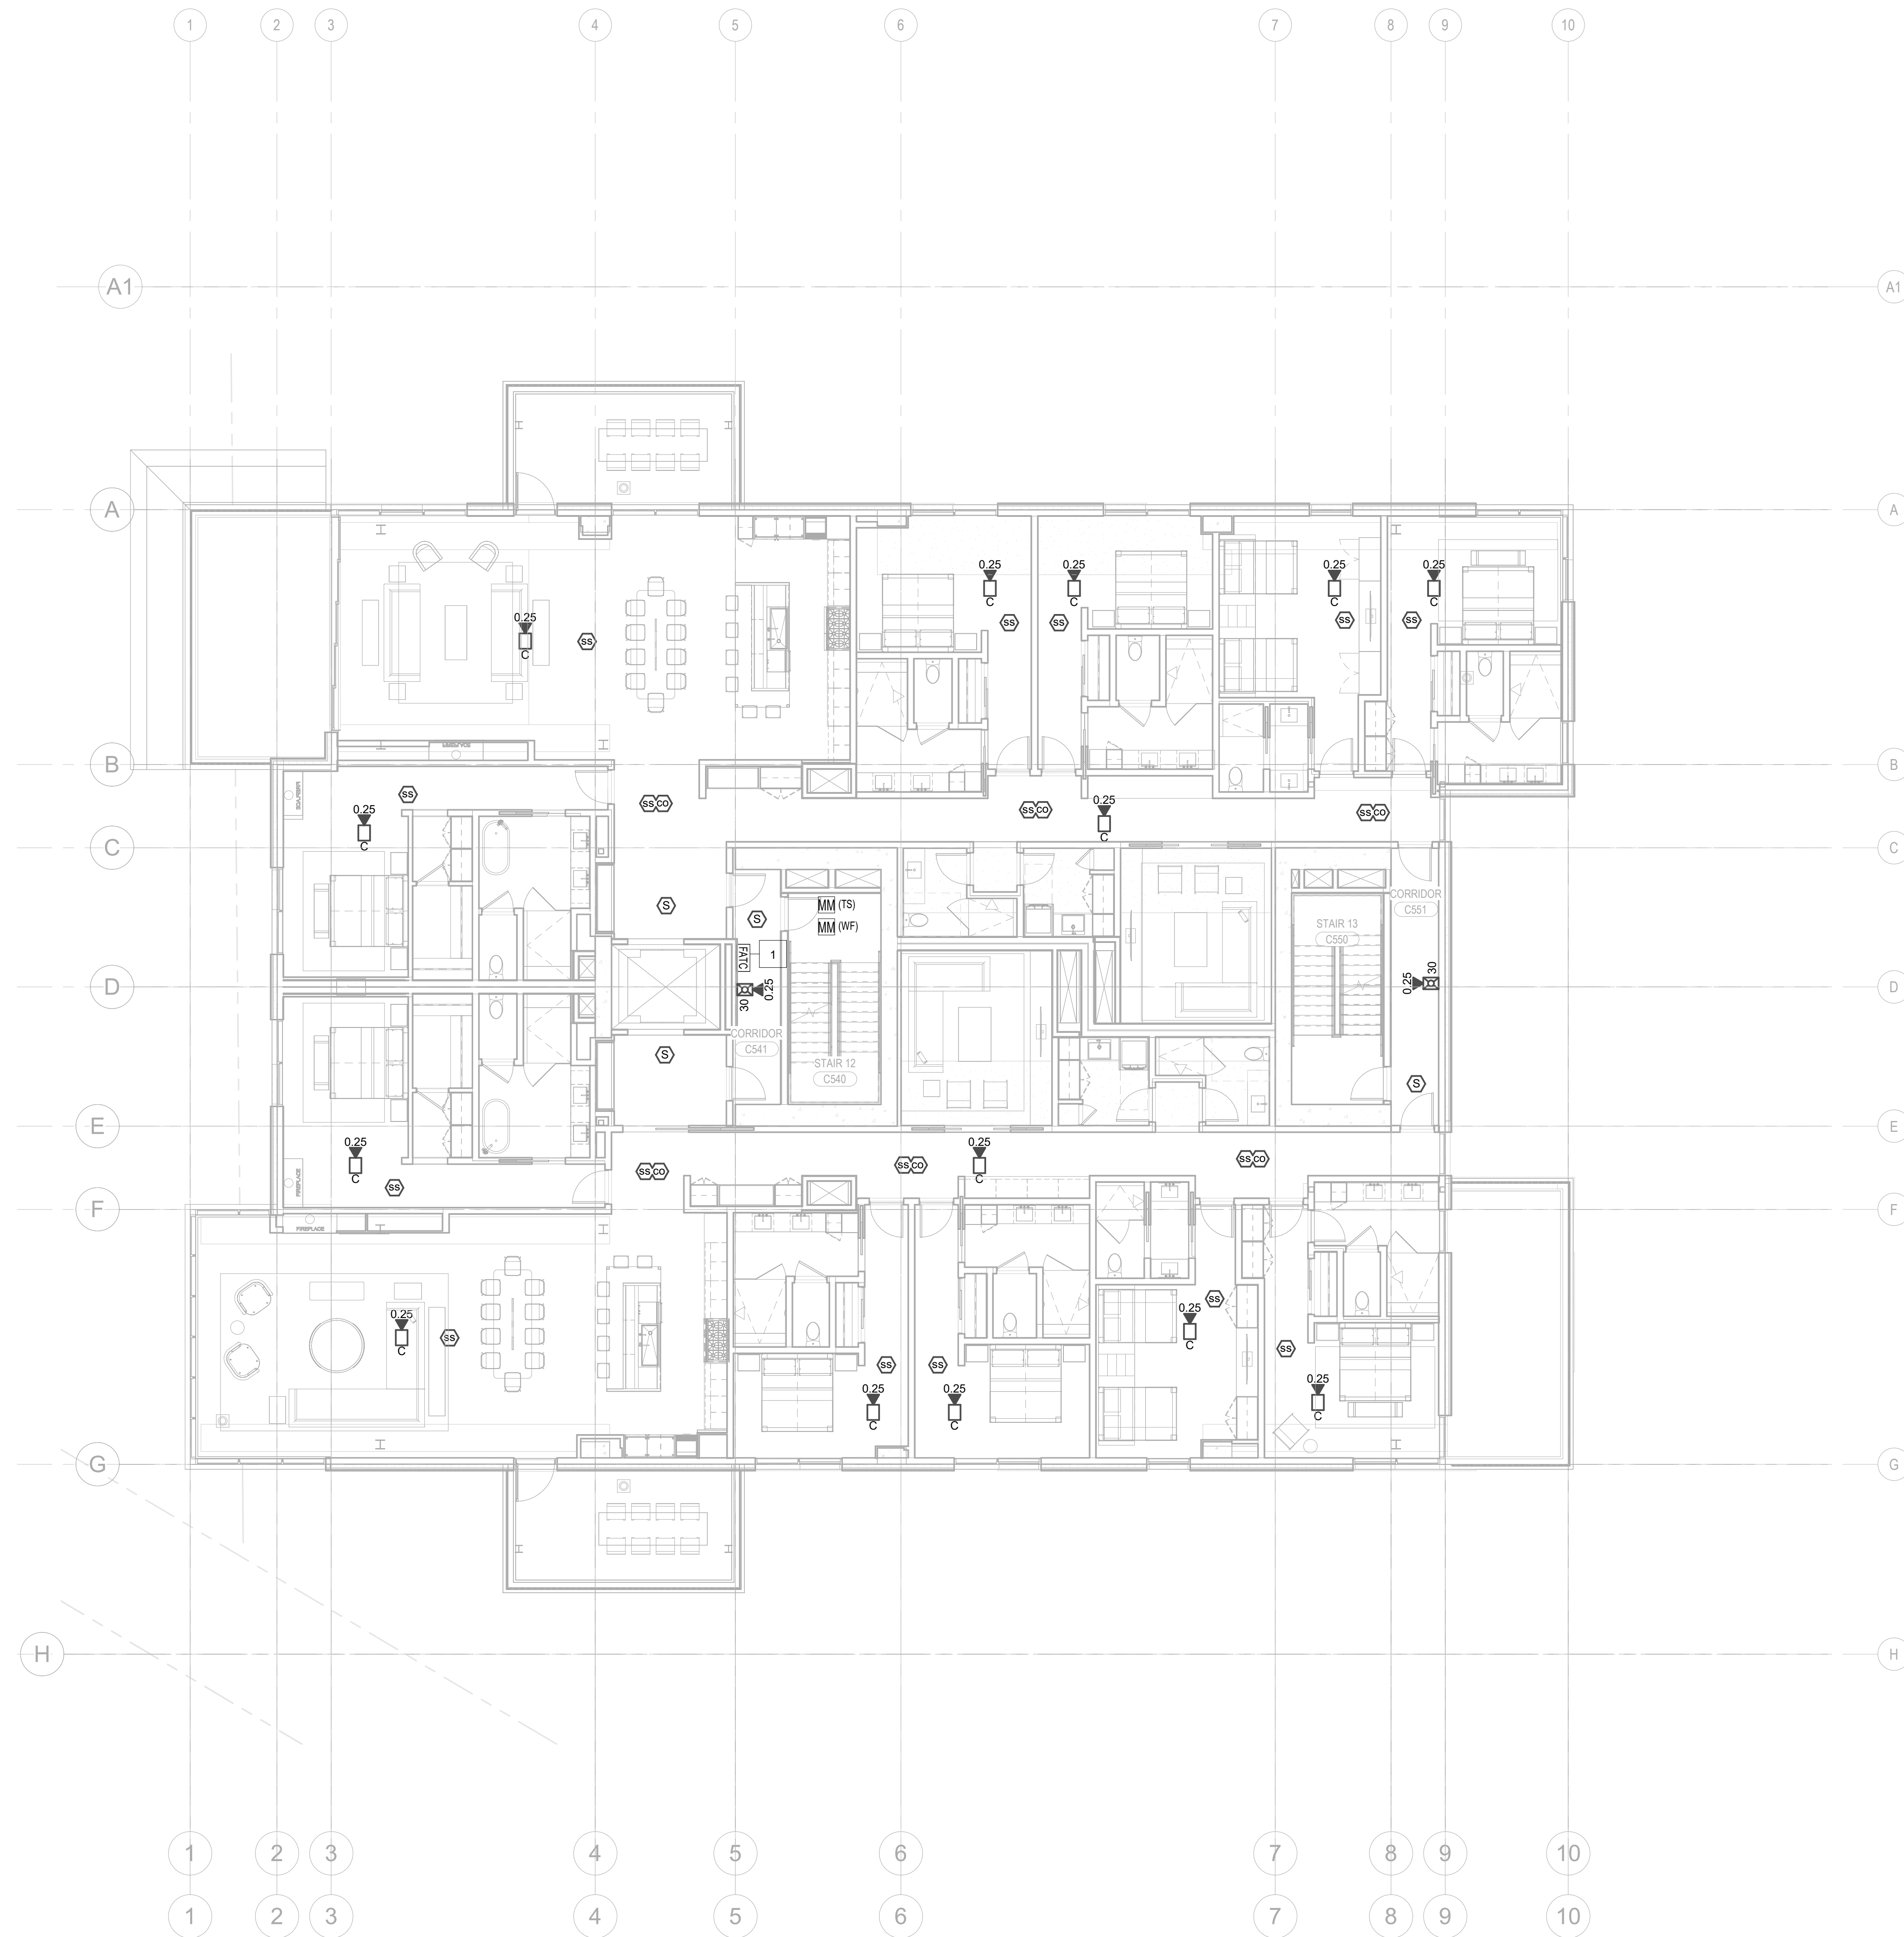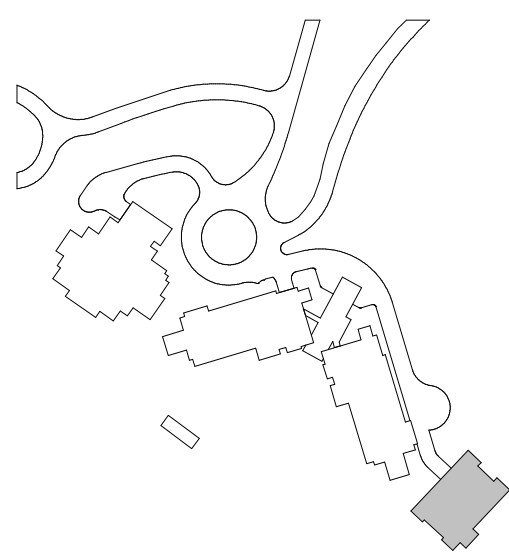

1 LEVEL 5 - FA
1/8" = 1'-0"

- KEYNOTES:**
- | | |
|---|--|
| 1 | FIRE ALARM TERMINAL CABINET WITHIN 2-HR RATED SHAFT ACCESSIBLE VIA 2-HR RATED ACCESS PANEL. COORDINATE INSTALLATION AND ACCESS WITH DIVISION 26. |
| 2 | STAIR SPEAKER FOR MANUAL PAGING CONNECTED TO DEDICATED CIRCUIT. |

Reserved for permit stamp

159 South Jackson St, Suite 600
Seattle, Washington 98104 USA
+1 206 624 5670 olsonkundig.com

Olson Kundig

project:
SOMMET BLANC - C
DEER VALLEY, UTAH

White Summit Development, LLC
PO Box 980022
Park City, Utah 84098

Acoustic Consultant
BRC Acoustics
1932 1st Ave, Suite 620
Seattle, WA 98101

Pool Consultant
Cloward H2O
2696 N University Ave, Suite 290
Provo, UT 84604

Landscape Architect
EPG Design
8949 South High Tech Drive, Suite 100
Midvale, Utah 84047

Specifications Writer
Friday Group
88 Mainelli Road
Middlebury, VT

Code Consultant
Holmes
800 1st Avenue, Suite 200A
Seattle, WA 98104

Fire Protection Engineer
Jensen Hughes
One Research Drive, Suite 305C
Westborough, MA 01581

Vertical Transportation Consultant
Lerch Bates
19515 North Creek Parkway, Suite 304
Bothell, WA 98011

Structural Engineer
Magnusson Klemencic Associates
1301 5th Ave, Suite 3200
Seattle, WA 98101

Lighting Designer
O.
1319 SE MLK Blvd, Suite 210
Portland, Oregon 97219

Building Envelope Consultant
RDH
2101 N 34th St
Seattle, WA 98103

Accessibility Consultant
Studio Pacifica
2144 Westlake Ave N, Suite F
Seattle, WA 98109

MEP Engineer
WSP USA
1001 Fourth Ave., Suite 3100
Seattle, WA 98154

principal architect TK
project manager JCC
drawn by CRB, SMK

checked by Checker
job no. 20052


revisions:

no. _____ date _____ by _____

ISSUE FOR
CONSTRUCTION
11/18/2022

FIRE ALARM PLAN -
TOWER C - LEVEL 6

FA2.2C.16

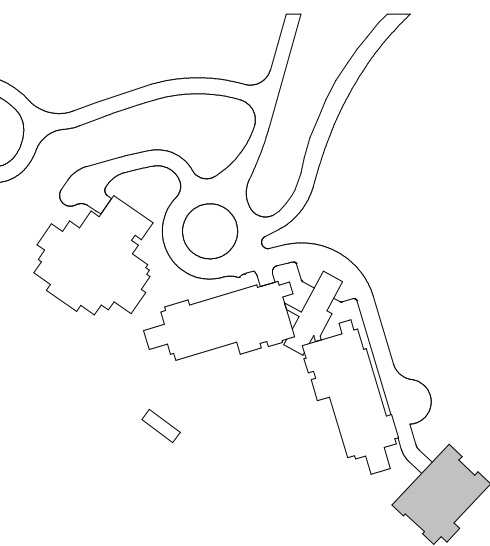

1

159 South Jackson St, Suite 800
Seattle, Washington 98104 USA
+1 206 624 5670 olsonkundig.com

Olson Kundig

project:
SOMMET BLANC - C
DEER VALLEY, UTAH

Acoustic Consultant
BRC Acoustics
1932 1st Ave, Suite 620
Seattle, WA 98101

Pool Consultant
Cloward H2O
2696 N University Ave, Suite 290
Provo, UT 84604

Landscape Architect
EPG Design
6949 South High Tech Drive, Suite 100
Midvale, Utah 84047

Specifications Writer
Friday Group
88 Mainelli Road
Middlebury, VT

Code Consultant
Holmes
600 1st Avenue, Suite 200A
Seattle, WA 98104

Fire Protection Engineer
Jensen Hughes
One Research Drive, Suite 305C
Westborough, MA 01581

Vertical Transportation Consultant
Lerch Bates
19515 North Creek Parkway, Suite 304
Bothell, WA 98011

Structural Engineer
Magnusson Klemencic Associates
1301 5th Ave, Suite 3200
Seattle, WA 98101

Lighting Designer
O.
1319 SE MLK Blvd, Suite 210
Portland, Oregon 97219

Building Envelope Consultant
RDH
2101 N 34th St
Seattle, WA 98103

Studio Pacifica
2144 Westlake Ave N, Suite F
Seattle, WA 98109

WSP USA
1001 Fourth Ave., Suite 3100
Seattle, WA 98154

principal architect JRK
project manager JCC
drawn by CRB, SMK

checked by Checker
job no. 20052
date 11/18/2022

revisions:



No. 0308 By

ISSUE FOR
CONSTRUCTION

11/18/2022

FIRE ALARM PLAN -
TOWER C - LEVEL 7

FA2.2C.17

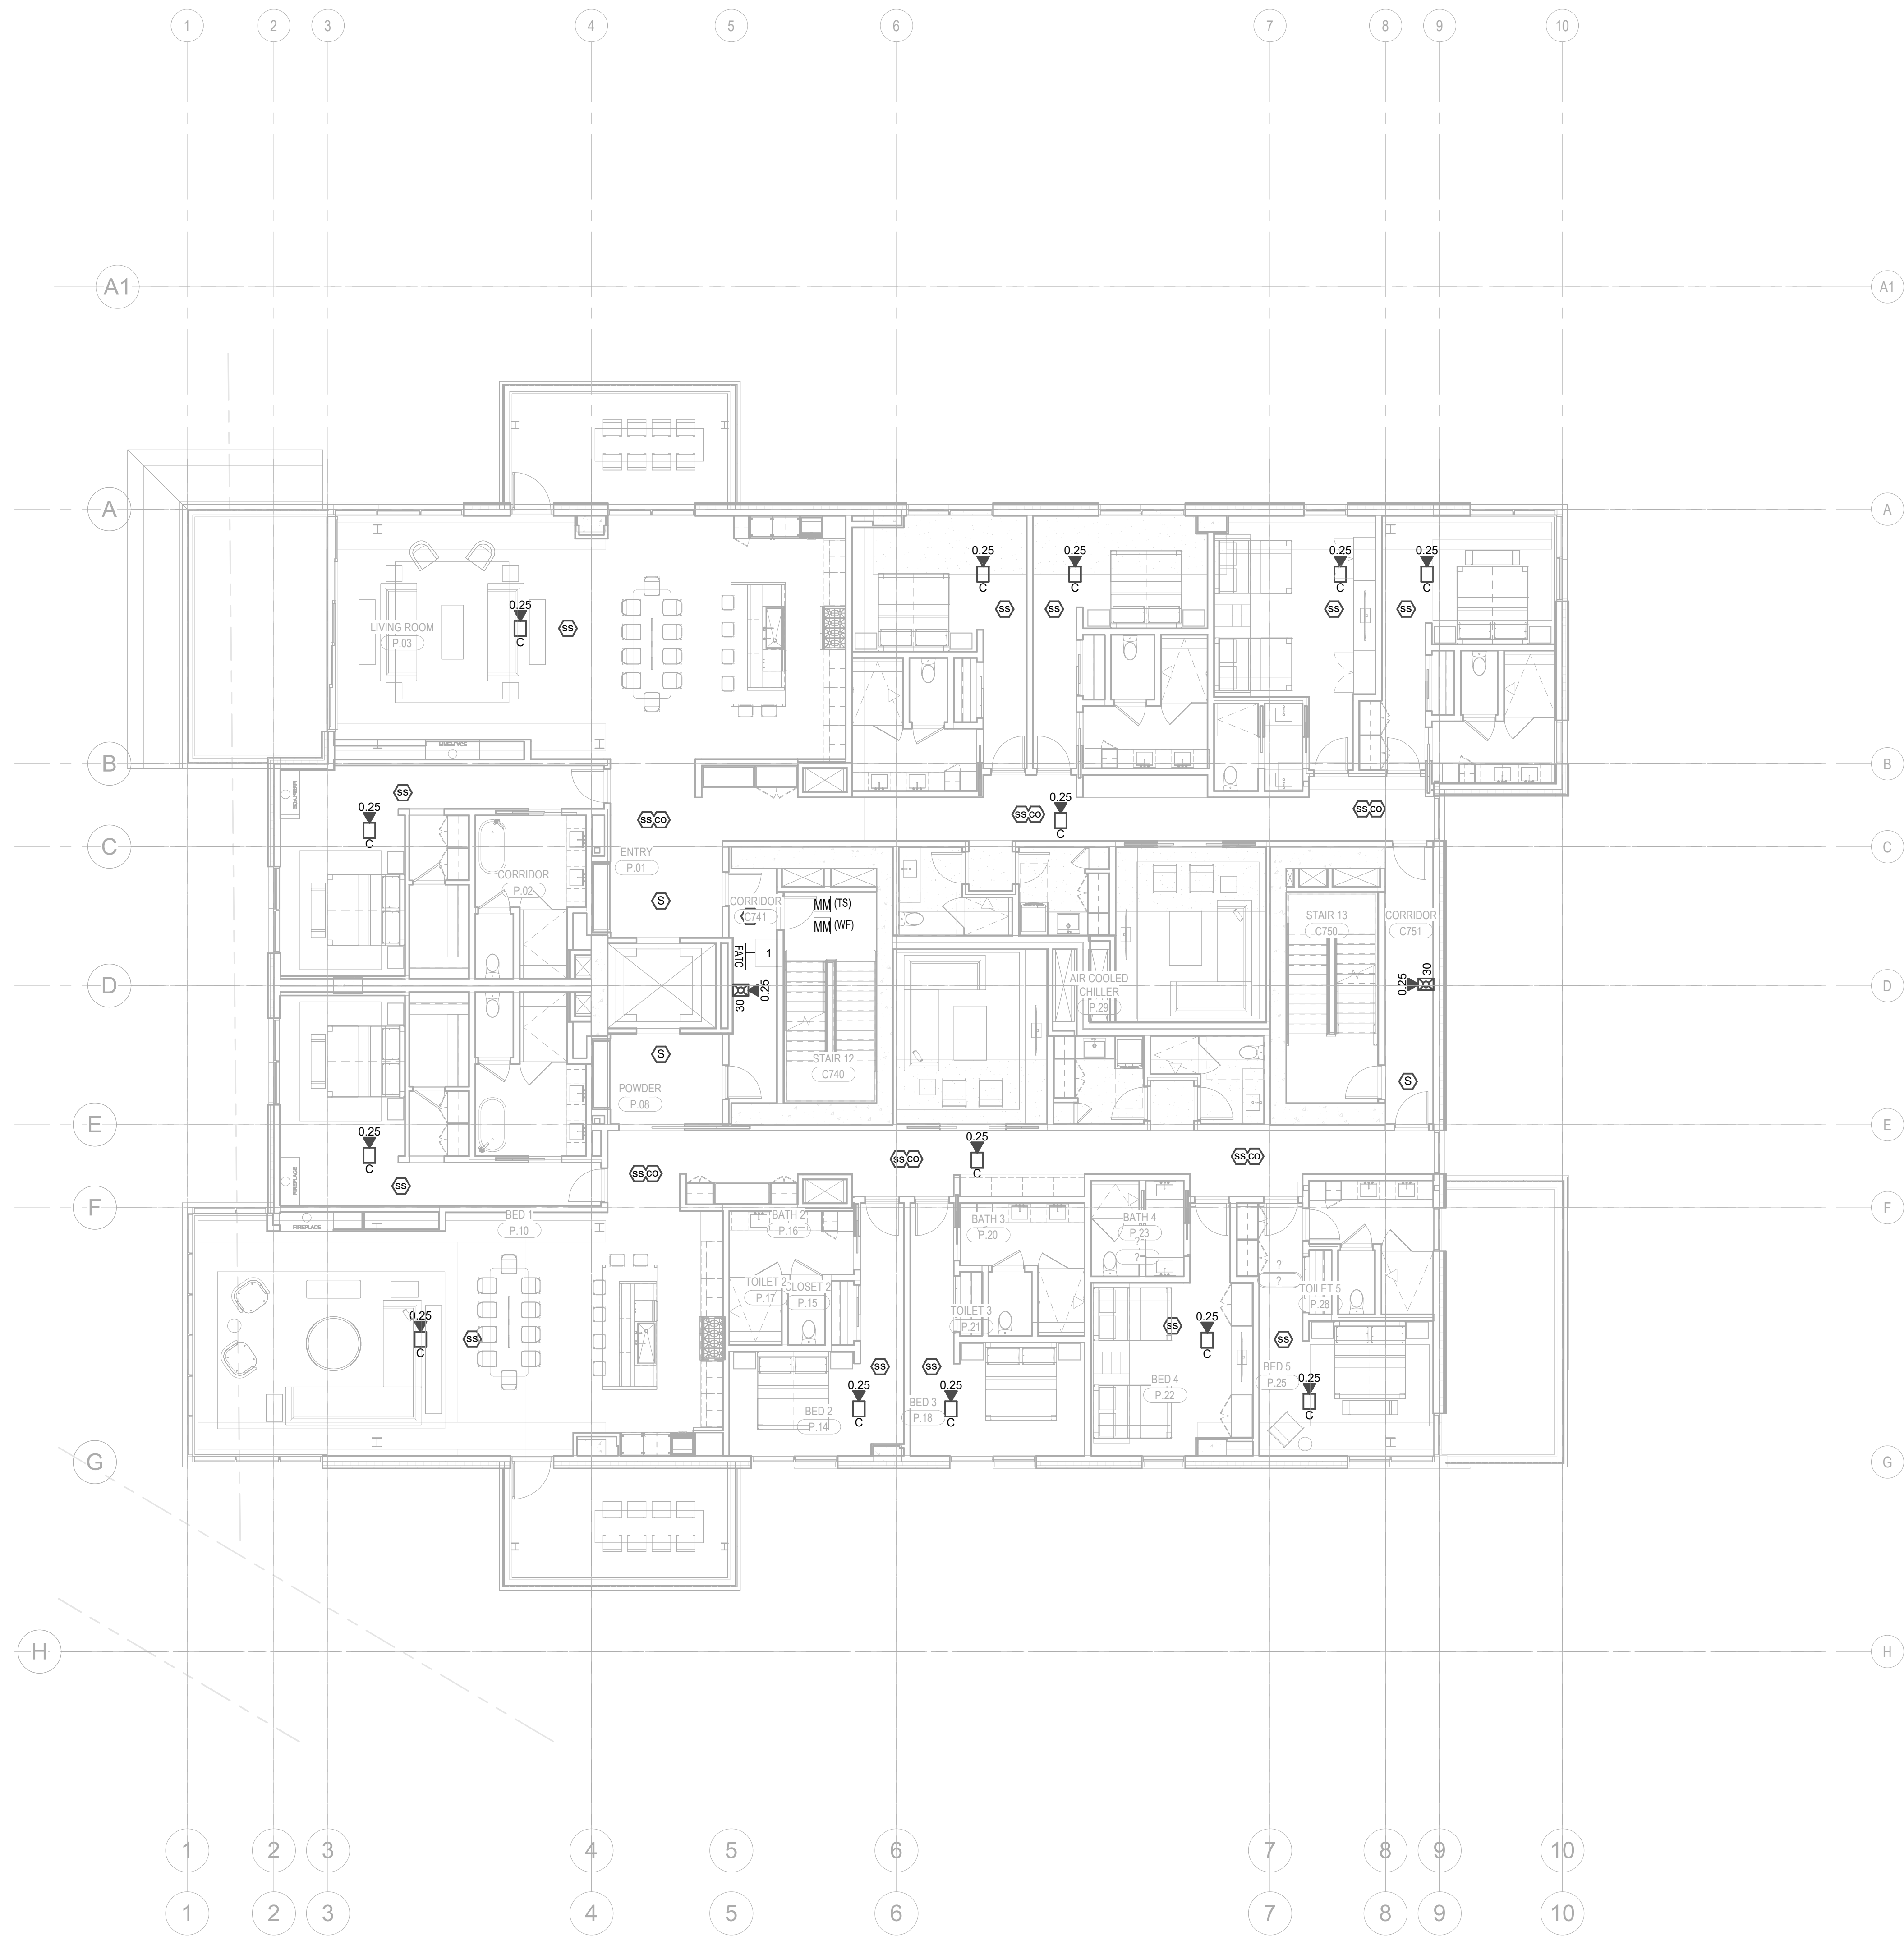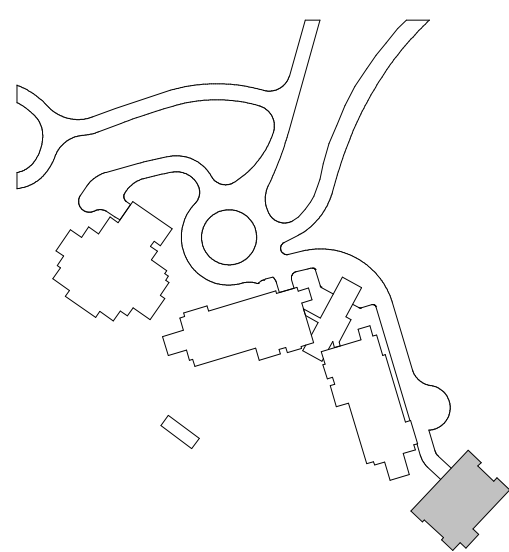

1 LEVEL 7 - FA
1/8" = 1'-0"

$$1/8'' = 1'-0''$$

- | | |
|---|--|
| 1 | FIRE ALARM RAMPANT CABINET WITHIN 2-HR RATED SHALT ACCESSIBLE VIA 2-HR RATED WALL PANEL, COORDINATE INSTALLATION AND ACCESS WITH DIVISION 26. |
| 2 | 2-HR UL LISTED RATED COAXIAL CABLE SYSTEM FROM BOX TO 2-HR RATED CLOSET. COAXIAL CABLE SHALL BE INSTALLED IN RATED CABINET. 2-HR FIRE ALARM RAMPANT WITH SPLITTERS AT EACH LEVEL ACCESSIBLE FROM SAME SPACE ACCESS PROVIDED FOR FATIC ACCESS. |
| 3 | ACCESSORY CABINET ENCLOSURE FOR SMOKE DETECTOR FAN INTERFERENCE IN NEMA-4 CONDITIONED ENCLOSURE ADJACENT TO FAN. PROVIDE FOR DETAIL. ALL ADDITIONAL INFORMATION MODULES SHALL BE CONNECTED TO 2-HR DEDICATED SLC FROM TYPICAL FACI PROVIDE FOR DETAIL. PROVIDE THROUGH FAS AND SUPERVISE FOR LOW TEMPERATURE ALARM VIA ADDRESSABLE MODULE. |
| 4 | STAIR PRESSURIZATION FLUOCT DETECTOR IN NEMA ENCLOSURE. |

159 South Jackson St, Suite 800
Seattle, Washington 98104 USA
+1 206 624 5670 olsonkundig.com

Olson Kundig

project:
SOMMET BLANC - C
DEER VALLEY, UTAH

White Summit Development, LLC
PO Box 980022
Park City, Utah 84098

Acoustic Consultant
BRC Acoustics
1932 1st Ave, Suite 620
Seattle, WA 98101

Pool Consultant
Cloward H2O
2696 N University Ave, Suite 290
Provo, UT 84604

Landscape Architect
EPG Design
6949 South High Tech Drive, Suite 100
Midvale, Utah 84047

Specifications Writer
Friday Group
88 Mainelli Road
Middlebury, VT

Code Consultant
Holmes
600 1st Avenue, Suite 200A
Seattle, WA 98104

Fire Protection Engineer
Jensen Hughes
One Research Drive, Suite 305C
Westborough, MA 01581

Vertical Transportation Consultant
Lerch Bates
19515 North Creek Parkway, Suite 304
Bothell, WA 98011

Structural Engineer
Magnusson Klemencic Associates
1301 5th Ave, Suite 3200
Seattle, WA 98101

Lighting Designer
O-
1319 SE MLK Blvd, Suite 210
Portland, Oregon 97219

Building Envelope Consultant
RDH
2101 N 34th St
Seattle, WA 98103

Accessibility Consultant
Studio Pacifica
2144 Westlake Ave N, Suite F
Seattle, WA 98109

MEP Engineer
WSP USA
1001 Fourth Ave., Suite 3100
Seattle, WA 98154

principal architect TK
project manager JCC
drawn by CRB SMK

checked by Checker
job no. 20052
date 11/18/2022

revisions:

no. date by

ISSUE FOR

11/18/2022

FIRE ALARM PLAN -
TOWER C - LEVEL 8

FA2.2C.18

