


SHEET NOTES:

- A. ALL CHILLED WATER AND HOT WATER BRANCH PIPING SHALL BE SIZED AT 1" FOR ALL FAN COIL UNITS.

NUMBERED NOTES:

1. ROUTE CONDENSATE TO NEAREST SINK DRAIN AIR GAP FITTING. SEE 31M5.04

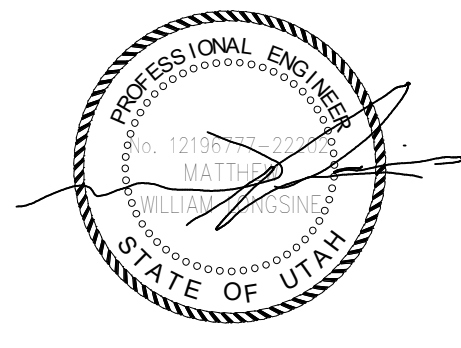

Reserved for permit stamp

109 South Jackson St., Suite 600
Seattle, Washington 98104 USA
+1 206 834 2670 ask@olsonkundig.com

Olson Kundig

project
SOMMET BLANC
9300 Marsac Ave (B2 East Parcel)
Park City, Utah 84060



Aspen Group USA, LLC
PO Box 980022
Park City, Utah 84098

Pool Consultant
Cloward M20
2696 N University Ave, Suite 290
Provo, UT 84604

Landscape Architect
EPG Design
6949 South High Tech Drive, Suite 100
Midvale, Utah 84047

Specifications Writer
Friday Group
86 Mainelli Road
Middlebury, VT

Code Consultant
Holmes
600 1st Avenue, Suite 200A
Seattle, WA 98104

Fire Protection Engineer
Jensen Hughes
One Research Drive, Suite 305C
Westborough, MA 01581

Vertical Transportation Consultant
Larch Bates
19515 North Creek Parkway, Suite 304
Bothell, WA 98011

Structural Engineer
Magnusson Klemencic Associates
1301 5th Ave, Suite 3200
Seattle, WA 98101

Lighting Designer
O-
1319 SE MLK Blvd, Suite 210
Portland, Oregon 97219

Building Envelope Consultant
RDH
2101 N 34th St
Seattle, WA 98103

Accessibility Consultant
Studio Pacifica
2144 Westlake Ave N, Suite F
Seattle, WA 98109

MEP Engineer
WSP USA
1001 Fourth Ave., Suite 3100
Seattle, WA 98154

principal architect _____
project manager _____
drawn by _____
checked by _____
job no. _____
date 11/18/2022


revisions:

no. date by



ISSUE FOR
CONSTRUCTION
11/18/2022


TOWER B - LVL B
MECHANICAL PIPING
PLAN

M3.2B.01

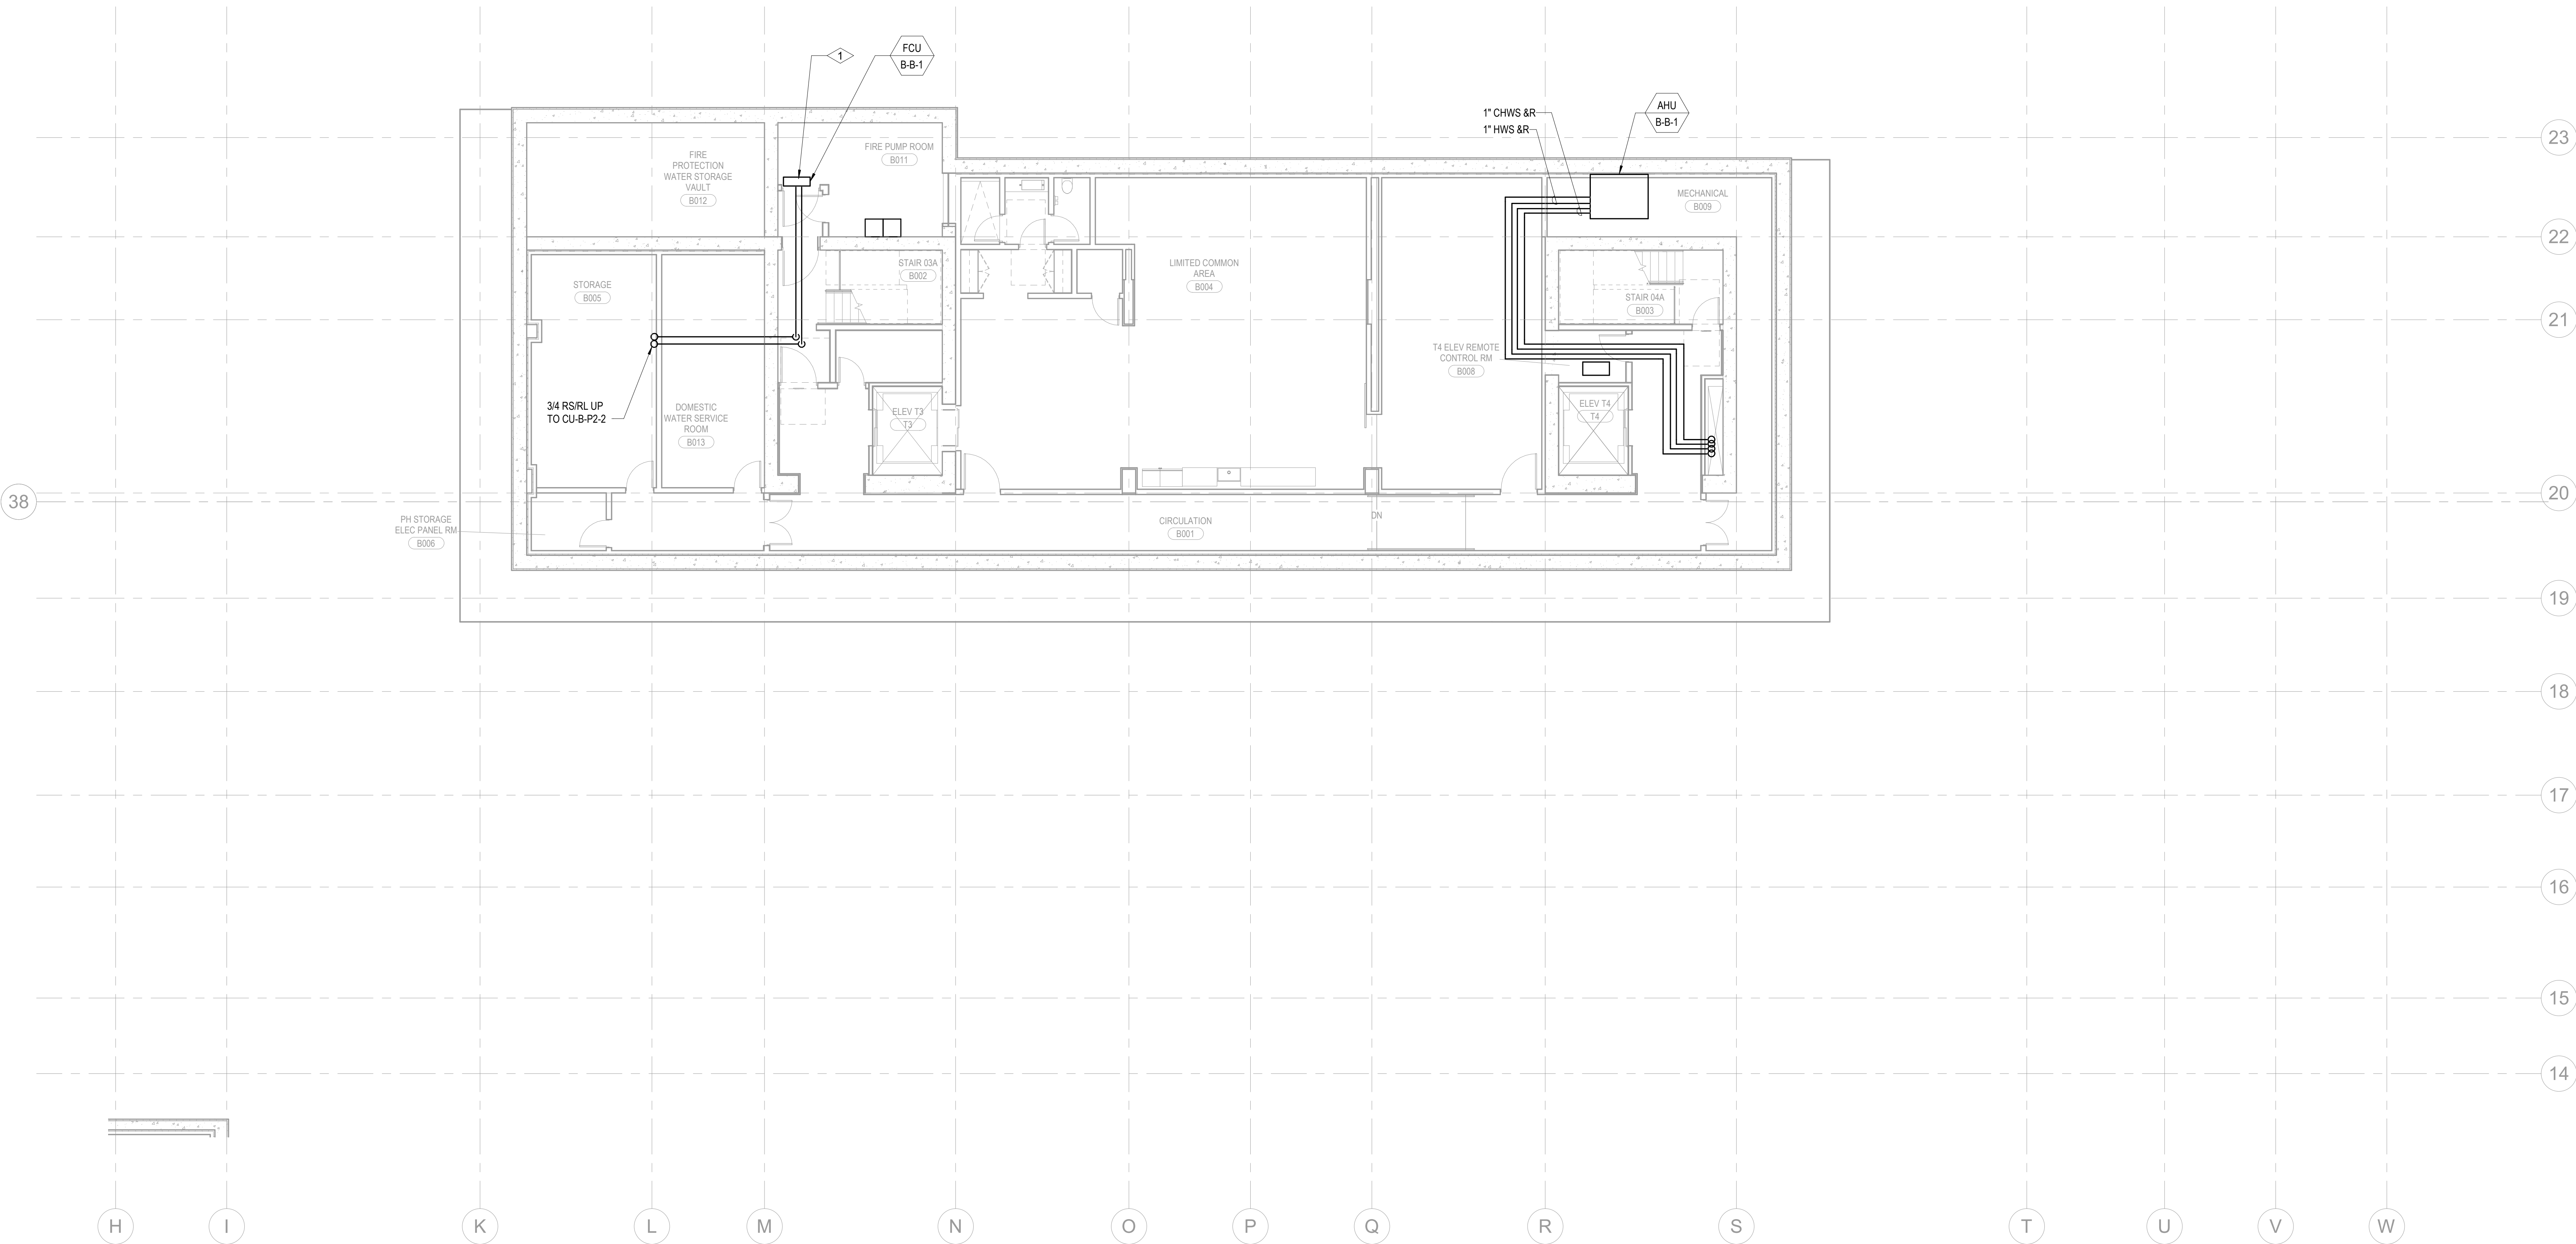

 1 TOWER B - LEVEL B1 MECHANICAL PIPING PLAN
SCALE: 1/8" = 1'-0"

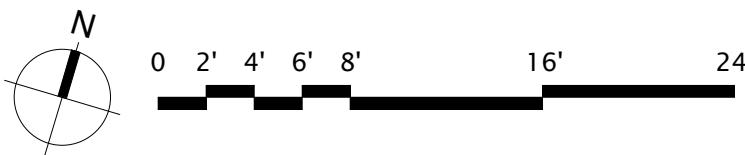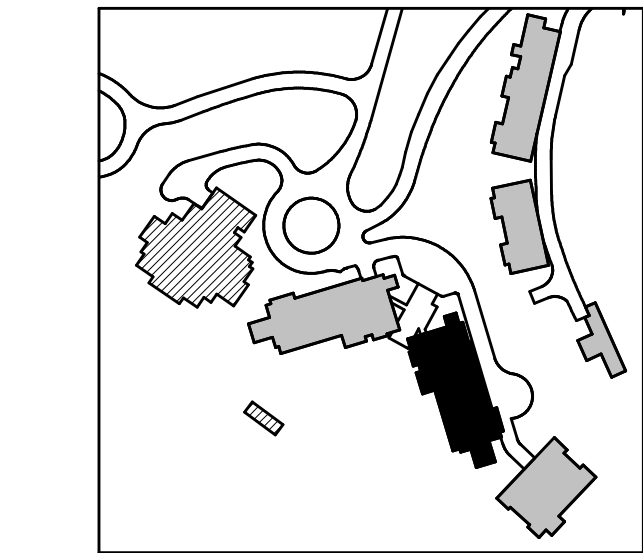




159 South Jackson St, Suite 600
Seattle, Washington 98104 USA
+1 206 624 5670 olsonlundig.com

Olson Kundig

SOMME I BLANC
9300 Marsac Ave (B2 East Parcel)
Park City, Utah 84060

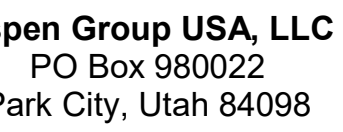

Edward H2O
6 N University Ave, Suite 290
Provo, UT 84604

3 Design
9 South High Tech Drive, Suite 100
Pleasant Dale, Utah 84047

Specifications Writer
Day Group
Mainelli Road
Middlebury, VT

Life Consultant
James
1st Avenue, Suite 200A
Seattle, WA 98104

John Hughes
Research Drive, Suite 305C
Westborough, MA 01581

Michael Bates
15 North Creek Parkway, Suite 3
Shel, WA 98011

Structural Engineer
Knudson Klemencic Associates
115th Ave, Suite 3200
Seattle, WA 98101

9 SE MLK Blvd, Suite 210
Tualatin, Oregon 97219

H
1 N 34th St
Seattle, WA 98103

Accessibility Consultant
Radio Pacifica
4 Westlake Ave N, Suite F
Seattle, WA 98109

P Engineer
P USA
1 Fourth Ave., Suite 3100
Seattle, WA 98154

principal architect _____
project manager _____
drawn by _____
checked by Checker
job no. _____
date 11/18/2022

Q15:

date b

ISSUE FOR
CONSTRUCTION
11/18/2022

POWER B - LVL P2
MECHANICAL PIPING
AN



M3.2B.02

 
SHEET NOTES:

- A. ALL CHILLED WATER AND HOT WATER BRANCH PIPING SHALL BE SIZED AT 1" FOR ALL FAN COIL UNITS.

NUMBERED NOTES:

- 1 2" FO DN TO FUEL SUBBASE TANK.
2 CHARGE AIR COOLER IS FURNISHED AND INSTALLED ON GENSET SKID BY OTHERS.

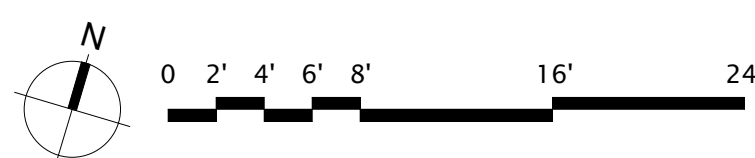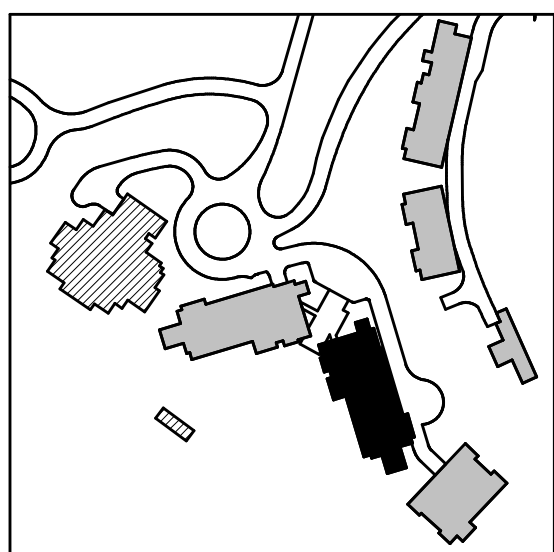




159 South Jackson St, Suite 600
Seattle, Washington 98104 USA
+1 206 624 5670 olsonlundig.com

Olson Kundig

SOMMET BLANC
9300 Marsac Ave (B2 East Parcel)
Park City, Utah 84060

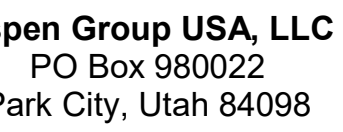

Consultant
Edward H20
65 N University Ave, Suite 290
Provo, UT 84604

Escape Architectural Design
100 South High Tech Drive, Suite 100
Provo, Utah 84047

Publications Writer
Gay Group
 Mainelli Road
 Weymouth, VT

Consultant
Services
 1st Avenue, Suite 200A
 Seattle, WA 98104

Protection Engineer
Ken Hughes
Research Drive, Suite 305C
Barnstable, MA 01581

Michael Bates
15 North Creek Parkway, Suite 304
Ell, WA 98011

Structural Engineer
Knudson Klemencic Associates
15th Ave, Suite 3200
Seattle, WA 98101

SE MLK Blvd, Suite 210
Portland, Oregon 97219

1 N 34th St
Seattle, WA 98103

Geo Pacifica
1 Westlake Ave N, Suite F
Seattle, WA 98109

USA
 1400 Fourth Ave., Suite 3100
 Seattle, WA 98154

principal architect _____
 project manager _____
 drawn by _____
 checked by Checker
 job no. _____
 date 11/18/2022

19:

date	by
------	----

ISSUE FOR
CONSTRUCTION
11/18/2022


POWER B - LVL P1
MECHANICAL PIPING
PLAN

M3.2B.03



SHEET NOTES:


A. ALL CHILLED WATER AND HOT WATER BRANCH PIPING SHALL BE SIZED AT 1" FOR ALL FAN COIL UNITS.

NUMBERED NOTES:

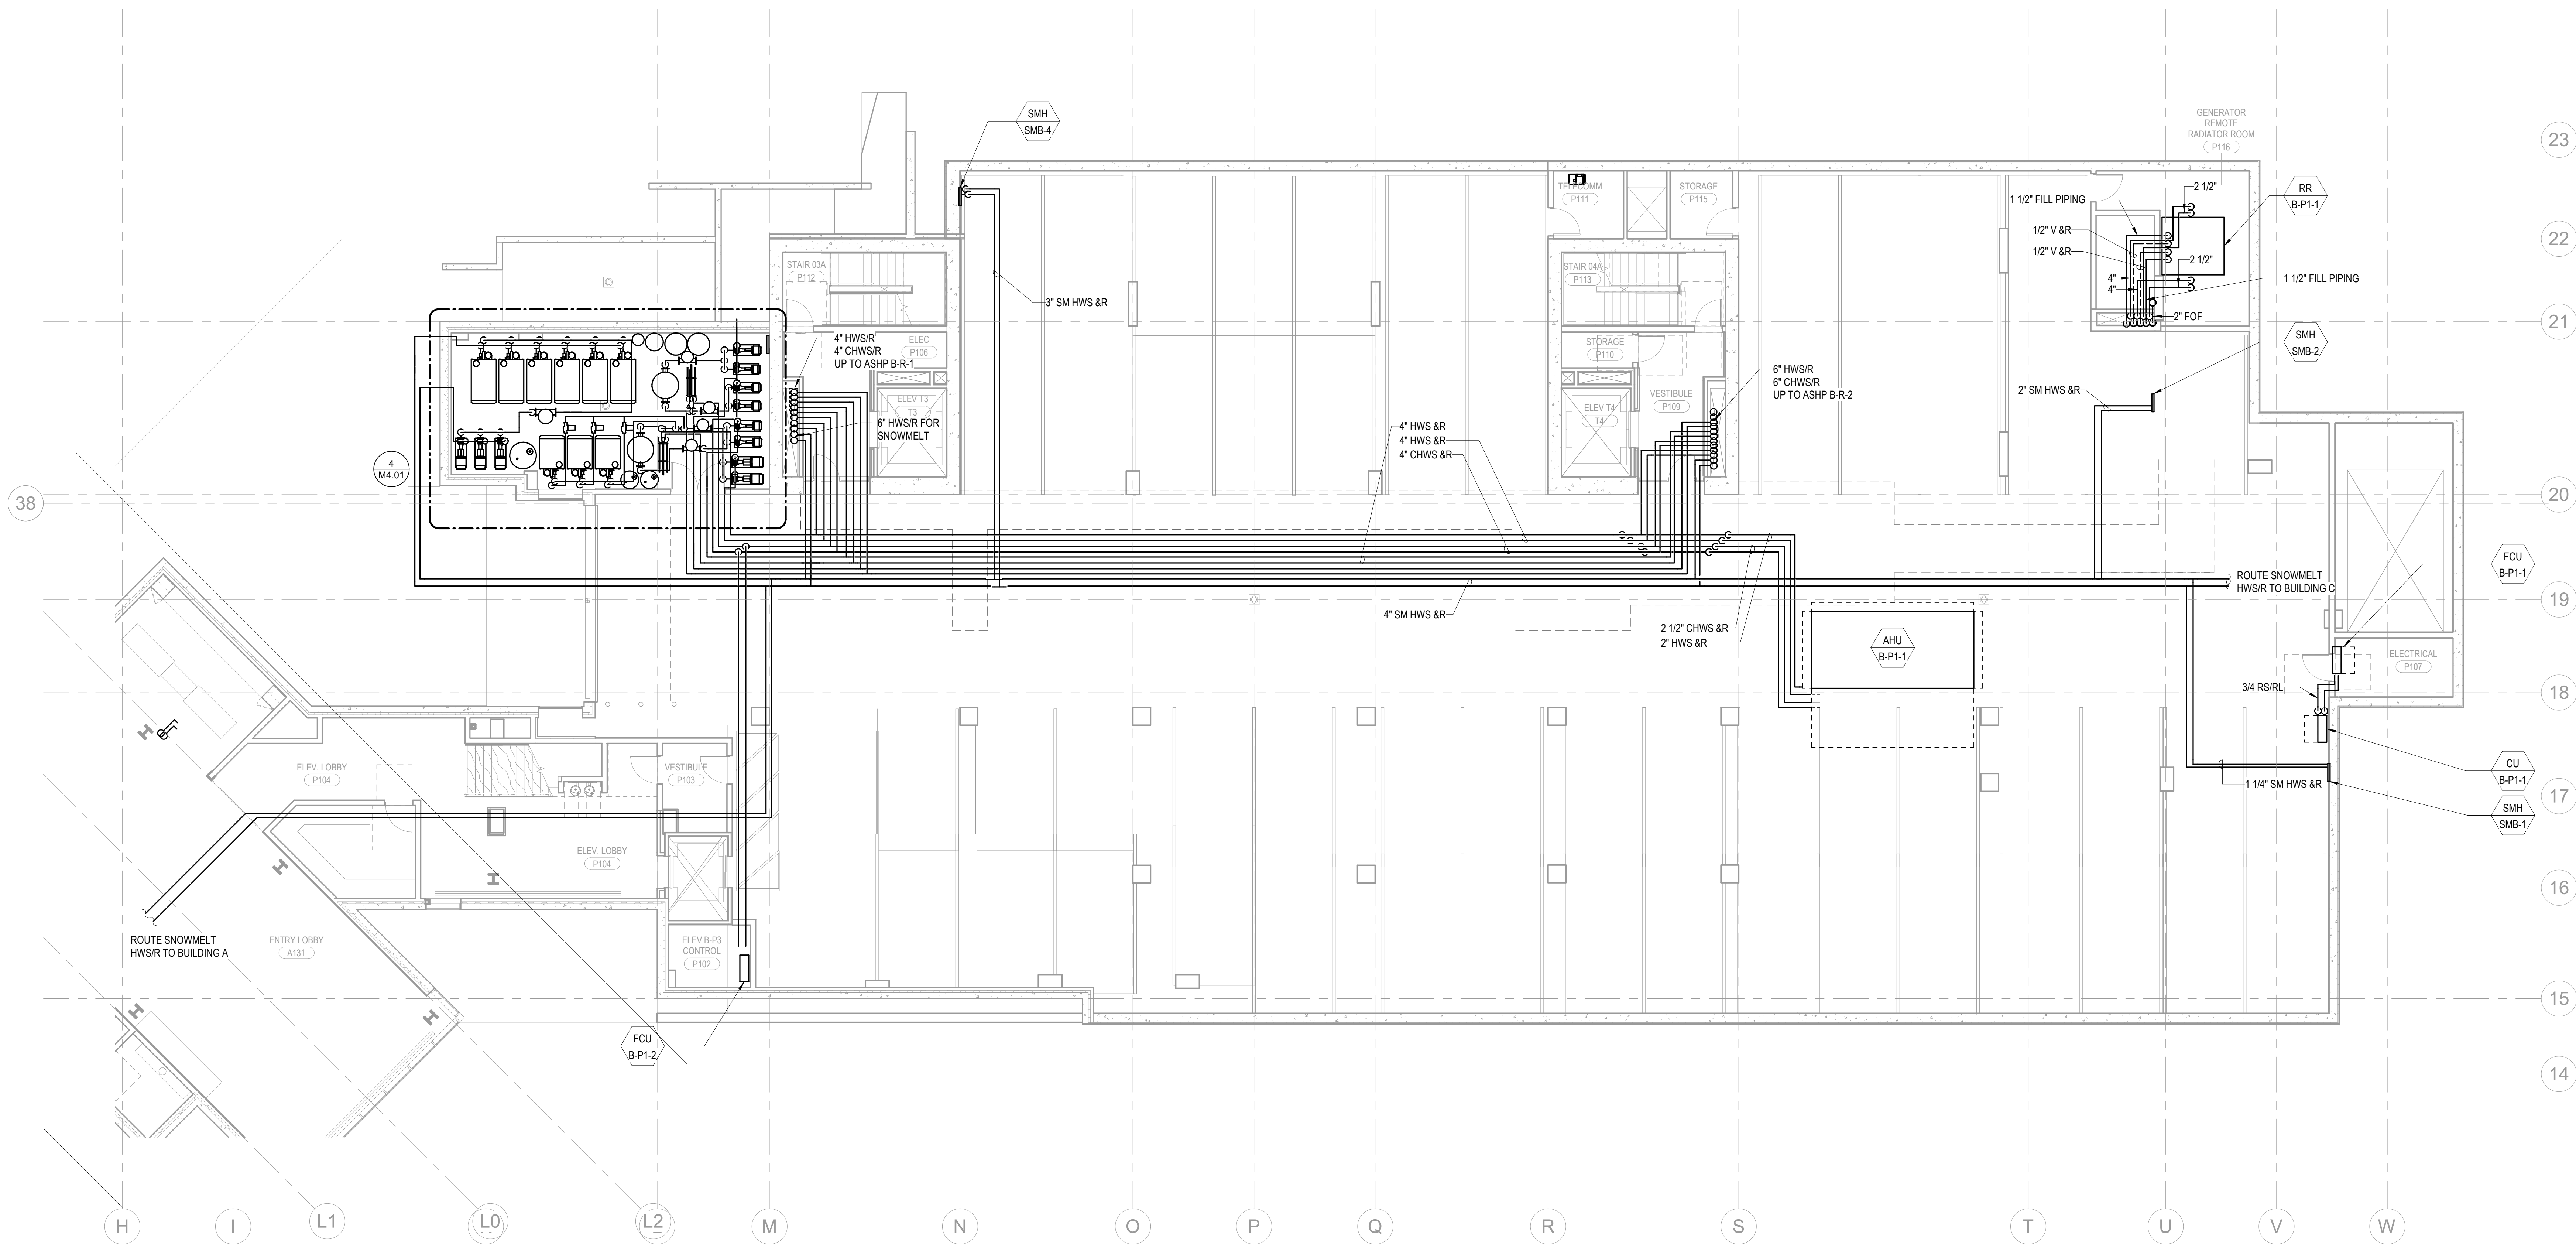

 1 TOWER B - PARKING LEVEL 1 MECHANICAL PIPING PLAN
SCALE: 1/8" = 1'-0"

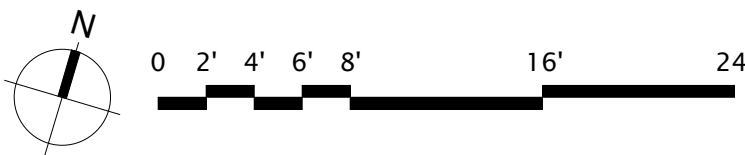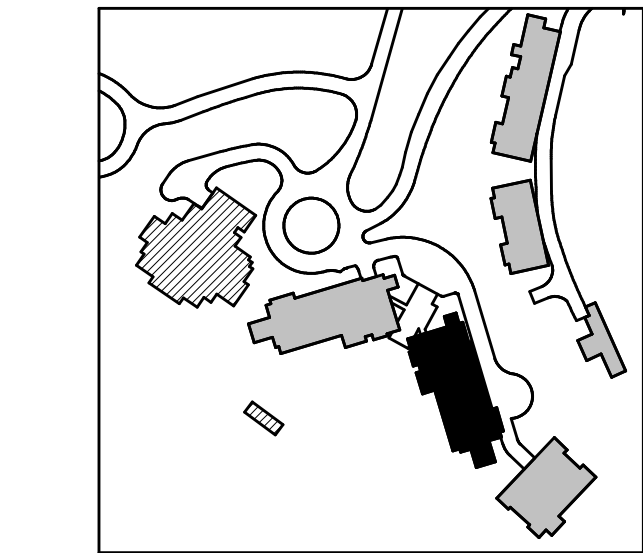




159 South Jackson St, Suite 600
Seattle, Washington 98104 USA
+1 206 624 5670 olsonkundig.com

Olson Kunding

SOMMET BLANC
9300 Marsac Ave (B2 East Parcel)
Park City, Utah 84060

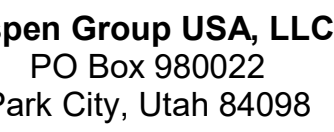

Consultant
Edward H2O
65 N University Ave, Suite 290
Provo, UT 84604

Escape Architectural Design
100 South High Tech Drive, Suite 100
Salt Lake City, Utah 84047

Ray Group
Mainelli Road
Whebury, VT

Consultant
nes
1st Avenue, Suite 200A
le, WA 98104

Protection Engineer
Ken Hughes
Research Drive, Suite 305C
Borough, MA 01581

John Bates
15 North Creek Parkway, Suite 300
Ell, WA 98011

Structural Engineer
Knudson Klemencic Associates
15th Ave, Suite 3200
Seattle, WA 98101

SE MLK Blvd, Suite 210
Portland, Oregon 97219

1 N 34th St
Seattle, WA 98103

Radio Pacifica
1 Westlake Ave N, Suite F
Seattle, WA 98109

USA
Fourth Ave., Suite 3100
Seattle, WA 98154

principal architect _____
project manager _____
drawn by _____
checked by Checker
job no. _____
date 11/18/2022

ns:

[illegible]

date

ISSUE FOR
CONSTRUCTION
11/18/2022

POWER B - LVL 1
MECHANICAL PIPING
PLAN

M3.2B.11



SHEET NOTES:

 
A. ALL CHILLED WATER AND HOT WATER BRANCH PIPING SHALL BE SIZED AT 1" FOR ALL FAN COIL UNITS.



NUMBERED NOTES

1 REMOTE FUEL FILL ASSEMBLY WITH OVERFILL PROTECTION FURNISHED BY OTHERS AND INSTALLED BY MECHANICAL CONTRACTOR. INSTALL 5' FROM BUILDING OPENINGS.

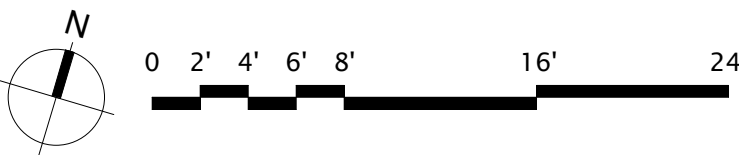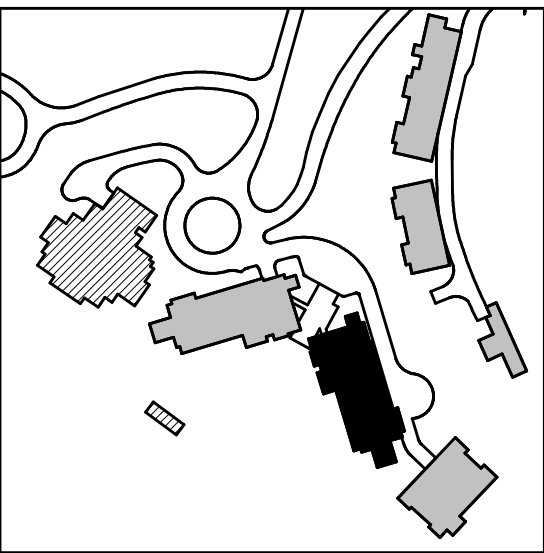




159 South Jackson St, Suite 600
Seattle, Washington 98104 USA
+1 206 624 5670 olsonkundig.com

Olson Kundig

SOMMET BLANC
9300 Marsac Ave (B2 East Parcel)
Park City, Utah 84060

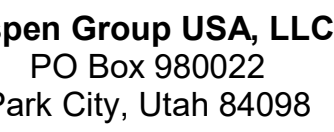

Consultant
Edward H2O
65 N University Ave, Suite 290
Salt Lake City, UT 84604

Escape Architectural Design
100 South High Tech Drive, Suite 100
Salt Lake City, Utah 84047

Publications Writer
Ray Group
Mainelli Road
Whebury, VT

Consultant
Services
1st Avenue, Suite 200A
Seattle, WA 98104

Protection Engineer
Ken Hughes
Research Drive, Suite 305C
Borough, MA 01581

Local Transportation Consultant
 Ch Bates
 15 North Creek Parkway, Suite 300
 Ell, WA 98011

Structural Engineer
Donusson Klemencic Associates
15th Ave, Suite 3200
Seattle, WA 98101

SE MLK Blvd, Suite 210
Portland, Oregon 97216

Envelope Consultant
N 34th St
111 33155

Accessibility Consultant
Radio Pacifica
1 Westlake Ave N, Suite F

Engineer
USA
Fourth Ave., Suite 3100

Principal architect _____

drawn by _____

checked by Checker

date 11/18/2022

100

CONSTRUCTION



MECHANICAL PIPING

13.2B.12

SHEET NOTES:

A. ALL CHILLED WATER AND HOT WATER BRANCH PIPING SHALL BE SIZED AT 1" FOR ALL FAN COIL UNITS.


NUMBERED NOTES:

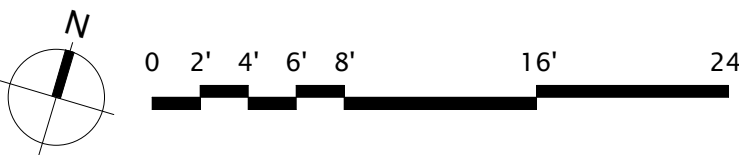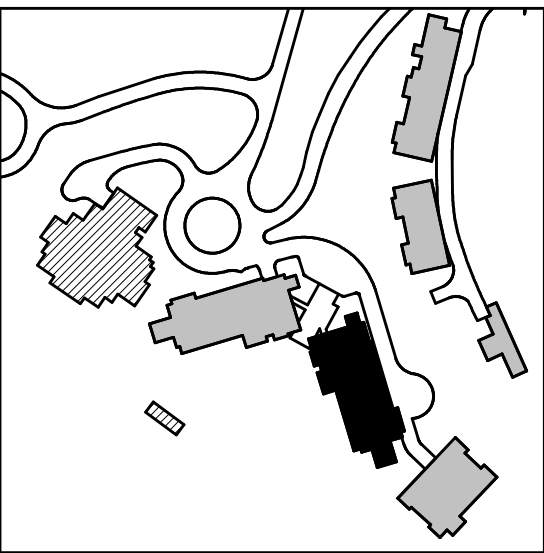

ER B - LVL 2

MECHANICAL PIPING

13 2B 12

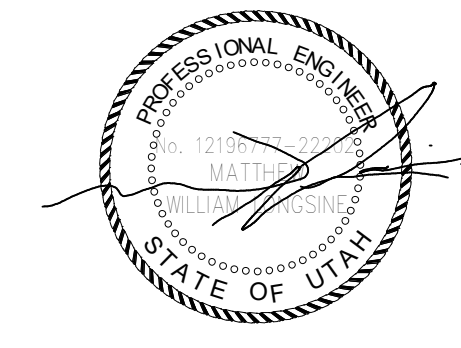

Reserved for permit stamp

100 South Jackson St., Suite 600
Seattle, Washington 98104 USA
+1 206 834 2670 olsonkundig.com

Olson Kundig

project
SOMMET BLANC
9300 Marzac Ave (B2 East Parcel)
Park City, Utah 84060



Aspen Group USA, LLC
PO Box 980022
Park City, Utah 84098

Pool Consultant
Cloward M20
2696 N University Ave, Suite 290
Provo, UT 84604

Landscape Architect
EPG Design
6048 South High Tech Drive, Suite 100
Midvale, Utah 84047

Specifications Writer
Friday Group
86 Mainelli Road
Middlebury, VT

Code Consultant
Holmes
600 1st Avenue, Suite 200A
Seattle, WA 98104

Fire Protection Engineer
Jensen Hughes
One Research Drive, Suite 305C
Westborough, MA 01581

Vertical Transportation Consultant
Larch Bates
19515 North Creek Parkway, Suite 304
Bothell, WA 98011

Structural Engineer
Magnusson Klemencic Associates
1301 5th Ave, Suite 3200
Seattle, WA 98101

Lighting Designer
O-
1319 SE MLK Blvd, Suite 210
Portland, Oregon 97219

Building Envelope Consultant
RDH
2101 N 34th St
Seattle, WA 98103

Accessibility Consultant
Studio Pacifica
2144 Westlake Ave N, Suite F
Seattle, WA 98109

MEP Engineer
WSP USA
1001 Fourth Ave., Suite 3100
Seattle, WA 98154

principal architect _____
project manager _____
drawn by _____
checked by _____
job no. _____
date 11/18/2022

revisions:

no. date by

ISSUE FOR
CONSTRUCTION
11/18/2022

TOWER B - LVL 3
MECHANICAL PIPING
PLAN



M3.2B.13

 
SHEET NOTES:

- A. ALL CHILLED WATER AND HOT WATER BRANCH PIPING
SHALL BE SIZED AT 1" FOR ALL FAN COIL UNITS.

NUMBERED NOTES:


1 TOWER B - LEVEL 3 MECHANICAL PIPING PLAN
SCALE: 1/8" = 1'-0"

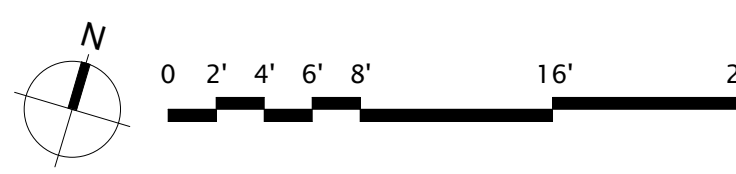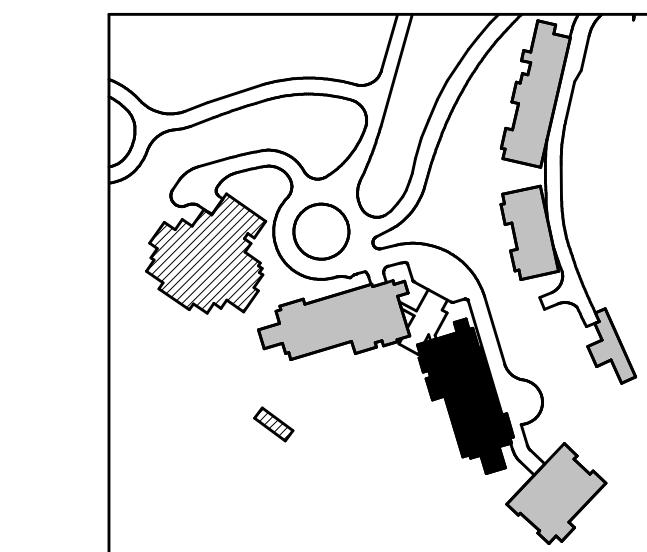



Olson Kundig

SOMME I BLANC
9300 Marsac Ave (B2 East Parcel)
Park City, Utah 84060

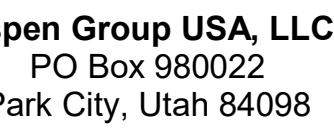

USA
Fourth Ave., Suite 3100
Seattle, WA 98154

W19:

date

ISSUE FOR
CONSTRUCTION
11/18/2022


POWER B - LVL 4
MECHANICAL PIPING
MAN

 
M3.2B.14

SHEET NOTES:

A. ALL CHILLED WATER AND HOT WATER BRANCH PIPING SHALL BE SIZED AT 1" FOR ALL FAN COIL UNITS.

NUMBERED NOTES:

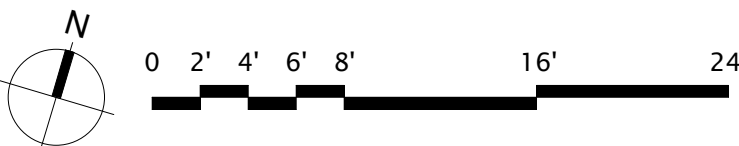




159 South Jackson St., Suite 600
Seattle, Washington 98104 USA
+1 206 624 5670 olsonkundig.com

Olson Kundig

SOMMET BLANC
9300 Marsac Ave (B2 East Parcel)
Park City, Utah 84060

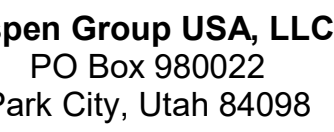

Consultant
Edward H20
65 N University Ave, Suite 290
Provo, UT 84604

Design
100 South High Tech Drive, Suite 10
Provo, Utah 84047

Publications Writer
Ray Group
Mainelli Road
Whebury, VT

**Consultant
Services**
1st Avenue, Suite 200A
Seattle, WA 98104

Protection Engineer
Ken Hughes
Research Drive, Suite 305C
Northborough, MA 01581

Cal Transportation Consultant
Ch Bates
15 North Creek Parkway, Suite 300
Ell, WA 98011

Structural Engineer
Knudson Klemencic Associates
15th Ave, Suite 3200
Seattle, WA 98101

SE MLK Blvd, Suite 210
Portland, Oregon 97219

Envelope Consultant
1 N 34th St
Seattle, WA 98103

Geo Pacifica
1 Westlake Ave N, Suite F
Seattle, WA 98109

USA
Fourth Ave., Suite 3100
Seattle, WA 98154

principal architect _____
project manager _____
drawn by _____
checked by Checker
job no. _____
date 11/18/2022

[illegible]

ISSUE FOR
CONSTRUCTION
11/18/2022


POWER B - LVL 5
MECHANICAL PIPING
MAN

M3.2B.15



SHEET NOTES:


A. ALL CHILLED WATER AND HOT WATER BRANCH PIPING SHALL BE SIZED AT 1" FOR ALL FAN COIL UNITS.

NUMBERED NOTES:

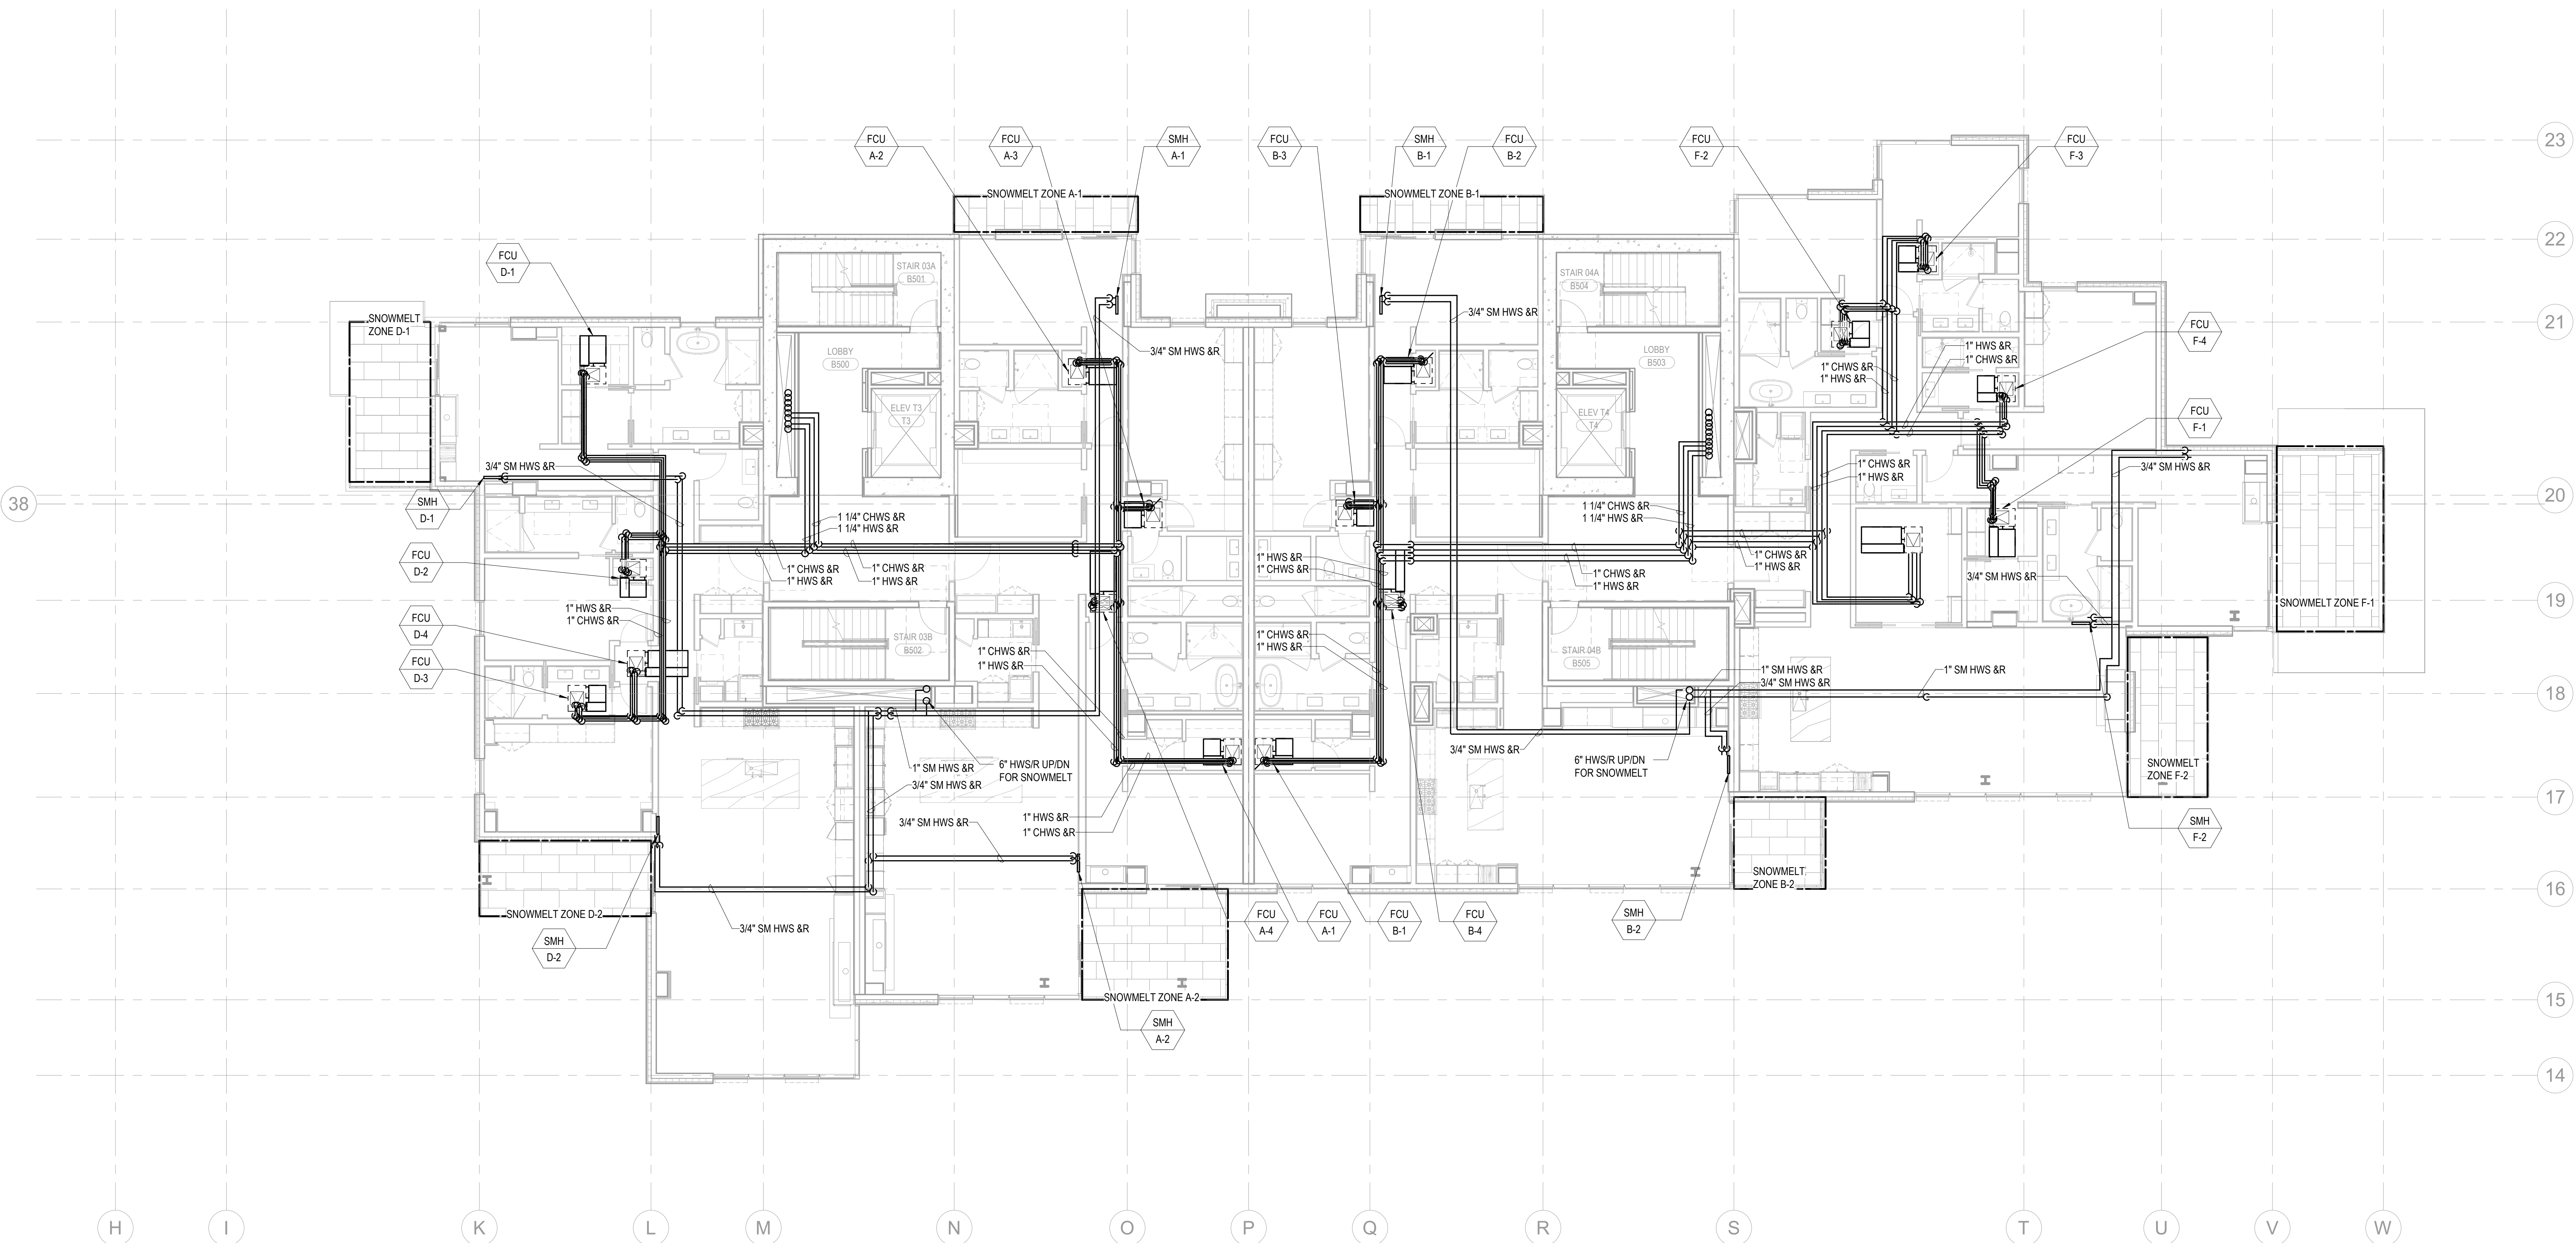

 1 TOWER B - LEVEL 5 MECHANICAL PIPING PLAN
SCALE: 1/8" = 1'-0"

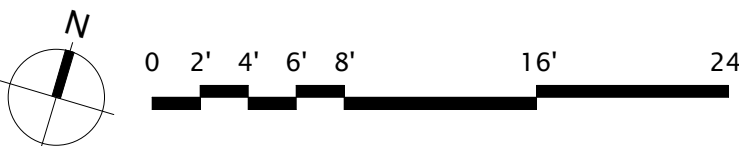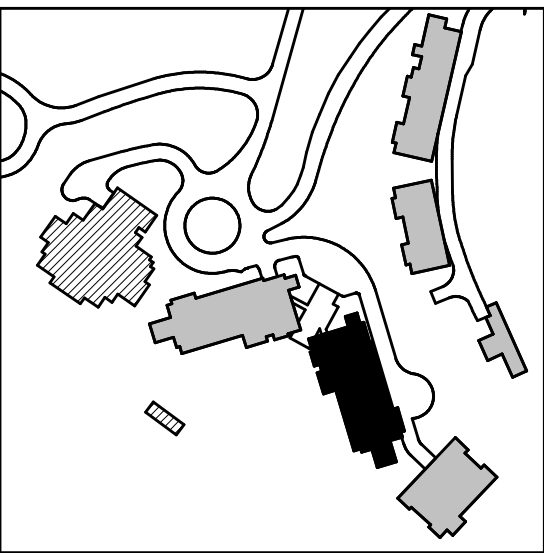




159 South Jackson St, Suite 600
Seattle, Washington 98104 USA
+1 206 624 5670 olsonkundig.com

Olson Kunding

SOMMET BLANC
9300 Marsac Ave (B2 East Parcel)
Park City, Utah 84060

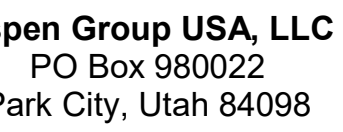

Consultant
Edward H2O
65 N University Ave, Suite 290
Salt Lake City, UT 84604

Escape Architectural Design
100 South High Tech Drive, Suite 100
Provo, Utah 84047

Ray Group
Mainelli Road
Whebury, VT

Consultant
nes
1st Avenue, Suite 200A
le, WA 98104

Protection Engineer
Ken Hughes
Research Drive, Suite 305C
Borough, MA 01581

Local Transportation Consultant
Ch Bates
15 North Creek Parkway, Suite 300
Ell, WA 98011

Structural Engineer
Knusson Klemencic Associates
15th Ave, Suite 3200
Seattle, WA 98101

SE MLK Blvd, Suite 210
Portland, Oregon 97219

Envelope Consultant
N 34th St
le, WA 98103

Feasibility Consultant
Radio Pacifica
1 Westlake Ave N, Suite F
Seattle, WA 98109

Engineer
USA
Fourth Ave., Suite 3100
Seattle, WA 98154

principal architect _____
project manager _____
drawn by _____
checked by Checker
job no. _____
date 11/18/2022

Q15:

date b7

ISSUE FOR
CONSTRUCTION
11/18/2022

POWER B - LVL 6
MECHANICAL PIPING
PLAN



M3.2B.16

 
SHEET NOTES:

- A. ALL CHILLED WATER AND HOT WATER BRANCH PIPING SHALL BE SIZED AT 1" FOR ALL FAN COIL UNITS.



NUMBERED NOTES

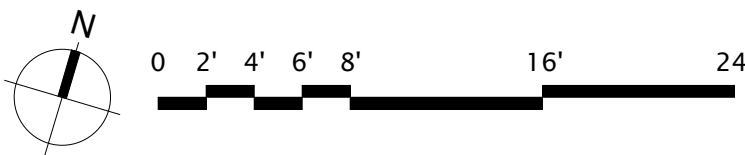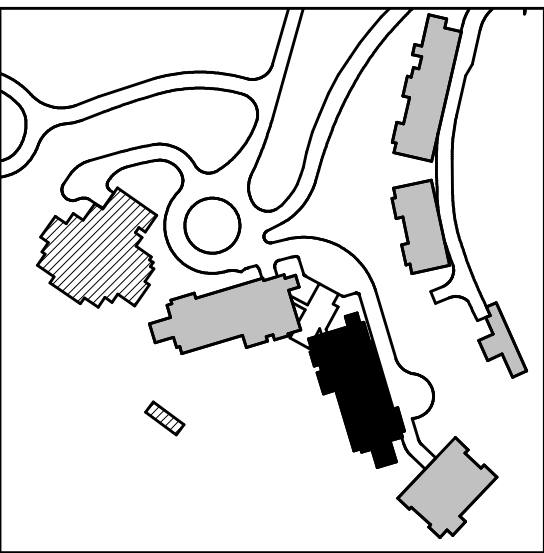




159 South Jackson St., Suite 600
Seattle, Washington 98104 USA
+1 206 624 5670 olsonkundig.com

Olson Kunding

SOMMET BLANC
9300 Marsac Ave (B2 East Parcel)
Park City, Utah 84060

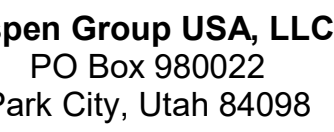

Consultant
Edward H2O
65 N University Ave, Suite 290
Provo, UT 84604

Design
100 South High Tech Drive, Suite 100
Provo, Utah 84047

Ray Group
Mainelli Road
Whebury, VT

**Consultant
Services**
1st Avenue, Suite 200A
Seattle, WA 98104

Protection Engineer
Ken Hughes
Research Drive, Suite 305C
Northborough, MA 01581

Cal Transportation Consultant
Ch Bates
15 North Creek Parkway, Suite 300
Ell, WA 98011

Structural Engineer
Knudson Klemencic Associates
15th Ave, Suite 3200
Seattle, WA 98101

SE MLK Blvd, Suite 210
Portland, Oregon 97219

1 N 34th St
Seattle, WA 98103

Radio Pacifica
1 Westlake Ave N, Suite F
Seattle, WA 98109

USA
Fourth Ave., Suite 3100
Seattle, WA 98154

principal architect _____
project manager _____
drawn by _____
checked by Checker
job no. _____
date 11/18/2022

19:

date

ISSUE FOR
CONSTRUCTION
11/18/2022

POWER B - LVL 7
MECHANICAL PIPING
MAN


M3.2B.17

SHEET NOTES:

- A. ALL CHILLED WATER AND HOT WATER BRANCH PIPING SHALL BE SIZED AT 1" FOR ALL FAN COIL UNITS.




NUMBERED NOTES

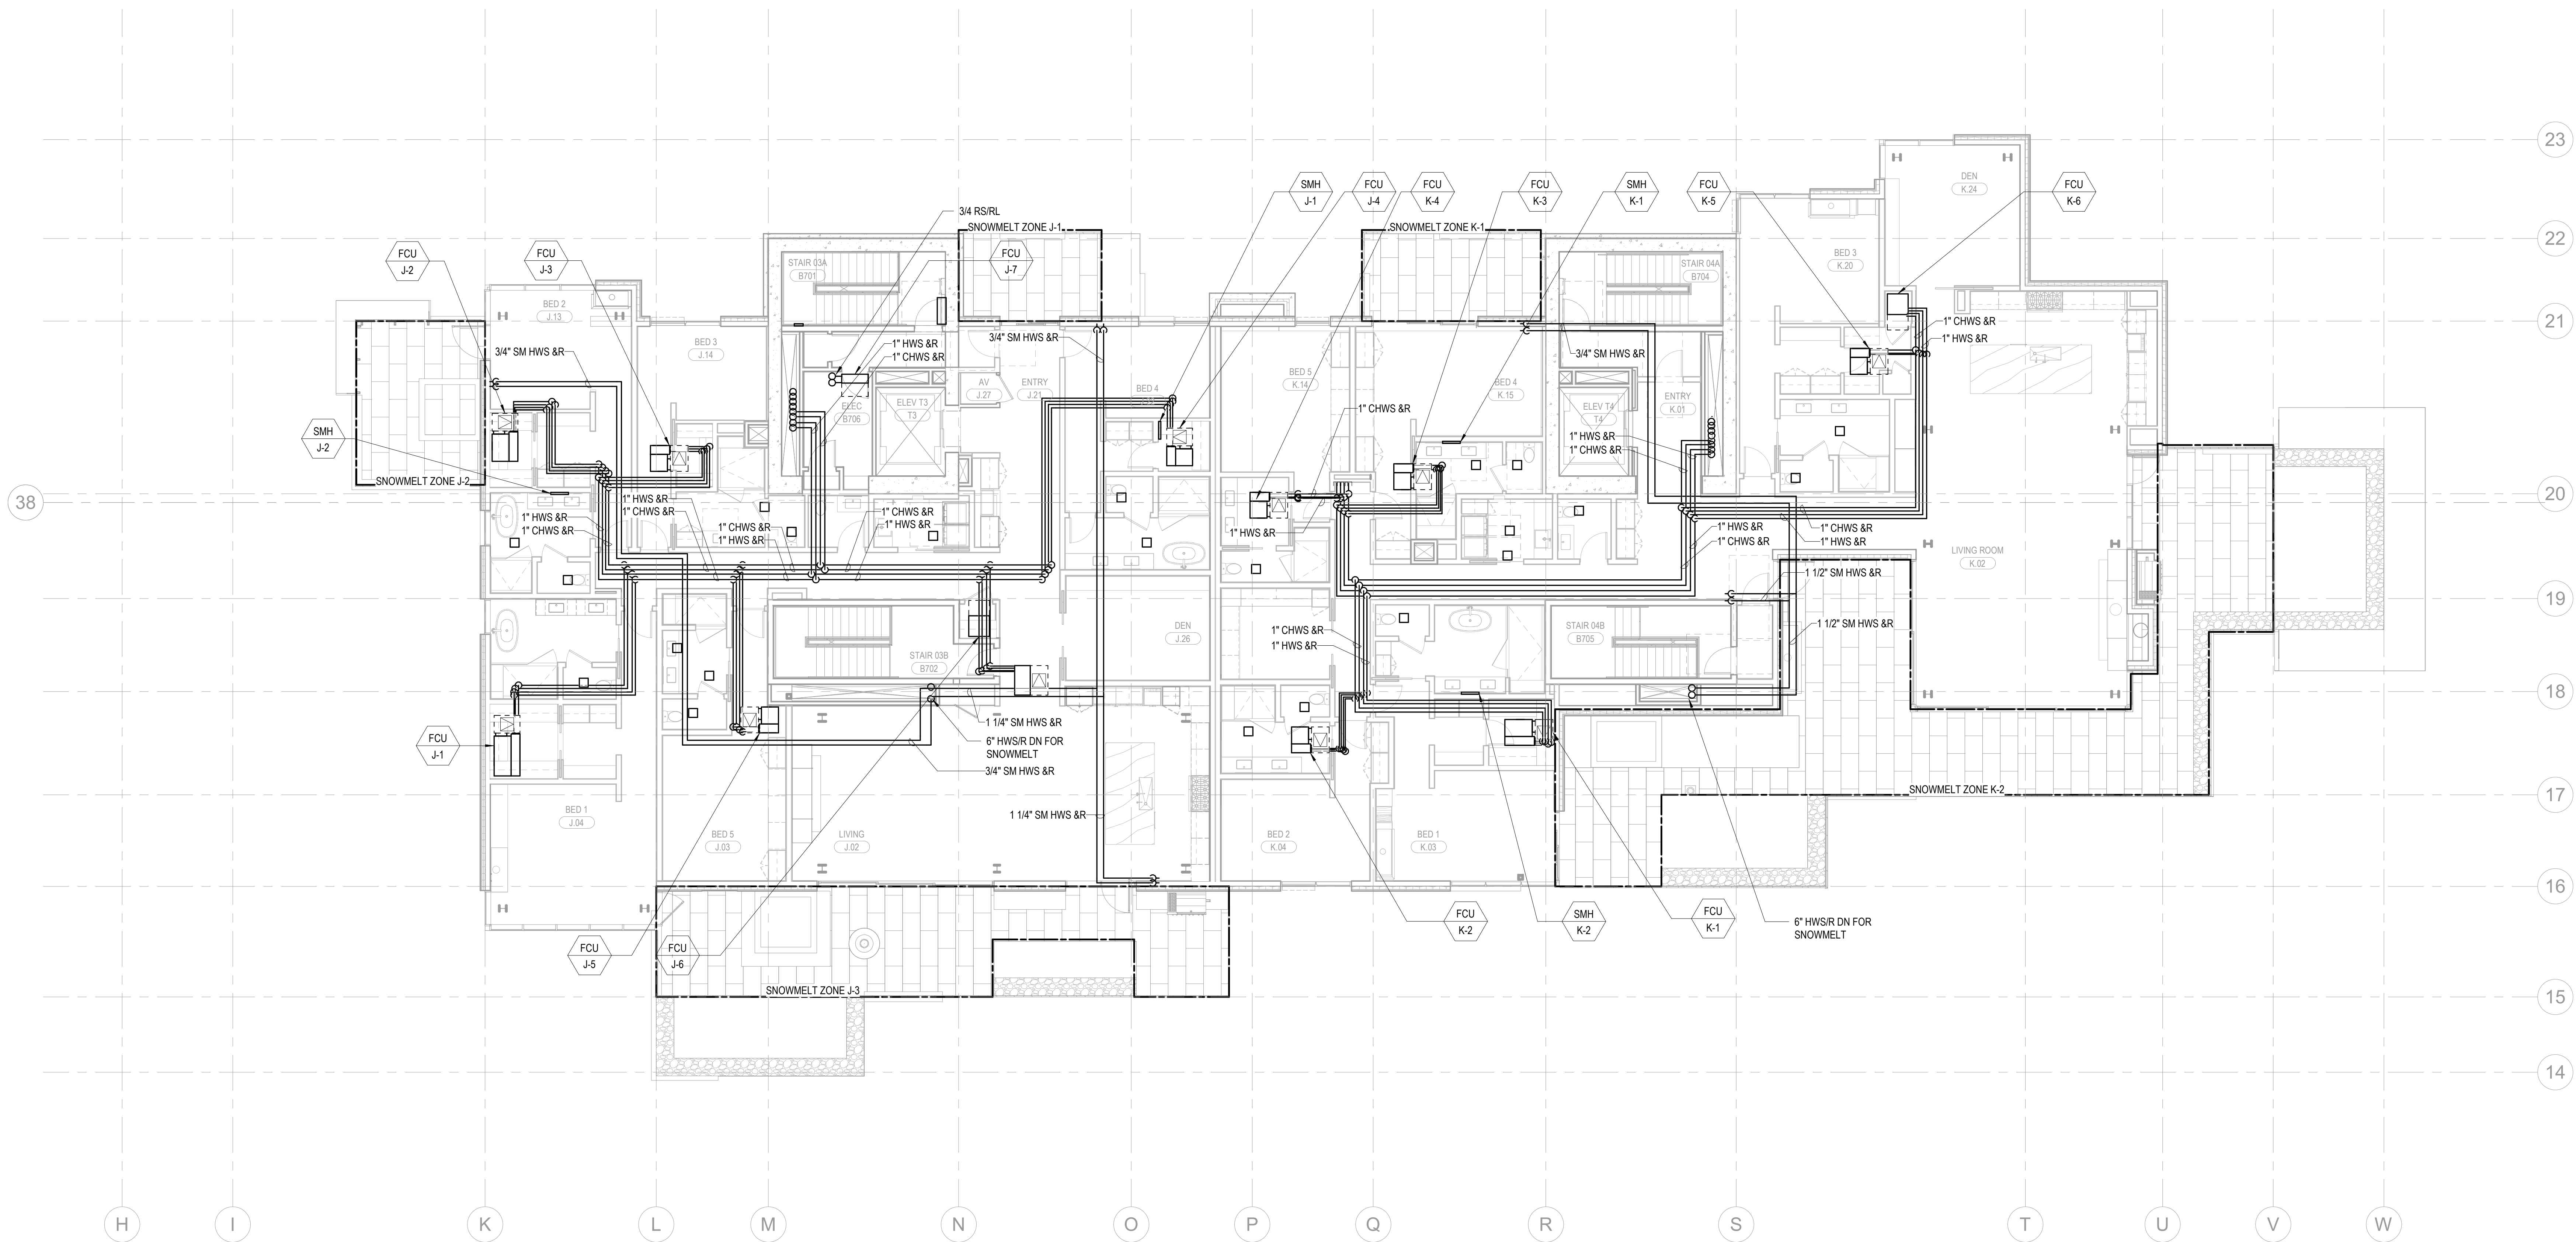

1 TOWER B - LEVEL 7 MECHANICAL PIPING PLAN
SCALE: 1/8" = 1'-0"

 
SCALE: 1/8" = 1'-0"



159 South Jackson St, Suite 600
Seattle, Washington 98104 USA
+1 206 624 5670 olsonkunding.com

Olson Kunding

SOMMET BLANC
9300 Marsac Ave (B2 East Parcel)
Park City, Utah 84060

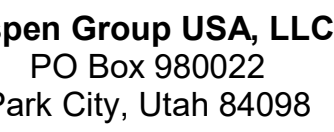

Edward H20
6 N University Ave, Suite 290
Provo, UT 84604

dscape Architects
G Design
 9 South High Tech Drive, Suite 10
 Layton, Utah 84047

Day Group
Mainelli Road
Middlebury, VT

Life Consultant
James
1st Avenue, Suite 200A
Seattle, WA 98104

Protection Engineer
Ken Hughes
Research Drive, Suite 305
Westborough, MA 01581

Michael Bates
15 North Creek Parkway, Suite 300
Bellevue, WA 98011

Structural Engineer
Knudson Klemencic Associates
115th Ave, Suite 3200
Seattle, WA 98101

9 SE MLK Blvd, Suite 210
Portland, Oregon 97219

H
1 N 34th St
Seattle, WA 98103

Feasibility Consultant
Radio Pacifica
4 Westlake Ave N, Suite F
Seattle, WA 98109

P Engineer
P USA
1 Fourth Ave., Suite 3100
Seattle, WA 98154

Principal architect _____

drawn by _____

checked by Checker
job no.

date 11/18/2022

Date _____

ISSUE FOR
CONSTRUCTION

11/10/2022

MECHANICAL PIPING

10. CONCLUSIONS

715.25.1X



SHEET NOTES:

A. ALL CHILLED WATER AND HOT WATER BRANCH PIPING SHALL BE SIZED AT 1" FOR ALL FAN COIL UNITS.



NUMBERED NOTES:

1 PROVIDE HEAT TRACE ON ALL EXPOSED PIPING. REFER TO ELECTRICAL DRAWINGS FOR 120/1 CONNECTION

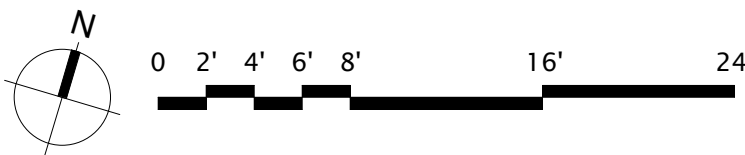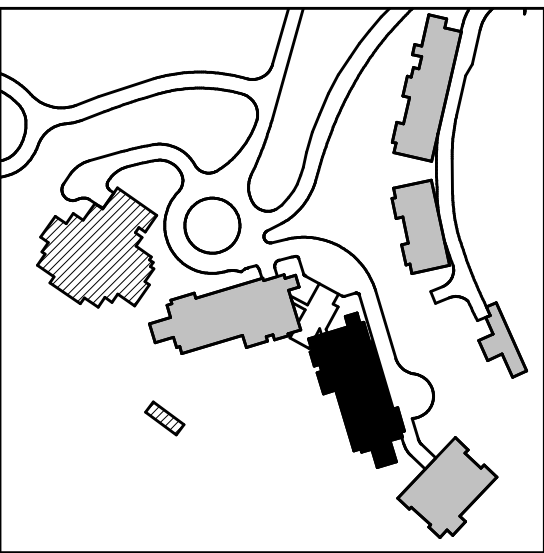

TOWER B - ROOF MECHANICAL PIPING PLAN

SCALE: 1/8" = 1'-0"