


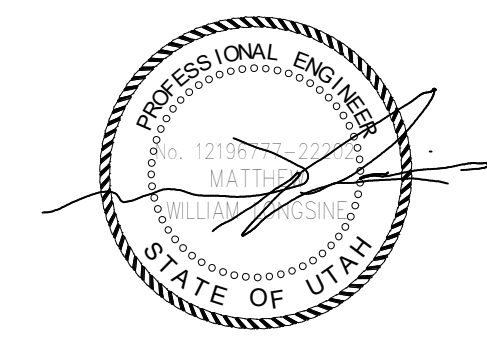

Reserved for permit stamp

100 South Jackson St., Suite 800  
Seattle, Washington 98104 USA  
+1 206 834 2670 [olsonkundig.com](mailto:olsonkundig.com)

Olson Kundig

project  
**SOMMET BLANC**  
8900 Marsac Ave (B2 East Parcel)  
Park City, Utah 84060



**Aspen Group USA, LLC**  
PO Box 980022  
Park City, Utah 84098

**Pool Consultant**  
**Cloward M20**  
2696 N University Ave., Suite 290  
Provo, UT 84604

**Landscape Architect**  
**EPG Design**  
6948 South High Tech Drive, Suite 100  
Midvale, Utah 84047

**Specifications Writer**  
**Friday Group**  
86 Mainelli Road  
Middlebury, VT

**Code Consultant**  
**Holmes**  
600 1st Avenue, Suite 200A  
Seattle, WA 98104

**Fire Protection Engineer**  
**Jensen Hughes**  
One Research Drive, Suite 305C  
Westborough, MA 01581

**Vertical Transportation Consultant**  
**Larch Bates**  
19515 North Creek Parkway, Suite 304  
Bothell, WA 98011

**Structural Engineer**  
**Magnusson Klemencic Associates**  
1301 5th Ave., Suite 3200  
Seattle, WA 98101

**Lighting Designer**  
**O-**  
1319 SE MLK Blvd, Suite 210  
Portland, Oregon 97219

**Building Envelope Consultant**  
**RDH**  
2101 N 34th St  
Seattle, WA 98103

**Accessibility Consultant**  
**Studio Pacifica**  
2144 Westlake Ave N, Suite F  
Seattle, WA 98109

**MEP Engineer**  
**WSP USA**  
1001 Fourth Ave., Suite 3100  
Seattle, WA 98154

principal architect \_\_\_\_\_  
project manager \_\_\_\_\_  
drawn by \_\_\_\_\_  
checked by \_\_\_\_\_  
job no. \_\_\_\_\_  
date 11/18/2022

revisions:  
\_\_\_\_\_  
\_\_\_\_\_  
no. date by

ISSUE FOR  
CONSTRUCTION  
11/18/2022


TOWER A - LVL B  
MECHANICAL PIPING  
PLAN

M3.2A.01



**SHEET NOTES:**

A. ALL CHILLED WATER AND HOT WATER BRANCH PIPING  
SHALL BE SIZED AT 1" FOR ALL FAN COIL UNITS.

**NUMBERED NOTES:**

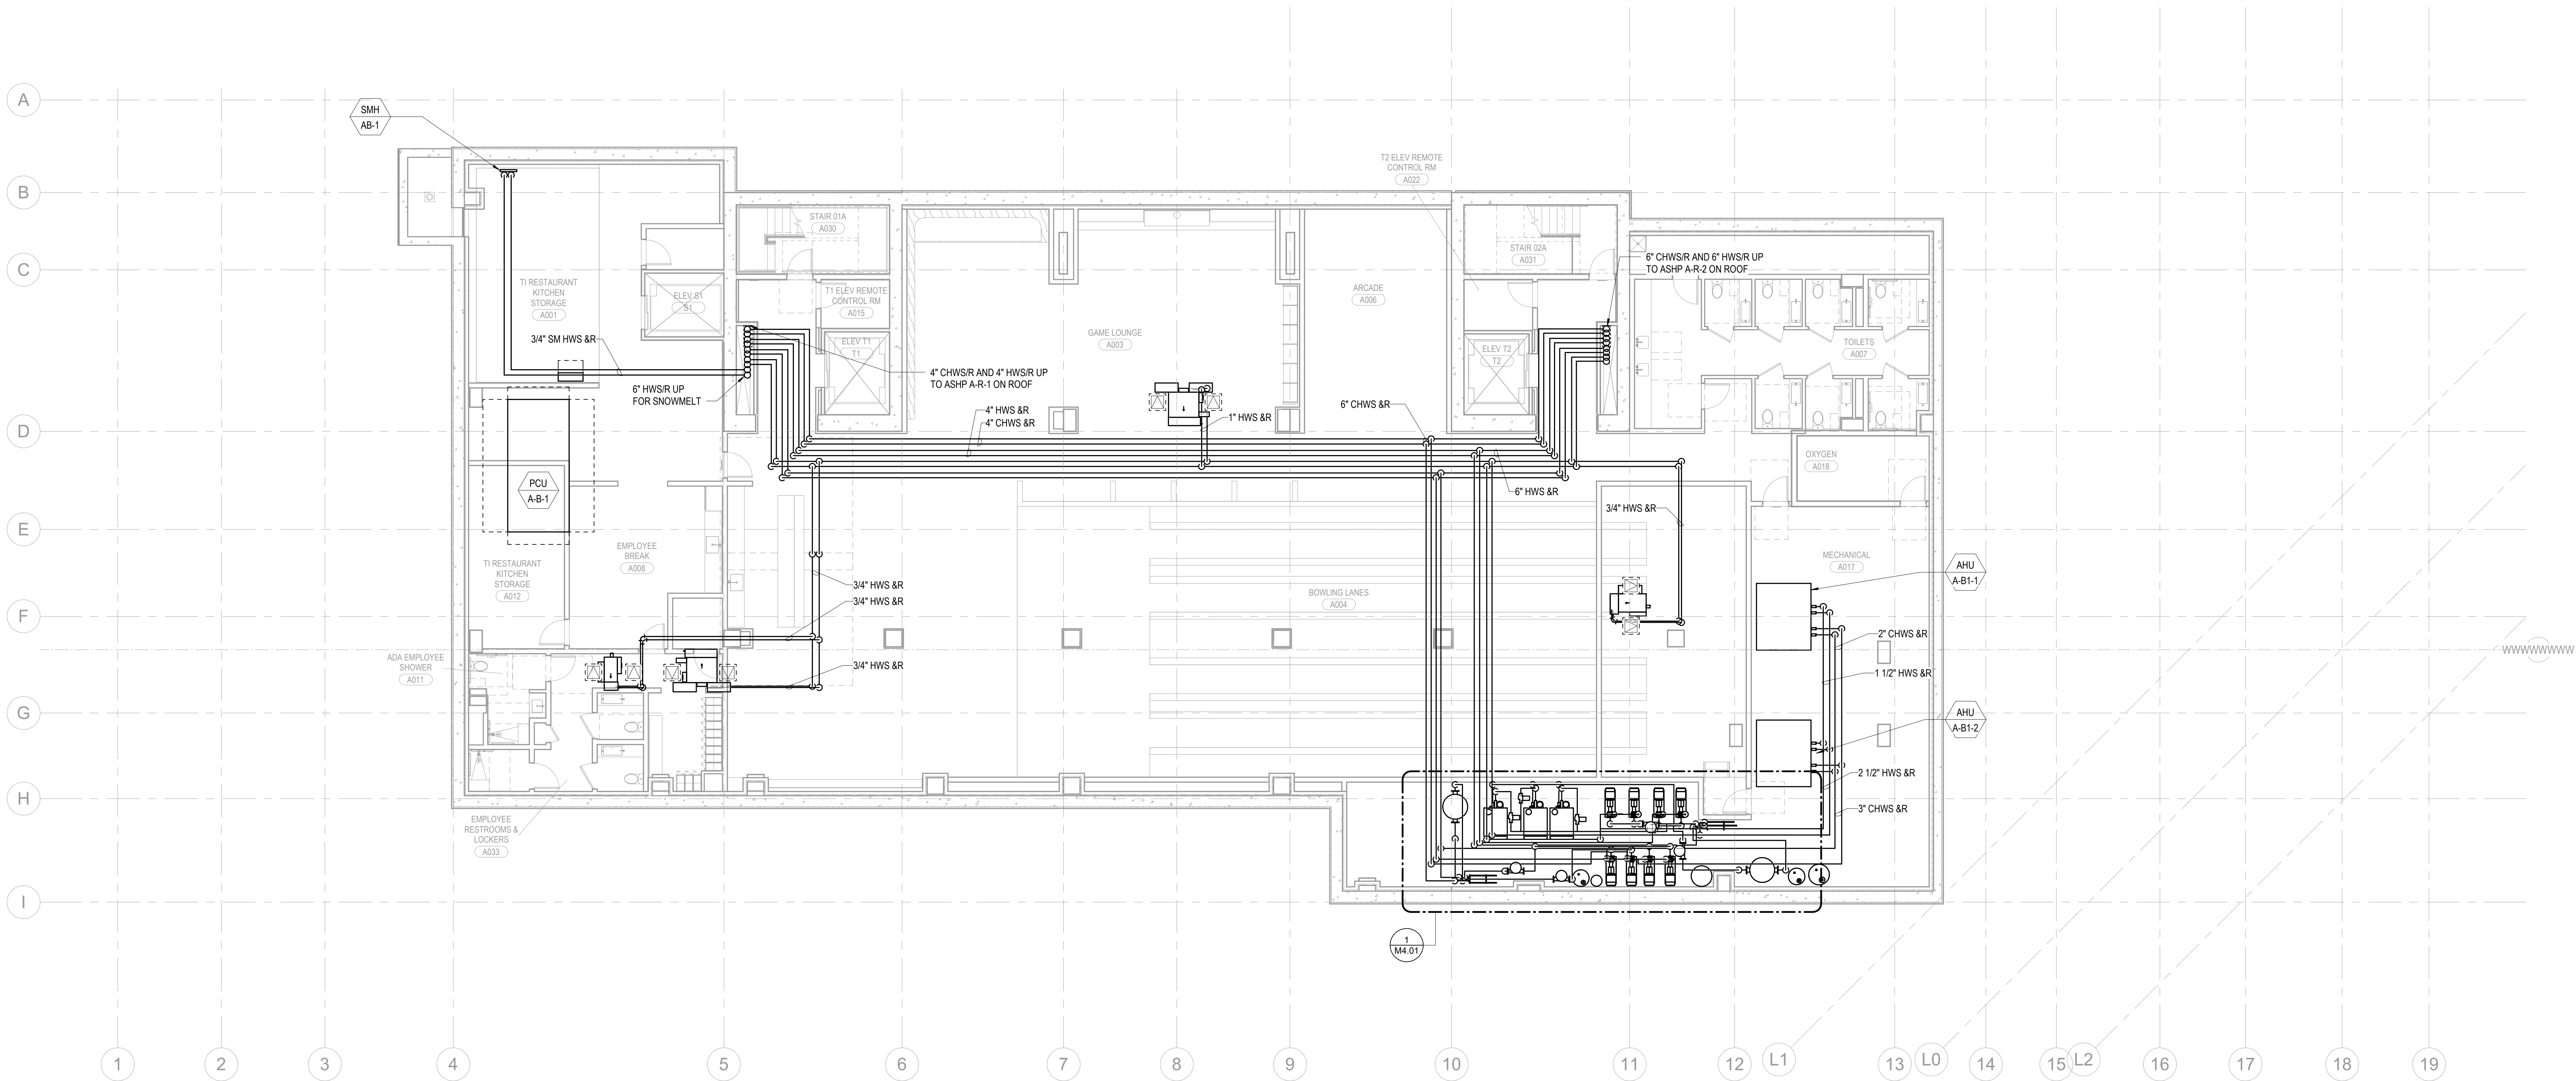


**1 TOWER A - LEVEL B MECHANICAL PIPING PLAN**  
SCALE: 1/8" = 1'-0"

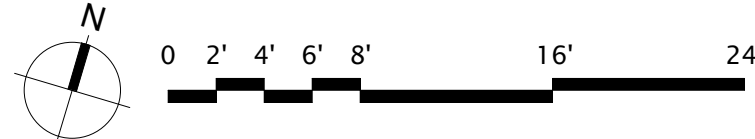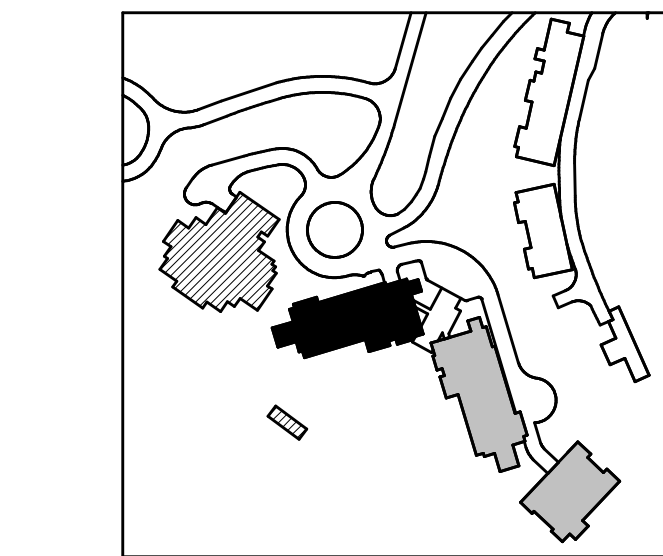




**SHEET NOTES:**

- A. ALL CHILLED WATER AND HOT WATER BRANCH PIPING SHALL BE SIZED AT 1" FOR ALL FAN COIL UNITS.

**NUMBERED NOTES:**

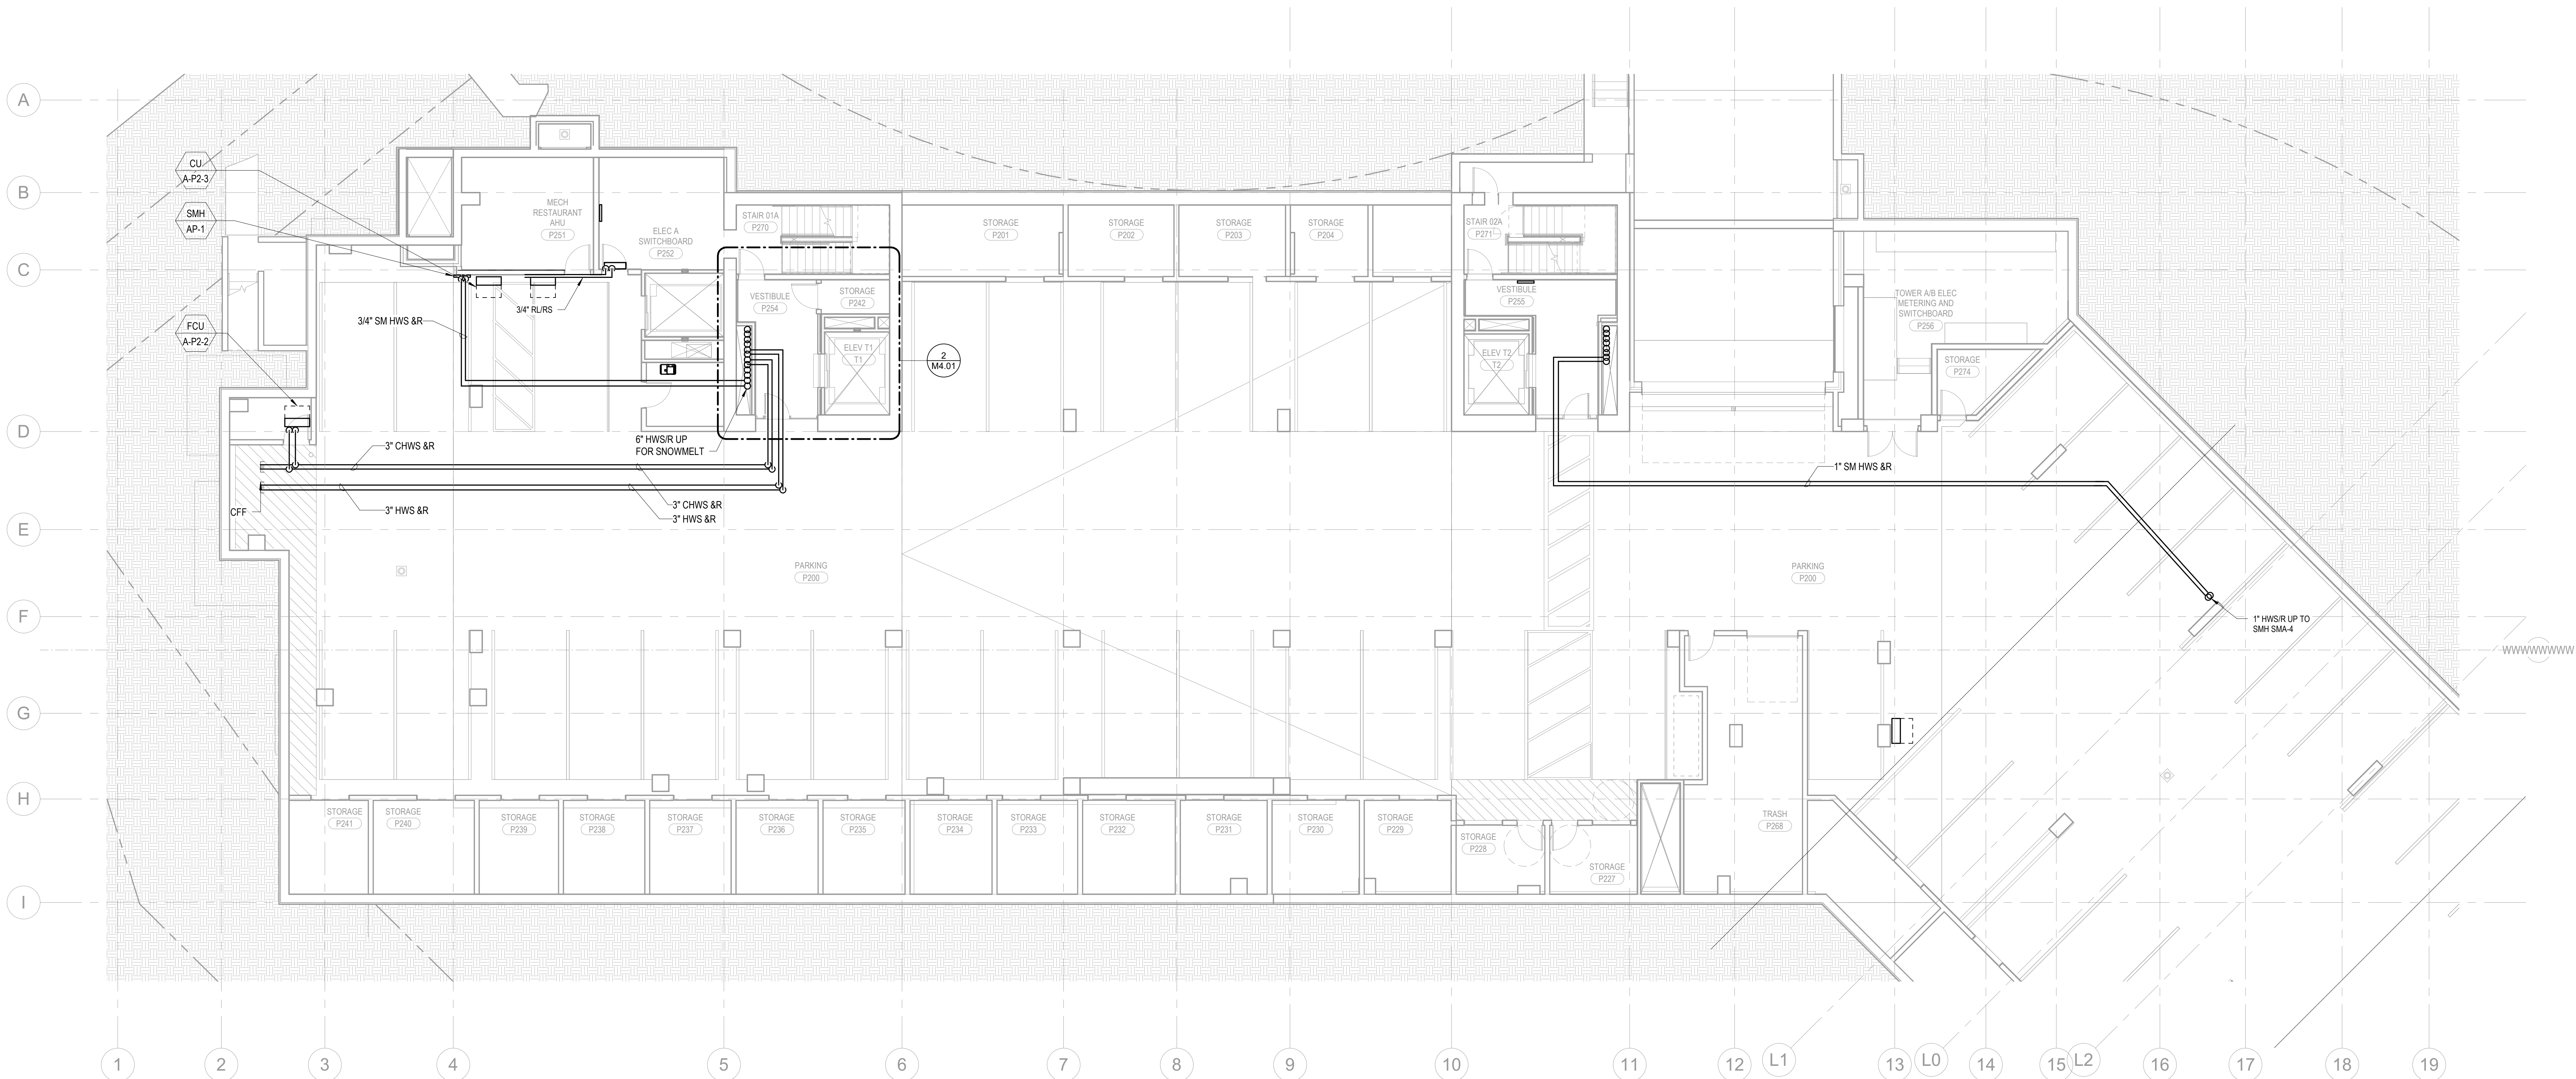

**1 TOWER A - PARKING LEVEL 2 MECHANICAL PIPING PLAN**  
SCALE: 1/8" = 1'-0"

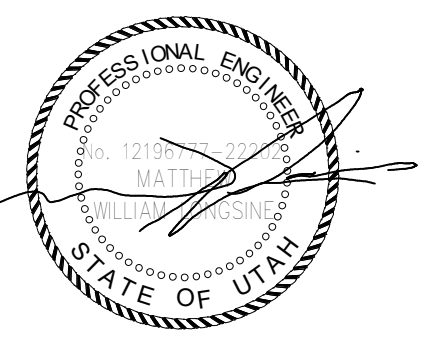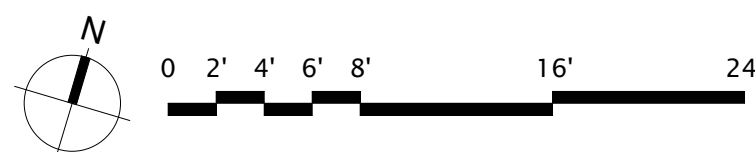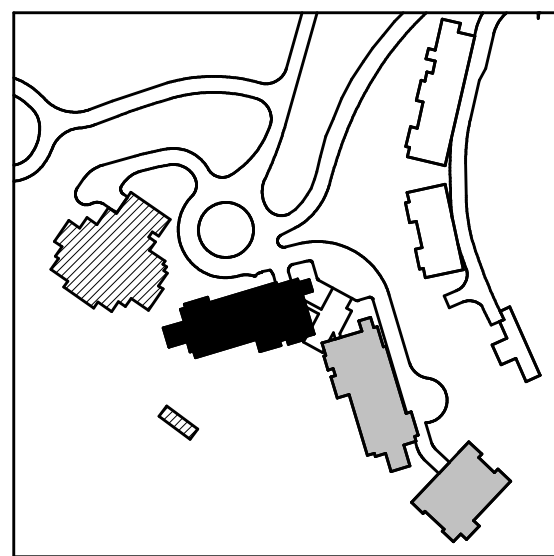

Reserved for permit stamp

100 South Jackson St., Suite 800  
Seattle, Washington 98104 USA  
+1 206 464 2670 [www.olsonkundig.com](http://www.olsonkundig.com)

**Olson Kundig**

project  
**SOMMET BLANC**  
9300 Marzac Ave (B2 East Parcel)  
Park City, Utah 84300



**Aspen Group USA, LLC**  
PO Box 980022  
Park City, Utah 84098

**Pool Consultant**  
**Cloward M20**  
2696 N University Ave., Suite 290  
Provo, UT 84604

**Landscape Architect**  
**EPG Design**  
6048 South High Tech Drive, Suite 100  
Midvale, Utah 84047

**Specifications Writer**  
**Friday Group**  
86 Marrett Road  
Middsbury, VT

**Code Consultant**  
**Holmes**  
600 1st Avenue, Suite 200A  
Seattle, WA 98104

**Fire Protection Engineer**  
**Jensen Hughes**  
One Research Drive, Suite 305C  
Westborough, MA 01581

**Vertical Transportation Consultant**  
**Larch Bates**  
19515 North Creek Parkway, Suite 304  
Bothell, WA 98011

**Structural Engineer**  
**Magnusson Klemencic Associates**  
1301 5th Ave., Suite 3200  
Seattle, WA 98101

**Lighting Designer**  
**O-**  
1319 SE MLK Blvd., Suite 210  
Portland, Oregon 97219

**Building Envelope Consultant**  
**RDH**  
2101 N 34th St  
Seattle, WA 98103

**Accessibility Consultant**  
**Studio Pacifica**  
2144 Westlake Ave N, Suite F  
Seattle, WA 98109

**MEP Engineer**  
**WSP USA**  
1001 Fourth Ave., Suite 3100  
Seattle, WA 98154

 
principal architect \_\_\_\_\_  
project manager \_\_\_\_\_  
drawn by \_\_\_\_\_  
checked by Checker  
job no. \_\_\_\_\_  
date 11/18/2022

revisions:  
\_\_\_\_\_  
\_\_\_\_\_  
no. date by

**ISSUE FOR CONSTRUCTION**  
11/18/2022

**TOWER A - LVL P2  
MECHANICAL PIPING  
PLAN**


**M3.2A.02**



159 South Jackson St, Suite 600  
Seattle, Washington 98104 USA  
+1 206 624 5670 [olsonkundig.com](mailto:olsonkundig.com)

Olson Kunding

**SOMMET BLANC**  
9300 Marsac Ave (B2 East Parcel)  
Park City, Utah 84060

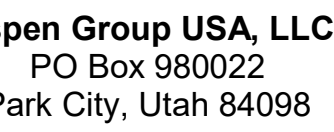

**Consultant**  
**Edward H2O**  
65 N University Ave, Suite 290  
Salt Lake City, UT 84604

**Escape Architectural Design**  
100 South High Tech Drive, Suite 100  
Salt Lake City, Utah 84047

**Day Group**  
Mainelli Road  
Whebury, VT

**Consultant**  
**nes**  
1st Avenue, Suite 200A  
le, WA 98104

**Protection Engineer**  
**Ken Hughes**  
Research Drive, Suite 305C  
Borough, MA 01581

**Michael Bates**  
15 North Creek Parkway, Suite 300  
Bellevue, WA 98011

**Structural Engineer**  
**Knusson Klemencic Associates**  
15th Ave, Suite 3200  
Seattle, WA 98101

9 SE MLK Blvd, Suite 21  
and, Oregon 97219

1 N 34th St  
Seattle, WA 98103

**Liability Consultant**  
**Radio Pacifica**  
1 Westlake Ave N, Suite F  
Seattle, WA 98109

Engineer  
USA  
Fourth Ave., Suite 3100  
Seattle, WA 98154

principal architect \_\_\_\_\_  
project manager \_\_\_\_\_  
drawn by \_\_\_\_\_  
checked by Checker  
job no. \_\_\_\_\_  
date 11/18/2022

visions:

---

---

---

---

---

---

---

---


---

---



ISSUE FOR  
CONSTRUCTION  
11/18/2022


POWER A - LVL 1  
MECHANICAL PIPING  
PLAN

M3.2A.11

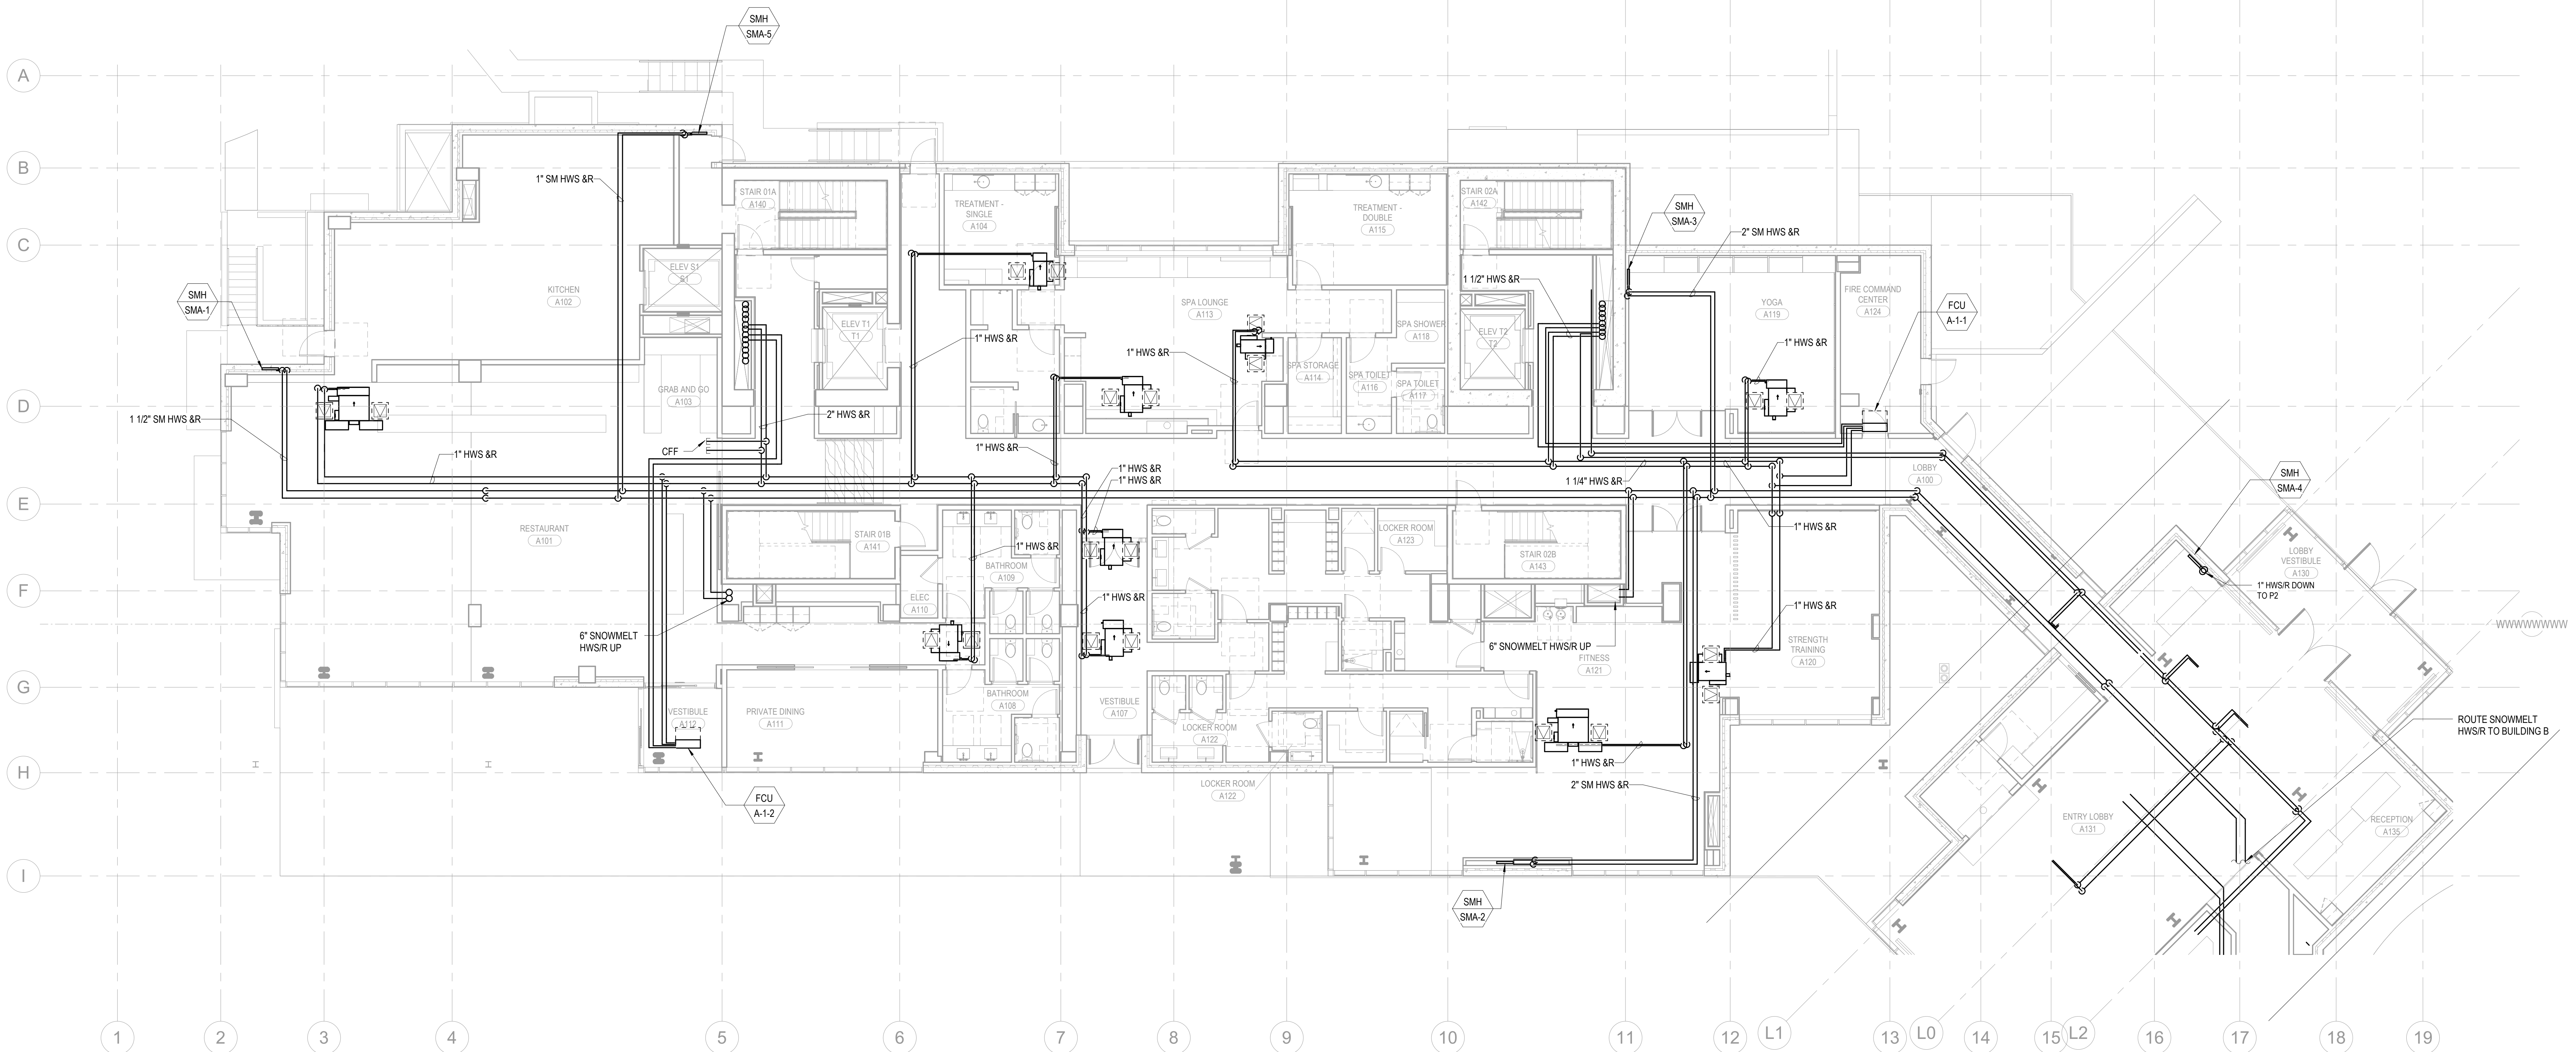

1 TOWER A - LEVEL 1 MECHANICAL PIPING PLAN  
SCALE: 1/8" = 1'-0"

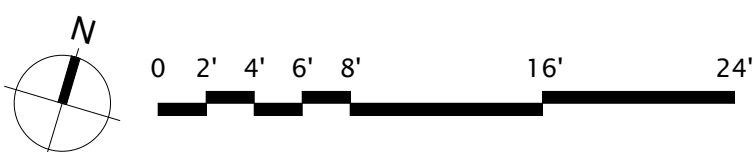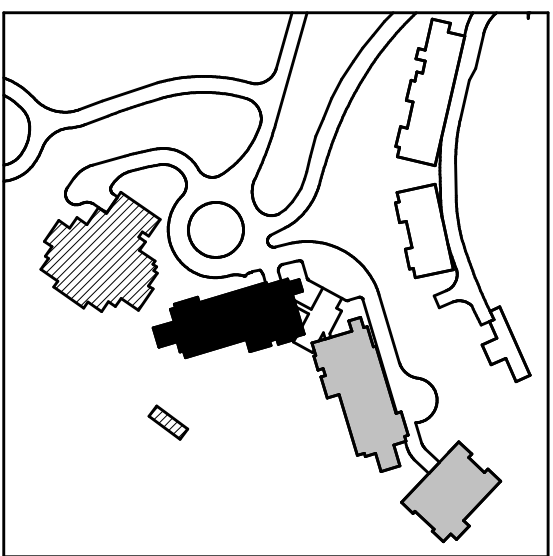

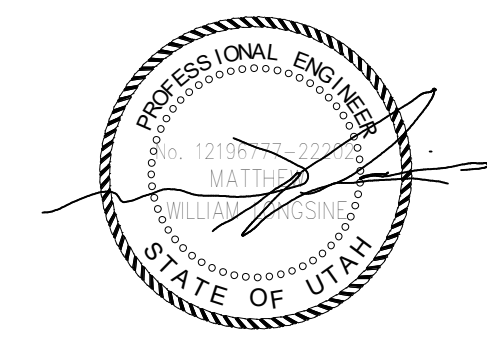

Reserved for permit stamp

100 South Jackson St., Suite 600  
Seattle, Washington 98104 USA  
+1 206 834 2670 olsonkundig.com

Olson Kundig

project  
SOMMET BLANC  
9300 Marsac Ave (B2 East Parcel)  
Park City, Utah 84060



Aspen Group USA, LLC  
PO Box 980022  
Park City, Utah 84098

Pool Consultant  
Cloward M20  
2696 N University Ave, Suite 290  
Provo, UT 84604

Landscape Architect  
EPG Design  
6948 South High Tech Drive, Suite 100  
Midvale, Utah 84047

Specifications Writer  
Friday Group  
86 Marrett Road  
Middletown, VT

Code Consultant  
Holmes  
600 1st Avenue, Suite 200A  
Seattle, WA 98104

Fire Protection Engineer  
Jensen Hughes  
One Research Drive, Suite 305C  
Westborough, MA 01581

Vertical Transportation Consultant  
Larch Bates  
19515 North Creek Parkway, Suite 304  
Bothell, WA 98011

Structural Engineer  
Magnusson Klemencic Associates  
1301 5th Ave, Suite 3200  
Seattle, WA 98101

Lighting Designer  
Q  
1319 SE MLK Blvd, Suite 210  
Portland, Oregon 97219

Building Envelope Consultant  
RDH  
2101 N 34th St  
Seattle, WA 98103

Accessibility Consultant  
Studio Pacifica  
2144 Westlake Ave N, Suite F  
Seattle, WA 98109

MEP Engineer  
WSP USA  
1001 Fourth Ave., Suite 3100  
Seattle, WA 98154

principal architect \_\_\_\_\_  
project manager \_\_\_\_\_  
drawn by \_\_\_\_\_  
checked by \_\_\_\_\_  
job no. \_\_\_\_\_  
date 11/18/2022

revisions:  
\_\_\_\_\_  
\_\_\_\_\_  
no. date by

ISSUE FOR  
CONSTRUCTION  
11/18/2022


TOWER A - LVL 2  
MECHANICAL PIPING  
PLAN

M3.2A.12



**SHEET NOTES:**


A ALL CHILLED WATER AND HOT WATER BRANCH PIPING  
SHALL BE SIZED AT 1" FOR ALL FAN COIL UNITS.

**NUMBERED NOTES:**

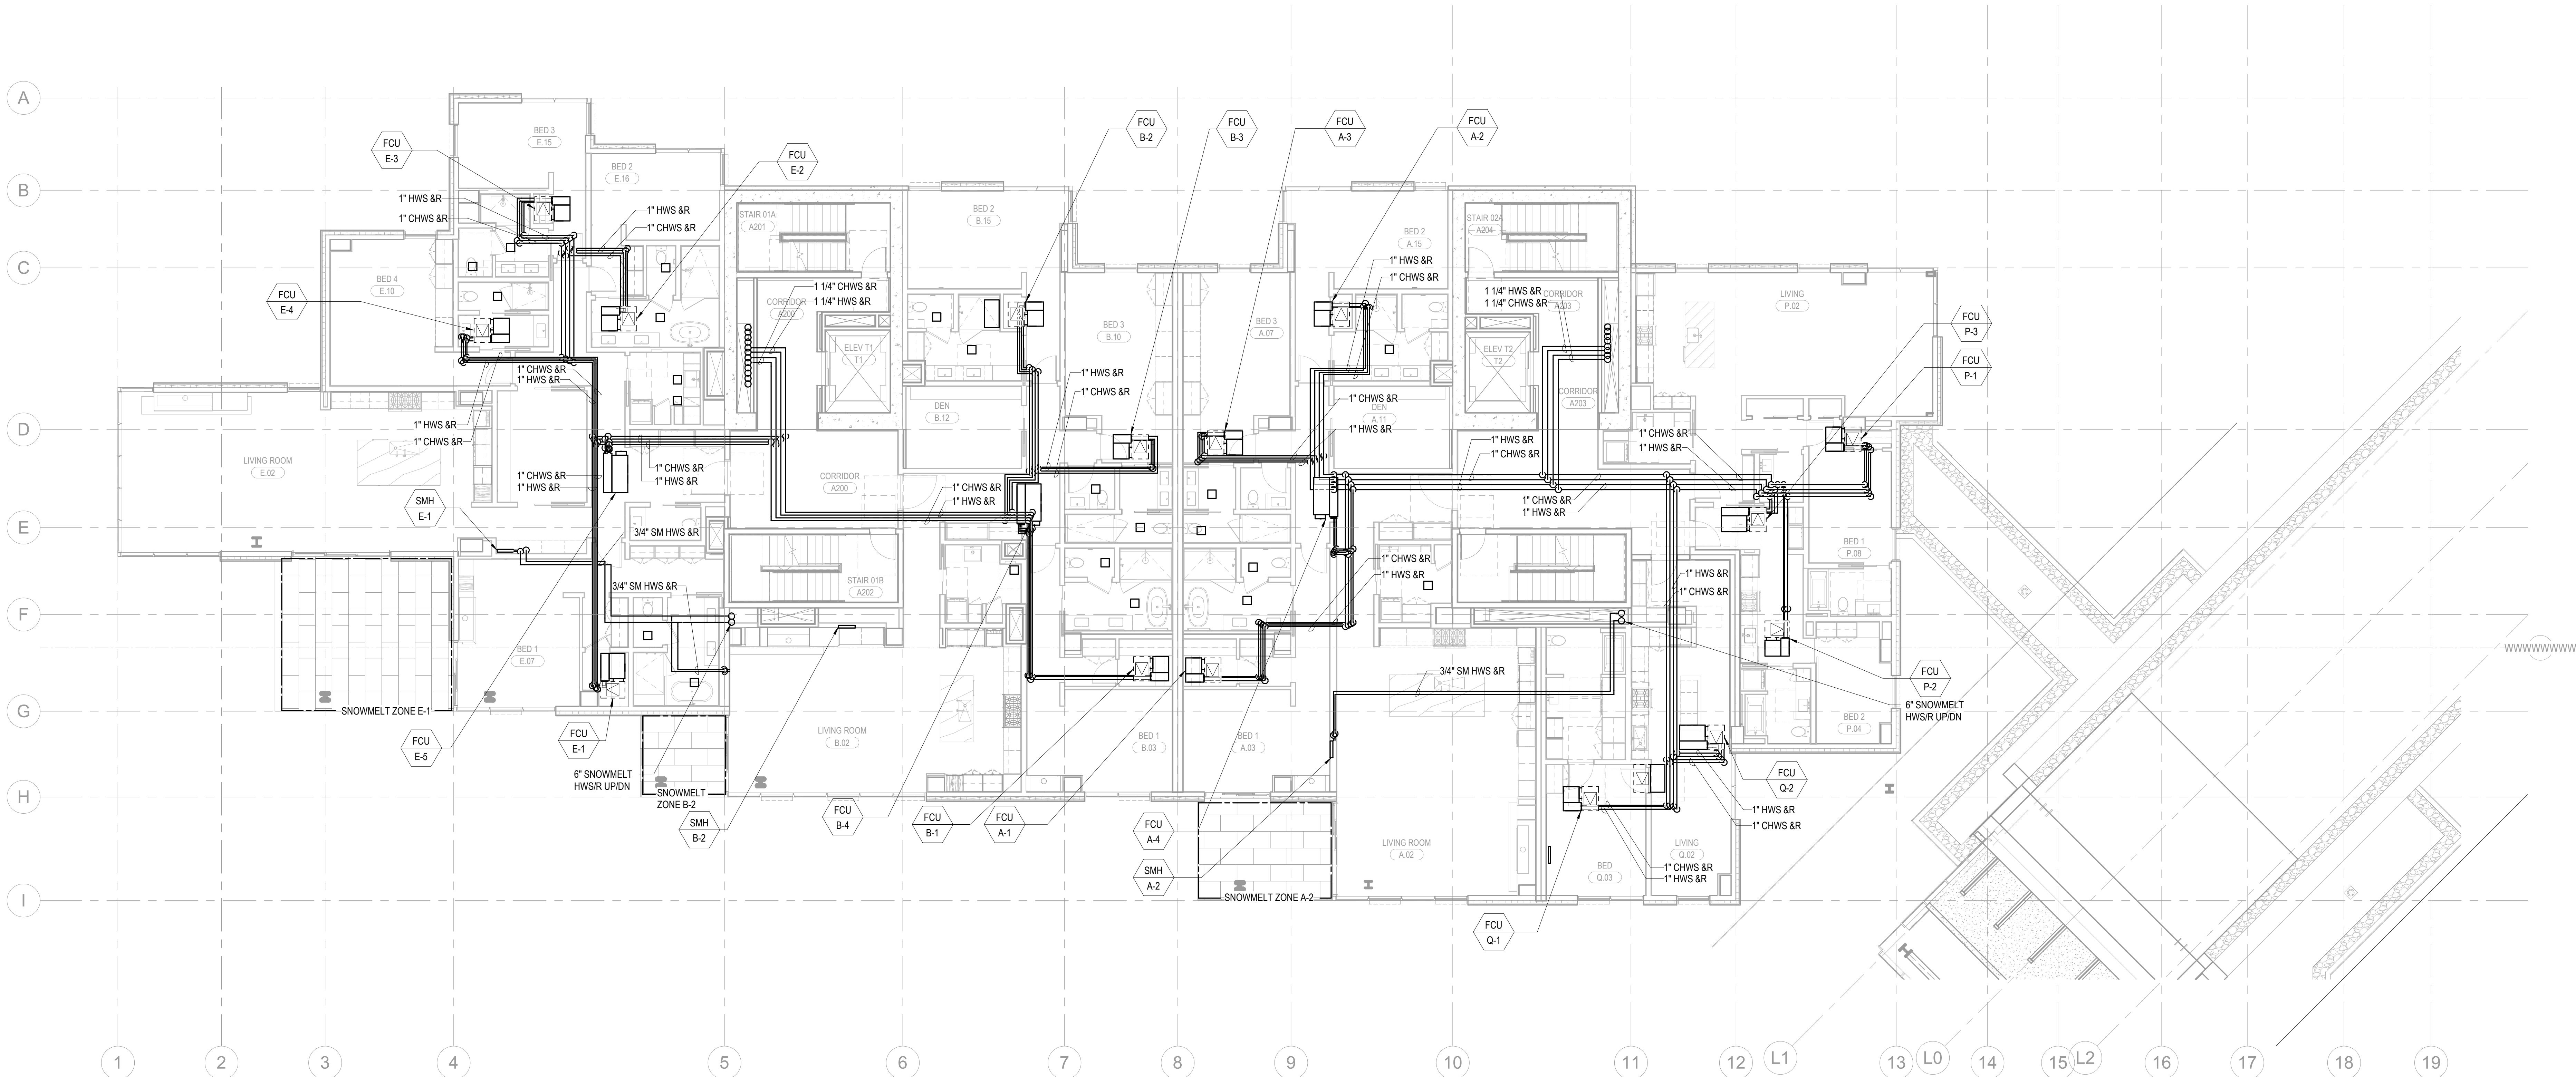

 
1 TOWER A - LEVEL 2 MECHANICAL PIPING PLAN  
SCALE: 1/8" = 1'-0"

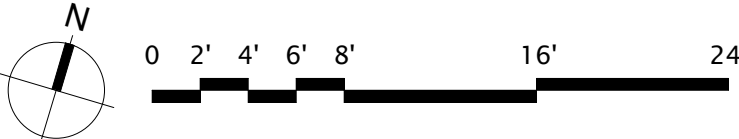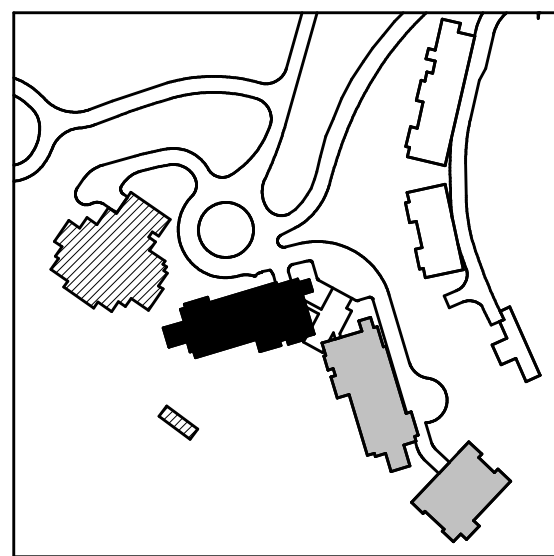



Olson Kundig

**SUMMEI BLANC**  
9300 Marsac Ave (B2 East Parcel)  
Park City, Utah 84060

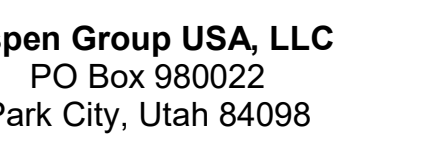

**USA**  
Fourth Ave., Suite 3100  
Seattle, WA 98154

[illegible]

ISSUE FOR  
CONSTRUCTION

11/18/2022

POWER A - LVL 3  
MECHANICAL PIPING  
PLAN


M3.2A.13


**NUMBERED NOTES:**

 - A. ALL CHILLED WATER AND HOT WATER BRANCH PIPING SHALL BE SIZED AT 1" FOR ALL FAN COIL UNITS.




1 TOWER A - LEVEL 3 MECHANICAL PIPING PLAN  
SCALE: 1/8" = 1'-0"

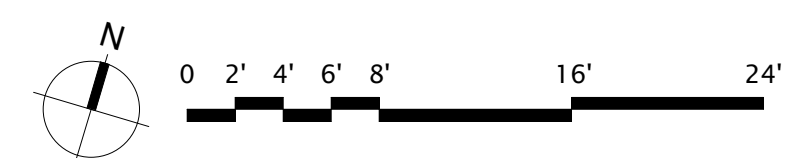



Olson Kundig

**SOMME I BLANC**  
9300 Marsac Ave (B2 East Parcel)  
Park City, Utah 84060

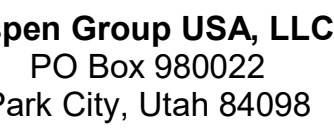



USA  
Fourth Ave., Suite 3100  
Seattle, WA 98154

11/18/2022


M3.2A.14

A. ALL CHILLED WATER AND HOT WATER BRANCH PIPING SHALL BE SIZED AT 1" FOR ALL FAN COIL UNITS.


**NUMBERED NOTES:**

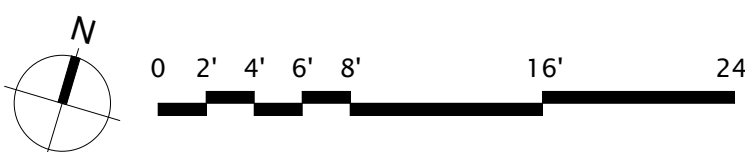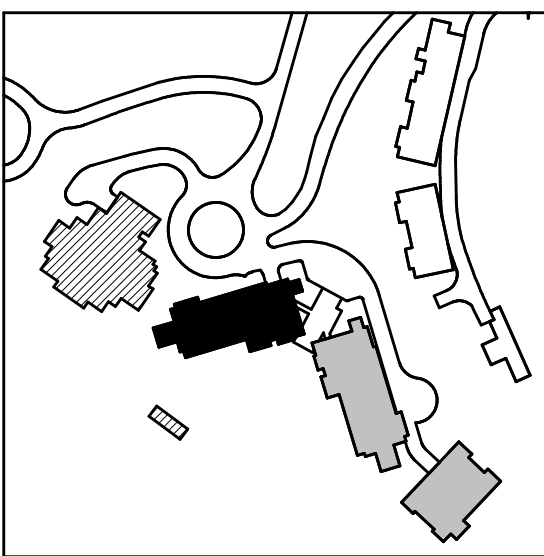

 1 TOWER A - LEVEL 4 MECHANICAL PIPING PLAN  
SCALE: 1/8" = 1'-0"



project: **SOMMET BLANC**  
9300 Marsac Ave (B2 East Parcel)  
Park City, Utah 84060

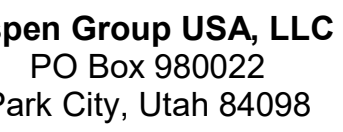

**Engineer**  
**USA**  
Fourth Ave., Suite 3100  
Seattle, WA 98154

ins:

date b

ISSUE FOR  
CONSTRUCTION  
11/18/2022


POWER A - LVL 5  
MECHANICAL PIPING  
PLAN


M3.2A.15

A. ALL CHILLED WATER AND HOT WATER BRANCH PIPING SHALL BE SIZED AT 1" FOR ALL FAN COIL UNITS.



SCALE: 1/8" = 1'-0"

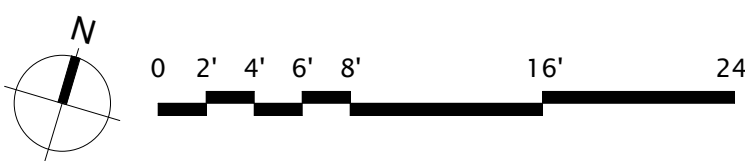

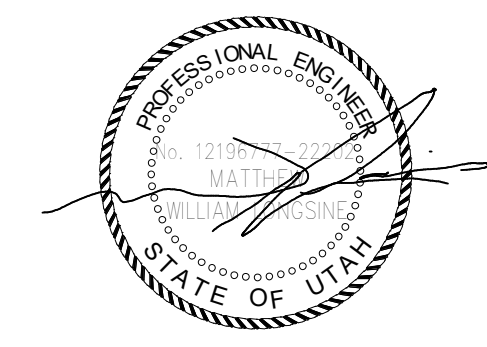

Reserved for permit stamp

100 South Jackson St., Suite 600  
Seattle, Washington 98104 USA  
+1 206 834 2670 olsonkundig.com

Olson Kundig

project  
SOMMET BLANC  
8900 Marzac Ave (B2 East Parcel)  
Park City, Utah 84060



Aspen Group USA, LLC  
PO Box 980022  
Park City, Utah 84098

Pool Consultant  
Cloward H2O  
2696 N University Ave., Suite 290  
Provo, UT 84604

Landscape Architect  
EPG Design  
6048 South High Tech Drive, Suite 100  
Midvale, Utah 84047

Specifications Writer  
Friday Group  
86 Mainelli Road  
Middlebury, VT

Code Consultant  
Holmes  
600 1st Avenue, Suite 200A  
Seattle, WA 98104

Fire Protection Engineer  
Jensen Hughes  
One Research Drive, Suite 305C  
Westborough, MA 01581

Vertical Transportation Consultant  
Larch Bates  
19515 North Creek Parkway, Suite 304  
Bothell, WA 98011

Structural Engineer  
Magnusson Klemencic Associates  
1301 5th Ave., Suite 3200  
Seattle, WA 98101

Lighting Designer  
O-  
1319 SE MLK Blvd, Suite 210  
Portland, Oregon 97219

Building Envelope Consultant  
RDH  
2101 N 34th St  
Seattle, WA 98103

Accessibility Consultant  
Studio Pacifica  
2144 Westlake Ave N, Suite F  
Seattle, WA 98109

MEP Engineer  
WSP USA  
1001 Fourth Ave., Suite 3100  
Seattle, WA 98154

principal architect \_\_\_\_\_  
project manager \_\_\_\_\_  
drawn by \_\_\_\_\_  
checked by \_\_\_\_\_  
job no. \_\_\_\_\_  
date 11/18/2022

revisions:  
\_\_\_\_\_  
\_\_\_\_\_  
no. date by

ISSUE FOR  
CONSTRUCTION  
11/18/2022


TOWER A - LVL 6  
MECHANICAL PIPING  
PLAN

M3.2A.16



### SHEET NOTES:


- A. ALL CHILLED WATER AND HOT WATER BRANCH PIPING  
SHALL BE SIZED AT 1" FOR ALL FAN COIL UNITS.

### NUMBERED NOTES:

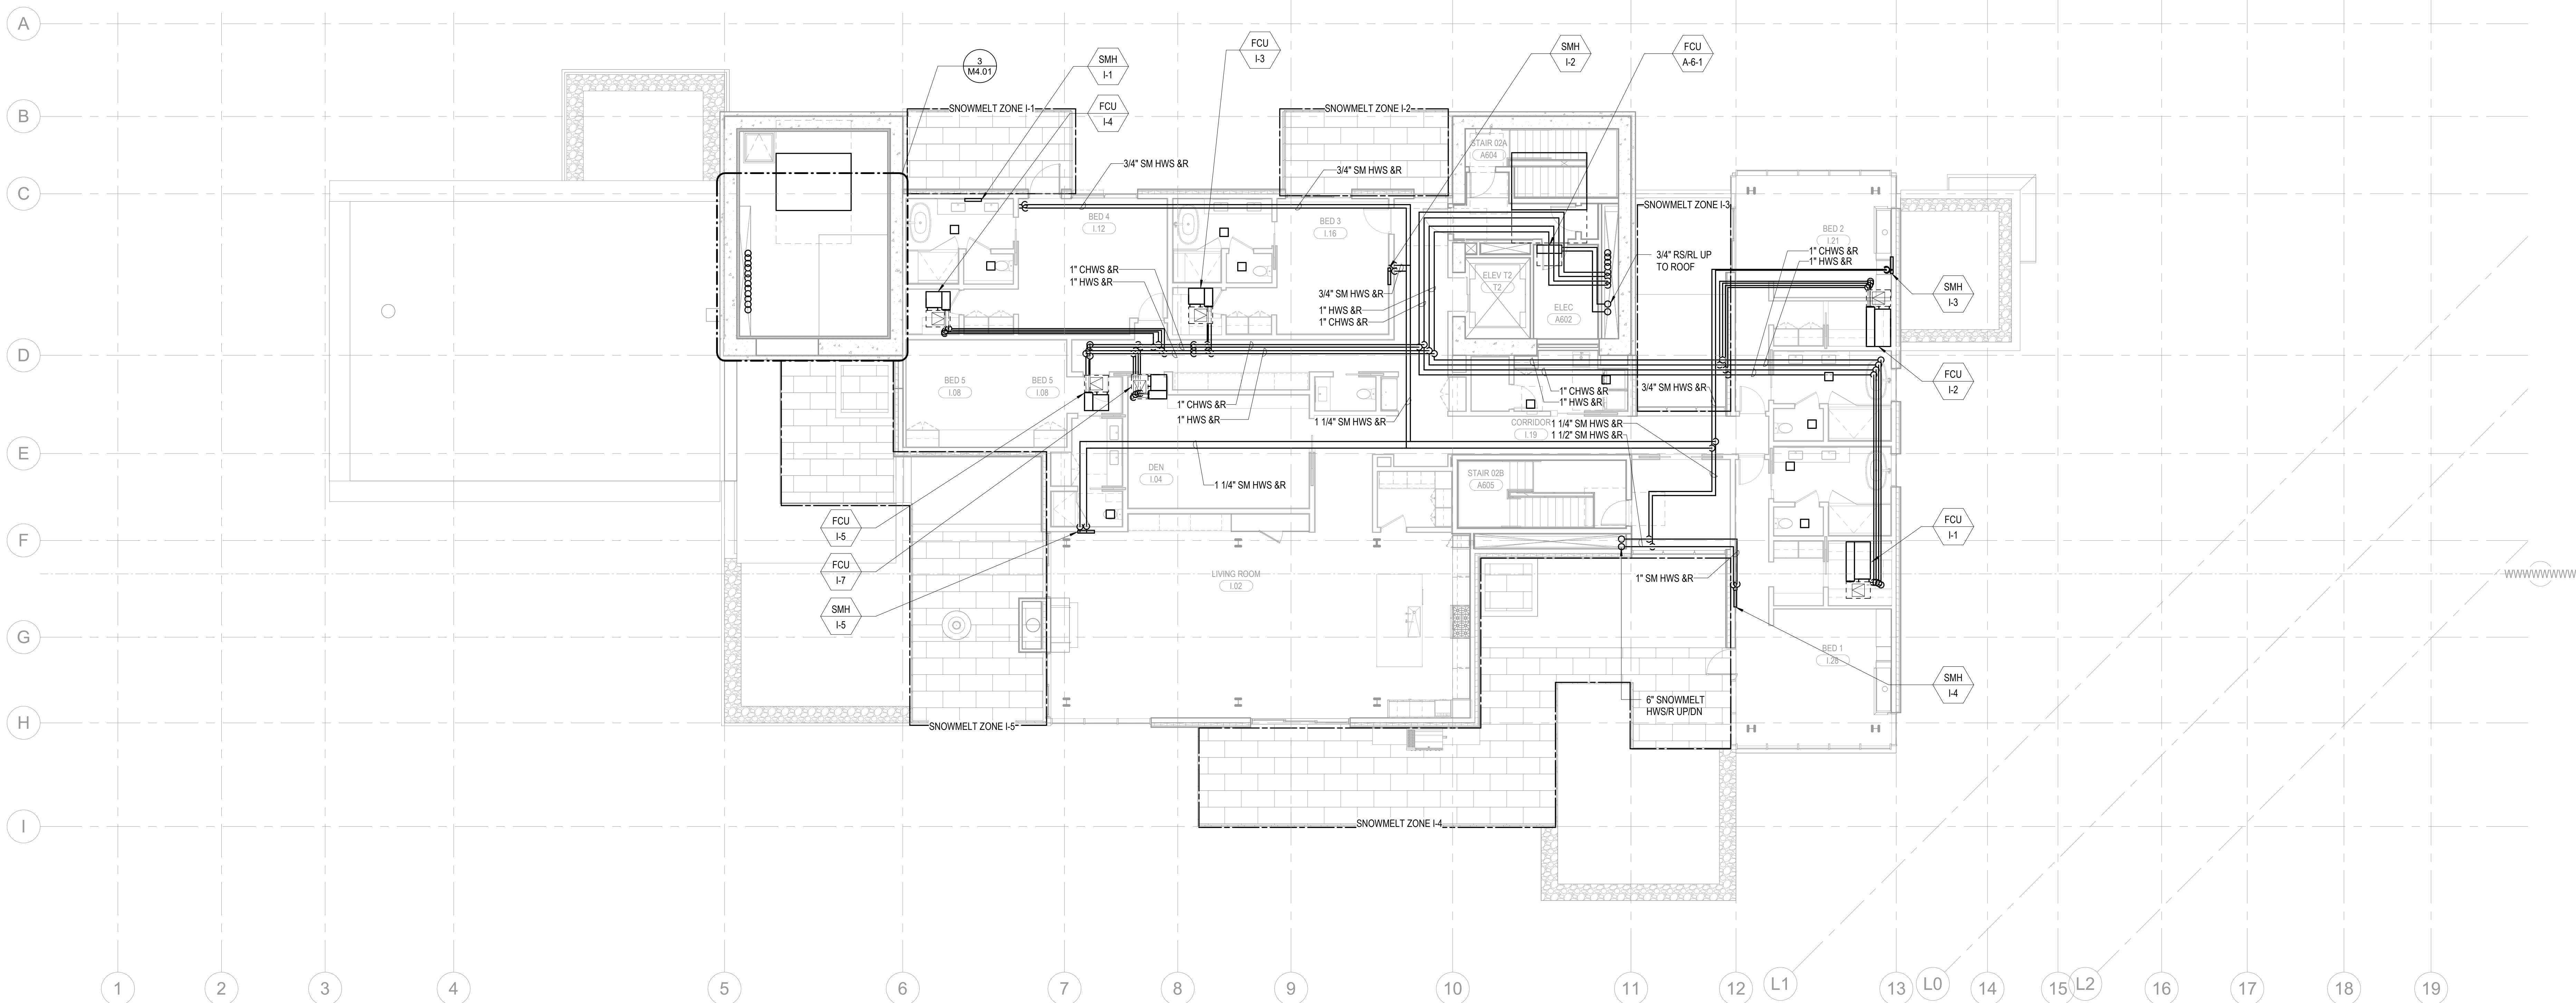

 1 TOWER A - LEVEL 6 MECHANICAL PIPING PLAN  
SCALE: 1/8" = 1'-0"

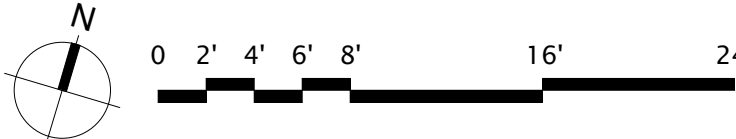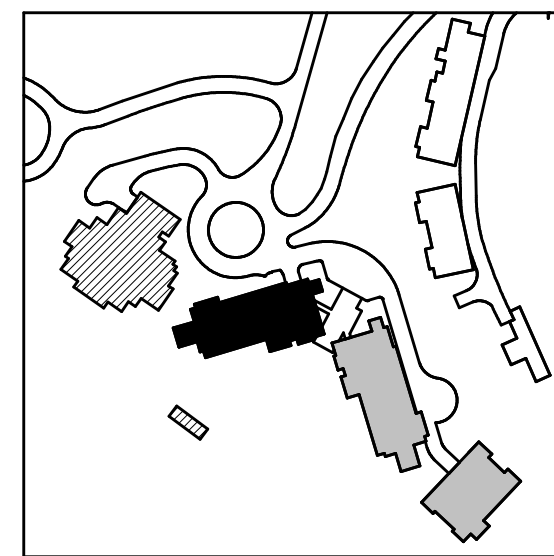



159 South Jackson St, Suite 600  
Seattle, Washington 98104 USA  
+1 206 624 5670 [olsonlundig.com](mailto:olsonlundig.com)

Olson Kundig

**SOMMET BLANC**  
9300 Marsac Ave (B2 East Parcel)  
Park City, Utah 84060



**Open Group USA, LLC**  
PO Box 980022  
Park City, Utah 84098

**Howard H20**  
96 N University Ave, Suite 290  
Provo, UT 84604

**Landscaped Architectural  
G Design**  
49 South High Tech Drive, Suite 100  
Pleasantville, Utah 84047

**Day Group**  
Mainelli Road  
Middlebury, VT

de Consultant  
lmes  
0 1st Avenue, Suite 200A  
attle, WA 98104

**Protection Engineer**  
**ensen Hughes**  
Research Drive, Suite 305C  
Westborough, MA 01581

**Arch Bates**  
515 North Creek Parkway, Suite 300  
Bellingham, WA 98011

**Structural Engineer**  
**Ingrosson Klemencic Associates**  
101 5th Ave, Suite 3200  
Seattle, WA 98101

**Lighting Designer**  
19 SE MLK Blvd, Suite 210  
Portland, Oregon 97219

**Building Envelope Consultant**  
**ENH**  
 101 N 34th St  
 Seattle, WA 98103

**Accessibility Consultant**  
**Radio Pacifica**  
44 Westlake Ave N, Suite F  
Seattle, WA 98109

PE Engineer  
SP USA  
01 Fourth Ave., Suite 3100  
Seattle, WA 98154

principal architect \_\_\_\_\_  
project manager \_\_\_\_\_  
drawn by \_\_\_\_\_  
checked by Checker  
job no. \_\_\_\_\_  
date 11/18/2022

sions:

---

---

| date | b |
|------|---|
|------|---|

ISSUE FOR  
CONSTRUCTION  
11/18/2022

POWER A - ROOF  
MECHANICAL PIPING  
PLAN



M3.2A.R

**SHEET NOTES:**

- A. ALL CHILLED WATER AND HOT WATER BRANCH PIPING SHALL BE SIZED AT 1" FOR ALL FAN COIL UNITS.



## NUMBERED NOTES

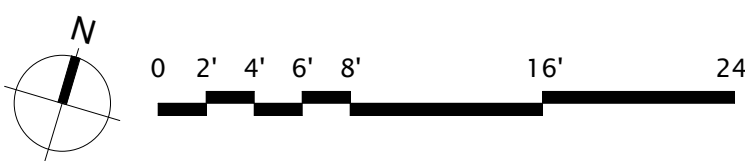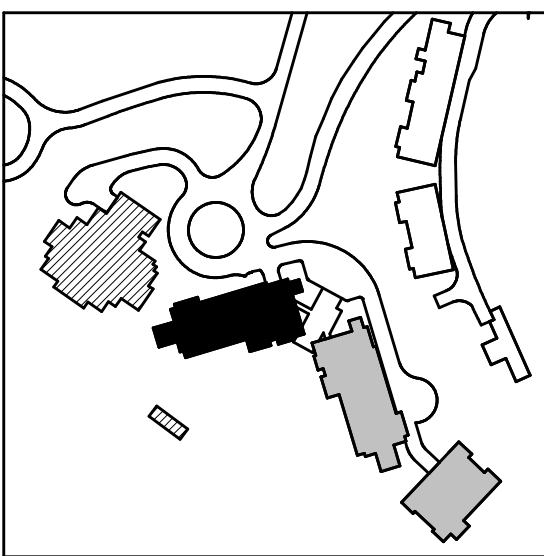

1 TOWER A - ROOF MECHANICAL PIPING PLAN  
SCALE: 1/8" = 1'-0"

SCALE: 1/8" = 1'-0"