


Olson Kundig

project: **SOMMET BLANC**
3300 Marsac Ave (B2 East Parcel)
Bark City, Utah 84050

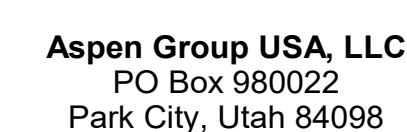

principal architect _____
project manager _____
drawn by _____
checked by Checker
job no. _____
date 5/17/2024



revisions:

no.	date	by
-----	------	----

IFC Set 2 of 3
5/17/2024

TOWER B - LVL 1
ELECTRICAL POWER
PLAN

 E2.2B.11

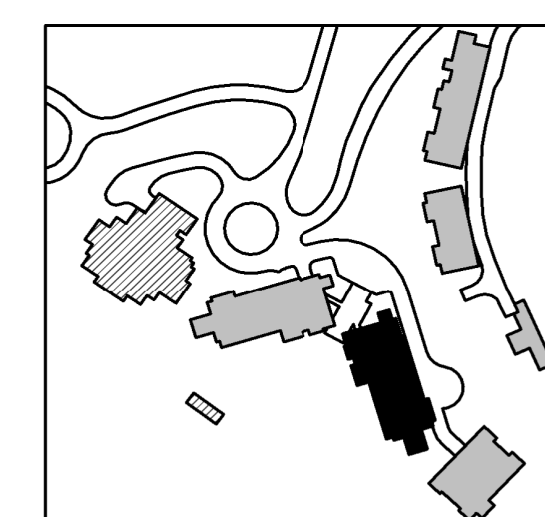

2 TOWER B - LEVEL 1 ELECTRICAL ROOM
SCALE: 1/4" = 1'-0"

1 TOWER B - LEVEL 1 ELECTRICAL POWER
SCALE: 1/8" = 1'-0"

SHEET NOTES:

- D. DRAWINGS ARE INTENDED TO SHOW GENERAL ARRANGEMENT, DESIGN, AND EXTENT OF WORK AND ARE DIAGRAMMATIC. DRAWINGS ARE NOT INTENDED TO SHOW EXACT LOCATIONS EXCEPT WHERE DIMENSIONS ARE SHOWN. ELECTRICAL WORK IS SHOWN ON THE BASIS OF THE STANDARD PRACTICES OF THE ELECTRICAL INDUSTRY.
- E. WORK VERIFY MEASUREMENTS PERTAINING THEREIN AND ASSUME RESPONSIBILITY THEREFOR. ANY SUBSTANTIAL DIFFERENCES BETWEEN DRAWINGS AND CONDITIONS OF THE PROJECT SHALL BE SUBMITTED TO THE ARCHITECT FOR REVIEW AND APPROVAL BEFORE PROCEEDING WITH WORK.
- F. WORK SHALL INCLUDE INSTALLATION OF CONDUIT, MATERIALS, AND EQUIPMENT TO INSTALL A COMPLETE ELECTRICAL SYSTEM AS INDICATED ON THE DRAWINGS AND AS SPECIFIED. REFER TO ELECTRICAL CONNECTION SCHEDULE FOR CONDUIT, WIRING, COPD, AND OTHER DOCUMENTS.
- G. VERIFY EQUIPMENT SIZES AND POWER REQUIREMENTS FOR EQUIPMENT PROVIDED BY OTHERS.
- H. ELECTRICAL CONDITIONS IN FINISHED SPACES SHALL BE CONCEALED. COORDINATE WITH OTHER TRADES AND USE CHASES AND CEILING SPACES LOCATIONS OF ELECTRICAL JUNCTION BOXES IN FINISHED SPACES SHALL BE APPROVED BY ARCHITECT PRIOR TO ROUGH-IN.
- I. REFER TO MECHANICAL AND PLUMBING PLANS FOR EXACT LOCATION OF HVAC/PLUMBING EQUIPMENT.
- J. PROVIDE CONDUIT, WIRE AND J-BOXES FOR ROUTING SHOWN. QUANTITY AND SIZES OF J-BOXES TO BE DETERMINED BY CONTRACTOR.
- K. CONTRACTOR SHALL BE RESPONSIBLE FOR REPAIR OF ANY ELECTRICAL CIRCUITS DAMAGED BY CONSTRUCTION. REPAIRS SHALL BE REPAIRED IMMEDIATELY. THERE SHALL BE NO DISRUPTION OF SERVICE OUTSIDE OF CONSTRUCTION ZONE AREA. PROVIDE TAMPER PROOF RECEPTACLES IN RESIDENTIAL UNITS AND ALL COMMON AREAS.

NUMBERED NOTES:

- 1 GENERATOR REMOTE FUEL FILL STATION IS TO BE SUPPLIED BY ELECTRICAL CONTRACTOR AS PART OF THE GENERATOR PACKAGE, AND BE INSTALLED BY MECHANICAL CONTRACTOR. ELECTRICAL CONTRACTOR TO COORDINATE WITH MECHANICAL CONTRACTOR TO CONSTRUCTION.