


Seattle, Washington 98104 USA
+1 206 624 5670 olav@kurdig.com

project: **SOMMET BLANC**
3300 Marsac Ave (B2 East Parcel)

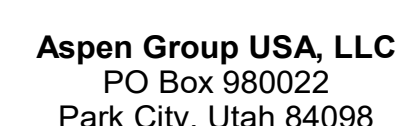

MEP Engineer
WSP USA
1001 Fourth Ave., Suite 3100
Seattle, WA 98154

revisions:

no.	date	t
-----	------	---

E2.2C.14

DRAWINGS ARE INTENDED TO SHOW GENERAL ARRANGEMENT, DESIGN, AND EXTENT OF WORK AND ARE DIAGNOSTIC. DRAWINGS ARE NOT INTENDED TO SHOW EXACT LOCATIONS WHERE THERE ARE DIMENSIONS ARE SHOWN. ELECTRICAL WORK IS SHOWN ON DRAWINGS FOR INFORMATION PURPOSES ONLY. CONTRACTOR SHALL BE RESPONSIBLE FOR VERIFYING MEASUREMENTS PERTAINING THERETO AND ASSUME RESPONSIBILITY THEREFOR. ANY SUBSTANTIAL DIFFERENCES BETWEEN DRAWINGS AND CONDITIONS IN THE FIELD SHALL BE SUBMITTED TO THE ARCHITECT FOR REVIEW AND APPROVAL PRIOR TO PROCEEDING WITH WORK.

WORK PERFORMED INCLUDES INSTALLATION OF MATERIALS, AND EQUIPMENT REQUIRED TO INSTALL ELECTRICAL SYSTEM AS INDICATED ON THESE DRAWINGS AND AS SPECIFIC REFER TO ELECTRICAL CONNECTION SCHEDULE FOR CONDUIT, WIRING, COPD, ETC.

D. VERIFY EQUIPMENT SIZES AND POWER REQUIREMENTS FOR EQUIPMENT PROVIDED BY OTHERS.

E. VERIFY ALL CONDITIONS IN FINISHED SPACES SHALL BE CONCEALED COORDINATE WITH OTHER TRADES AND USE CHASES AND CEILING SPACES. LOCATIONS OF ELECTRICAL JUNCTION BOXES IN FINISHED SPACES SHALL BE APPROVED BY ARCHITECT PRIOR TO ROOFING.


F. REFER TO MECHANICAL AND PLUMBING PLANS FOR EXACT LOCATION OF HVAC/PLUMBING EQUIPMENT.

G. CONTRACTOR SHALL WIRE AND J-BOXES FOR CRUISING SHOW, QUANTITY AND SIZES OF J-BOXES TO BE DETERMINED BY CONTRACTOR.

H. CONTRACTOR SHALL BE RESPONSIBLE FOR REPAIR OF ANY ELECTRICAL CIRCUITS THAT ARE DESTROYED OR DAMAGED DURING THE WORK. REPAIRS WILL BE REQUIRED IMMEDIATELY. THERE WILL BE NO DISRUPTION OF SERVICE OUTSIDE OF CONSTRUCTION ZONE/AREA. PROVIDE TAMPER PROOF RECEPTACLES IN RESIDENTIAL UNITS AND ALL COMMON AREAS.

1 BRANCH CIRCUITS IN EACH DWELLING UNIT SHALL SUPPLY ONLY LOADS WITHIN
THAT DWELLING UNIT OR LOADS ASSOCIATED ONLY WITH THAT DWELLING UNIT.

2 FEEDERS TO A DWELLING UNIT SHALL NOT ENTER AND BE ROUTED THOUGH
ANOTHER DWELLING UNIT.

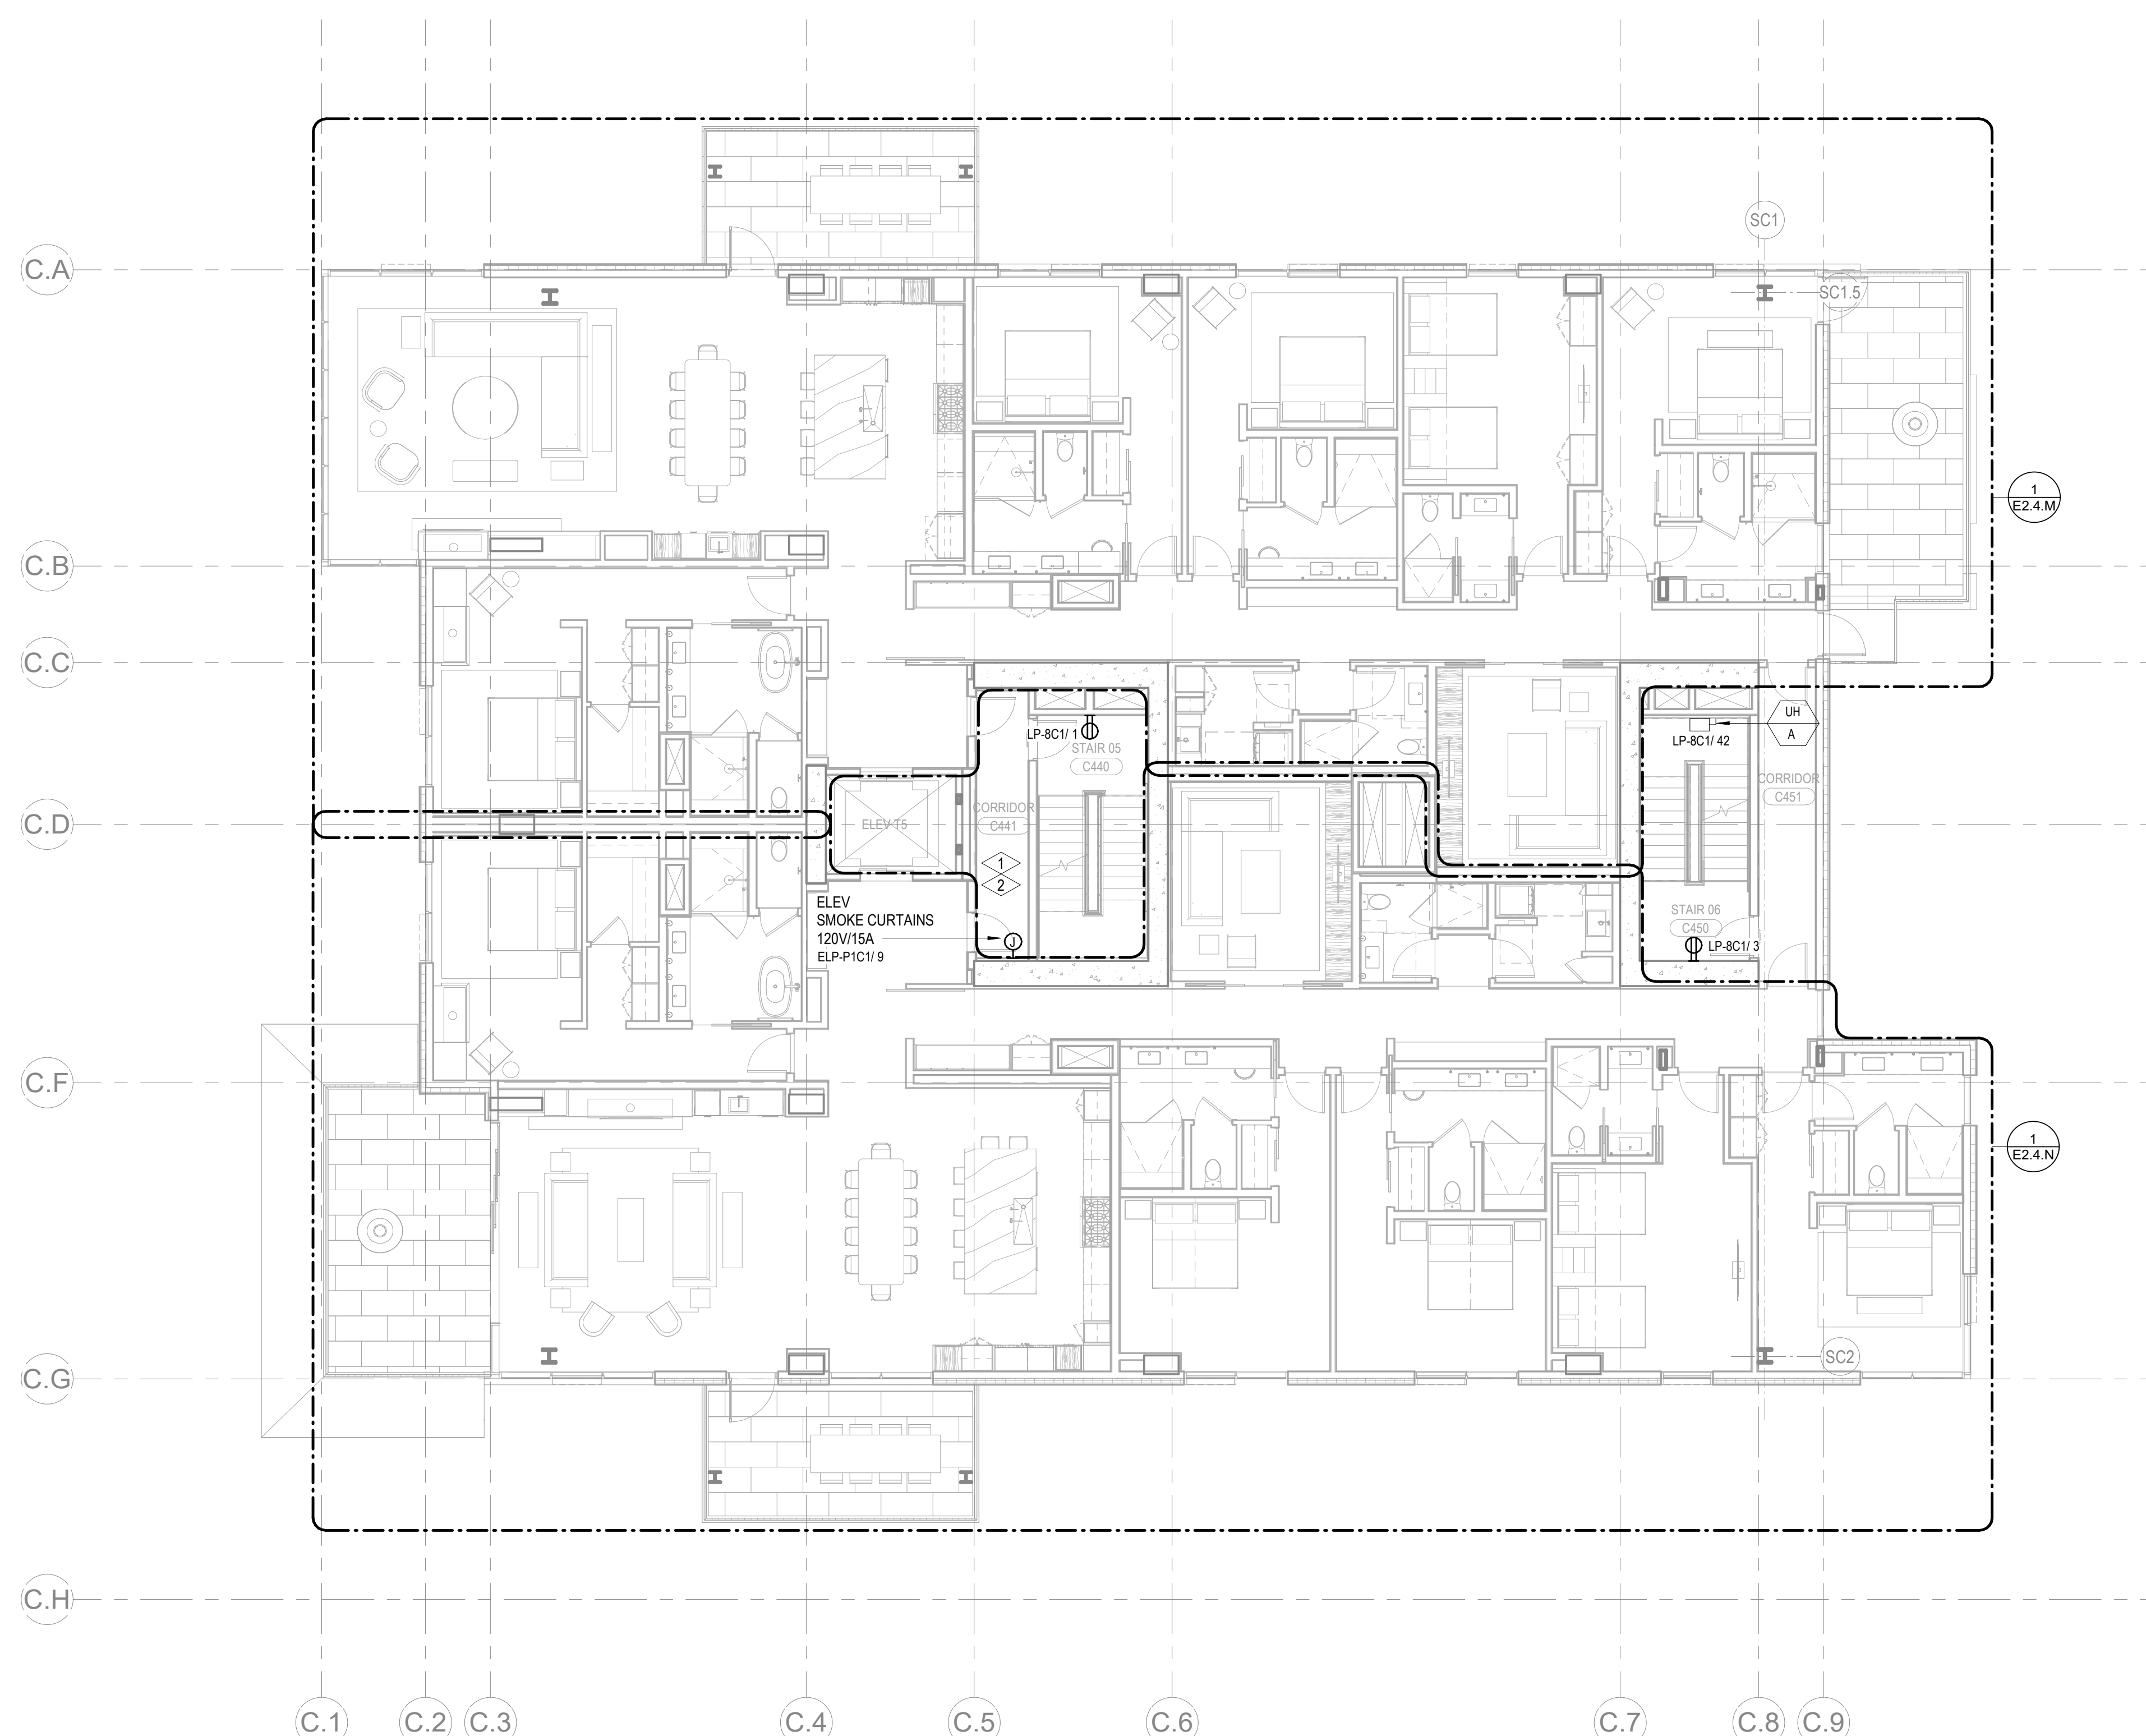

1 TOWER C - LEVEL 4 ELECTRICAL POWER PLAN
SCALE: 1/8" = 1'-0"

