


Olson Kundig

project:
SOMMET BLANC
3300 Marsac Ave (B2 East Parcel)
New York City, 10018-0450


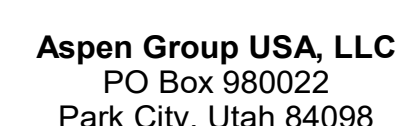


MEP Engineer
WSP USA
1001 Fourth Ave., Suite 3100
Seattle, WA 98154

revisions:

no.	date	t
-----	------	---

 E3.2B.03

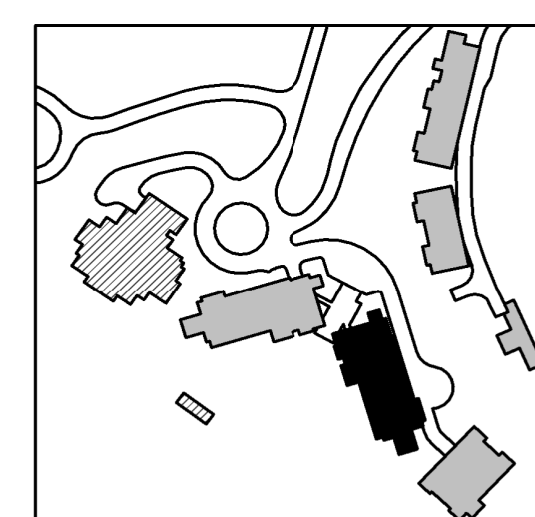

A. DRAWINGS ARE INTENDED TO SHOW GENERAL ARRANGEMENT, DESIGN, AND EXTENT OF WORK AND ARE DIAGRAMMATIC. DRAWINGS ARE NOT INTENDED TO SHOW EXACT LOCATIONS EXCEPT WHERE DIMENSIONS ARE SHOWN. ELECTRICAL WORK IS SHOWN ON PLANS IN GENERAL AND LOCATIONS ARE INDICATED BY DIMENSIONS. THE CONTRACTOR SHALL COMMENCEMENT WITH WORK. VERIFY MEASUREMENTS PERTAINING THERETO AND ASSUME RESPONSIBILITY THEREFOR. ANY SUBSTANTIAL DIFFERENCES BETWEEN THE CONTRACT CONDITIONS AND THE ACTUAL CONDITIONS OF THE CONSTRUCTION MANAGER FOR CONSIDERATION BEFORE PROCEEDING WITH WORK.

B. WORK PERFORMED INCLUDES LABOR, MATERIALS, AND EQUIPMENT REQUIRED TO INSTALL ALL ELECTRICAL WORK SHOWN ON THE DRAWINGS.


C. PROVIDE EMT SIZES AND CONNECT EXIT SIZES AND LUMINAIRES NOTED AS EMERGENCY TO ELECTRICAL POWER SOURCE OR AS NOTICED ON PLANS.

D. REFER TO LUMINAIRE SCHEDULE FOR LUMINAIRE TYPES AND SPECIFICATIONS. ALL FIXTURE CATALOG NUMBERS ARE SUBJECT TO CHANGE BY MANUFACTURER. VERIFY ALL FIXTURE CATALOG NUMBERS.

E. VERIFY EQUIPMENT SIZES AND POWER REQUIREMENTS FOR EQUIPMENT PROVIDED BY OTHERS.

F. ELECTRICAL CONDITIONS IN FINISHED SPACES SHALL BE CONCEALED. COORDINATE WITH OTHER TRADES AND USE CHASES AND CEILING SPACES. LOCATIONS OF ELECTRICAL JUNCTION BOXES IN FINISHED SPACES SHALL BE APPROVED BY ARCHITECT PRIOR TO BOX

NUMBERED NOTES:

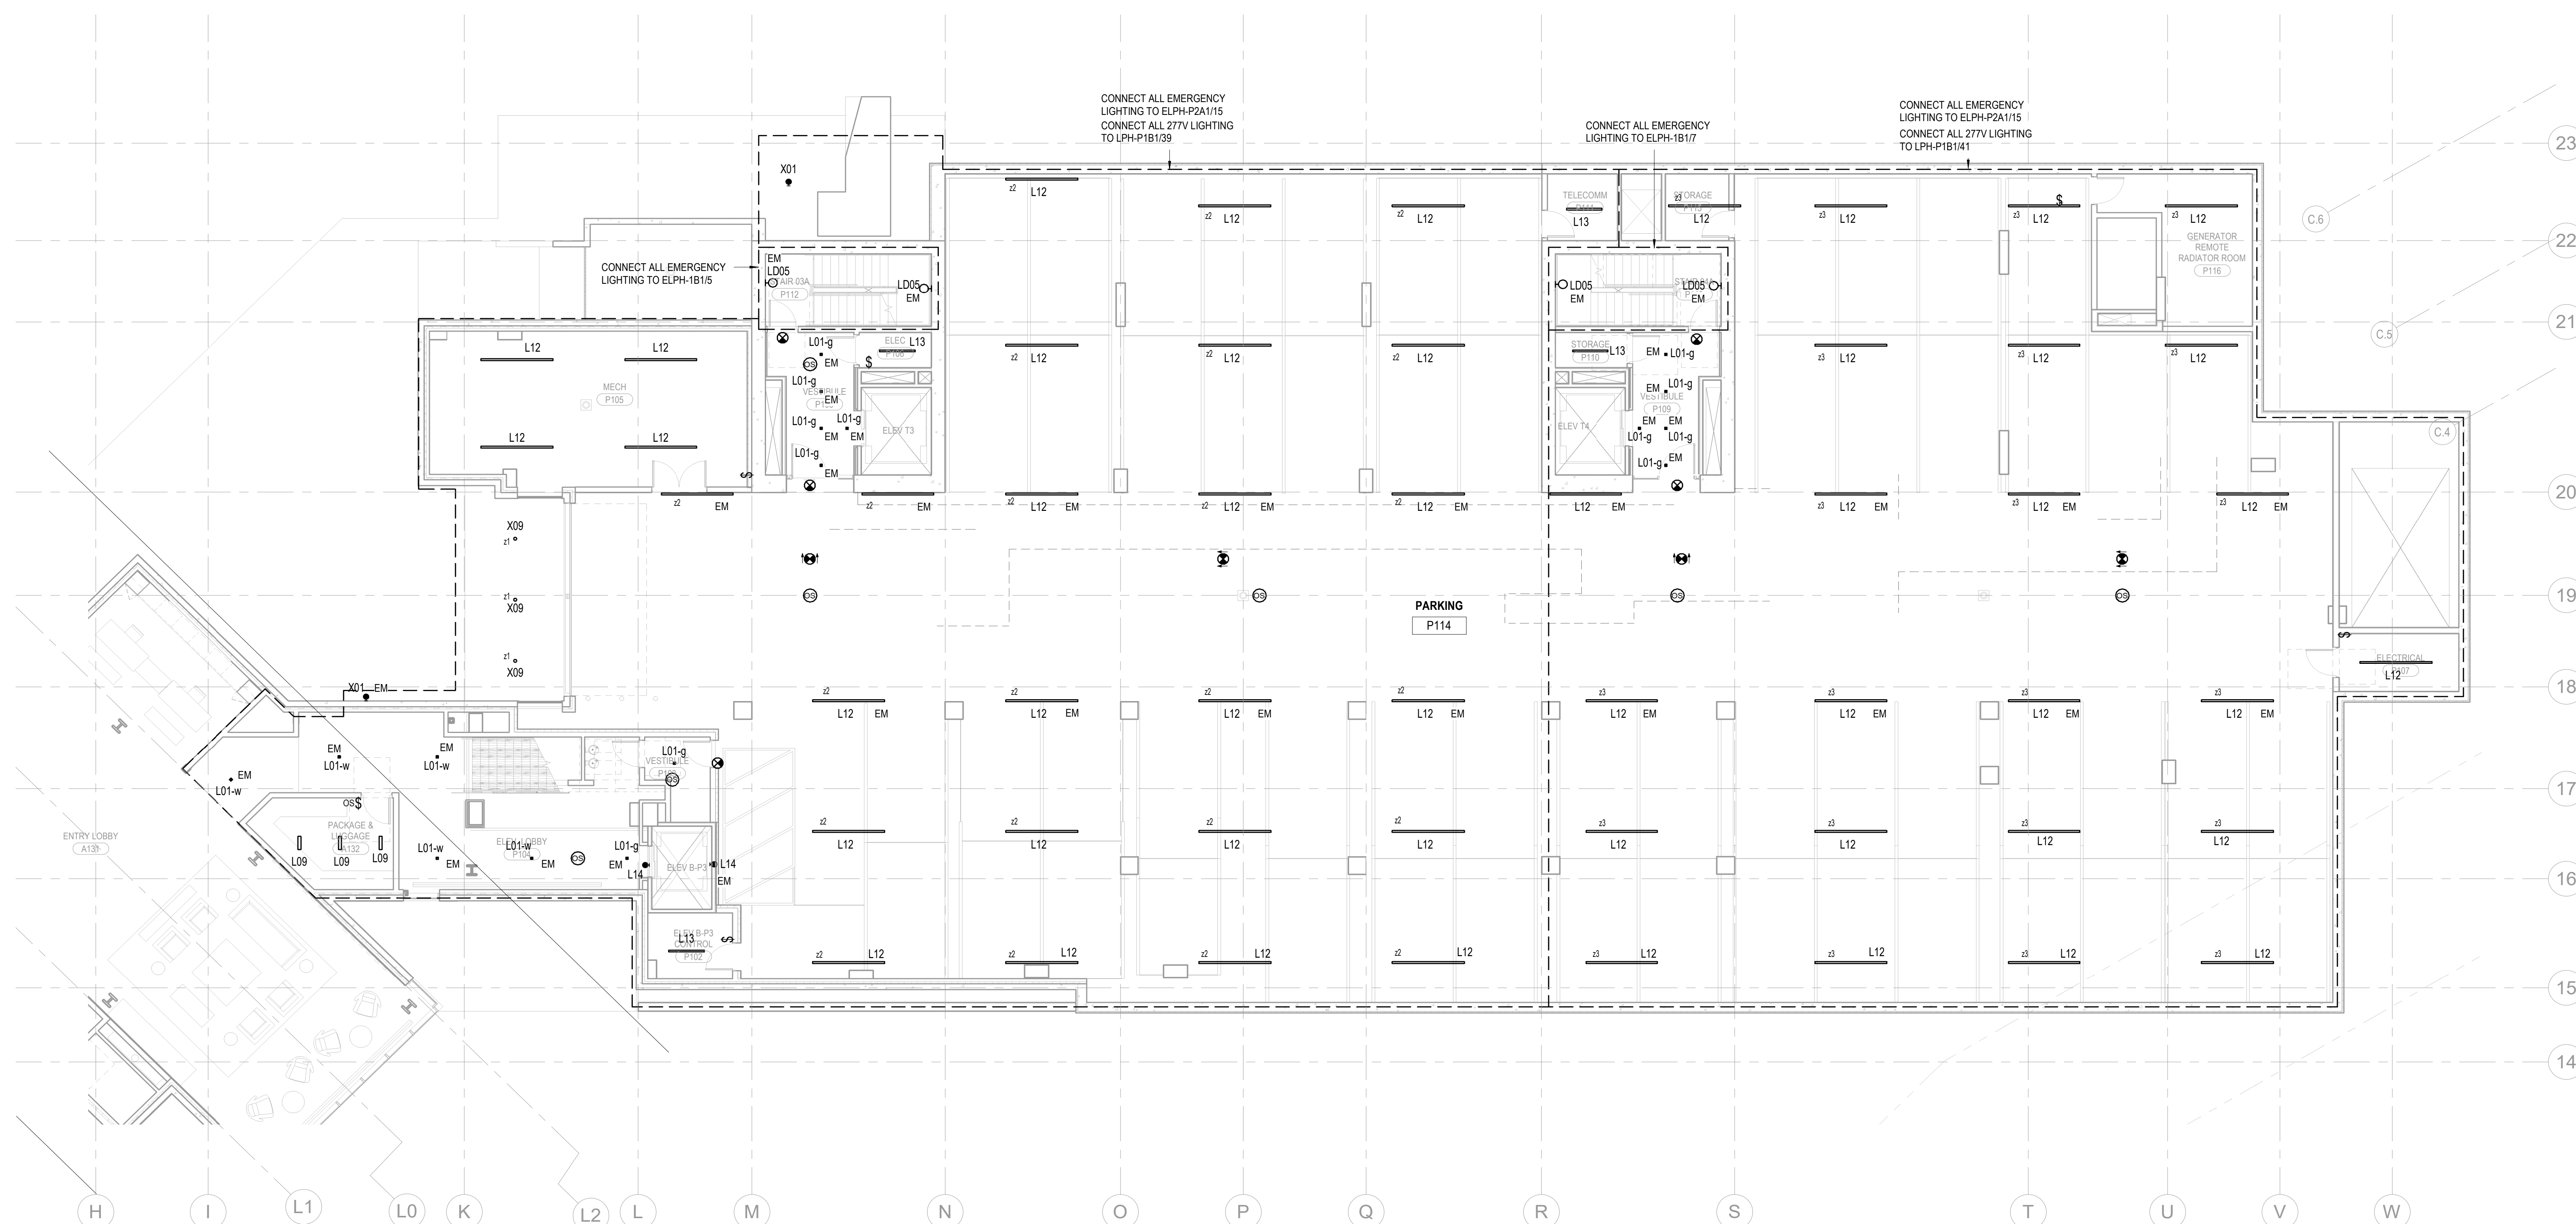

1 TOWER B - PARKING LEVEL 1 ELECTRICAL LIGHTING RCP
SCALE: 1/8" = 1'-0"

