


Seattle, Washington 98104 USA
+1 206 624 5670 olav@kurdig.com


project: **SOMMET BLANC**
3300 Marsac Ave (B2 East Parcel)

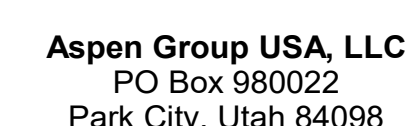

E3.4.D

2. H. COORDINATE REMOTE DRIVER MOUNTING LOCATIONS WITH ARCHITECT PRIOR TO ROUGH-IN.
I. COORDINATE LUMINAIRE VOLTAGE WITH ARCHITECT AND OWNER PRIOR TO PURCHASE AND INSTALLATION TYPICAL FOR ALL UNIT LIGHTING.

- 1 LIGHT FIXTURE LOCATED IN CLOSETS ARE TO BE CONTROLLED BY CLOSET DOOR JAM SWITCH.
- 2 LUTRON WIRELESS PICO CONTROL SWITCH IS TO BE SUPPLIED AND INSTALLED FOR SHADE CONTROL.
- 3 SUPPLY AND INSTALL CEILING MOUNTED JUNCTION BOX COMPLETE WITH CAPPED LIGHTING CIRCUIT WIRING FOR INSTALLATION OF FUTURE CLOSET LIGHT FIXTURE.
- 4 REFER TO ARCHITECTURAL DRAWINGS AND ELEVATIONS FOR EXACT DIMENSION AND MOUNTING LOCATION OF LIGHT FIXTURE TYPE L04. COORDINATE WITH MILL/WORK CONTRACTOR PRIOR TO INSTALLATION.

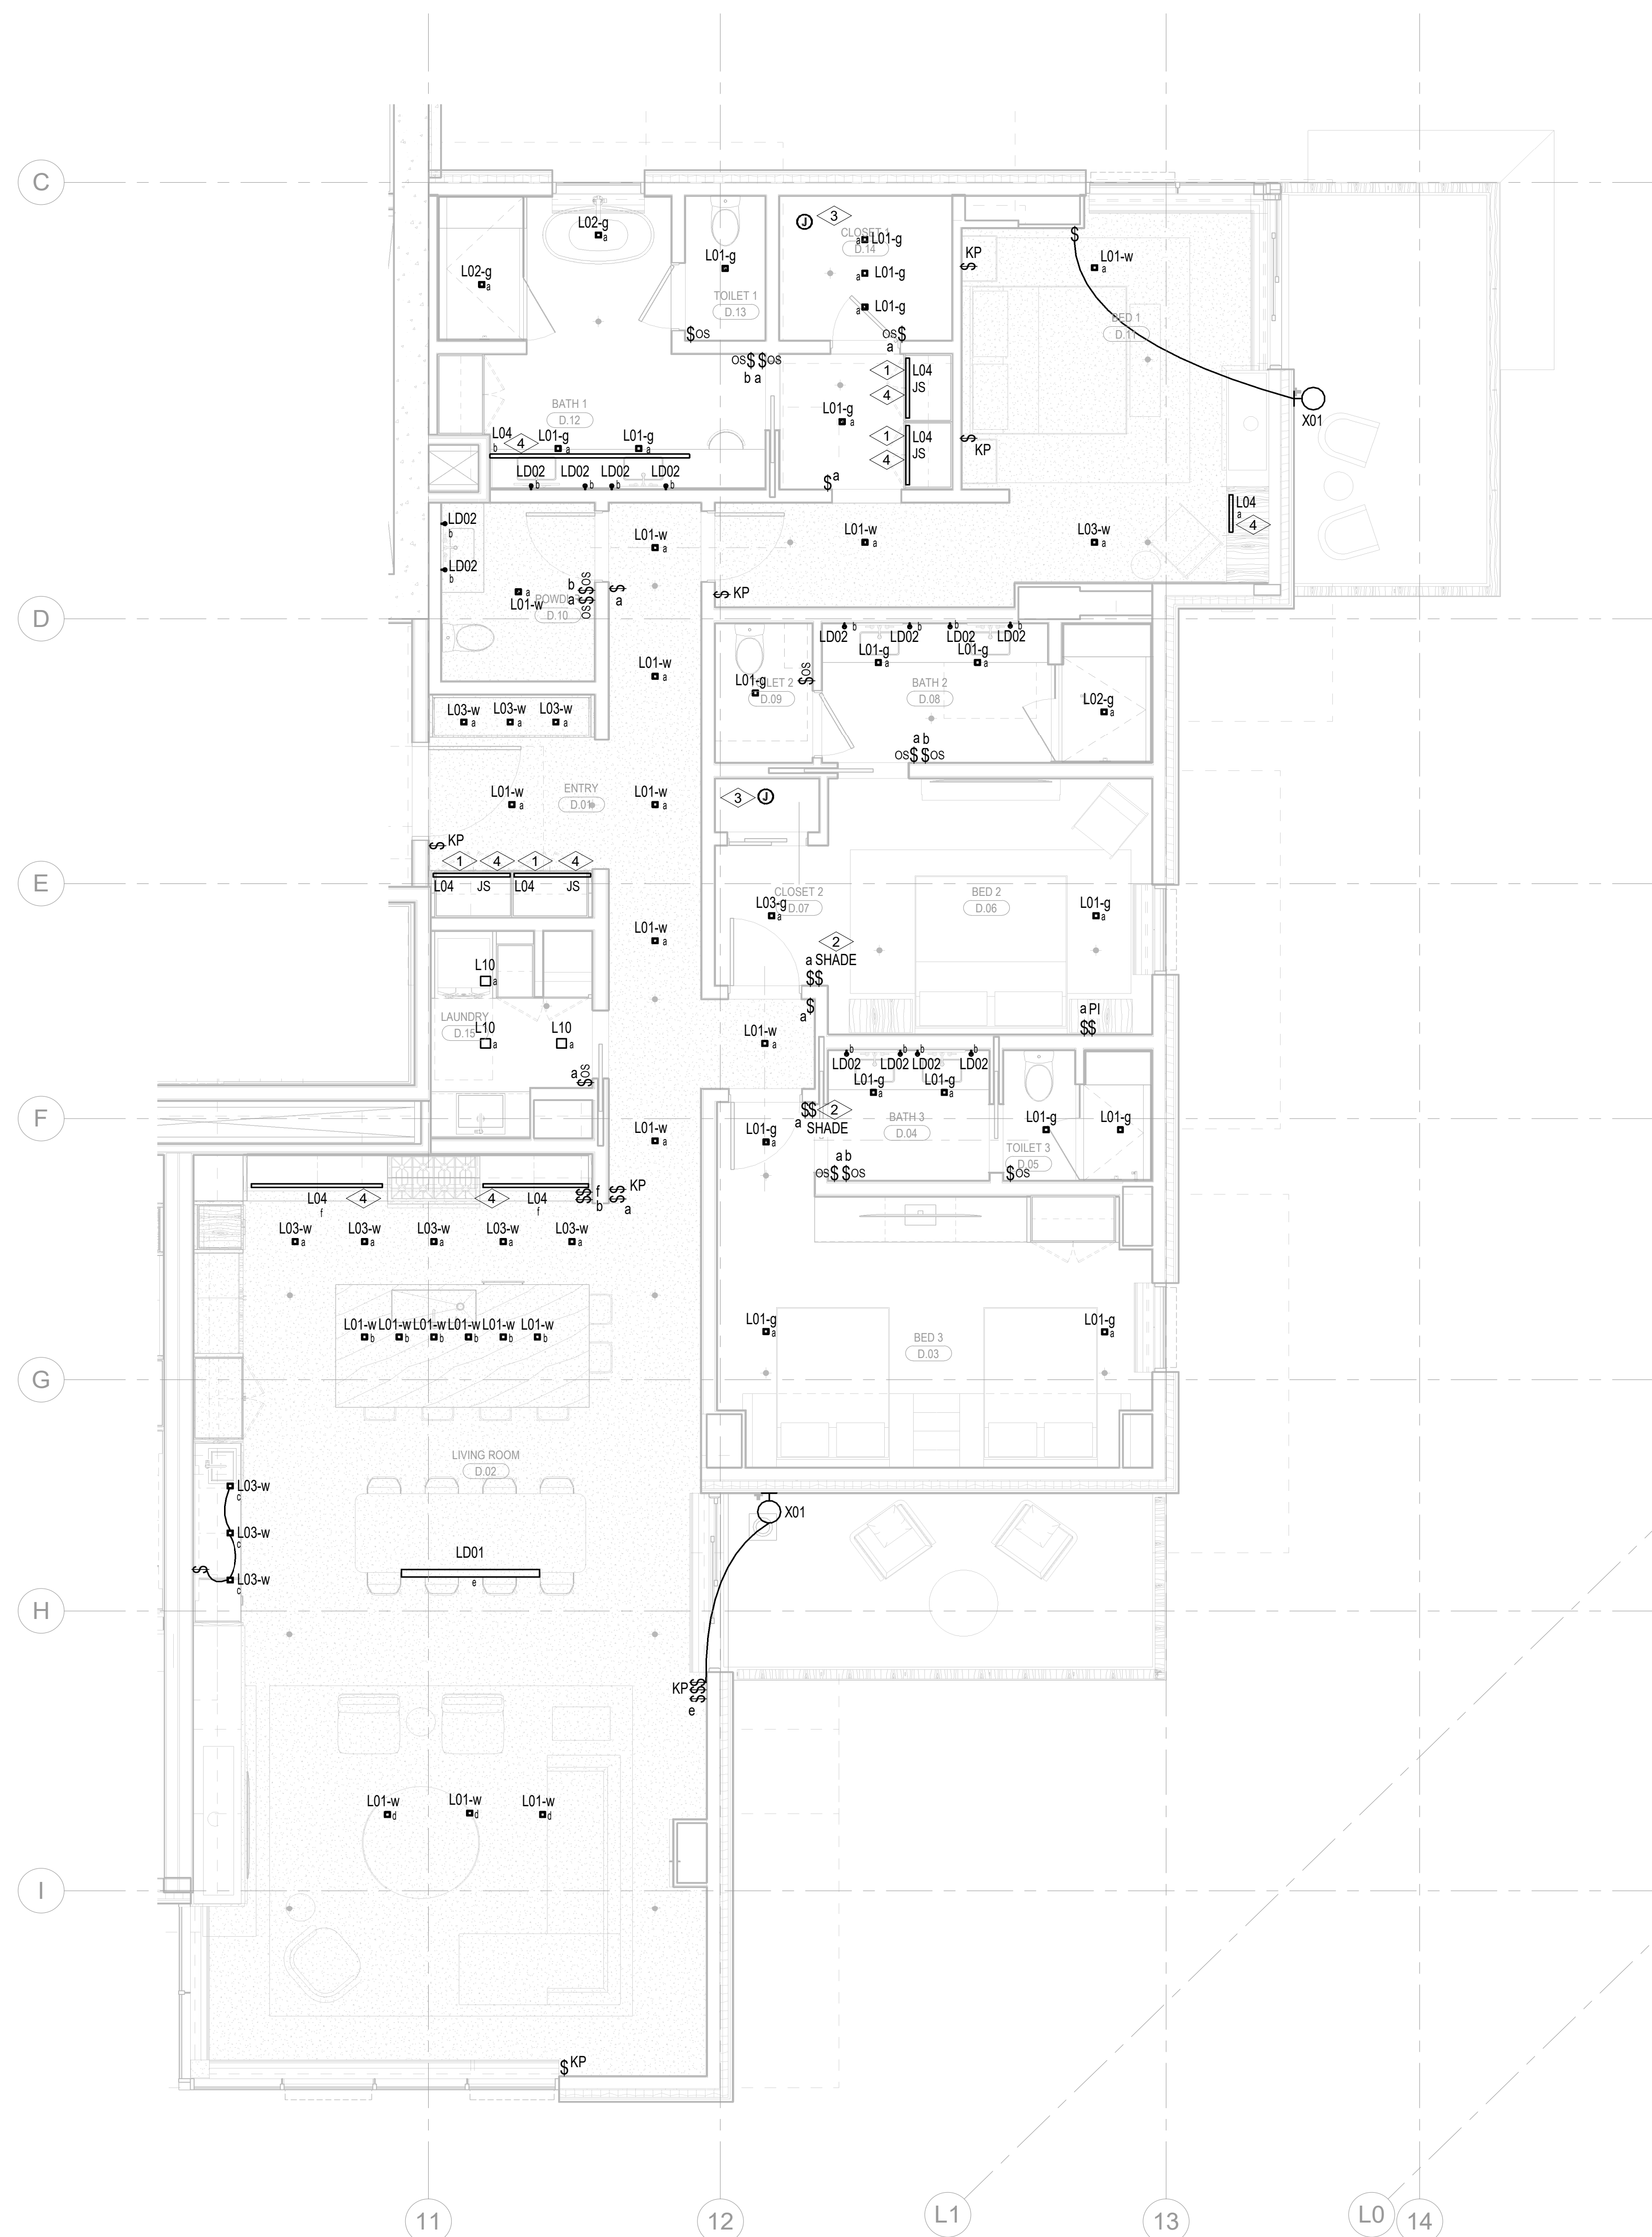

1 TOWER A/B - ELECTRICAL LIGHTING PLAN - UNIT D
SCALE: 1/4" = 1'-0"



0 1' 2' 3' 4' 8' 12