



- KEYNOTES:
- 1 FIRE ALARM TERMINAL CABINET WITHIN 2-HR RATED SHAFT ACCESSIBLE VIA 2-HR RATED ACCESS PANEL. COORDINATE INSTALLATION AND ACCESS WITH DIVISION 26.
 - 2 STAIR SPEAKER FOR MANUAL PAGING CONNECTED TO DEDICATED CIRCUIT.

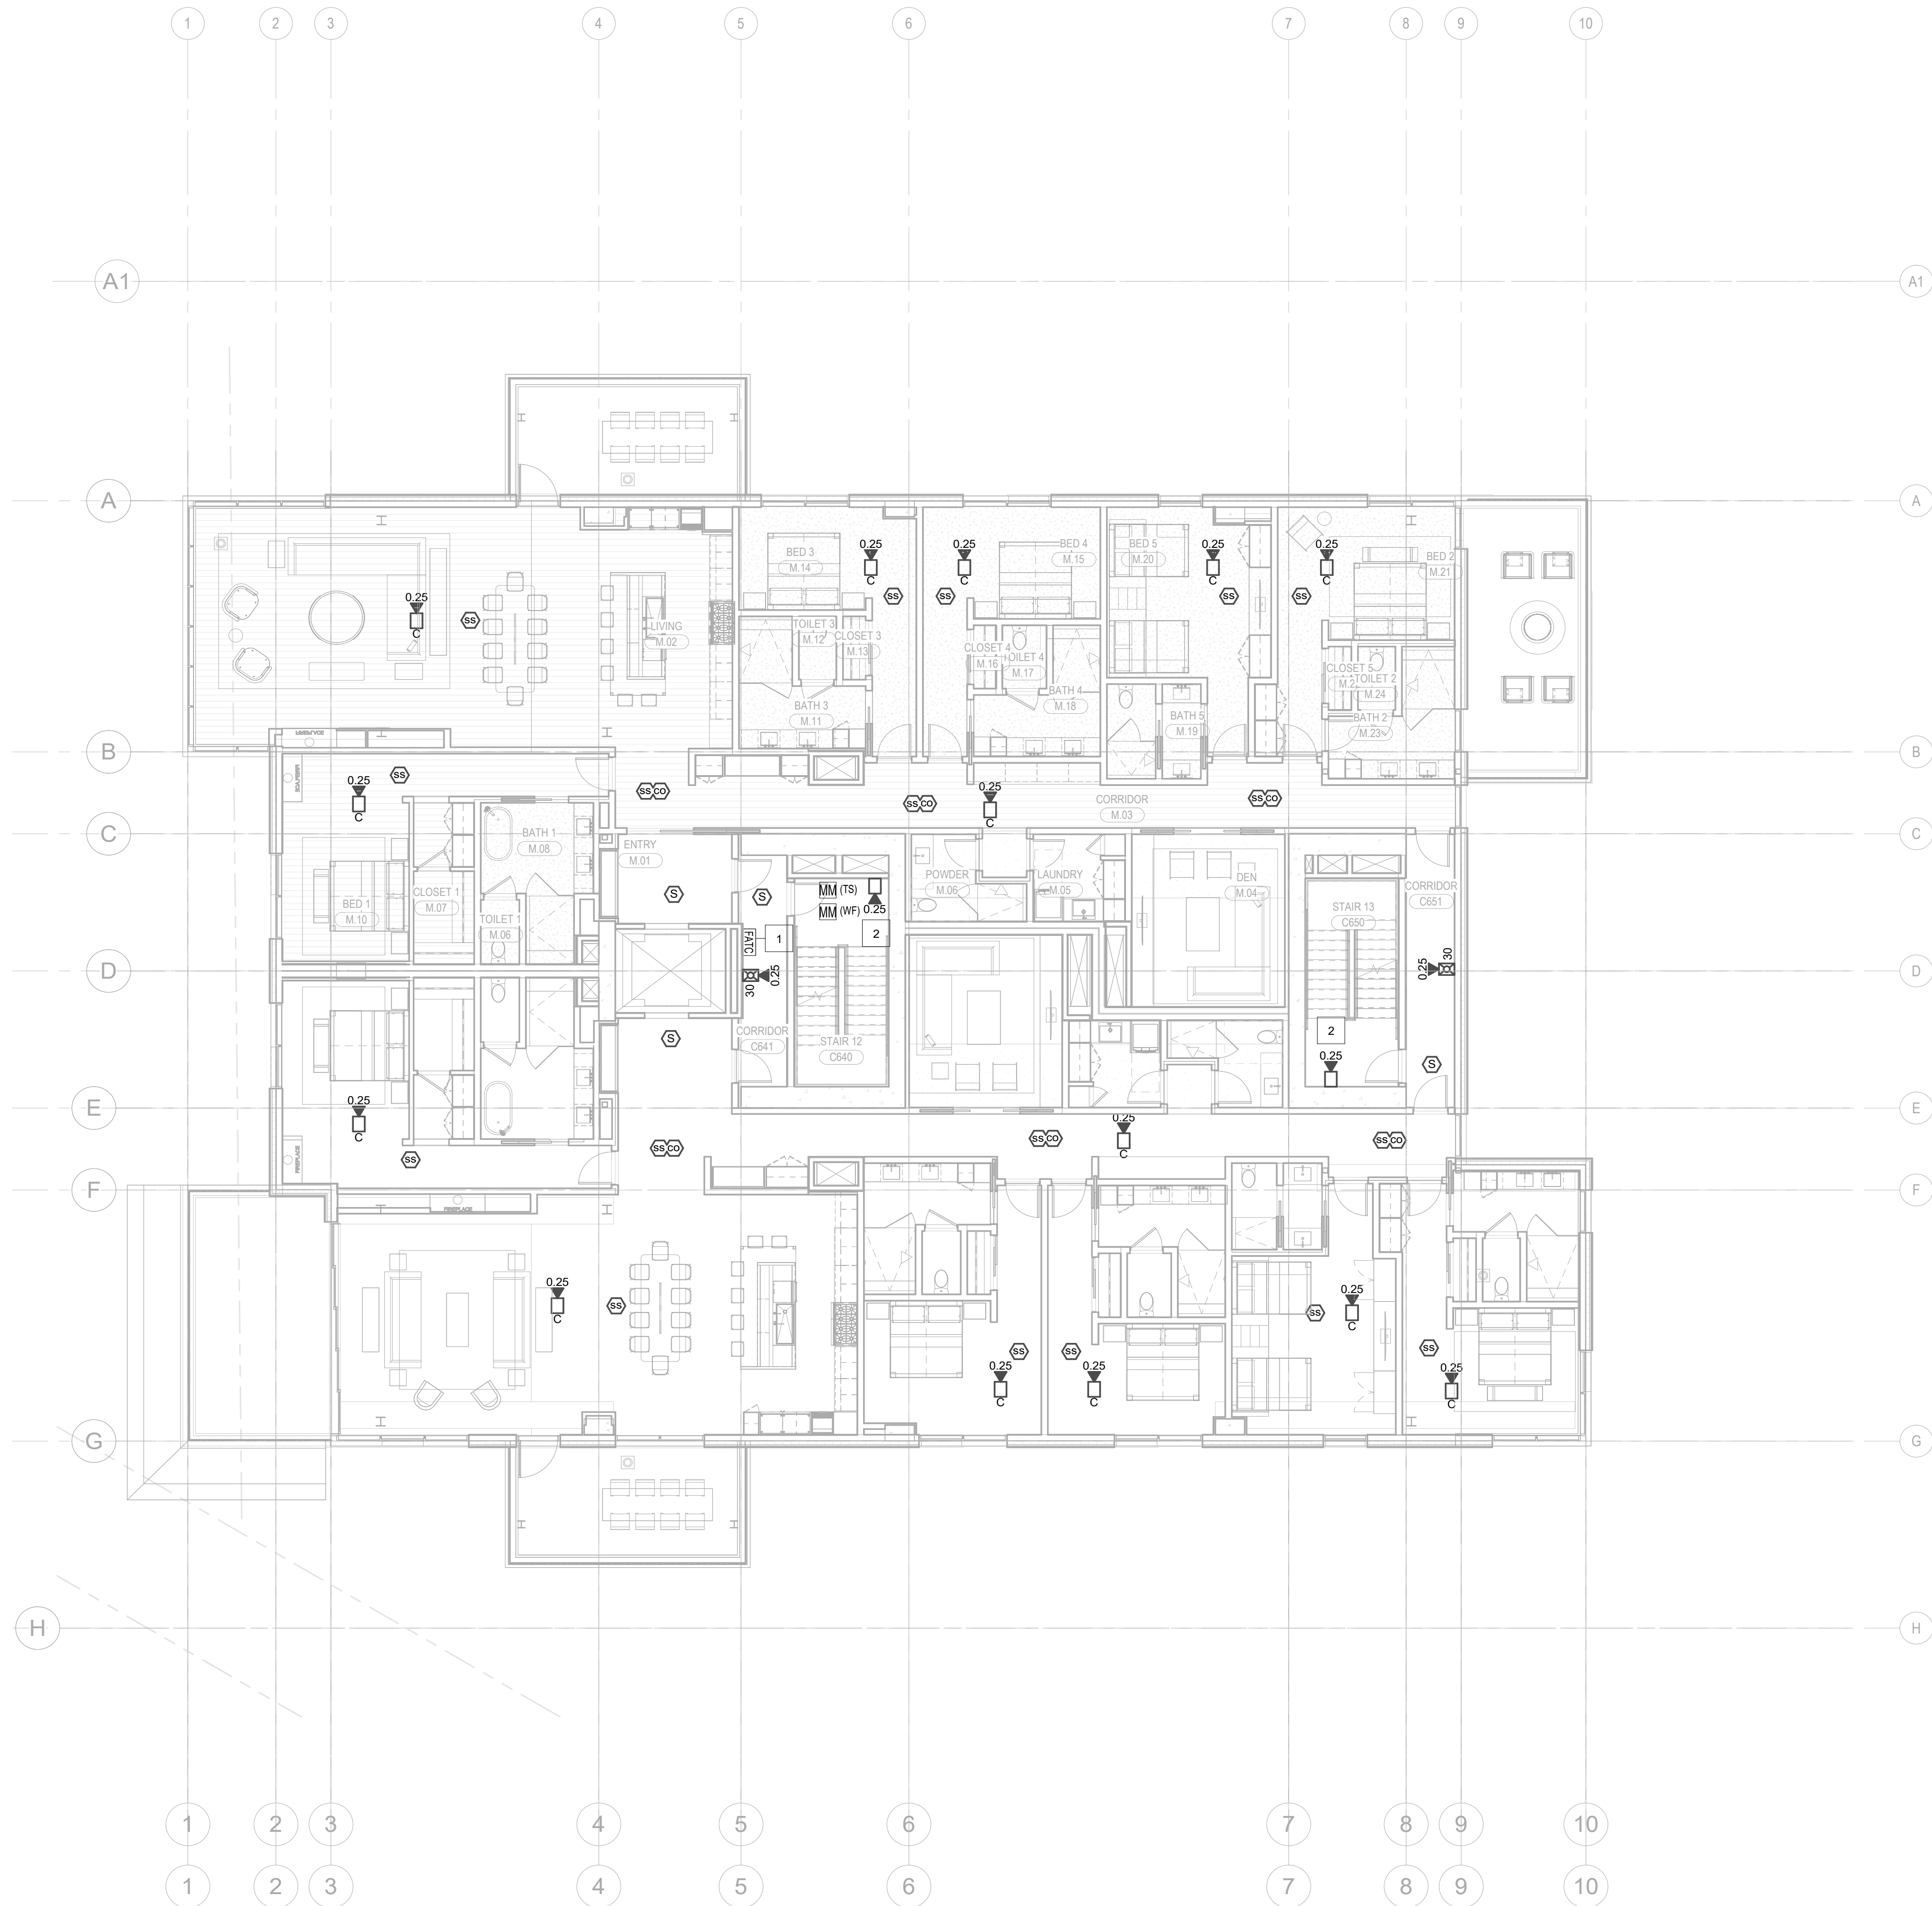

1 LEVEL 6 - FA
1/8" = 1'-0"

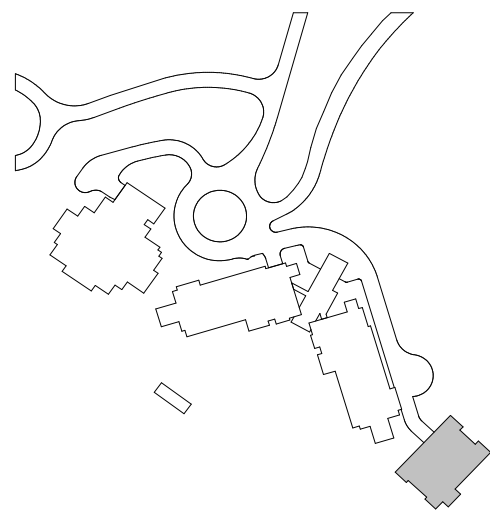

Reserved for permit stamp

193 South Jackson St., Suite 400
Seattle, Washington 98104 USA
+1 206 454 1900 olsonkundig.com

Olson Kundig

project
SOMMET BLANC - C
DEER VALLEY, UTAH

White Summit Development, LLC
PO Box 980022
Park City, Utah 84098

Acoustic Consultant
BRC Acoustics
1932 1st Ave., Suite 420
Seattle, WA 98101

Pool Consultant
Cloward H2O
2096 N University Ave., Suite 290
Provo, UT 84604

Landscape Architect
EPG Design
6940 South High Tech Drive, Suite 100
Midvale, Utah 84047

Specifications Writer
Friday Group
88 Marmol Road
Middlebury, VT

Code Consultant
Holmes
600 1st Avenue, Suite 200A
Seattle, WA 98104

Fire Protection Engineer
Jensen Hughes
One Research Drive, Suite 305C
Westborough, MA 01581

Vertical Transportation Consultant
Lerch Bates
19515 North Creek Parkway, Suite 304
Bellevue, WA 98011

Structural Engineer
Magnusson Klemencic Associates
1301 5th Ave., Suite 3200
Seattle, WA 98101

Lighting Designer
O
1319 SE MLK Blvd., Suite 210
Portland, Oregon 97219

Building Envelope Consultant
RDH
2101 N 34th St
Seattle, WA 98103

Accessibility Consultant
Studio Pacifica
2144 Westlake Ave N, Suite F
Seattle, WA 98109

MEP Engineer
WSP USA
1901 Fourth Ave., Suite 3100
Seattle, WA 98154

principal architect...TK
project manager...JCC
drawn by...CBB, SMM
checked by...Checker
job no. 2052
date 05/17/2024

revisions:

no. — date — by —

IFC Set 2 of 3
05/17/2024

FIRE ALARM PLAN -
TOWER C - LEVEL 6
FA2.2C.16