


1. SCOPE OF WORK INCLUDES SPRINKLER PROTECTION THROUGHOUT ALL AREAS IN ACCORDANCE WITH NFPA 13. SPRINKLERS ARE INDICATED IN HYDRAULIC CALCULATION REMOTE AREAS AND AREAS WITH FINISHED CEILINGS FOR COORDINATION PURPOSES. INSTALLING CONTRACTOR SHALL BE RESPONSIBLE FOR DETAILED DESIGN OF BRANCH PIPING AND UPRIGHT SPRINKLERS IN AREAS WITHOUT FINISHED CEILINGS.

159 South Jackson St, Suite 600
Seattle, Washington 98104 USA
+1 206 624 5670 olson@olsonbundy.com

SOMMET BLANC - C
DEER VALLEY, UTAH

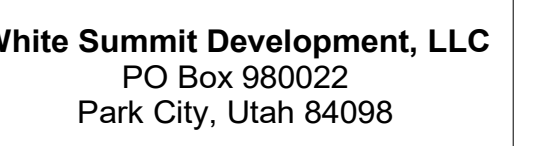

principal architect...TK
project manager...JCC
drawn by...CRB, SMK
checked by...Checker
job no. 20052
date 05/17/2024



sions:

date _____ by _____

FC Set 2 of 3
05/17/2024

FIRE PROTECTION PLAN
TOWER C - LEVEL 8

FP2.2C.18

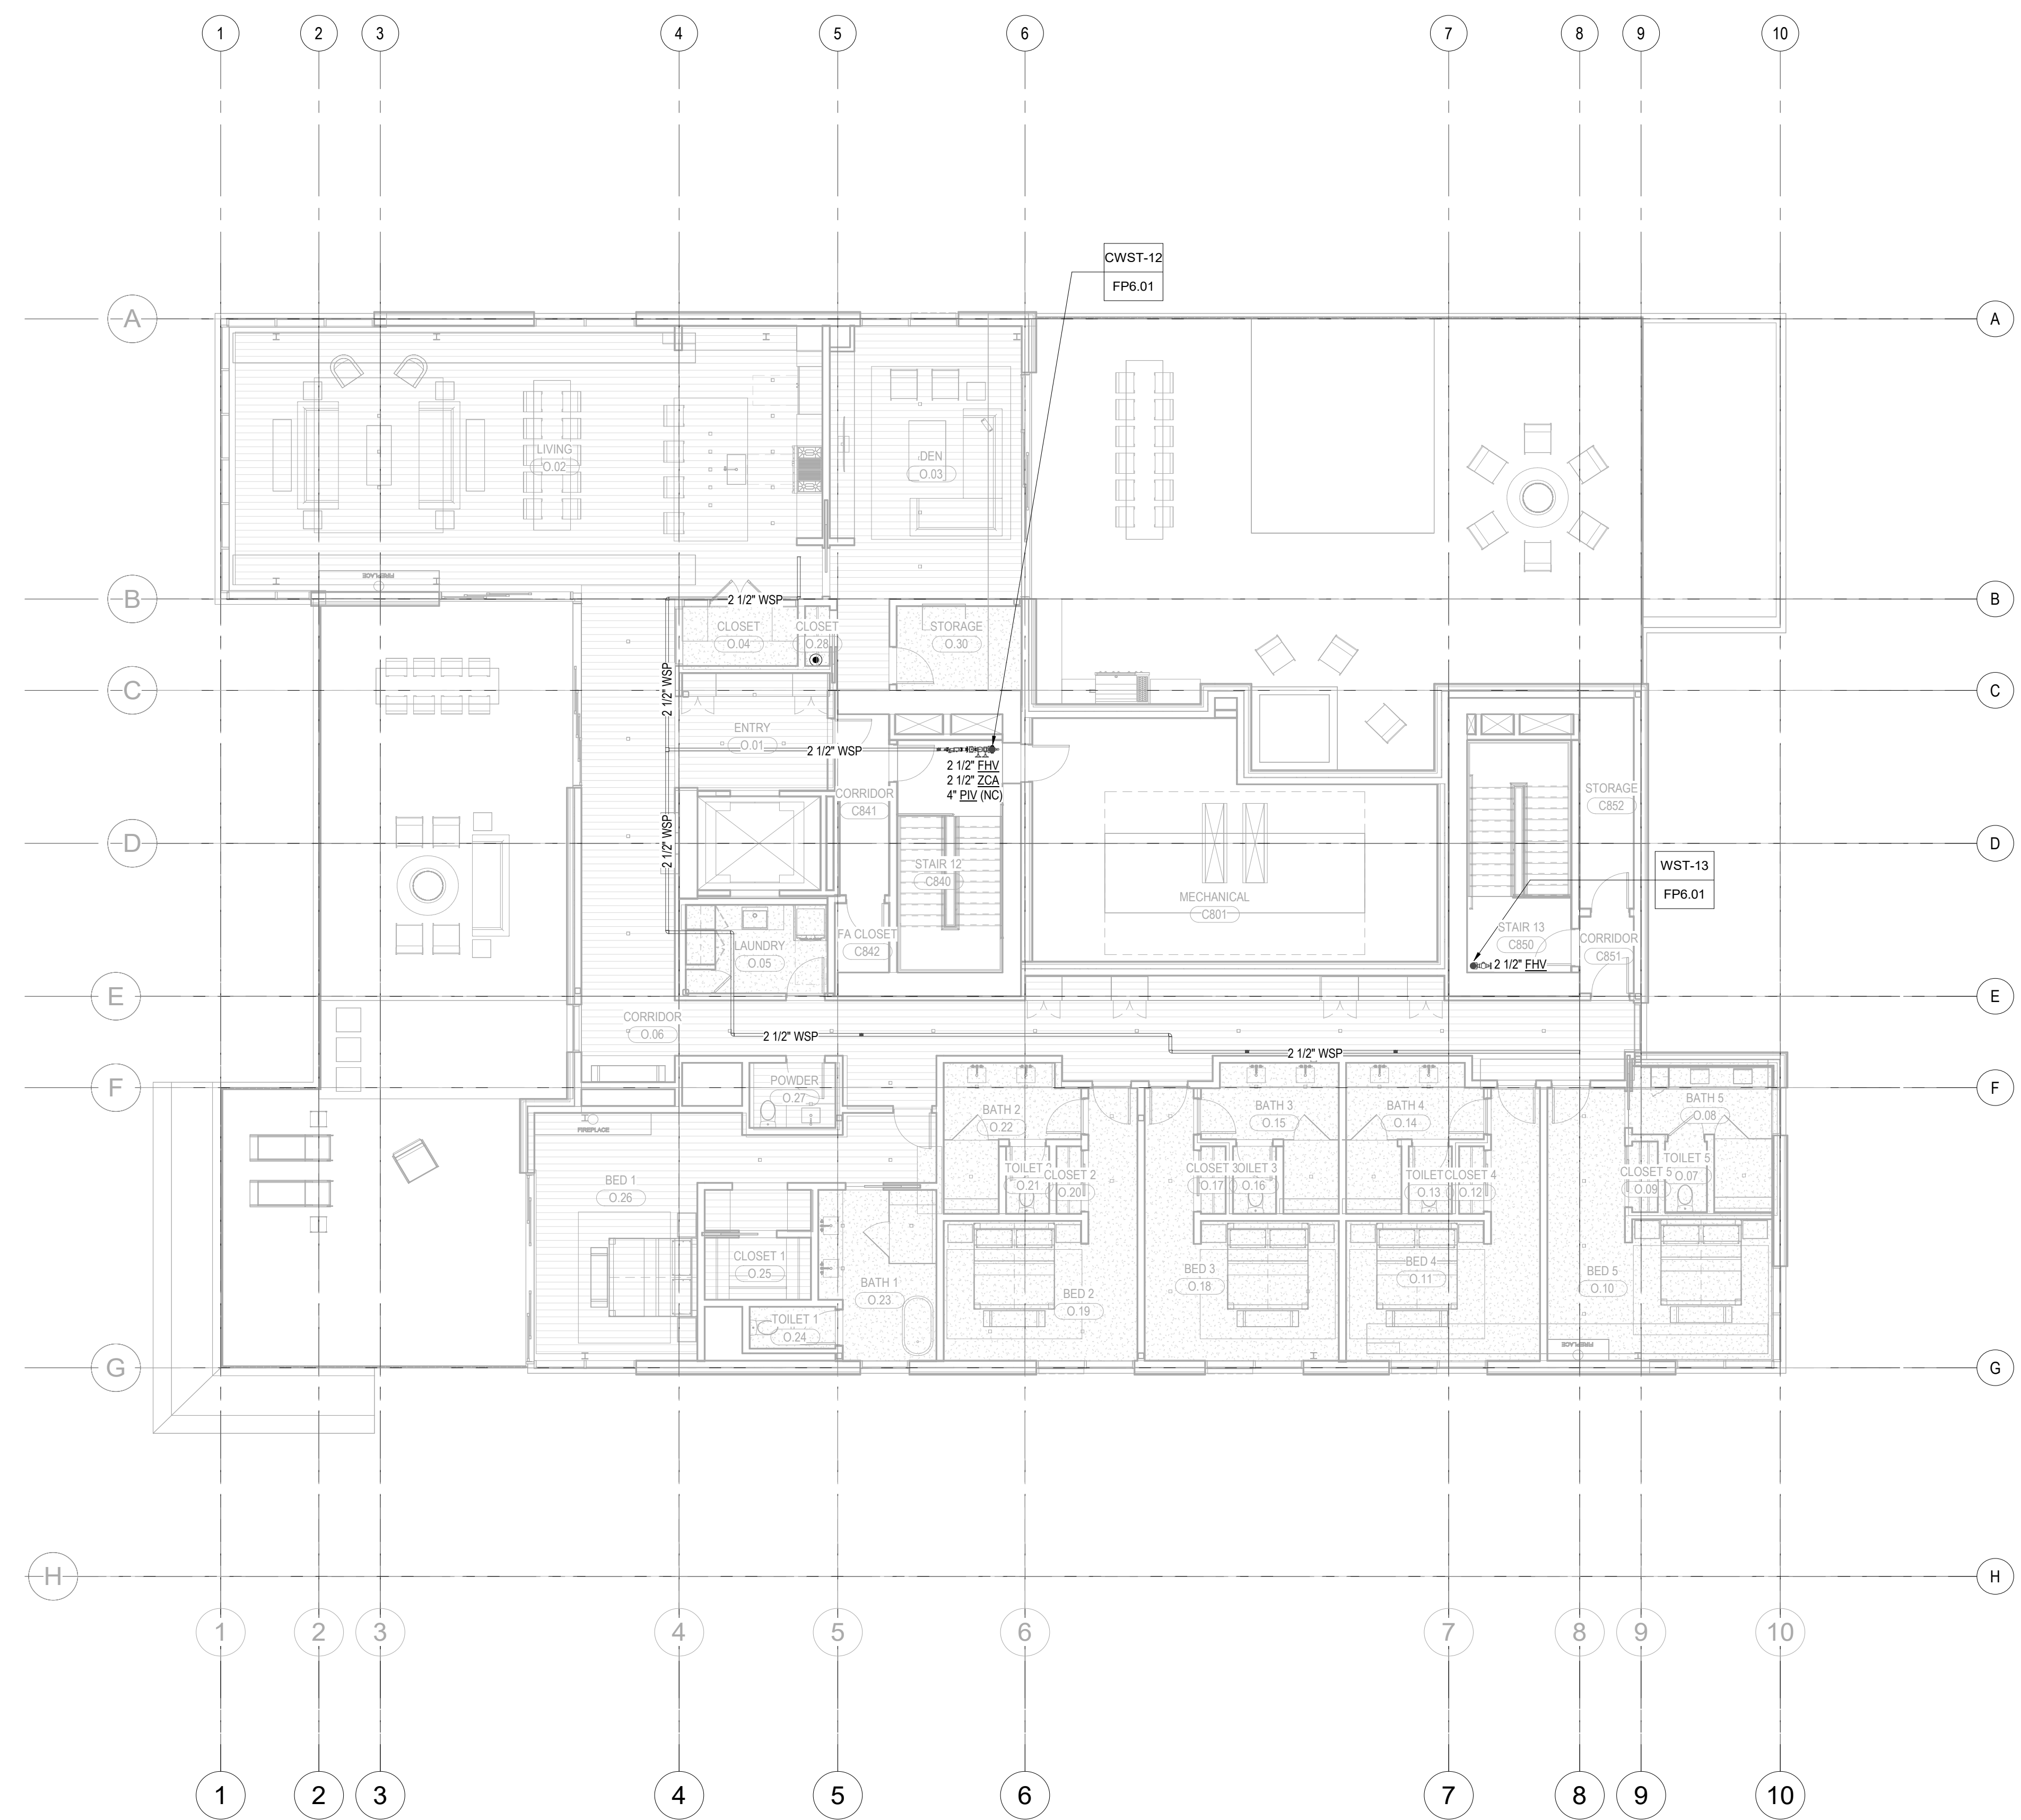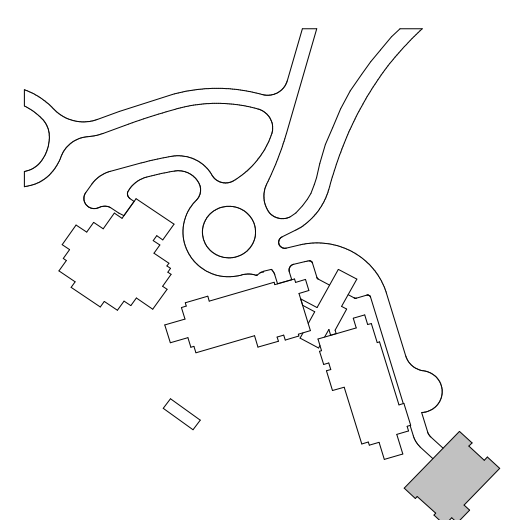

1 TOWER C - LEVEL 8 - FP
1/8" = 1'-0"