


139 South Jackson St, Suite 620
Seattle, Washington 98104 USA
Tel: 206 624 5670 osonkundig.com

Olson Kundig

project: **SOMMET BLANC**
9300 Marsac Ave (B2 East Parcel)
Berk City, Utah 84060

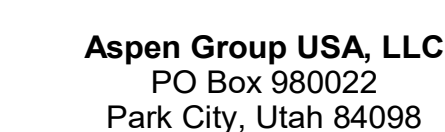

Pool Consultant
Cloward H2O
2696 N University Ave, Suite 290
Provo, UT 84604

Landscape Architect
EPG Design
6949 South High Tech Drive, Suite 100
Midvale, Utah 84047

Specifications Writer
Friday Group
88 Mainelli Road
Middletown, CT

Code Consultant
Holmes
600 1st Avenue, Suite 200
Seattle, WA 98104

Fire Protection Engineer
Jensen Hughes
One Research Drive, Suite 305C
Westborough, MA 01581

Vertical Transportation Consultant
Lerch Bates
19515 North Creek Parkway, Suite 300
Redmond, WA 98051

Structural Engineer
Magnusson Klemencic Associates
1301 5th Ave, Suite 3200
Seattle, WA 98101

Lighting Designer
O-
1319 SE MLK Blvd, Suite 210
Portland, Oregon 97216

Building Envelope Consultants
RDH
2101 N 34th St
Seattle, WA 98103

Accessibility Consultant
Studio Pacifica
2144 Westlake Ave N, Suite F
Seattle, WA 98109

MEP Engineer
WSP USA
1001 Fourth Ave., Suite 3100
Seattle, WA 98154

principal architect _____
project manager _____
drawn by _____
checked by Checker
job no. _____
date 05/17/2024


revisions:

no.	date	to	for
1	1950	...	...
2	1951	...	...
3	1952	...	...
100	2049	...	...

IFC Set 2 of 3
05/17/2024

TOWER C - LVL 5
MECHANICAL PIPING
PLAN

M3.2C.15

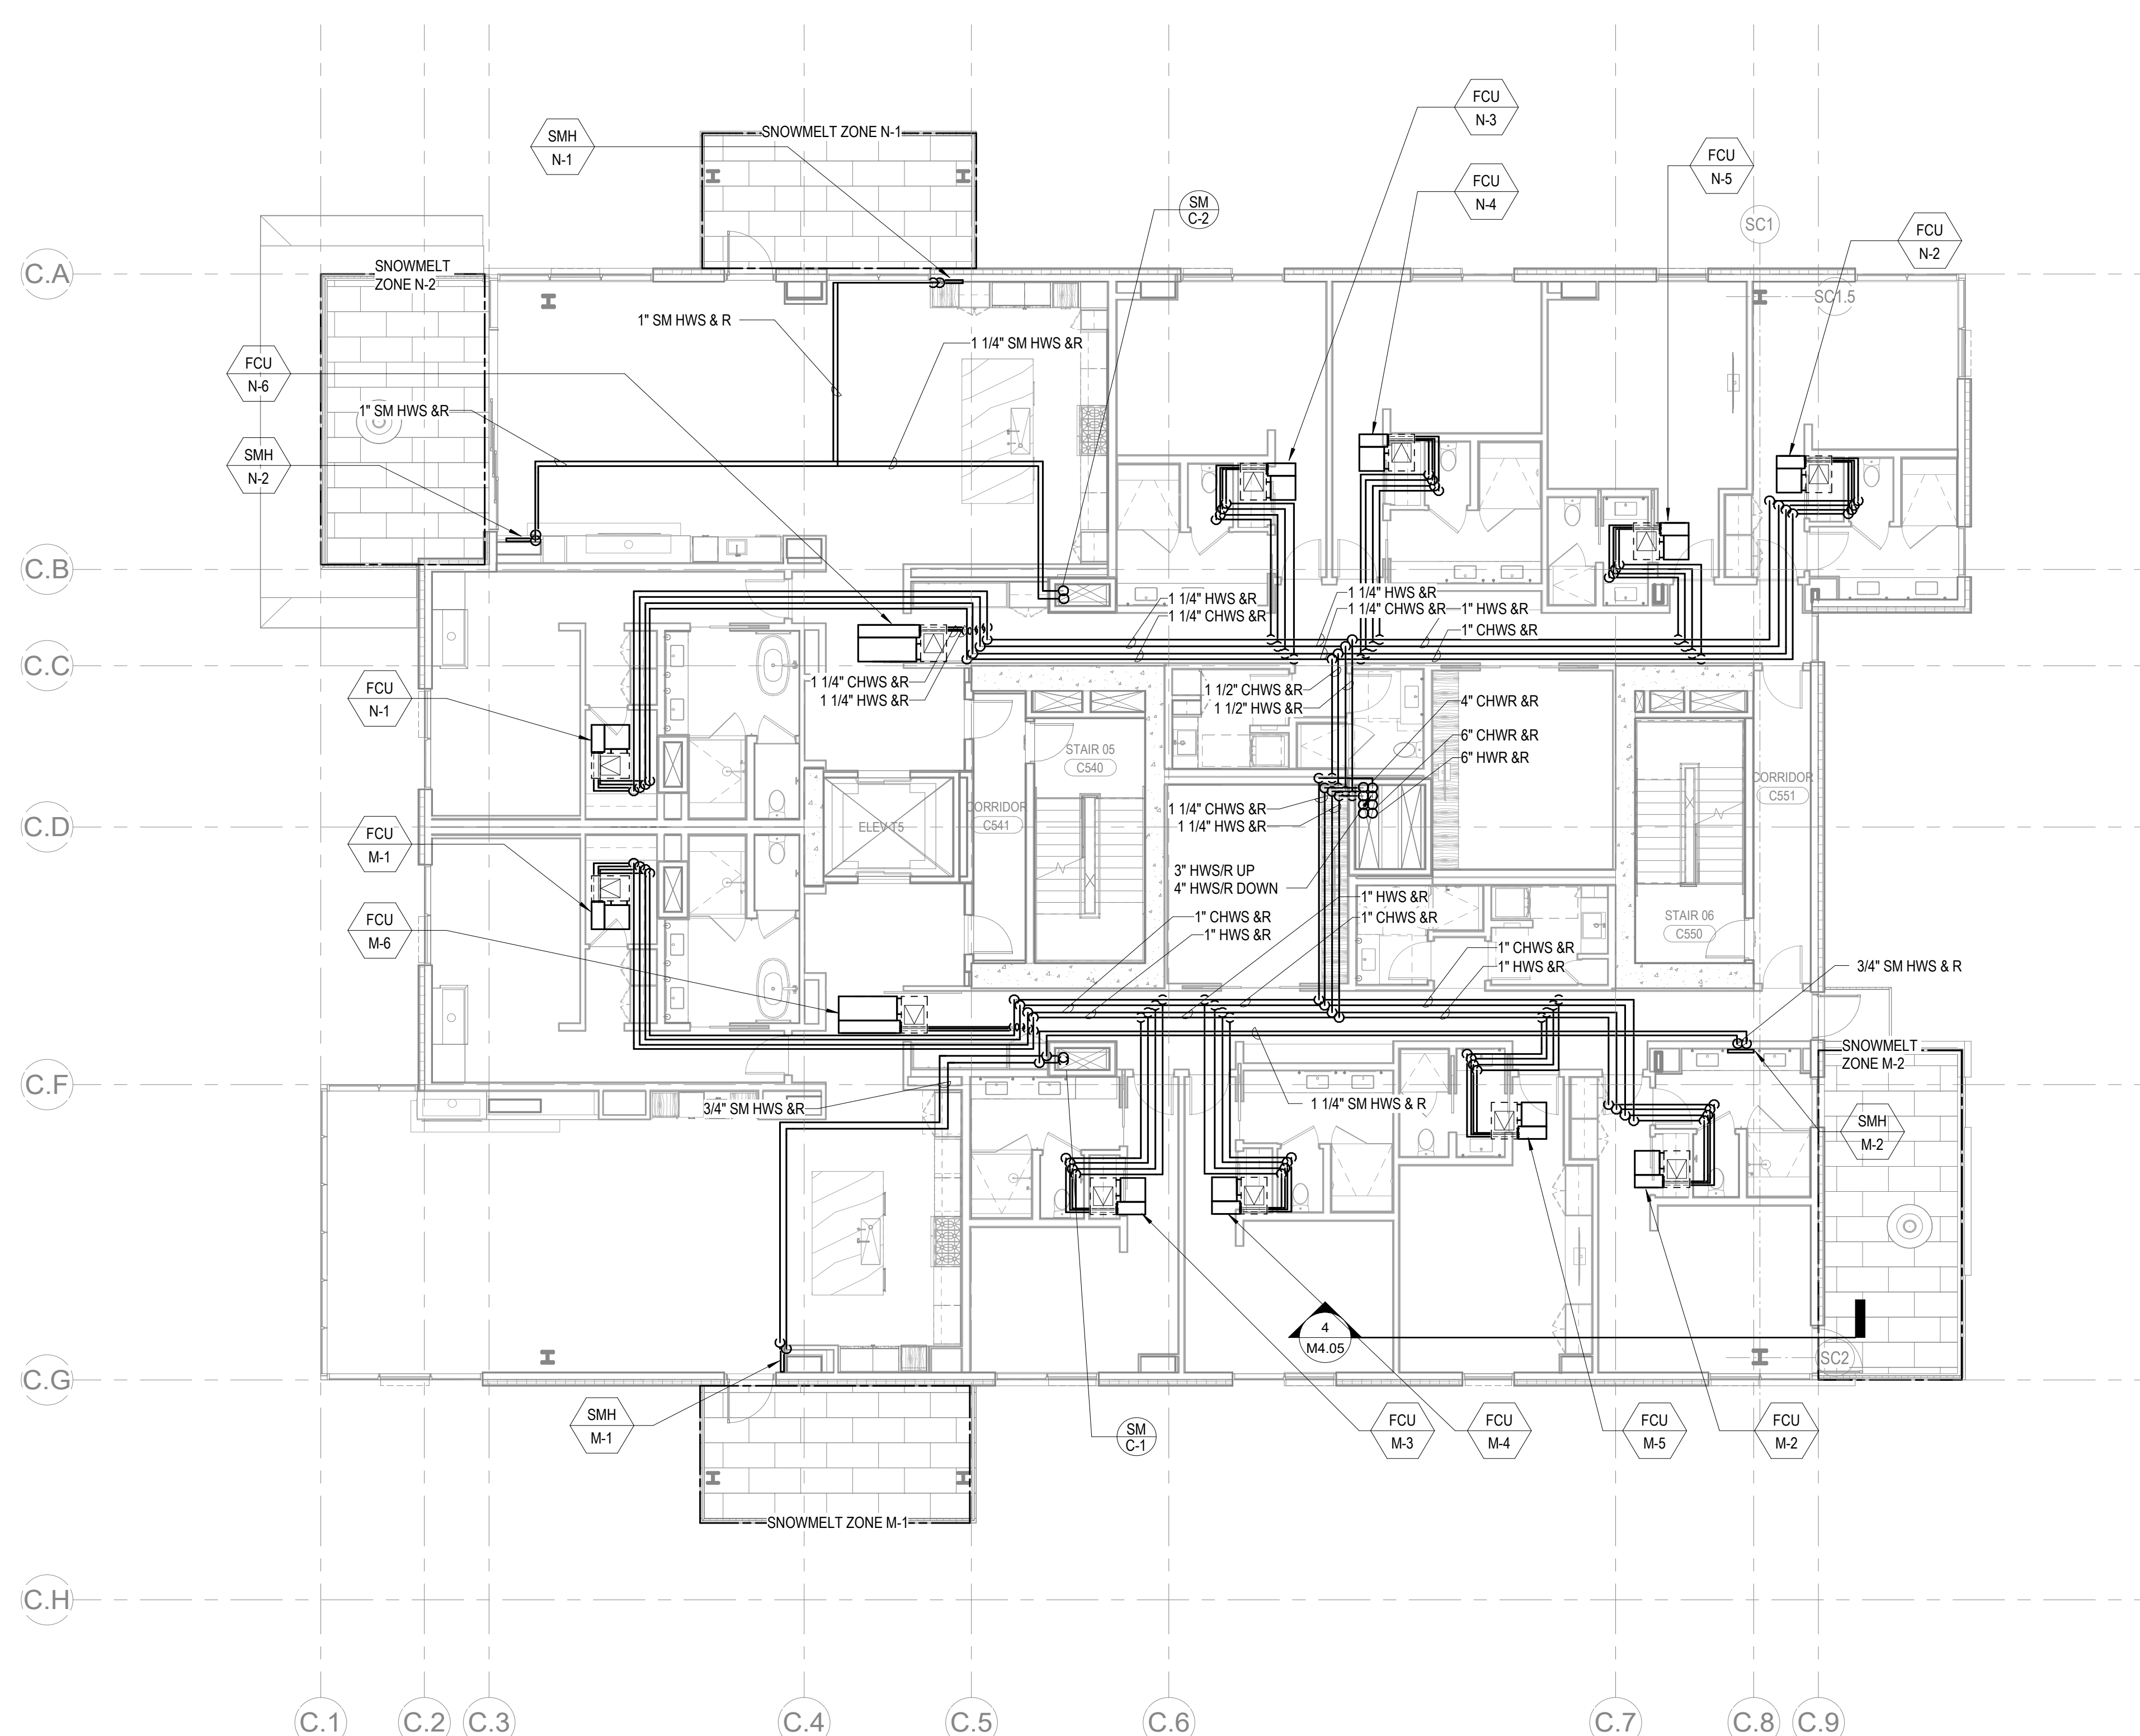

1 TOWER C - LEVEL 5 MECHANICAL PIPING PLAN
SCALE: 1/8" = 1'-0"

