


Olson Kundig

project:  
**SOMMET BLANC**  
9300 Marsac Ave (B2 East Parcel)  
Park City, Utah 84060

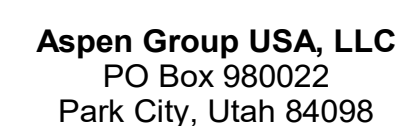


**MEP Engineer**  
**WSP USA**  
1001 Fourth Ave., Suite 3100  
Seattle, WA 98154

revisions

| no. | date | by |
|-----|------|----|
|-----|------|----|

M3.2C.17

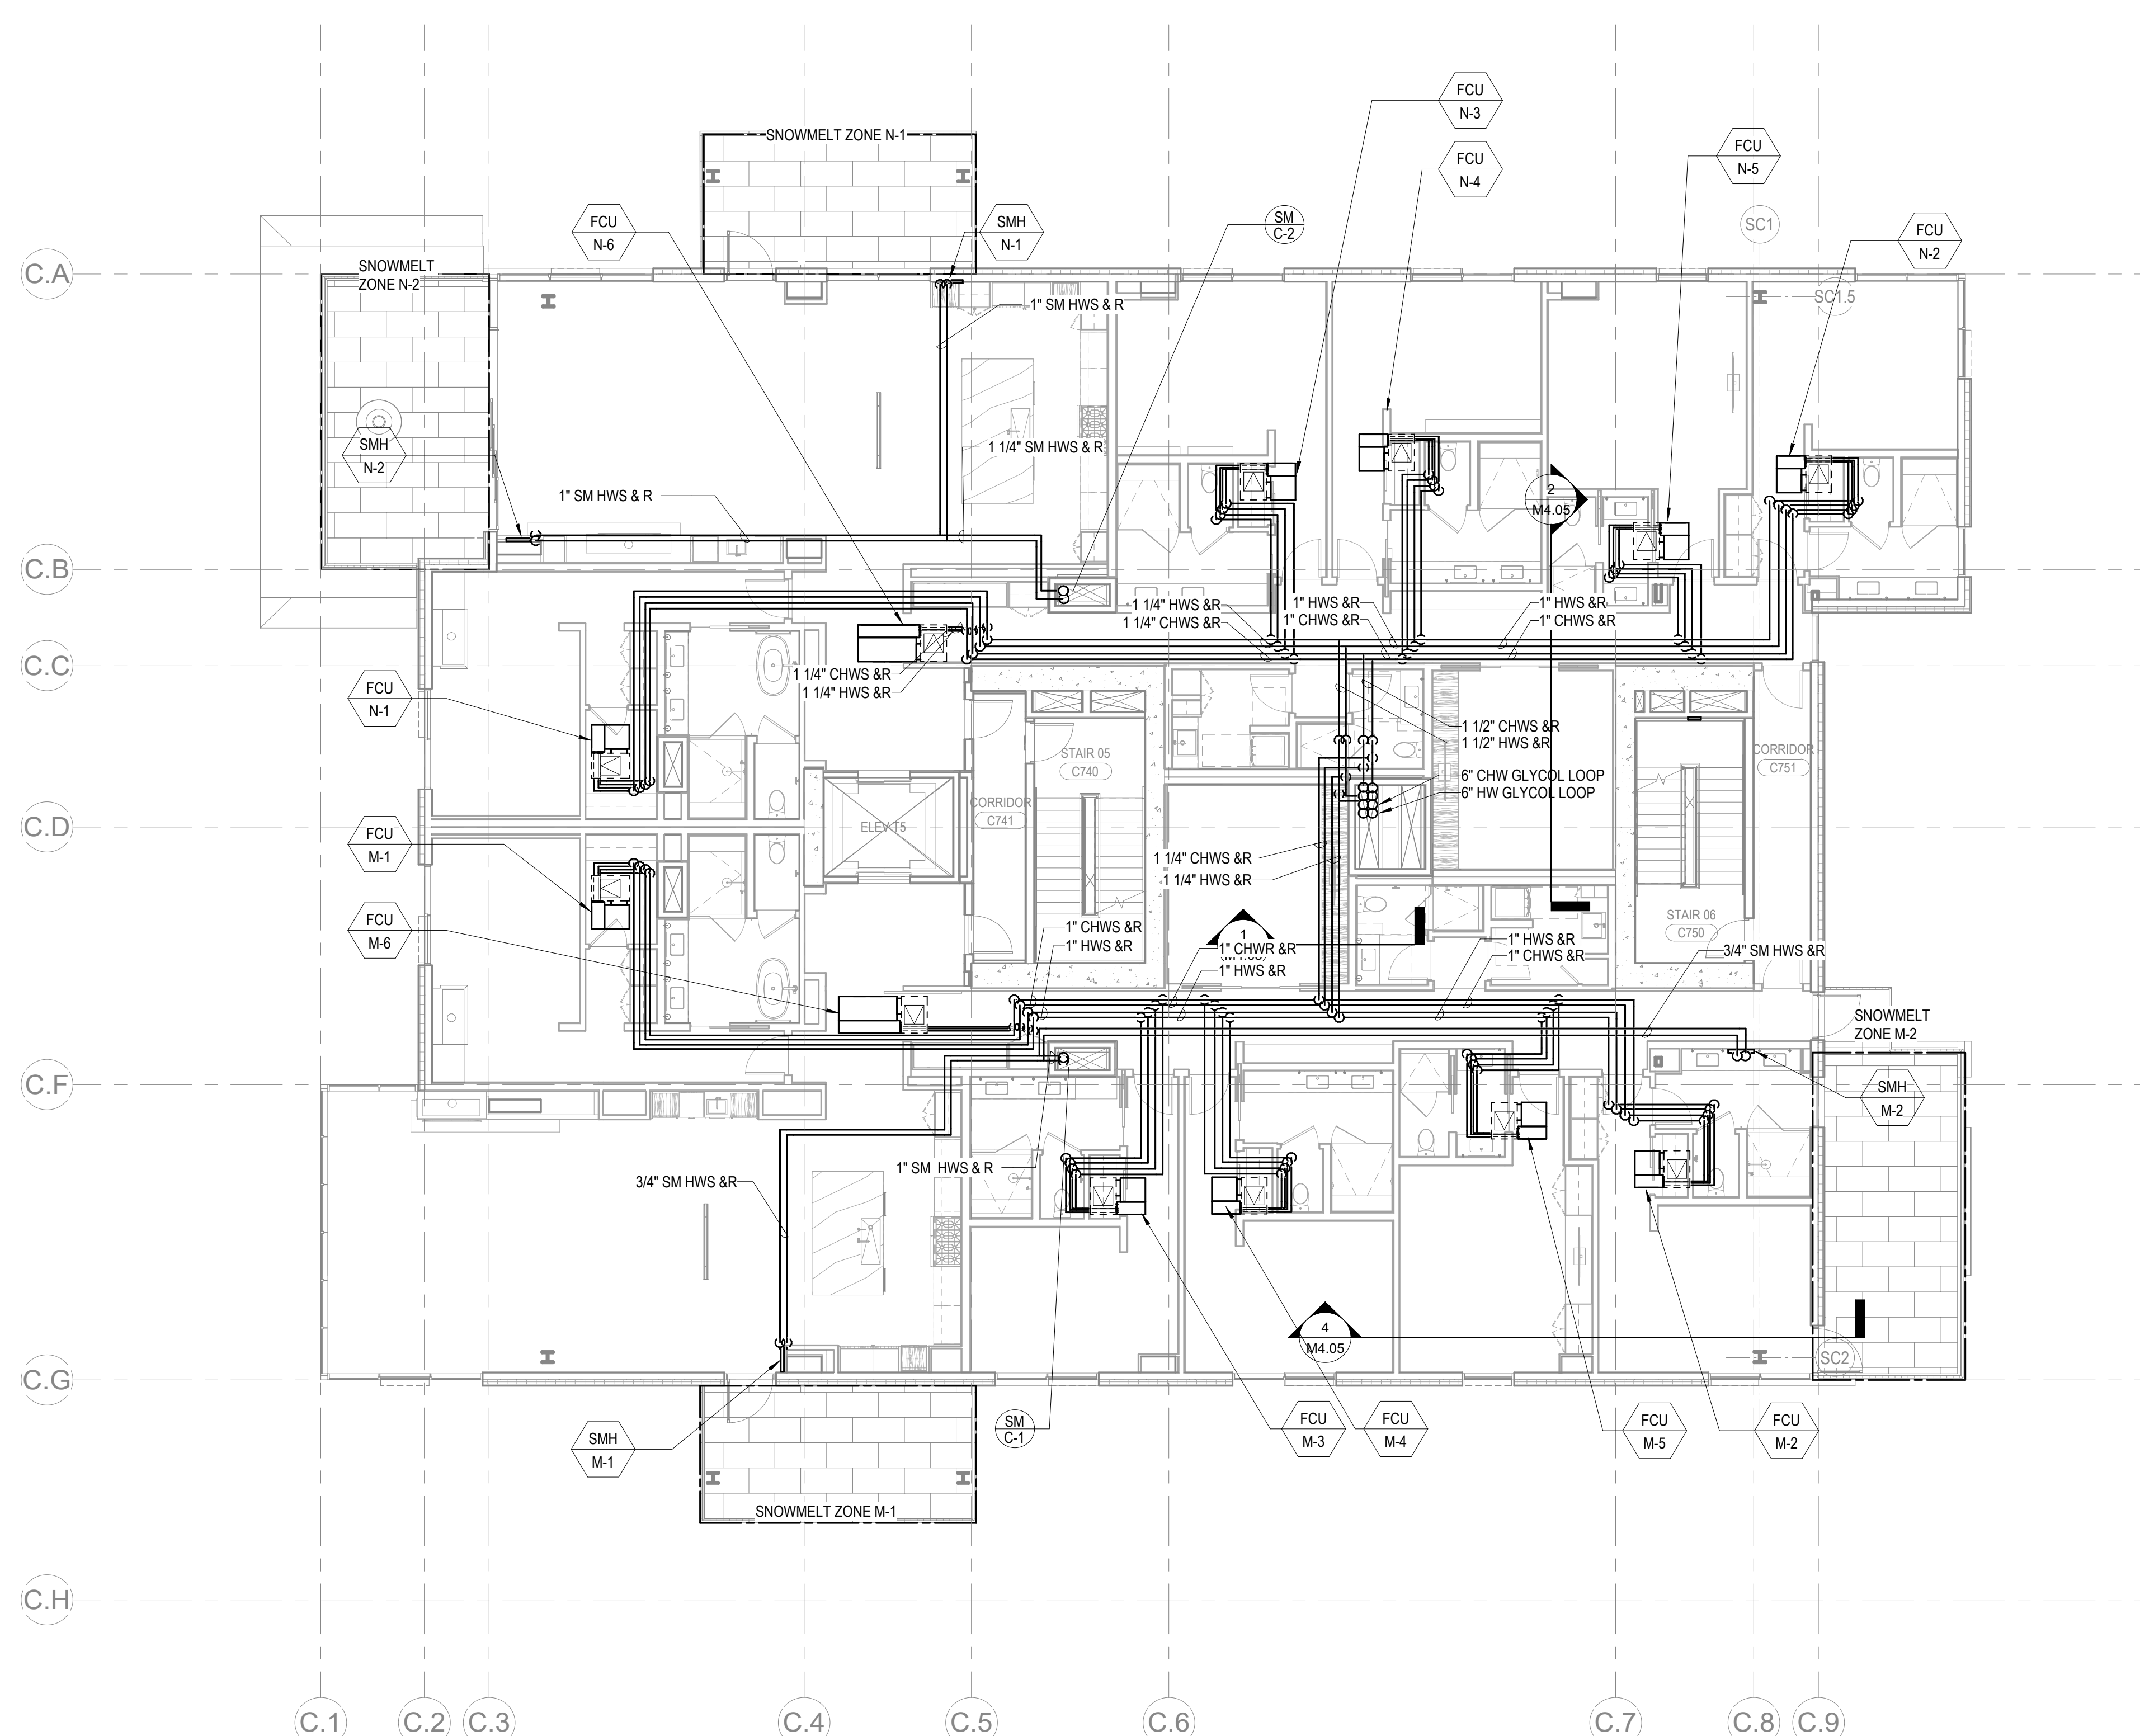

1 TOWER C - LEVEL 7 MECHANICAL PIPING PLAN  
SCALE: 1/8" = 1'-0"

