


Olson Kundig


project: **SOMMET BLANC**
9300 Marsac Ave (B2 East Parcel)
Park City, Utah 84060

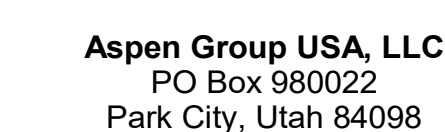

principal architect _____
project manager _____
drawn by _____
checked by Checker
job no. _____
date 05/17/2024

no.	date	to	from	amount	balance
1	1/1/19				
2	1/1/19				
3	1/1/19				
86	1/1/19				

M4.02

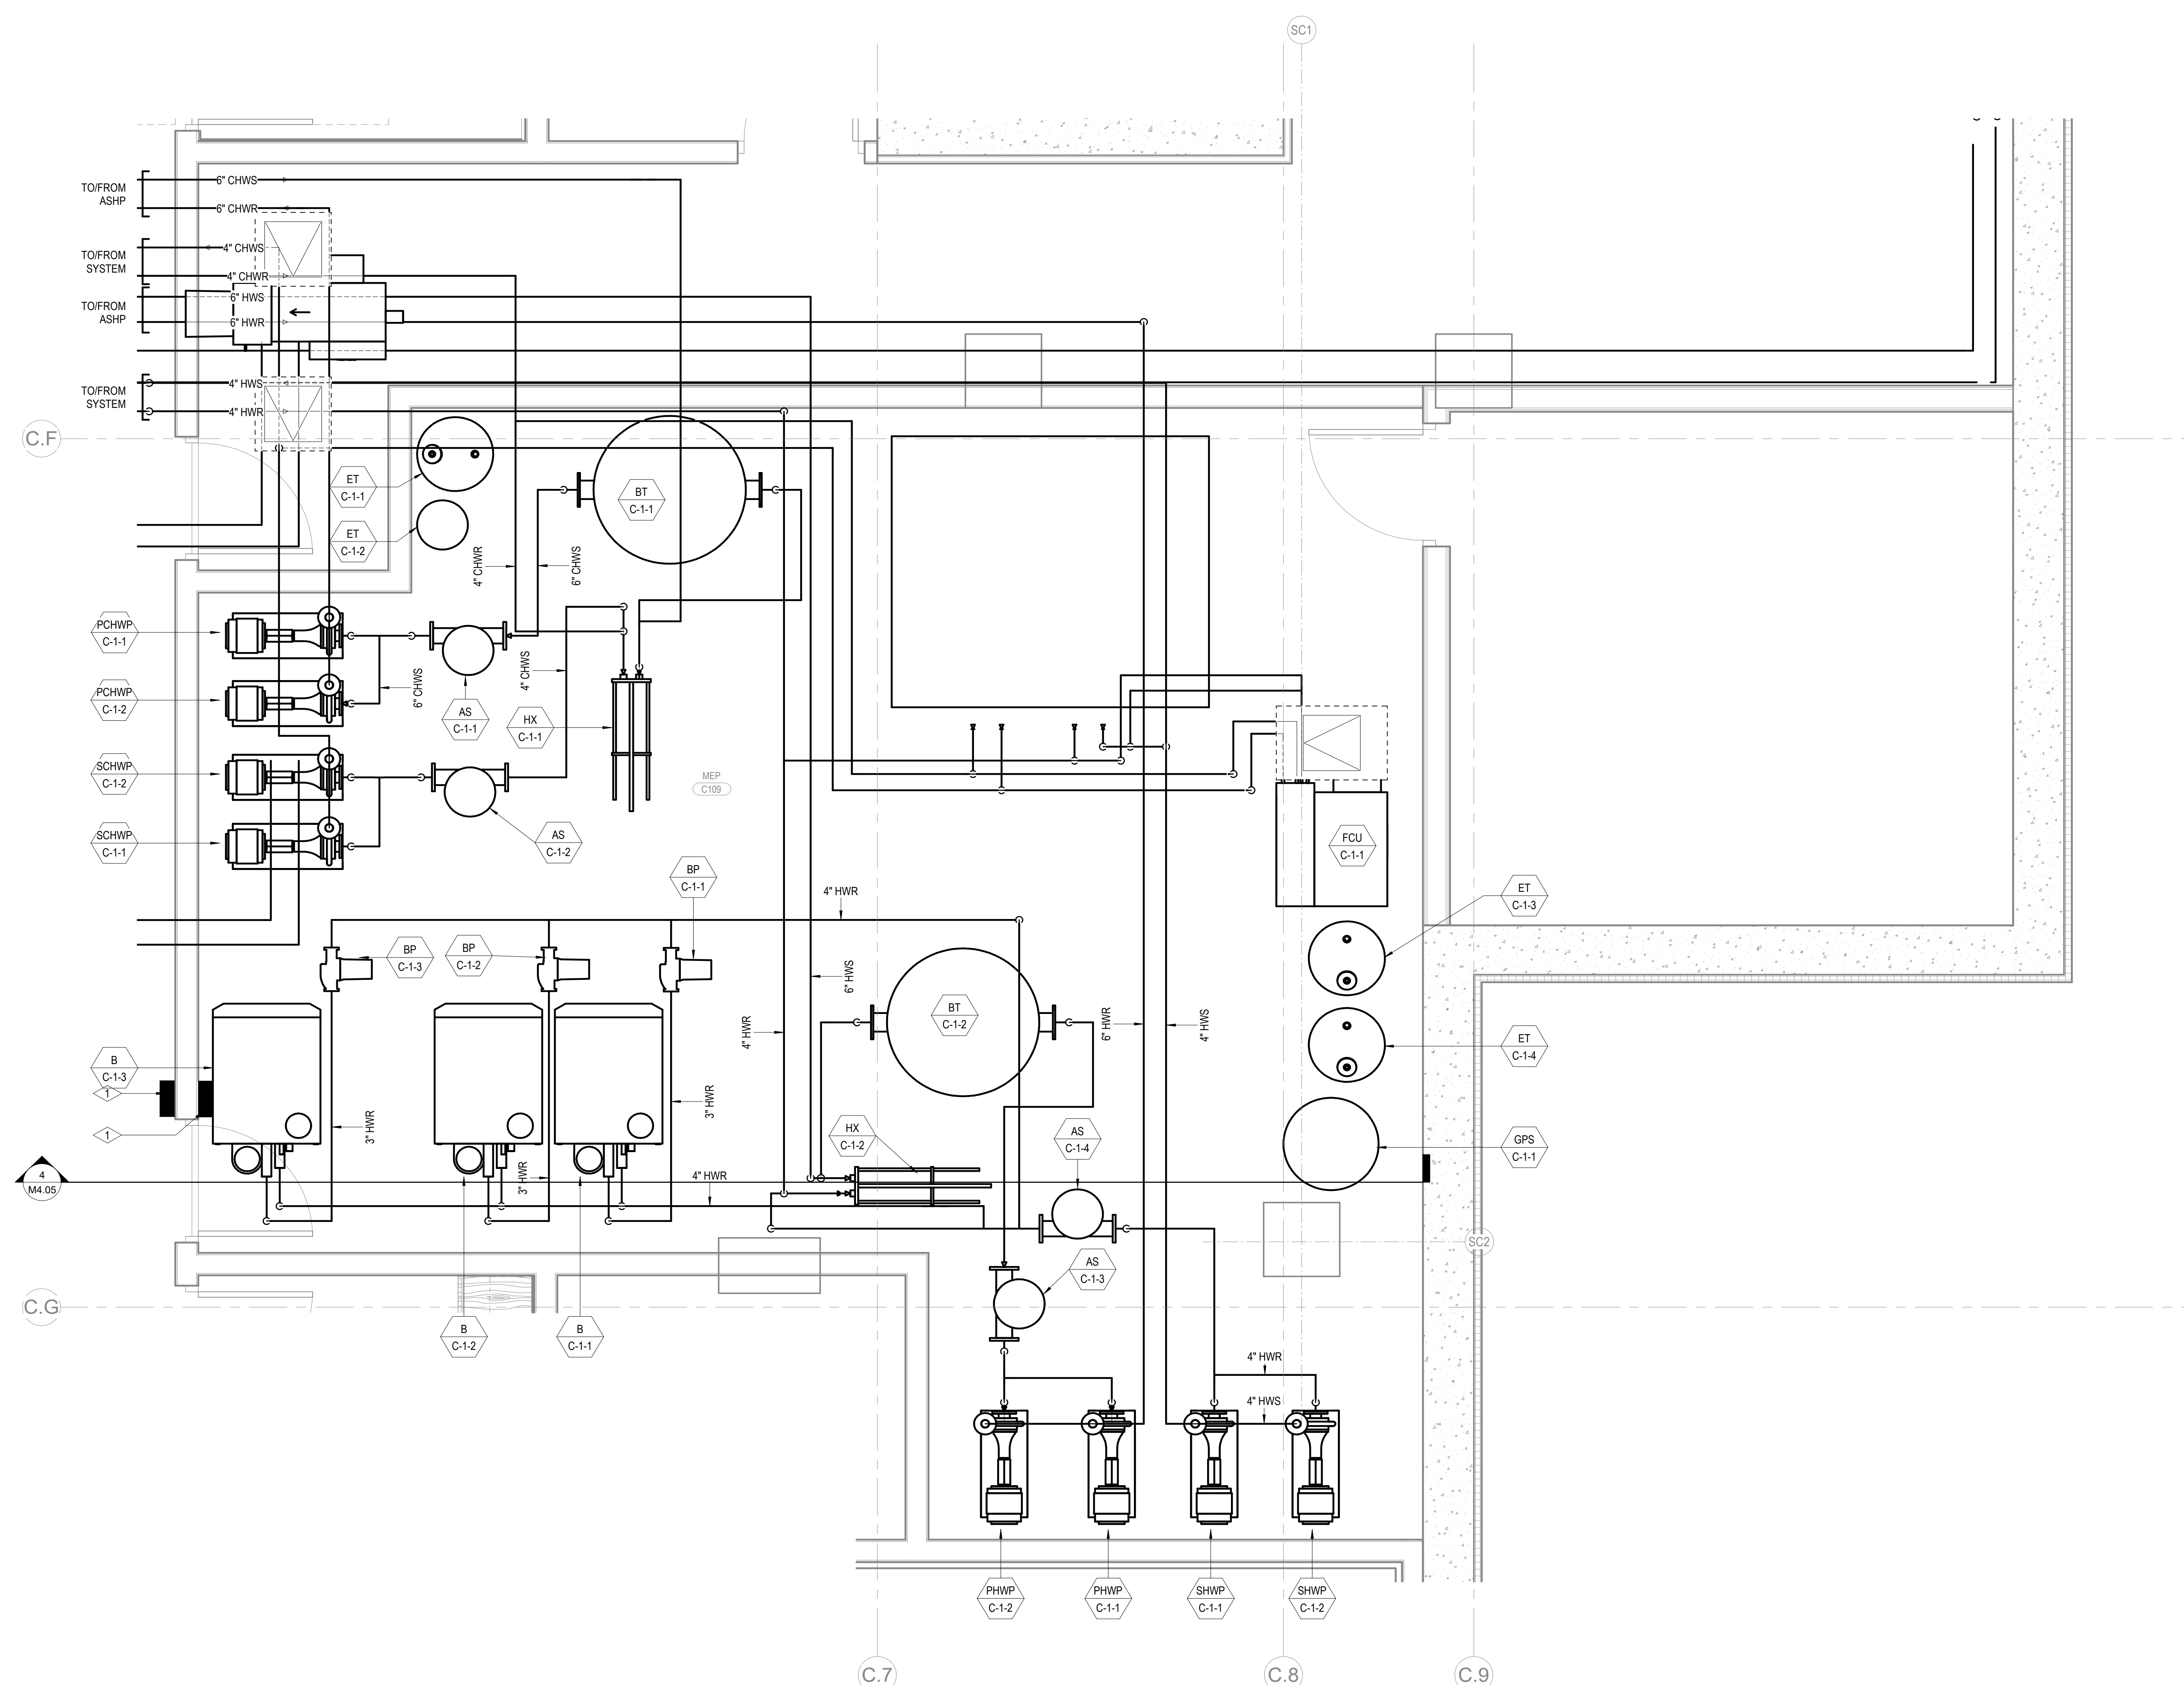

1 TOWER C - LEVEL 1 ENLARGED MECHANICAL PIPING PLAN
SCALE: 1/2" = 1'-0"

IFC Set 2 of 3
05/17/2024

MECHANICAL
ENLARGED PLANS

M4.02