

Reserved for permit stamp

159 South Jackson St, Suite 600
Seattle, Washington 98104 USA
+1 206 624 5670 info@onekindig.com

Olson Kundig

project: **SOMMET BLANC**
3300 Marsac Ave (B2 East Parcel)



Aspen Group USA, LLC
PO Box 980022
Park City, Utah 84098

Pool Consultant
Cloward H20
2696 N University Ave, Suite 290
Provo, UT 84604

Landscape Architect
EPG Design
6949 South High Tech Drive, Suite 100
Midvale, Utah 84047

Specifications Writer
Friday Group
88 Mainelli Road
Milford, CT

Code Consultant
Holmes
600 1st Avenue, Suite 200A
Seattle, WA 98104

Fire Protection Engineer
Jensen Hughes
One Research Drive, Suite 100
Westborough, MA 01581

Vertical Transportation Consultant
Lorch Bates
19515 North Creek Parkway, Suite 100
Bothell, WA 98011

Structural Engineer
Magnusson Klemencic Associates
1301 5th Ave., Suite 3200
Seattle, WA 98101

Lighting Designer
O-
1319 SE MLK Blvd, Suite 210
Portland, Oregon 97219

Building Envelope Consultants
RDH
2101 N 34th St
Seattle, WA 98103

Accessibility Consultant
Studio Pacifica
2144 Westlake Ave N, Suite F
Seattle, WA 98109

MEP Engineer
WSP USA
1001 Fourth Ave., Suite 310
Seattle, WA 98154


principal architect _____
project manager _____
drawn by _____
checked by Checker
job no. _____
date 5/17/2024

no.	date	t
-----	------	---


IFC Set 2 of 3
5/17/2024

MECHANICAL DETAILS


M5.02

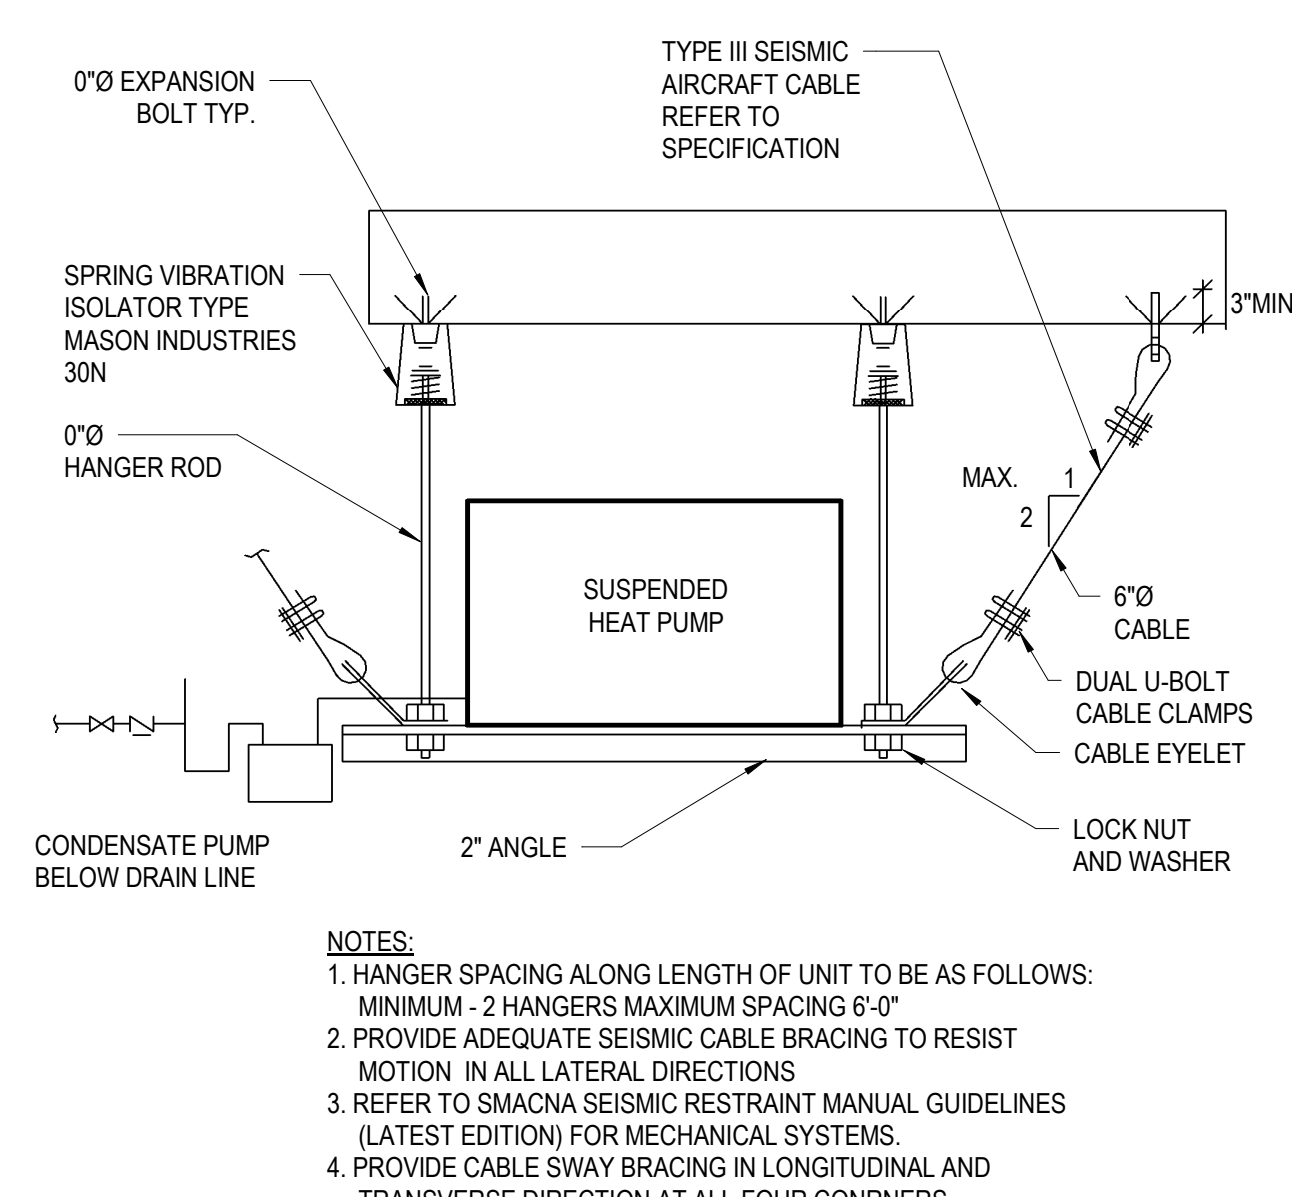



9 SUSPENDED EQUIPMENT WITH SEISMIC CABLES - A

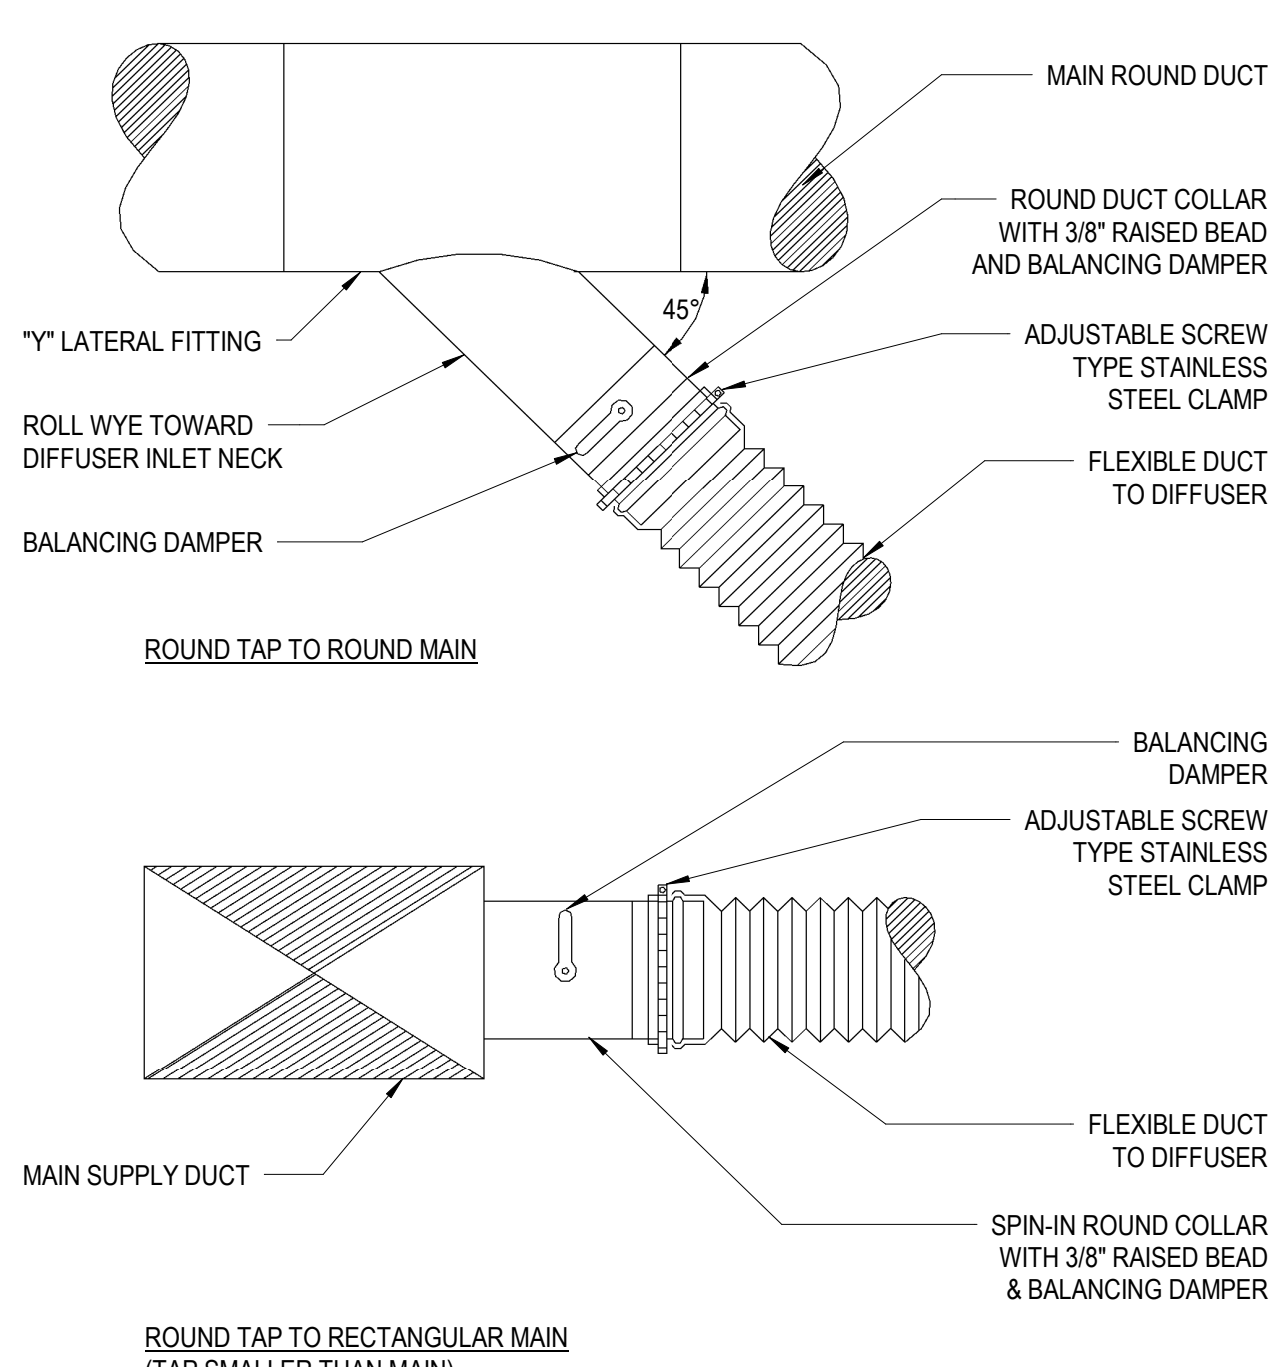



6 LOW PRESSURE BRANCH DUCT CONNECTIONS
SCALE: NTS

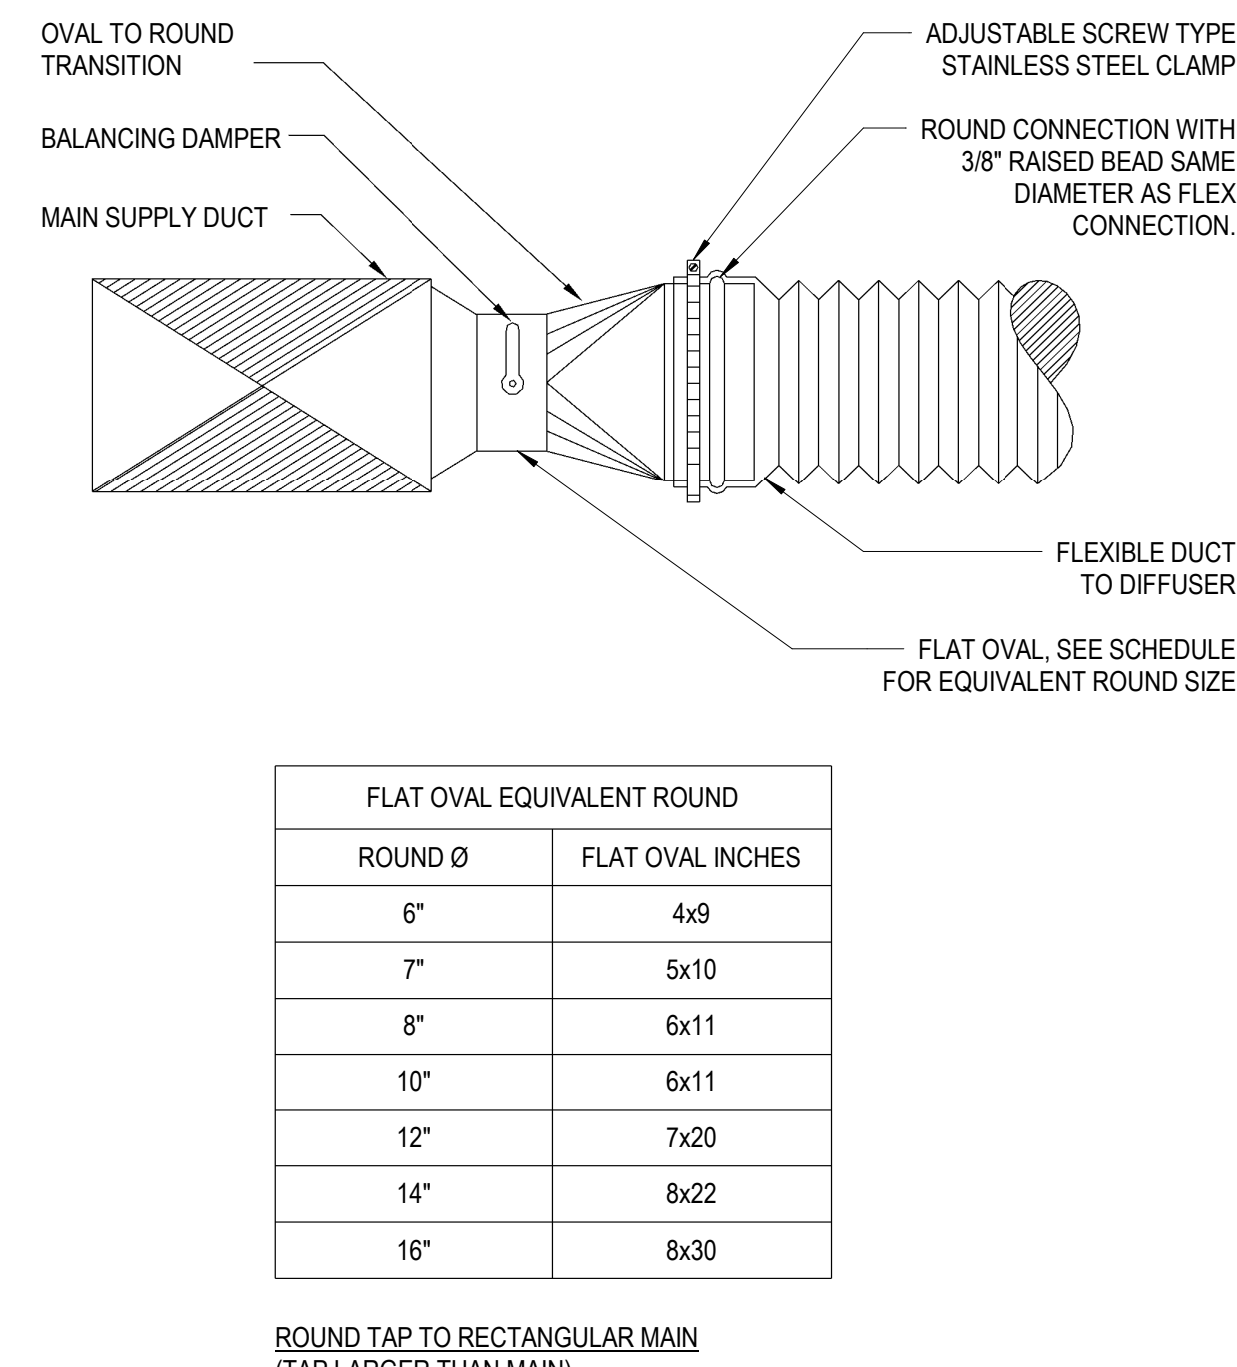


3 BOILER CONNECTION DETAIL

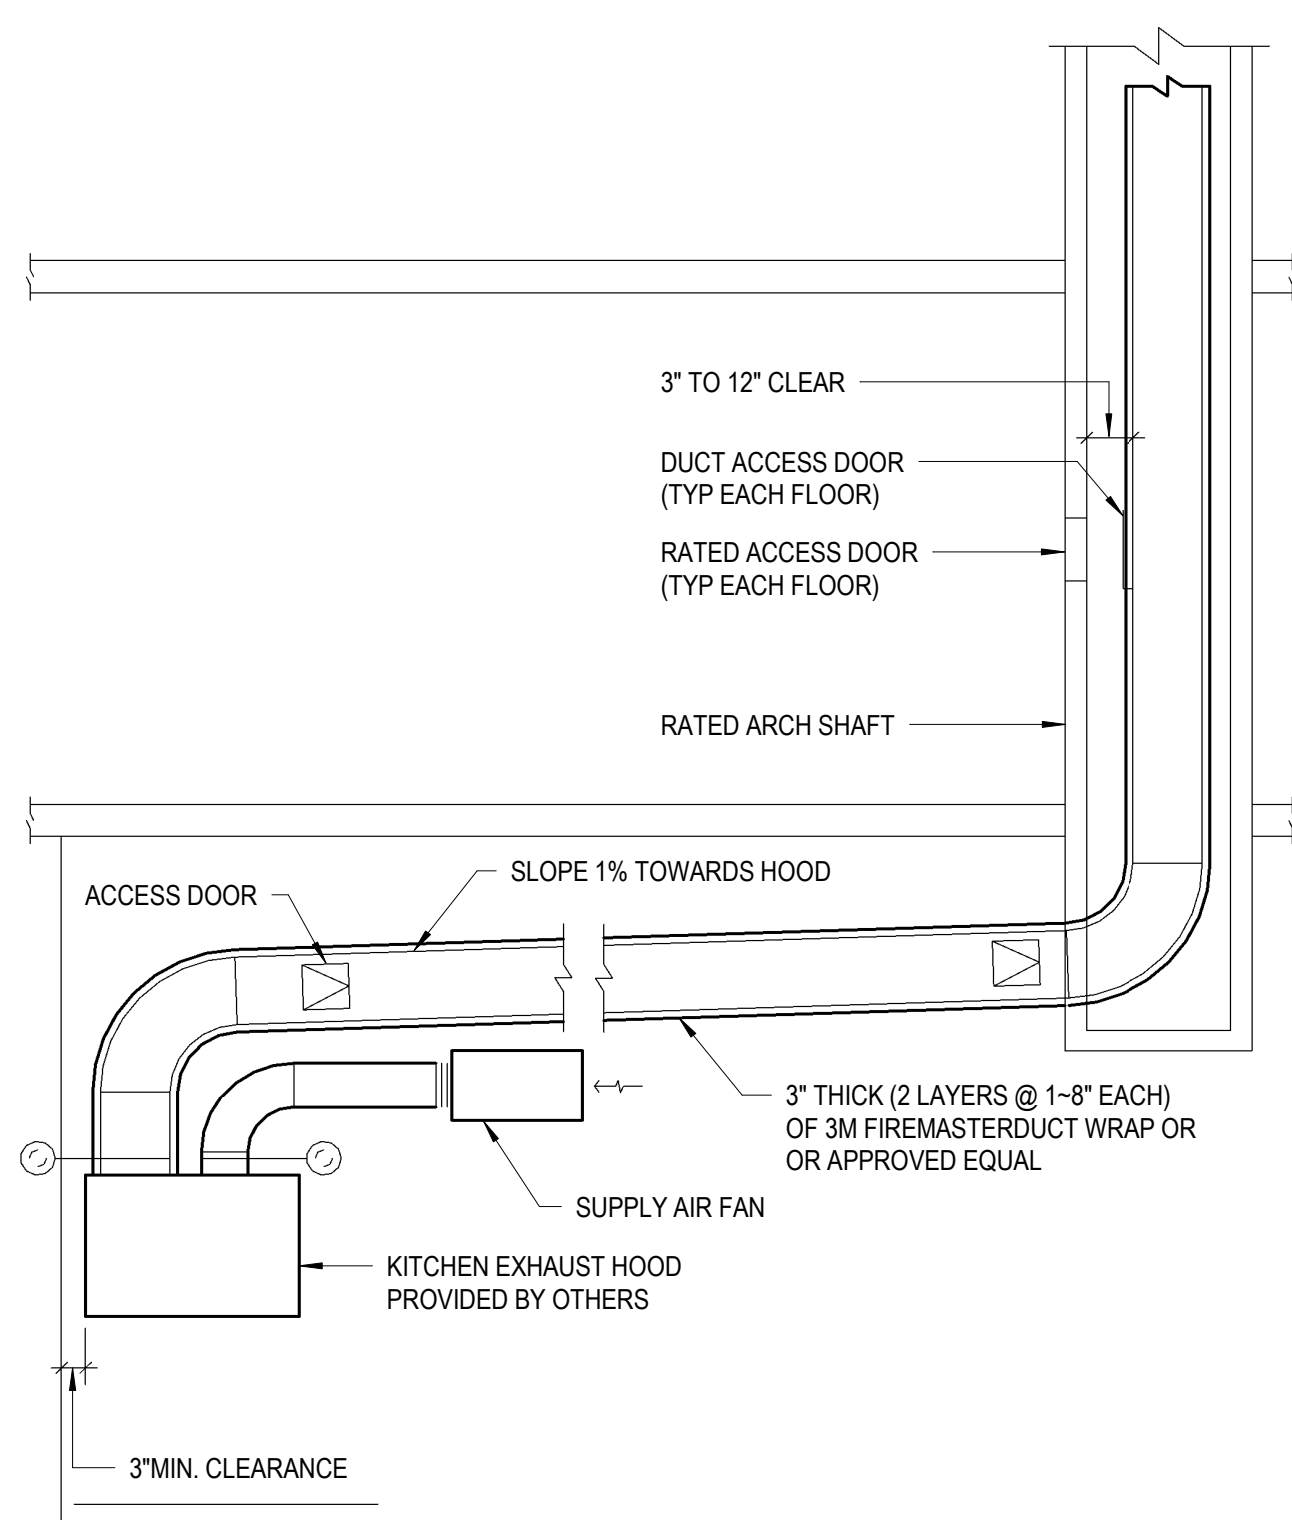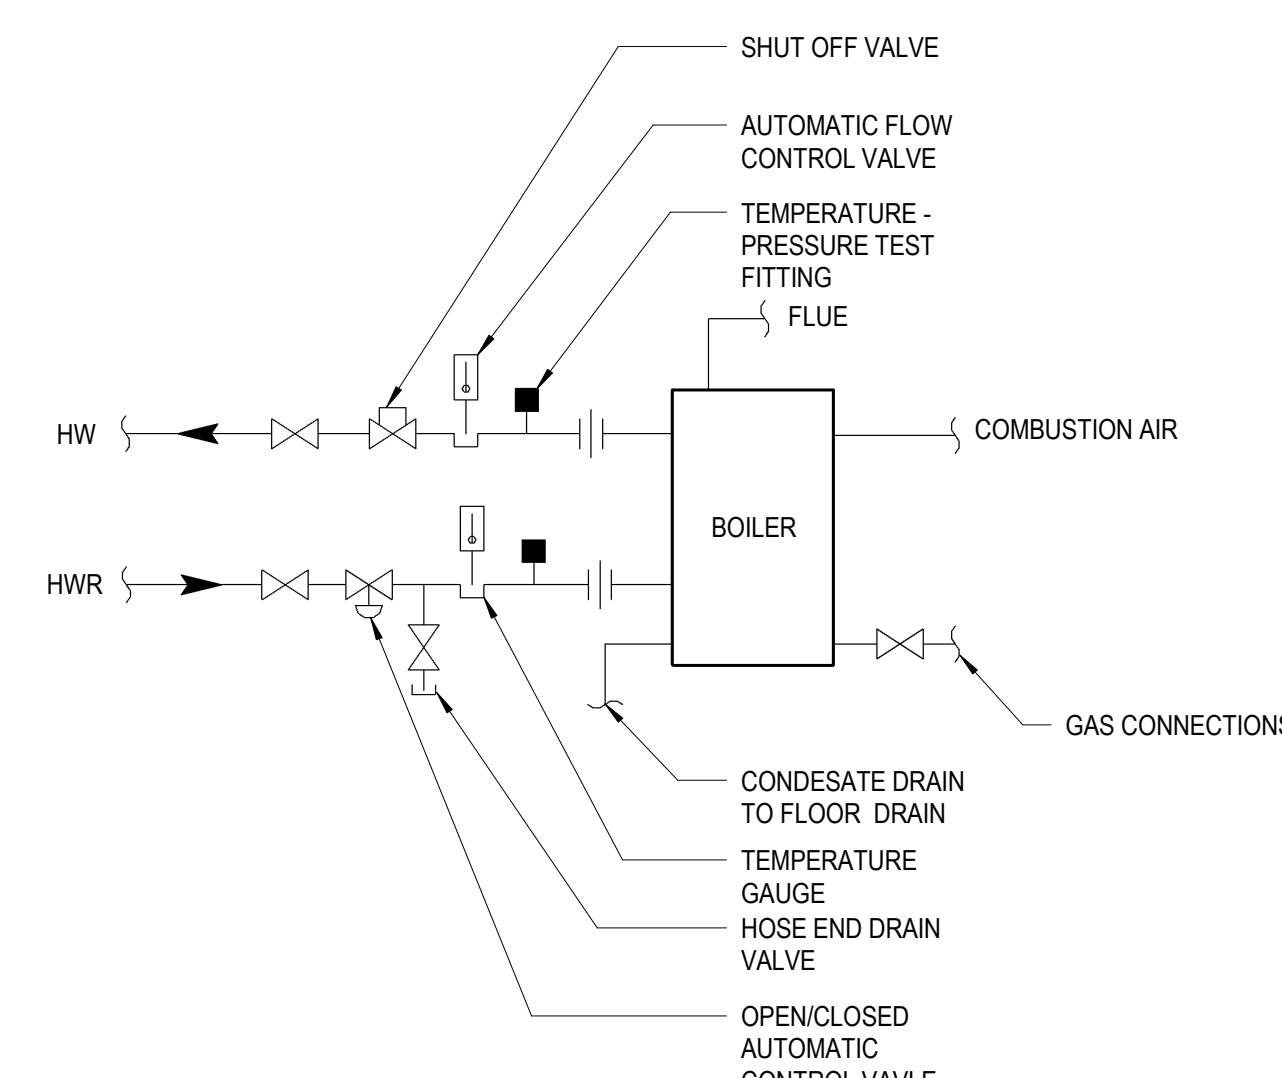


8 KITCHEN HOOD EXHAUST RISER DETAIL
SCALE: NTS

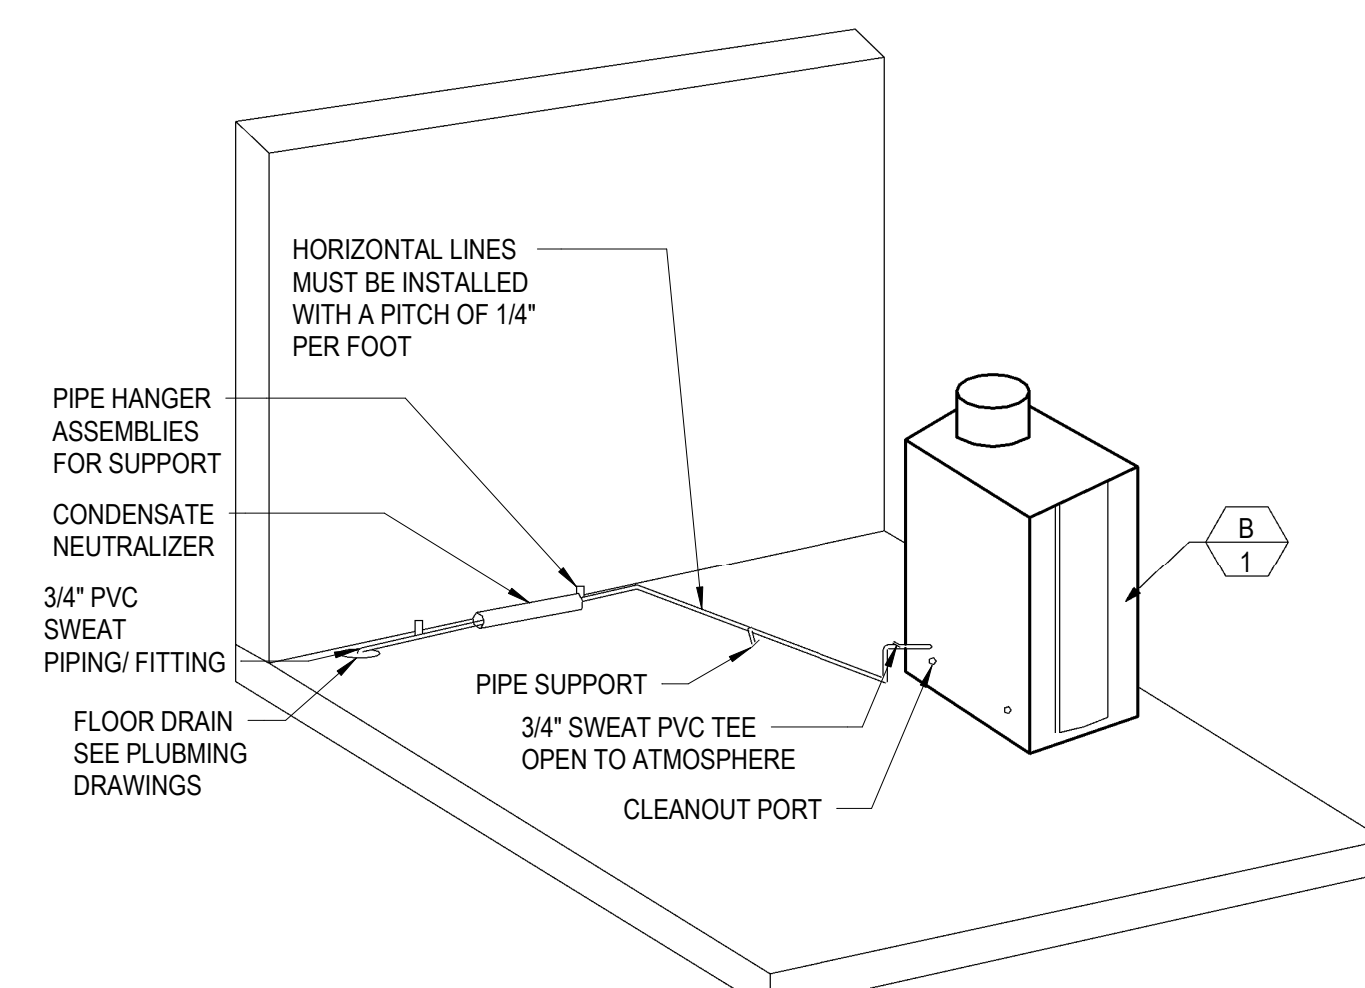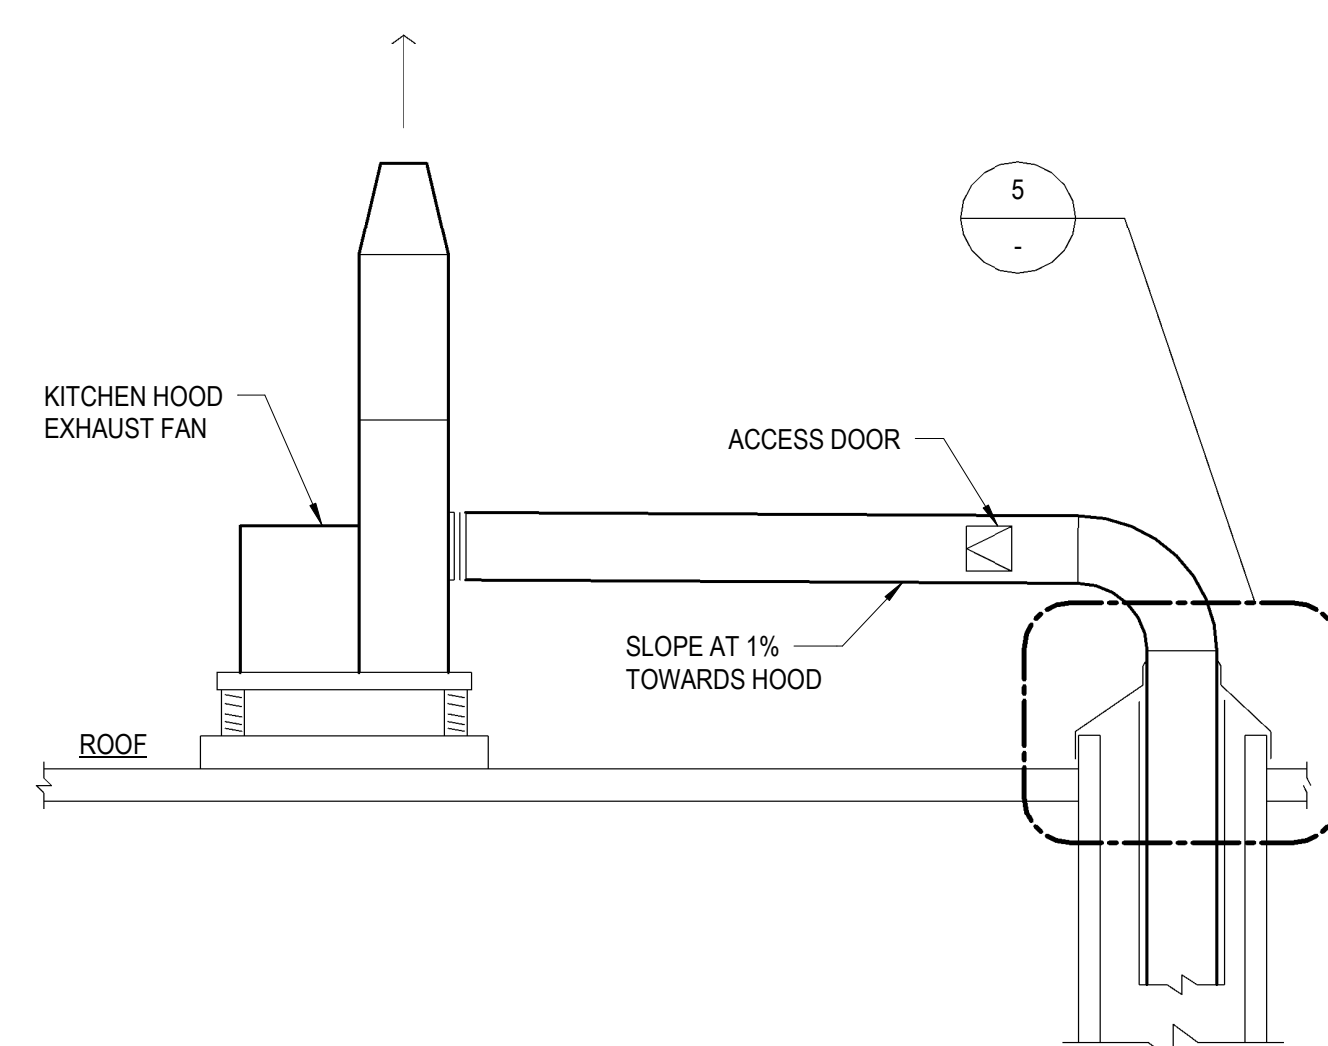


5 BOILER CONDENSATE DRAIN DETAIL
SCALE: NTS

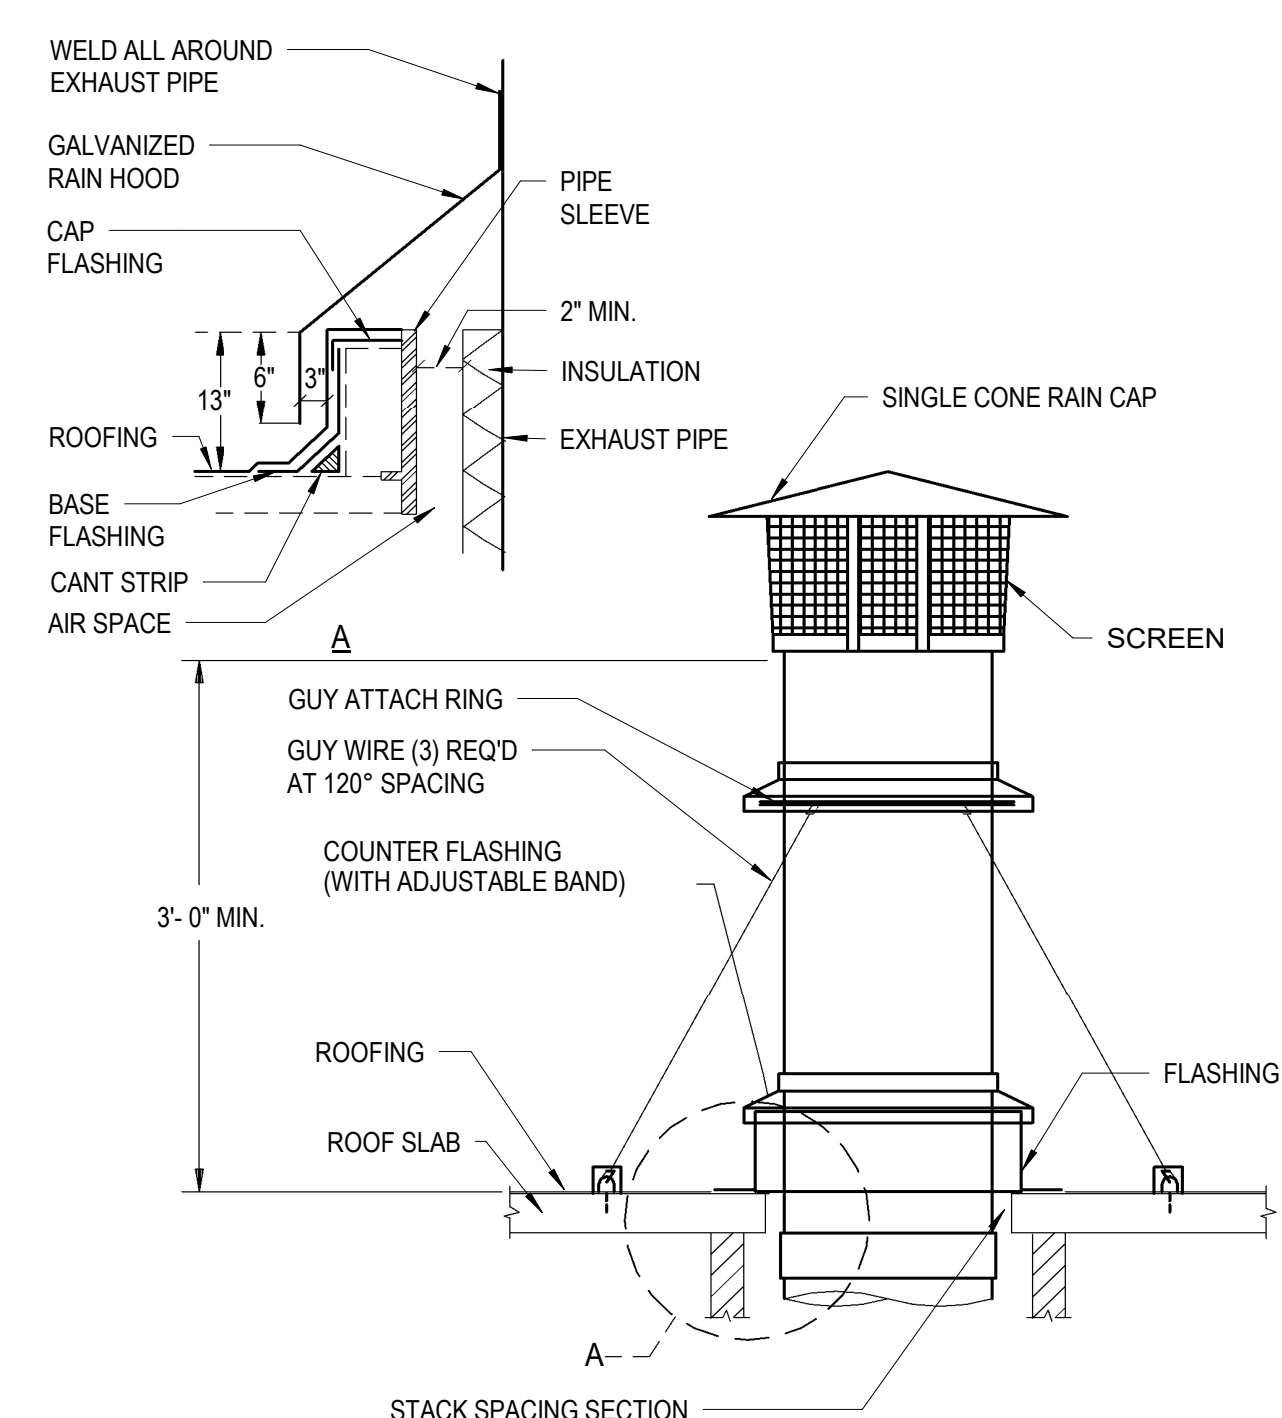


2 CONDENSING BOILER FLUE THRU ROOF
SCALE: NTS

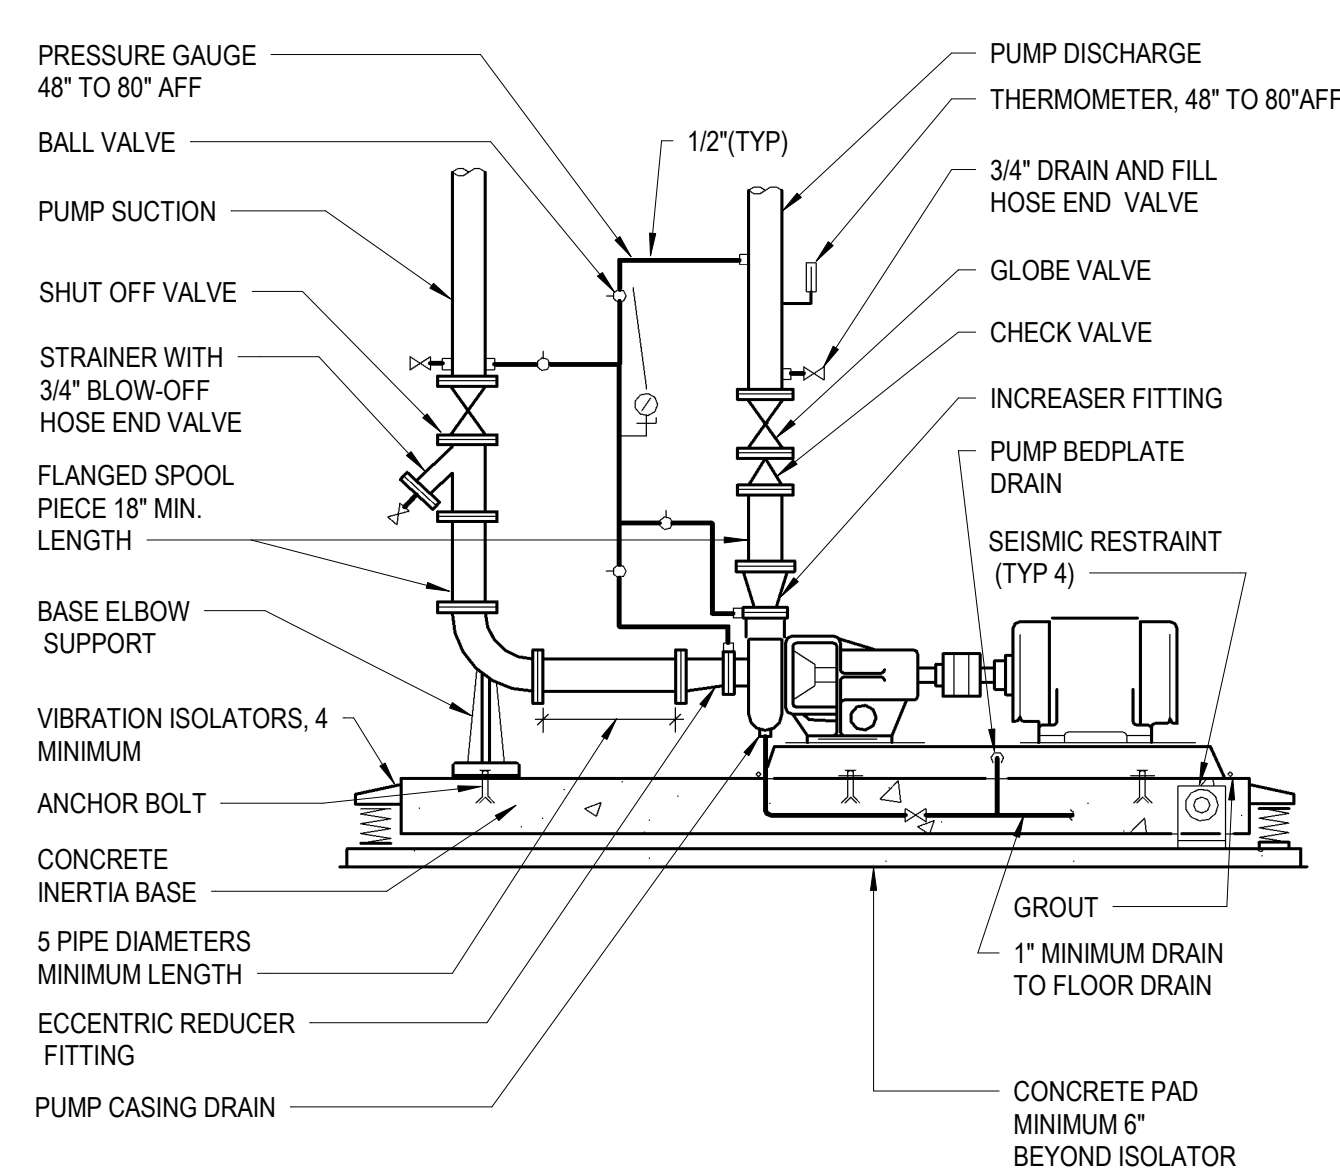


7 END SUCTION PUMP
SCALE: NTS

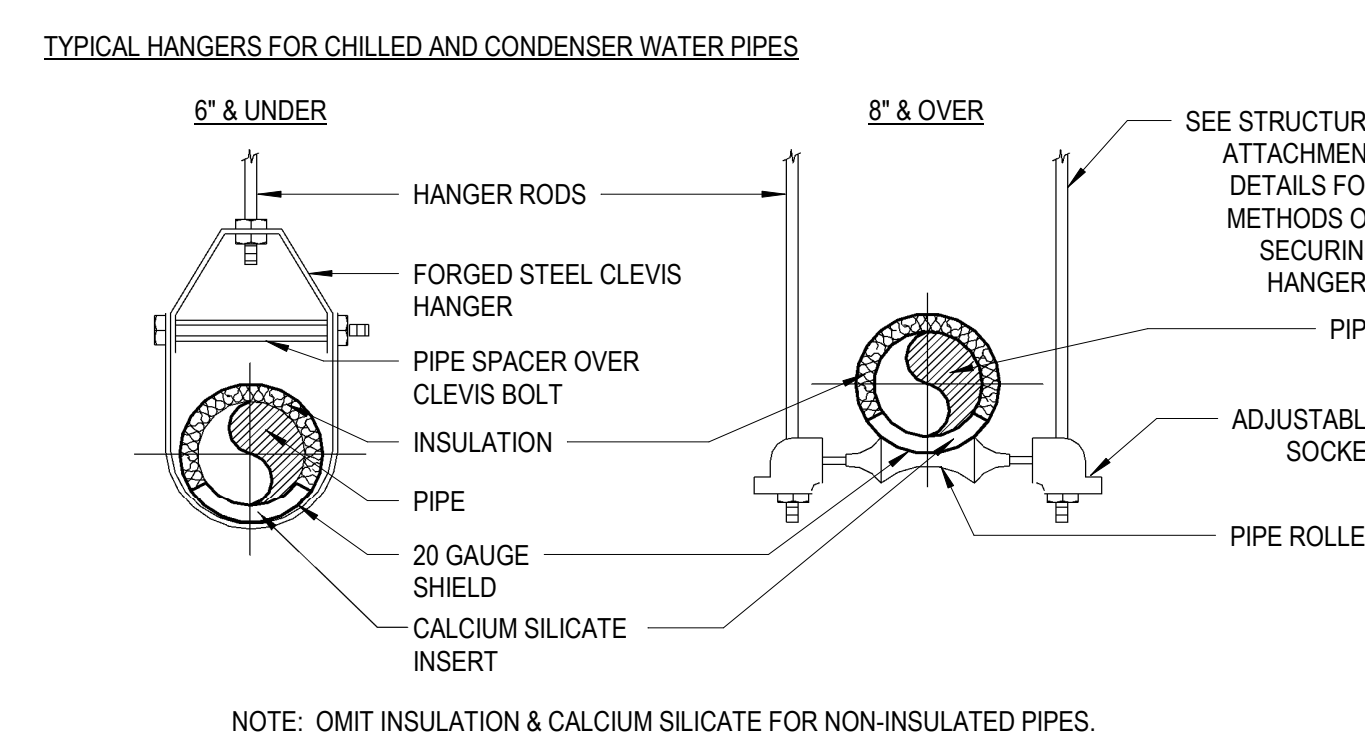

TYPICAL HANGERS FOR HOT WATER PIPE

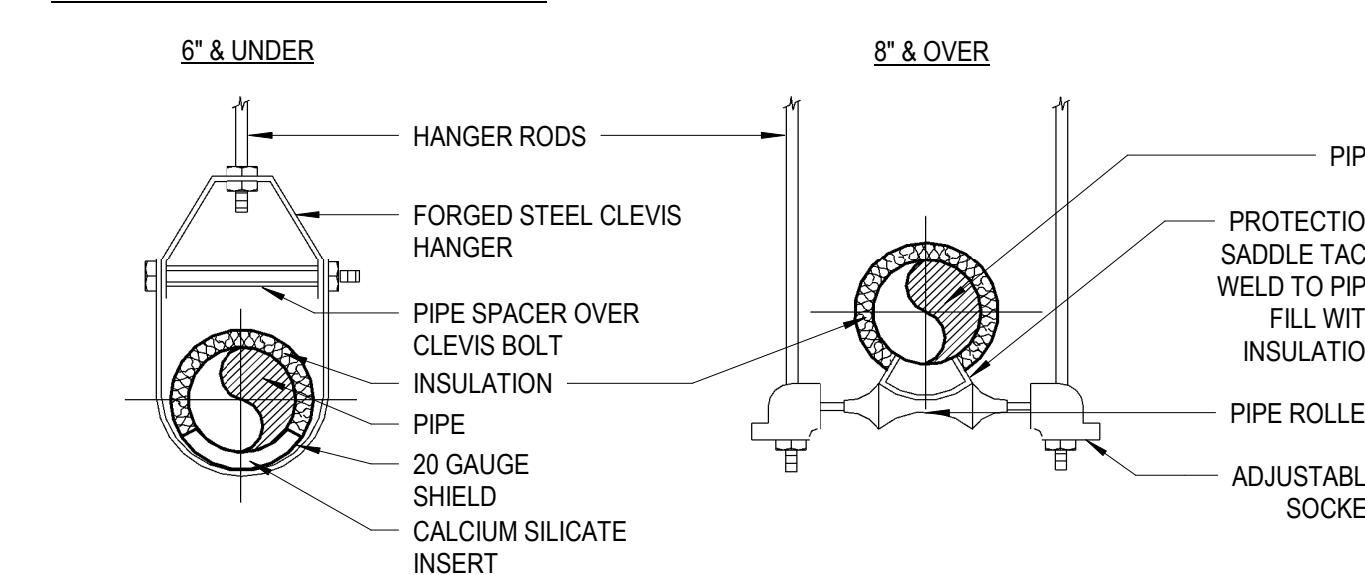

4 HOT AND CHILLED WATER PIPE HANGER SINGLE PIPE
SCALE: NTS

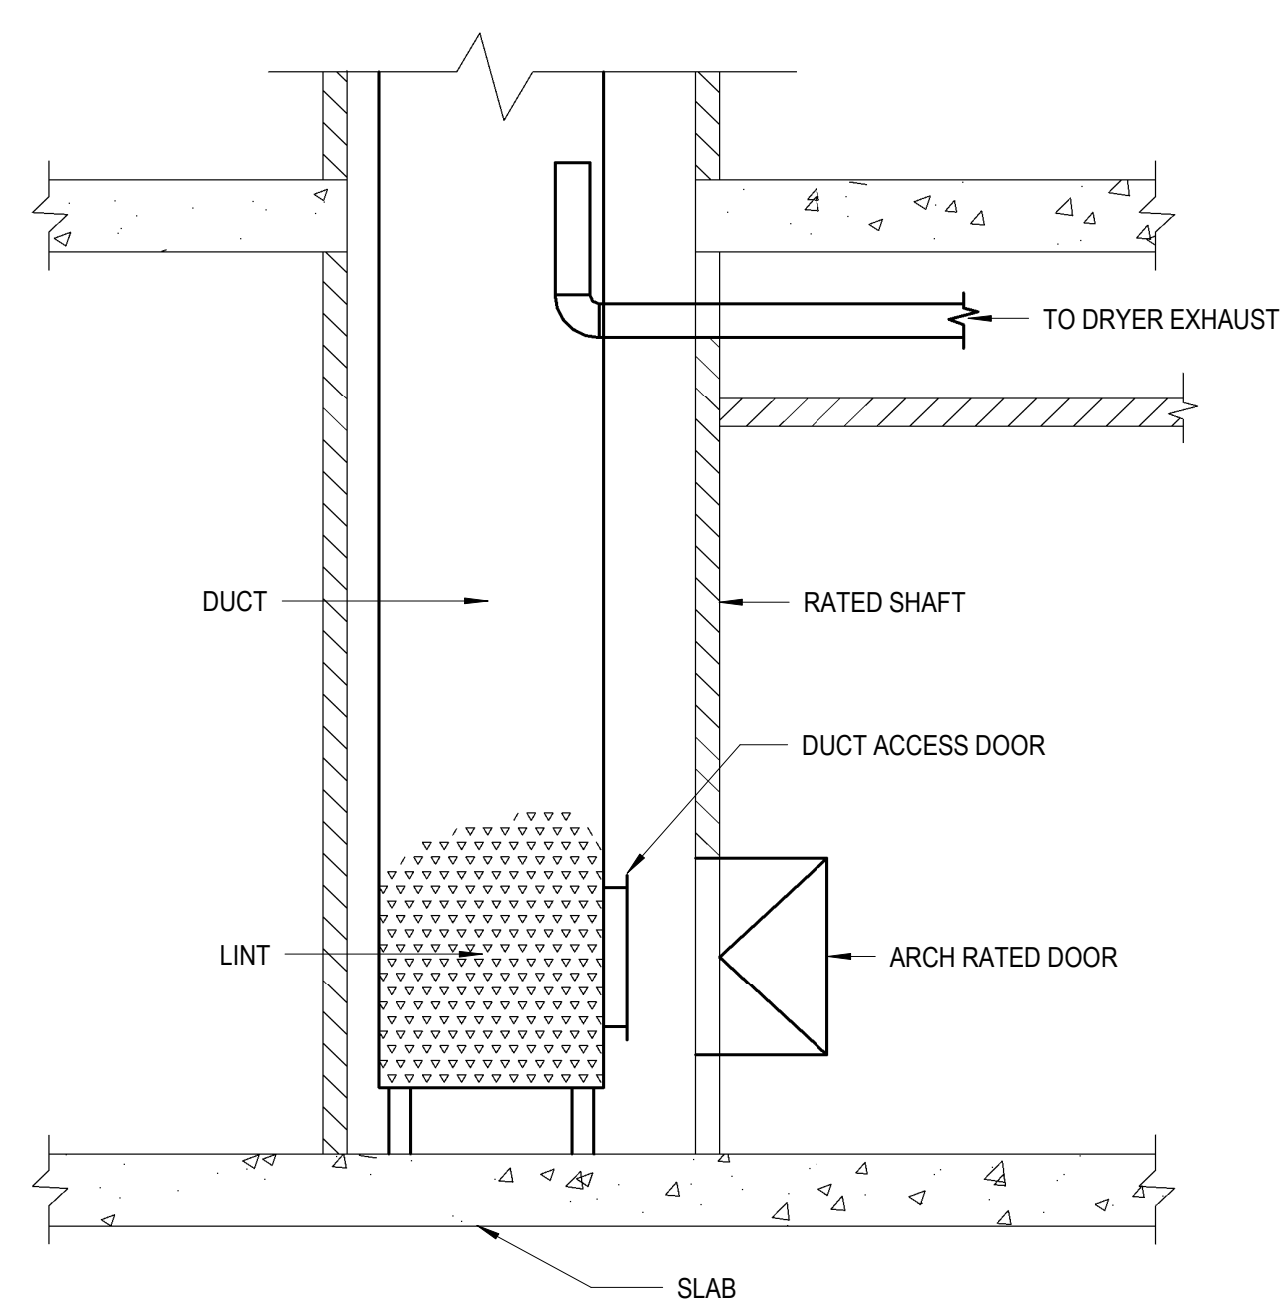

1 DRYER EXHAUST LINT TRAP
SCALE: NTS