


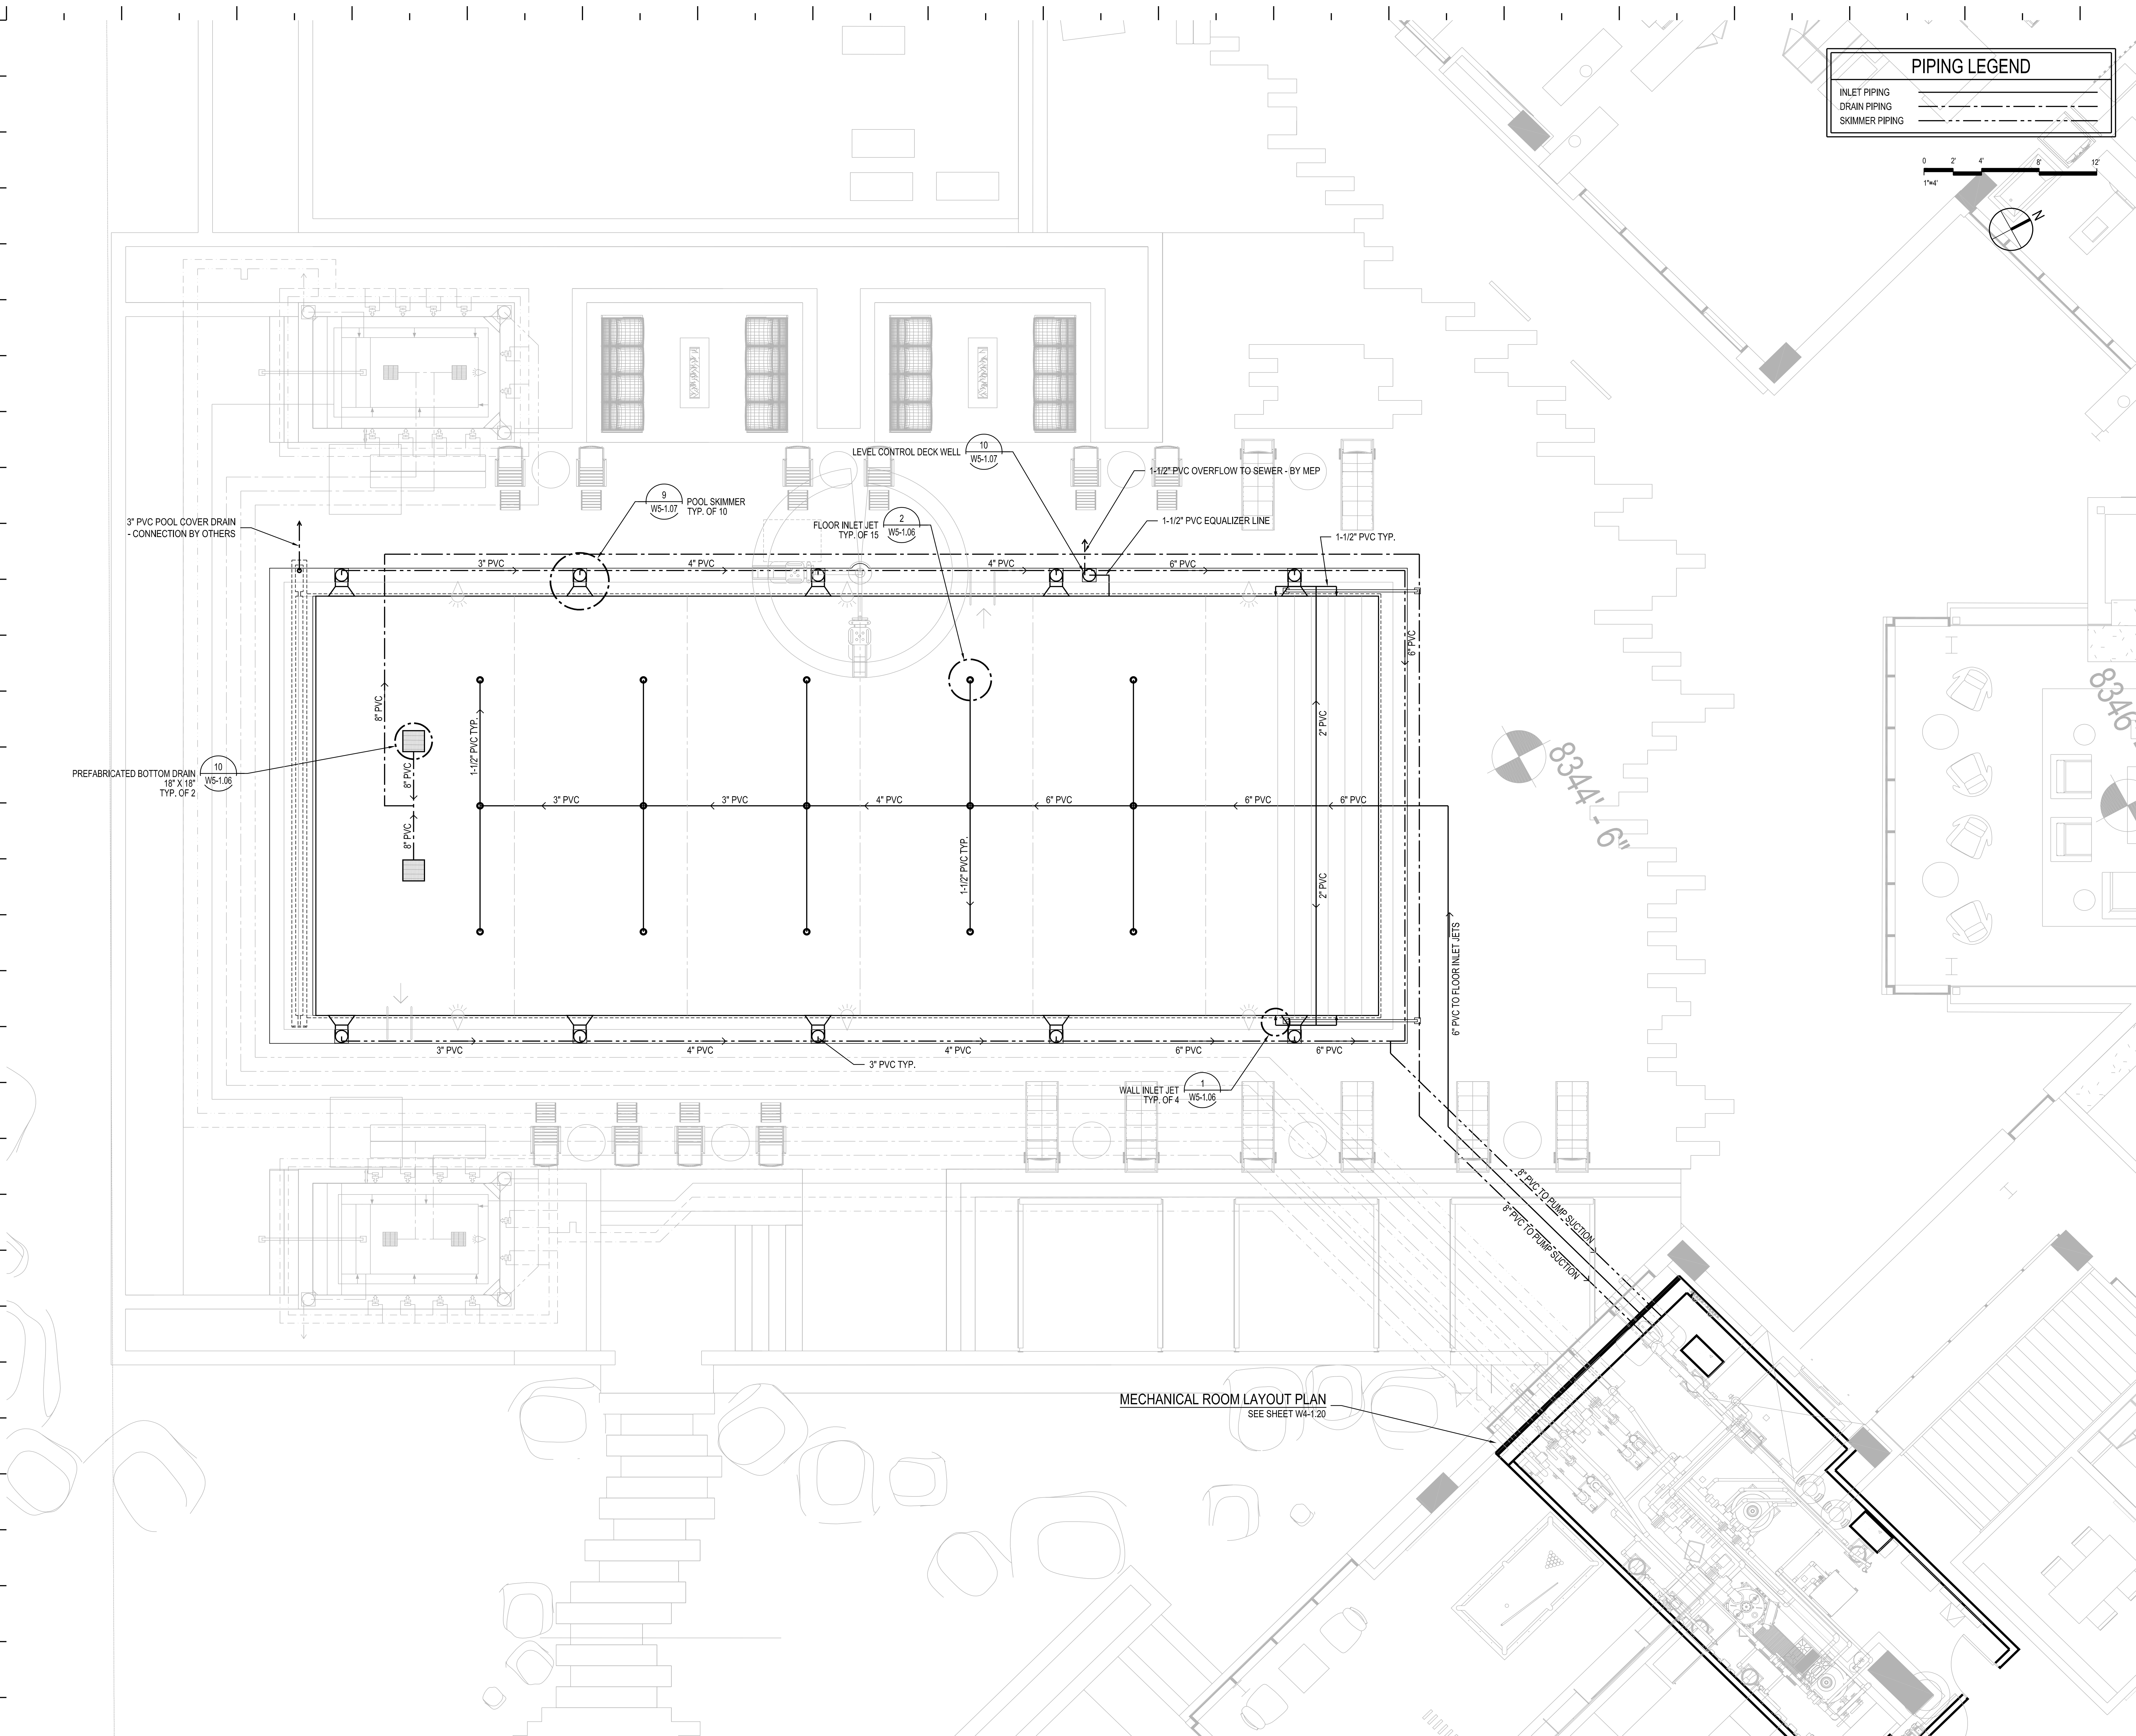

PIPING LEGEND	
INLET PIPING	---
DRAIN PIPING	---
SKIMMER PIPING	---



 
MECHANICAL ROOM LAYOUT PLAN
SEE SHEET W4-1.20



Reserved for permit stamp
159 South Jackson St. Suite 400
Seattle, Washington 98104 USA
P: 206.461.9170 o.kundig.com

Olson Kundig

PROJECT
PROJECT NAME : SOMMET BLANC
PROJECT ADDRESS



White Summit Development, LLC
PO Box 980022
Park City, Utah 84098

Acoustic Consultant
BRC Acoustics
1332 1st Ave. Suite 620
Seattle, WA 98101

Cloward H&O
ARCHITECTS
1000 1st Avenue, Suite 1000
Seattle, WA 98101

Landscape Architect
EPD Design
5949 South High Tech Drive, Suite 100
Midvale, Utah 84047

Specifications Writer
Friday Group
55 Main Street
Middlebury, VT

Code Consultant
Holmes
600 1st Avenue, Suite 200A
Seattle, WA 98104

Fire Protection Engineer
Jensen Hughes
One Research Drive, Suite 305C
Westborough, MA 01501

Vertical Transportation Consultant
Lynch Bates
19515 North Creek Parkway, Suite 304
Solihull, WA 90011

Structural Engineer
Magnusson Karmach Associates
1301 5th Ave. Suite 3200
Seattle, WA 98101

Lighting Designer
D
1319 SE MLK Blvd. Suite 210
Portland, Oregon 97219

Building Envelope Consultant
RDH
2101 N 34th St
Seattle, WA 98103

Accessibility Consultant
Studio Pacifica
2144 Westlake Ave N, Suite F
Seattle, WA 98109

MEP Engineer
WSP USA
1001 Fourth Ave., Suite 3100
Seattle, WA 98154

principal architect: CHD
project manager: CHD
drawn by: CHD
checked by: CHD
job no.: XXXXX
date: 05/17/2024

revisions:

DRAWING STATUS

IFC SET 2 OF 3

05/17/2024

POOL SITE
PIPING PLAN

W1-1.02