



① PLC-0C1 DIGITAL INPUTS SCALE: SCHEMATIC

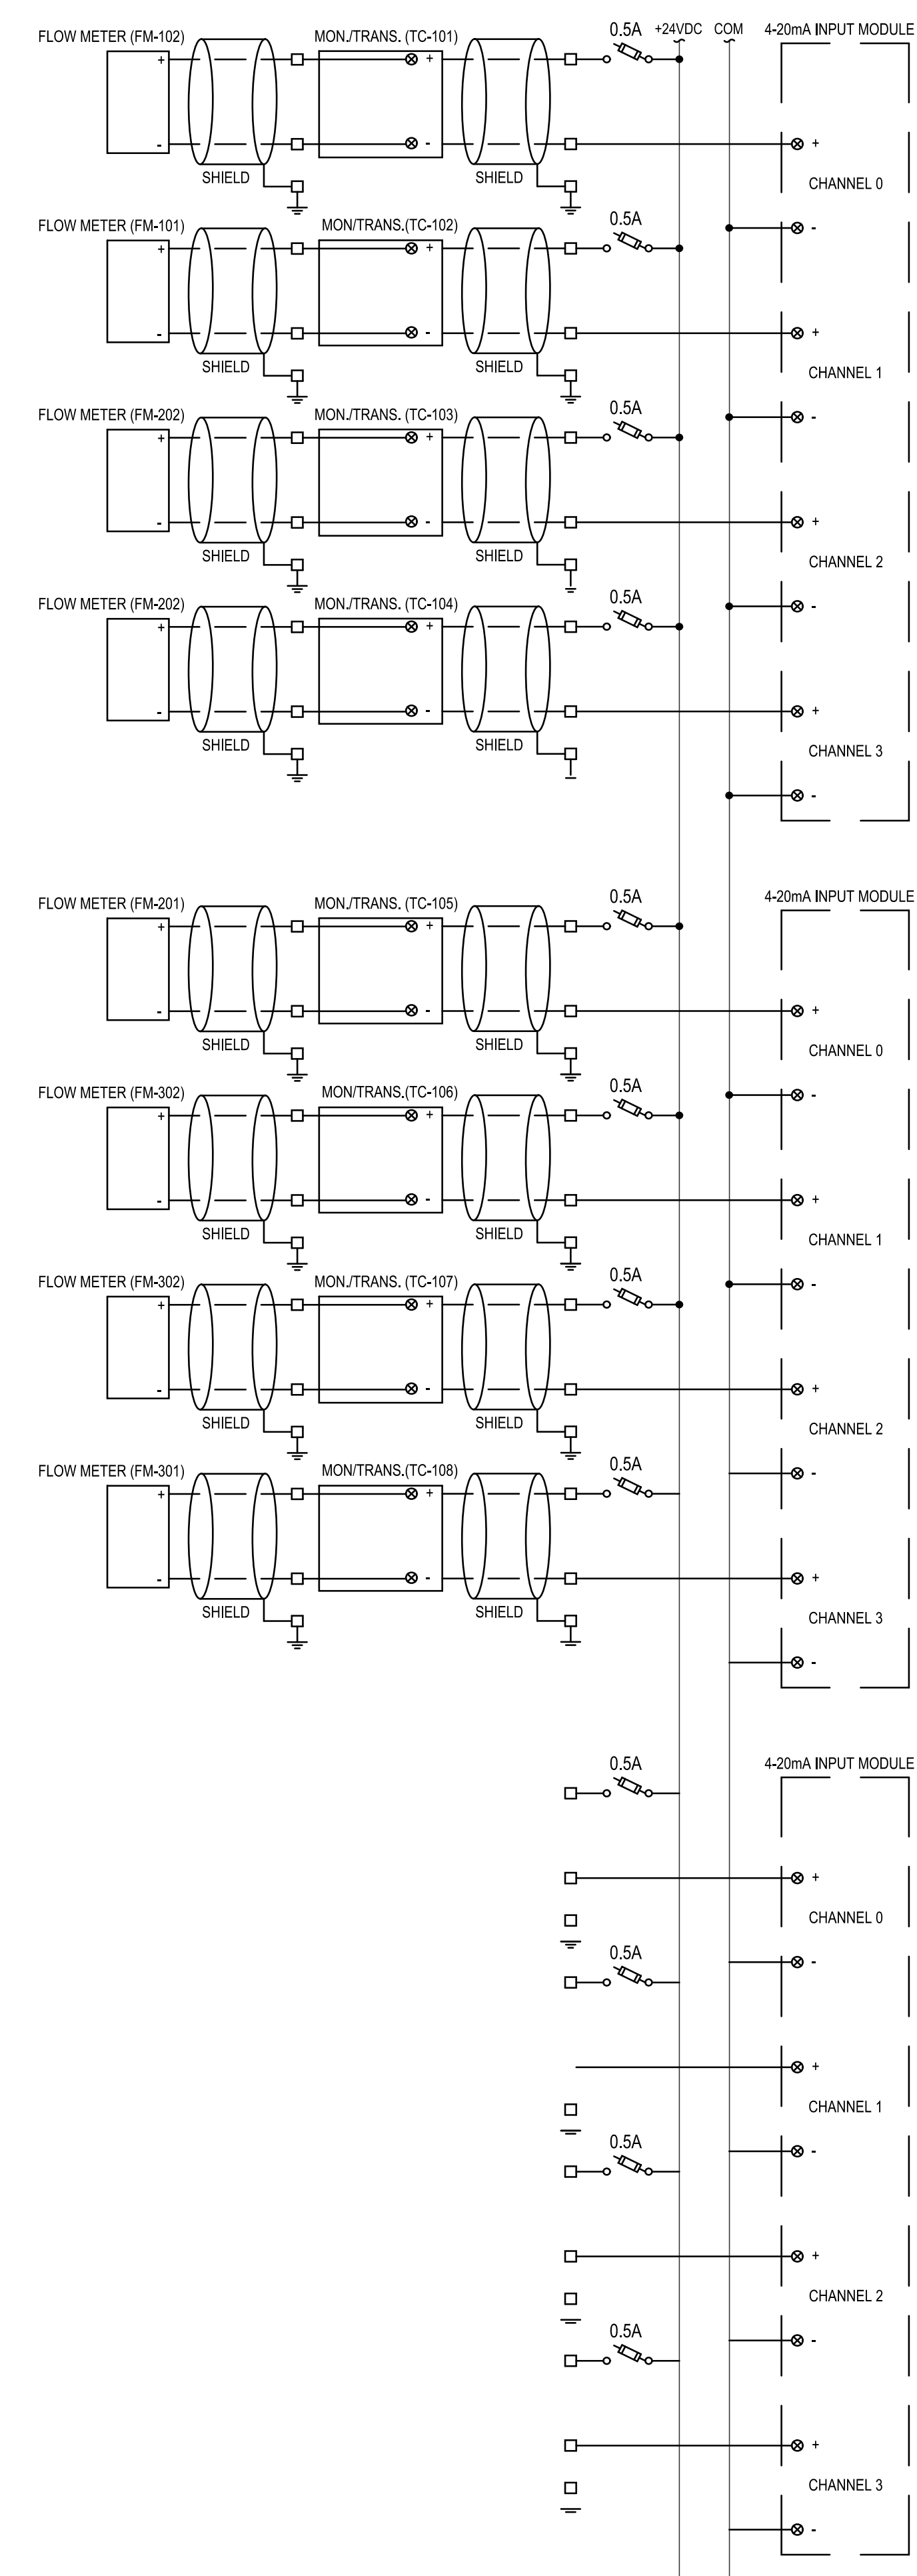


② PLC-0C1 ANALOG INPUTS

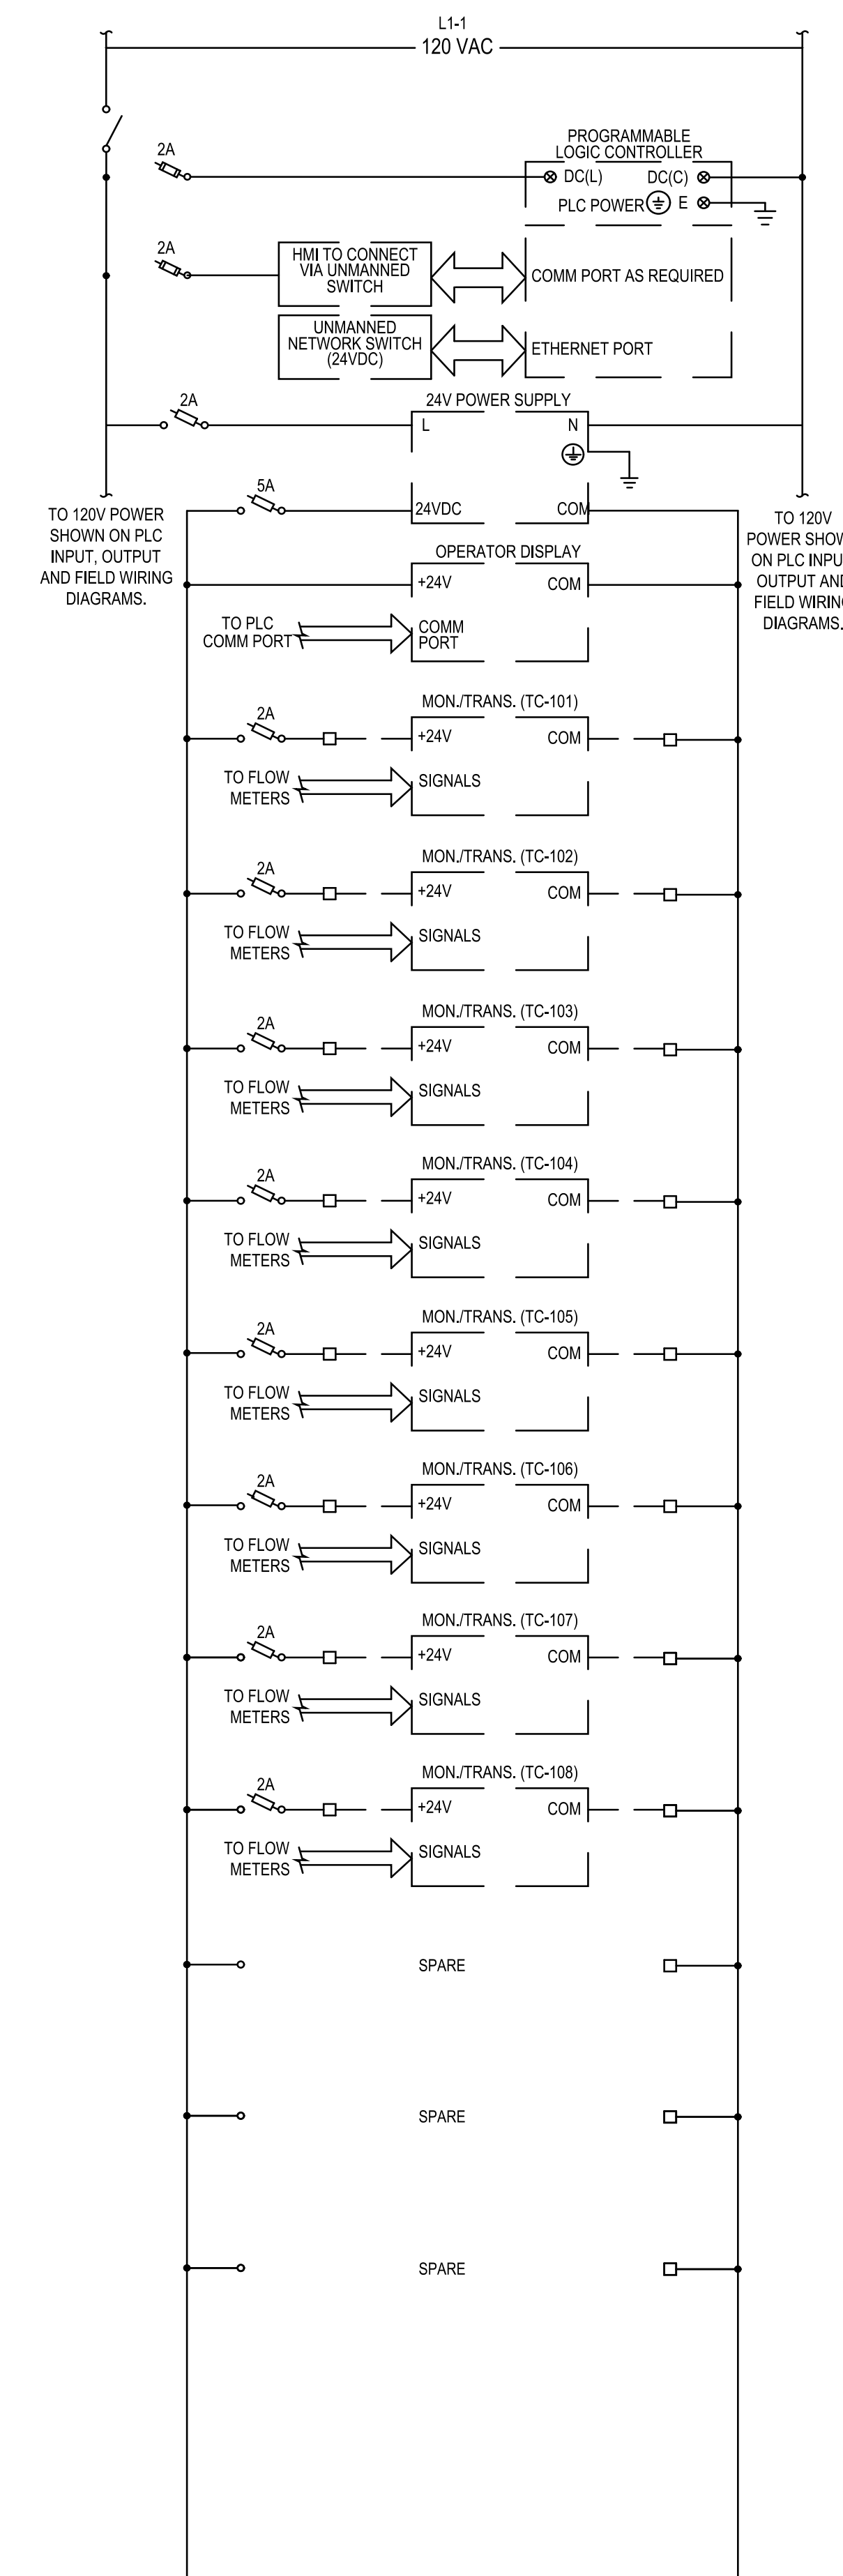

③ CONTROL PANEL POWER & COMMUNICATION

- | GENERAL CONTROL DIAGRAM NOTES: | |
|--------------------------------|--|
| 1. | CONTROL DIAGRAMS ARE CONCEPTUAL. CONTRACTOR SHALL MODIFY AS REQUIRED BASED ON EQUIPMENT SUPPLIED. |
| 2. | REFER TO SPECIFICATIONS FOR CONTROL REQUIREMENTS. |
| 3. | CONTRACTOR SHALL ASSIGN RELAY AND TERMINAL AND WIRE NUMBERS AS REQUIRED. REFER TO CONTROL PANEL NOTES. |
| 4. | TERMINALS SHALL BE SIZED APPROPRIATELY FOR THE CORRESPONDING WIRE SIZE. |

 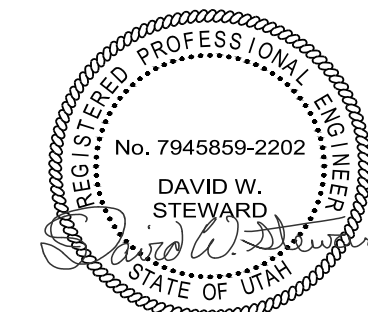


Reserved for permit stamp

159 South Jackson St, Suite 600
Seattle, Washington 98104 USA
206 624 5670 olsonkundig.com

Olson Kundig

project: PROJECT NAME : SOMMET BLANC
PROJECT ADDRESS



White Summit Development, LLC
PO Box 980022
Park City, Utah 84098

Acoustic Consultant
BRC Acoustics
1932 1st Ave, Suite 62
Seattle, WA 98101

CLOWARD H_2O
WATER PERFECTED

3595 N. University Ave., Ste. 290, Provo UT 84604, USA
Tel.: +1 801 375 4333 www.clowardh2o.com

Landscape Architect
EPG Design
6949 South High Tech
Midvale, Utah 84047

Specifications Writer
Friday Group
88 Mainelli Road
Middlebury, VT

Code Consultant
Holmes
600 1st Avenue, Suite
Seattle, WA 98104

Fire Protection Engineer
Jensen Hughes
One Research Drive, Suite 200
Westborough, MA 01581

Vertical Transportation Consultants
Lerch Bates
19515 North Creek Parkway, Suite
Bothell, WA 98011

Structural Engineer
Magnusson Klemencic Associates
1301 5th Ave, Suite 3200
Seattle, WA 98101

Lighting Designer
O.
1319 SE MLK Blvd, Su
Portland, Oregon 9721

Building Envelope Consultants
RDH
2101 N 34th St
Seattle, WA 98103

Accessibility Consultant
Studio Pacifica
2144 Westlake Ave N,
Seattle, WA 98109

MEP Engineer
WSP USA
1001 Fourth Ave., Suite
Seattle, WA 98154

principal architect CH20
project manager AP
drawn by RB/AD
checked by RMCE
job no. XXXXX
date 05/17/202

revisions:

DRAWING STATUS

IFC SET 2 OF 3

05/17/2024

MAIN MECHANICAL ROOM INPUT DETAILS

WE-4.01