


159 South Jackson St, Suite 600
Seattle, Washington 98104 USA
+1 206 624 5670 olson@undig.com

Olson Kunding

SOMMET BLANC
9300 Marsac Ave (B2 East Parcel)
Park City, Utah 84060

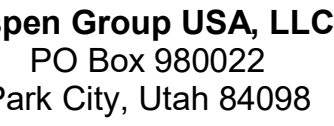

Edward H2O
6 N University Ave, Suite 290
Provo, UT 84604

3 Design
9 South High Tech Drive, Suite 100
Provo, Utah 84047

Day Group
Mainelli Road
Middlebury, VT

Life Consultant
James
1st Avenue, Suite 200A
Seattle, WA 98104

John Hughes
Research Drive, Suite 305C
Westborough, MA 01581

Michael Bates
15 North Creek Parkway, Suite 300
Seattle, WA 98011

Structural Engineer
Ingusson Klemencic Associates
1151 5th Ave, Suite 3200
Seattle, WA 98101

9 SE MLK Blvd, Suite 210
Tualatin, Oregon 97219

H
1 N 34th St
Seattle, WA 98103

Accessibility Consultant
Radio Pacifica
4 Westlake Ave N, Suite F
Seattle, WA 98109

P Engineer
P USA
1 Fourth Ave., Suite 3100
Seattle, WA 98154

principal architect _____
project manager _____
drawn by _____
checked by Checker
job no. _____
date 05/31/2024


sions:

date b

FC Set 3 of 3
05/31/2024

POWER C - LVL 2
MECHANICAL PIPING
PLAN

M3.2C.12

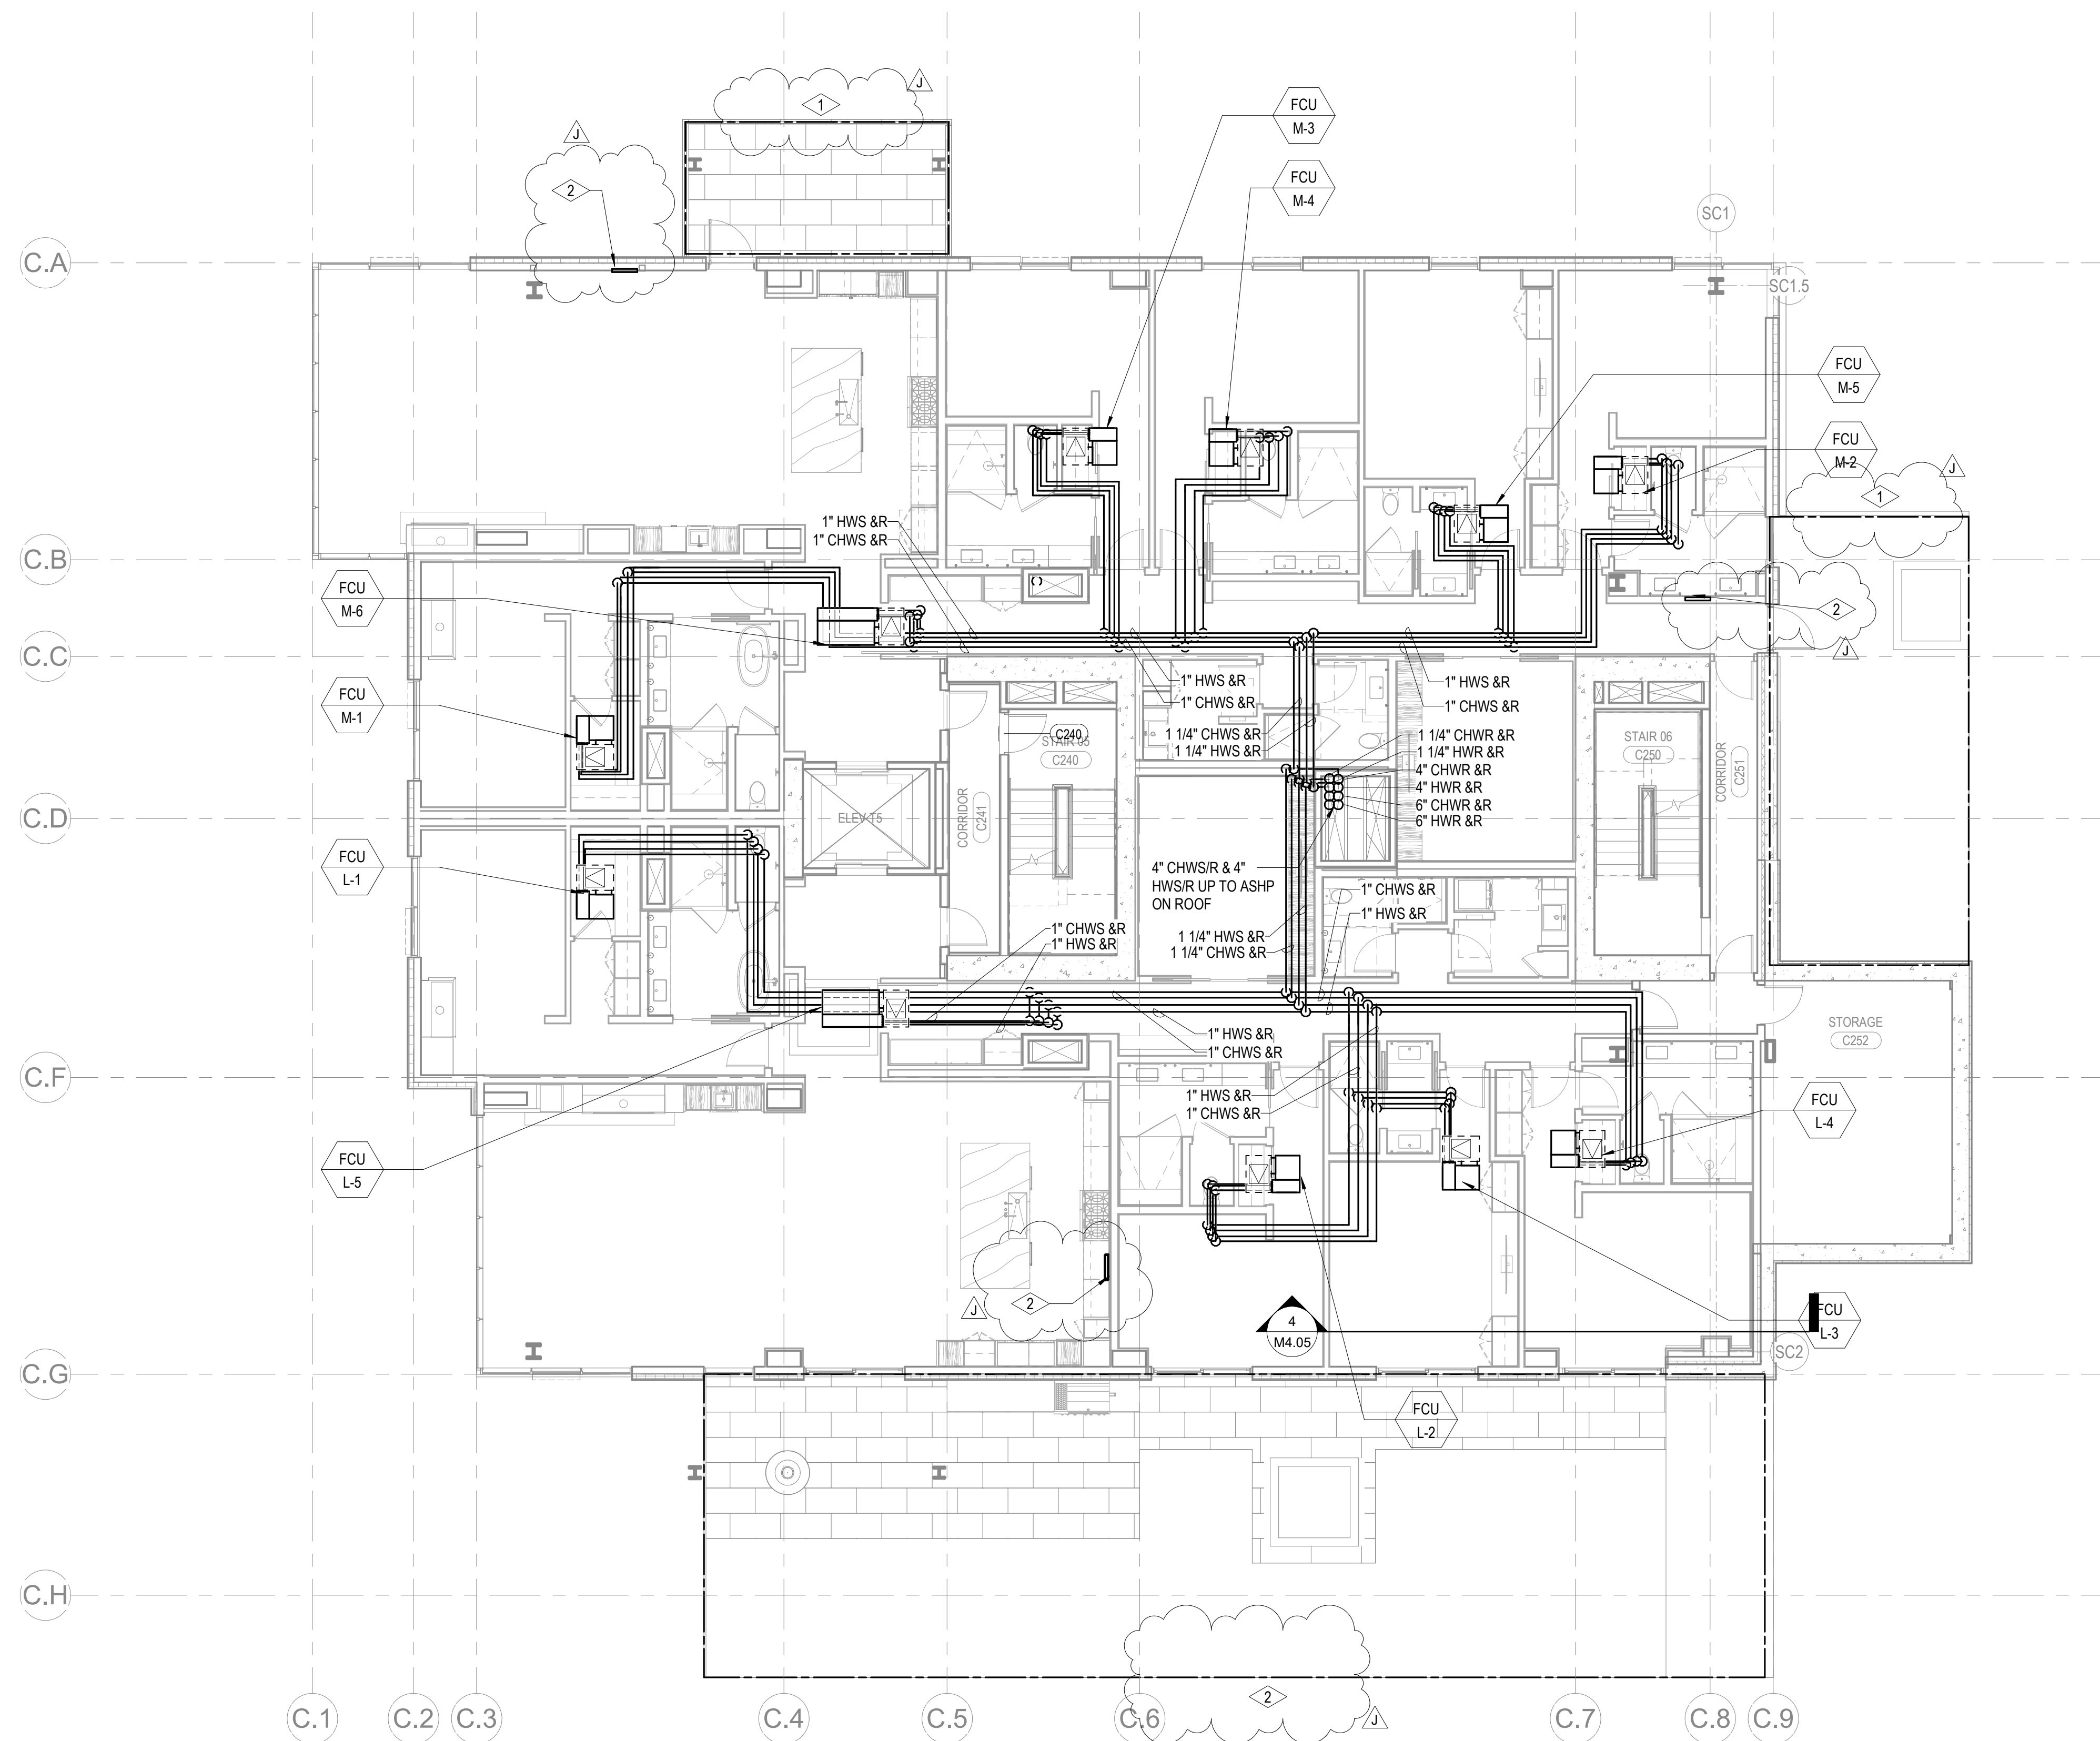

1 TOWER C - LEVEL 2 MECHANICAL PIPING PLAN
SCALE: 1/8" = 1'-0"

