

Olson Kundig



WSP USA
1001 Fourth Ave., Suite 3100
Seattle, WA 98154

 
no. date by

LAN - TOWER A - LVL B

P2.2A.01




PLAN - TOWER A LVL BU
P2.2A.01U



159 South Jackson St., Suite 600
Seattle, Washington 98104 USA
+1 206 624 5870 olsonkundig.com

Olson Kundig

Sommet Blanc - Bldg AB
DEEP VALLEY, UTAH

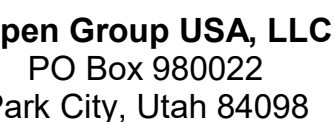

Pool Consultant
Cloward H2O
2696 N University Ave, Suite 290
Provo, UT 84604

Landscape Architect
EPG Design
5949 South High Tech Drive, Suite 100
Midvale, Utah 84047

Specifications Writer
Friday Group
88 Mainelli Road
Middlebury, VT

Code Consultant
Holmes
500 1st Avenue, Suite 200A
Seattle, WA 98104

Fire Protection Engineer
Jensen Hughes
One Research Drive, Suite 305C
Westborough, MA 01581

Vertical Transportation Consultant
Lerch Bates
19515 North Creek Parkway, Suite 304
Bothell, WA 98011

Structural Engineer
Magnusson Klemencic Associates
1301 5th Ave, Suite 3200
Seattle, WA 98101

Lighting Designer
D-
1319 SE MLK Blvd, Suite 210
Portland, Oregon 97219

Building Envelope Consultant
RDH
2101 N 34th St
Seattle, WA 98103

Accessibility Consultant
Studio Pacifica
2144 Westlake Ave N, Suite F
Seattle, WA 98109

WSP USA
1001 Fourth Ave., Suite 3100
Seattle, WA 98154

principal architect _____
project manager _____
drawn by _____
checked by GM
job no. 2021-0595
date 5/31/2024

revisions:


D	1/10/2025	ASI 6
B	5/31/2024	IFC 3
1	10/05/2022	PERMIT RESUBMITTAL

no.	date	t
-----	------	---

IFC Set 3 of 3
5/31/2024

PLAN - TOWER A - LVL 2

 
P2.2A.02



159 South Jackson St., Suite 600
Seattle, Washington 98104 USA
+1 208 624 5870 olsonkundig.com

Olson Kundig

Sommet Blanc - Bldg AB
DEER VALLEY, UTAH

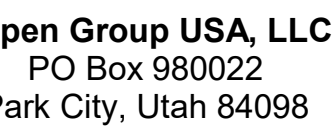

Howard H20
96 N University Ave, Suite 290
Provo, UT 84604

Landscape Architect
G Design
49 South High Tech Drive, Suite 100
Irvine, Utah 84047

Day Group
Mainelli Road
Middlebury, VT

de Consultant
Imes
101st Avenue, Suite 200A
Seattle, WA 98104

Protection Engineer
Jensen Hughes
Research Drive, Suite 305C
Westborough, MA 01581

Arch Bates
515 North Creek Parkway, Suite 304
Seattle, WA 98011

Structural Engineer
Ingusson Klemencic Associates
101 5th Ave, Suite 3200
Seattle, WA 98101

Lighting Designer
19 SE MLK Blvd, Suite 210
Portland, Oregon 97219

Building Envelope Consultant
PH
 101 N 34th St
 Seattle, WA 98103

Feasibility Consultant
Audio Pacifica
44 Westlake Ave N, Suite F
Seattle, WA 98109

PE Engineer
SP USA
01 Fourth Ave., Suite 3100
Seattle, WA 98154

Principal architect _____

project manager _____
drawn by _____

checked by BW
job no. 0004 0506

date 5/31/2024

sions:

1/10/2025	ASI 6
10/05/2022	PERMIT RESUBMITTAL

date	by
------	----


IFC Set 3 of 3

5/31/2024


N - TOWER A - LVI

N - TOWER A - LEVEL

2.2A.11

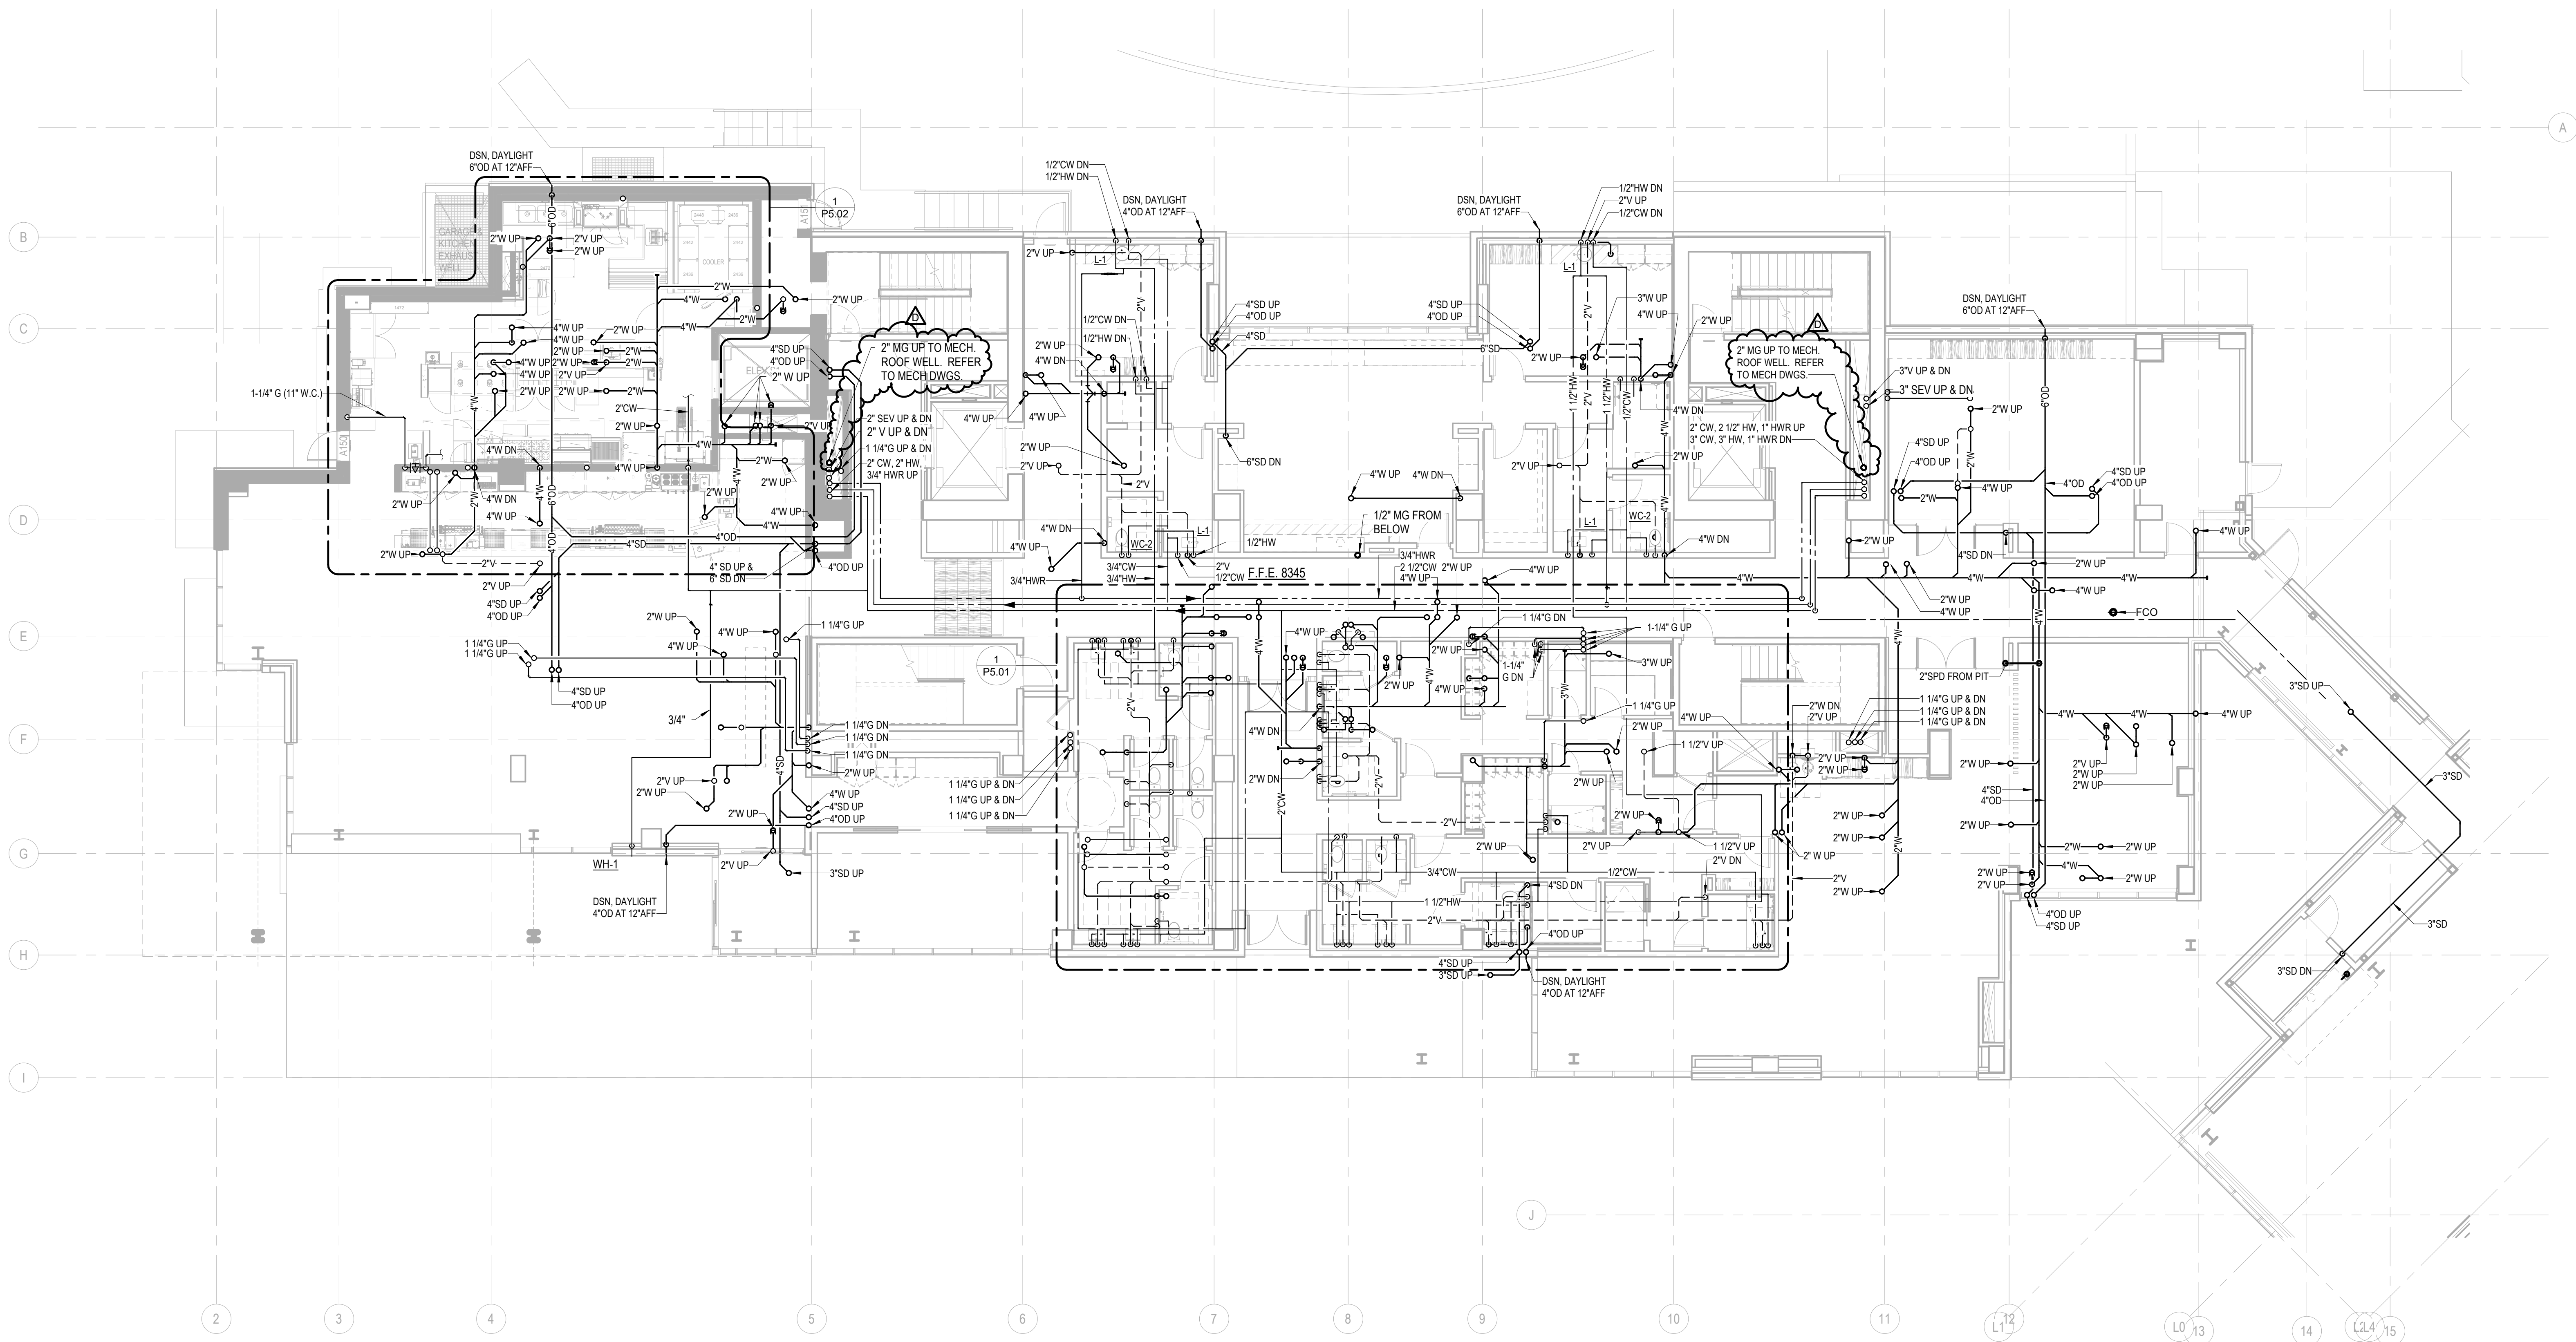

 
1 PLAN - TOWER A - LVL 1
SCALE: 1/8" = 1'-0"



159 South Jackson St., Suite 600
Seattle, Washington 98104 USA
+1 206 624 5870 olsonkundig.com

Olson Kundig

Sommet Blanc - Bldg AB
DEER VALLEY, UTAH

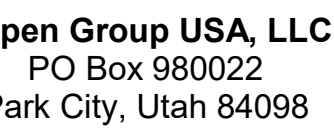

Consultant
Edward H20
6 N University Ave, Suite 290
Provo, UT 84604

5 Design
9 South High Tech Drive, Suite 100
Pleasantville, Utah 84047

Play Group
Mainelli Road
Middlebury, VT

Lead Consultant
James
1st Avenue, Suite 200A
Seattle, WA 98104

Protection Engineer
Ken Hughes
Research Drive, Suite 305C
Westborough, MA 01581

Michael Bates
15 North Creek Parkway, Suite 300
Seattle, WA 98011

Structural Engineer
Knudson Klemencic Associates
115th Ave, Suite 3200
Seattle, WA 98101

9 SE MLK Blvd, Suite 210
Portland, Oregon 97219

Envelope Consultant
H
1 N 34th St
Seattle, WA 98103

Feasibility Consultant
Radio Pacifica
4 Westlake Ave N, Suite F
Seattle, WA 98109

P Engineer
P USA
1 Fourth Ave., Suite 3100
Seattle, WA 98154

principal architect _____
project manager _____
drawn by _____

checked by GM
job no. 2021-0595
date 5/31/2024

sions:

1/10/2025	ASI 6
10/05/2022	PERMIT RESUBMITTAL

date	by
------	----


FC Set 3 of 3
5/31/2024

AN - TOWER A - ROOF


P2.2A.R



SCALE: 1/8" = 1'-0"

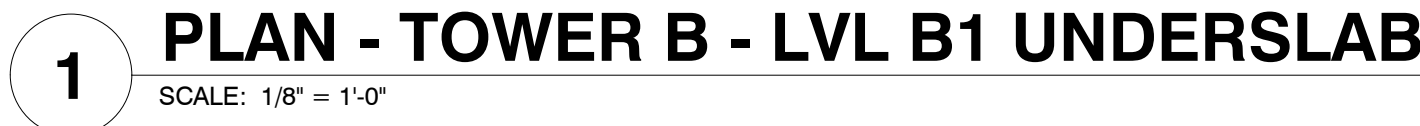


P2.2B.01U

 

159 South Jackson St., Suite 600
Seattle, Washington 98104 USA
+1 206 624 5870 olsonkundig.com

Olson Kundig

Sommet Blanc - Bldg AB
DEER VALLEY, UTAH

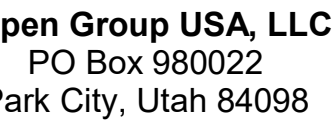

Pool Consultant
Cloward H2O
2696 N University Ave, Suite 290
Provo, UT 84604

Landscape Architect
EPG Design
6949 South High Tech Drive, Suite 100
Midvale, Utah 84047

Specifications Writer
Friday Group
88 Mainelli Road
Middlebury, VT

Code Consultant
Holmes
600 1st Avenue, Suite 200A
Seattle, WA 98104

Fire Protection Engineer
Jensen Hughes
One Research Drive, Suite 305
Westborough, MA 01581

Vertical Transportation Consultant
Lerch Bates
19515 North Creek Parkway, Suite 300
Bothell, WA 98011

Structural Engineer
Magnusson Klemencic Associates
1301 5th Ave, Suite 3200
Seattle, WA 98101

Lighting Designer
O-
1319 SE MLK Blvd, Suite 210
Portland, Oregon 97219

Building Envelope Consultant
RDH
2101 N 34th St
Seattle, WA 98103

Accessibility Consultant
Studio Pacifica
2144 Westlake Ave N, Suite F
Seattle, WA 98109

MEP Engineer
WSP USA
1001 Fourth Ave., Suite 3100
Seattle, WA 98154

principal architect _____
project manager _____
drawn by _____
checked by GM
job no. 2021-0595
date 5/31/2024

revisions


E	1/21/2025	ASL 6.1
D	1/10/2025	ASL 6
4	1/3/2025	RFI 94.1
3	11/14/2024	RFI 062
2	5/05/2023	PERMIT COMMENT RESPONSE
1	10/05/2022	PERMIT RESUBMITTAL

no.	date	by
-----	------	----

IFC Set 3 of 3
5/31/2024


PLAN - TOWER B - LVL
P2

 P2.2B.02



Olson Kundaig

Sommet Blanc - Bldg AB
DEER VALLEY, UTAH

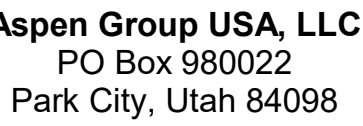


WSP USA
1001 Fourth Ave., Suite 3100
Seattle, WA 98154

no. date by

LAN - TOWER B - LVL
1

 LAN - TOWER B - LVL
1






159 South Jackson St., Suite 600
Seattle, Washington 98104 USA
+1 206 624 5870 olsonkundig.com

Olson Kundaig

Sommet Blanc - Bldg AB
DEER VALLEY, UTAH

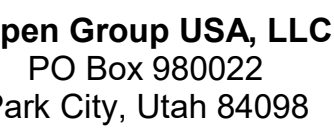

Edward H2O
16 N University Ave, Suite 290
Provo, UT 84604

3D Design
9 South High Tech Drive, Suite 100
Provo, Utah 84047

Play Group
Mainelli Road
Middlebury, VT

le Consultant
mes
1st Avenue, Suite 200A
ttle, WA 98104

Protection Engineer
Ken Hughes
10 Research Drive, Suite 305C
Westborough, MA 01581

Michael Bates
15 North Creek Parkway, Suite 304
Seattle, WA 98011

Structural Engineer
Knudson Klemencic Associates
115th Ave, Suite 3200
Seattle, WA 98101

9 SE MLK Blvd, Suite 210
Portland, Oregon 97219

Design Envelope Consultant
H
1 N 34th St
Seattle, WA 98103

Feasibility Consultant
Radio Pacifica
4 Westlake Ave N, Suite F
Seattle, WA 98109

P Engineer
P USA
1 Fourth Ave., Suite 3100
Seattle, WA 98154

Principal architect _____
Project manager _____
Designed by _____

checked by GM
job no. 2021-0595
date 5/31/2024

ns:


10/2025	ASI 6
10/6/2022	PERMIT RESUBMITTAL

date by

Set 3 of 3
31/2024

AN - TOWER B - LVL 1

 
2.2B.11



159 South Jackson St., Suite 600
Seattle, Washington 98104 USA
+1 206 624 5870 olsonkundig.com

Olson Kundig

Sommet Blanc - Bldg AB
DEER VALLEY, UTAH

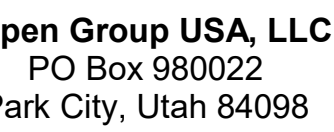

Edward H2O
16 N University Ave, Suite 290
Provo, UT 84604

Landscape Architect
CG Design
9 South High Tech Drive, Suite 100
Pleasantville, Utah 84047

Play Group
Mainelli Road
Dalebury, VT

le Consultant
mes
1st Avenue, Suite 200A
ttle, WA 98104

Protection Engineer
Ken Hughes
100 Research Drive, Suite 305C
Westborough, MA 01581

Michael Bates
15 North Creek Parkway, Suite 304
Seattle, WA 98011

Structural Engineer
Knudson Klemencic Associates
115th Ave, Suite 3200
Seattle, WA 98101

9 SE MLK Blvd, Suite 210
Portland, Oregon 97219

Envelope Consultant
H
1 N 34th St
Seattle, WA 98103

Accessibility Consultant
Radio Pacifica
4 Westlake Ave N, Suite F
Seattle, WA 98109

P Engineer
P USA
1 Fourth Ave., Suite 3100
Seattle, WA 98154

Principal architect _____

Project manager _____
drawn by _____

Drawn by _____

job no. 2021-0595

date 5/31/2024

ns:

ADMSF ACIS

06/2022	PERMIT RESUBMITTAL
---------	--------------------


data

IFC Set 3 of 3

5/31/2024

AN - TOWER B - ROOF

P2.2B.R

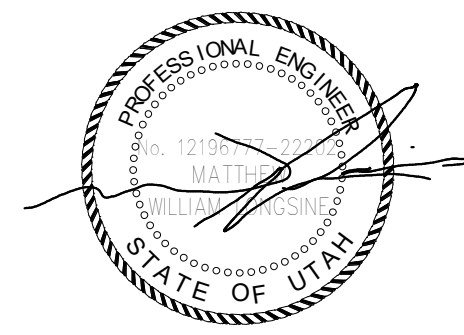

Reserved for permit stamp

100 South Jackson St., Suite 200
Seattle, Washington 98104 USA
+1 206 451 2010
olsonkundig.com

Olson Kundig

Sommet Blanc - C
DEER VALLEY, UTAH



Aspen Group USA, LLC
PO Box 980022
Park City, Utah 84098

Pool Consultant
Cloward H2O
2696 N University Ave., Suite 200
Provo, UT 84604

Landscape Architect
EPG Design
6940 South High Tech Drive, Suite 100
Midvale, Utah 84047

Specifications Writer
Friday Group
88 Mainelli Road
Middlebury, VT

Code Consultant
Holmes
600 1st Avenue, Suite 200A
Seattle, WA 98104

Fire Protection Engineer
Jensen Hughes
One Research Drive, Suite 305C
Westborough, MA 01581

Vertical Transportation Consultant
Lerch Bates
1615 North Creek Parkway, Suite 304
Bothell, WA 98011

Structural Engineer
Magnusson Klemencic Associates
1301 5th Ave, Suite 3200
Seattle, WA 98101

Lighting Designer
O
1319 SE MLK Blvd, Suite 210
Portland, Oregon 97219

Building Envelope Consultant
RDH
2101 N 34th St
Seattle, WA 98103

Accountability Consultant
Studio Pacifica
2144 Westlake Ave N, Suite F
Seattle, WA 98109

MEP Engineer
WSP USA
1001 Fourth Ave., Suite 3100
Seattle, WA 98154

principal architect _____
project manager _____
drawn by _____
checked by _____
job no. 2021-0356
date 5/31/2024

revisions:

D 08/23/2024 AS 003


no. date by

IFC Set 3 of 3
5/31/2024


PLAN - TOWER C - LVL 6
P2.2C.16

KEYNOTES:

- 2" SAN DN & 2" V RISE
- 2" V DN
- 3" SAN UP & DN
- 2" SAN & 2" V DN
- 2" SAN & 2" V UP
- 3" V UP & DN
- 2" V UP
- 2" SAN UP
- 4" SAN UP
- 4" SAN DN
- 2" SAN DN
- 4" SAN UP & DN
- 4" V UP & DN
- 2" V UP & DN
- 3" SAN DN
- 2" V RISE
- 3" SAN UP

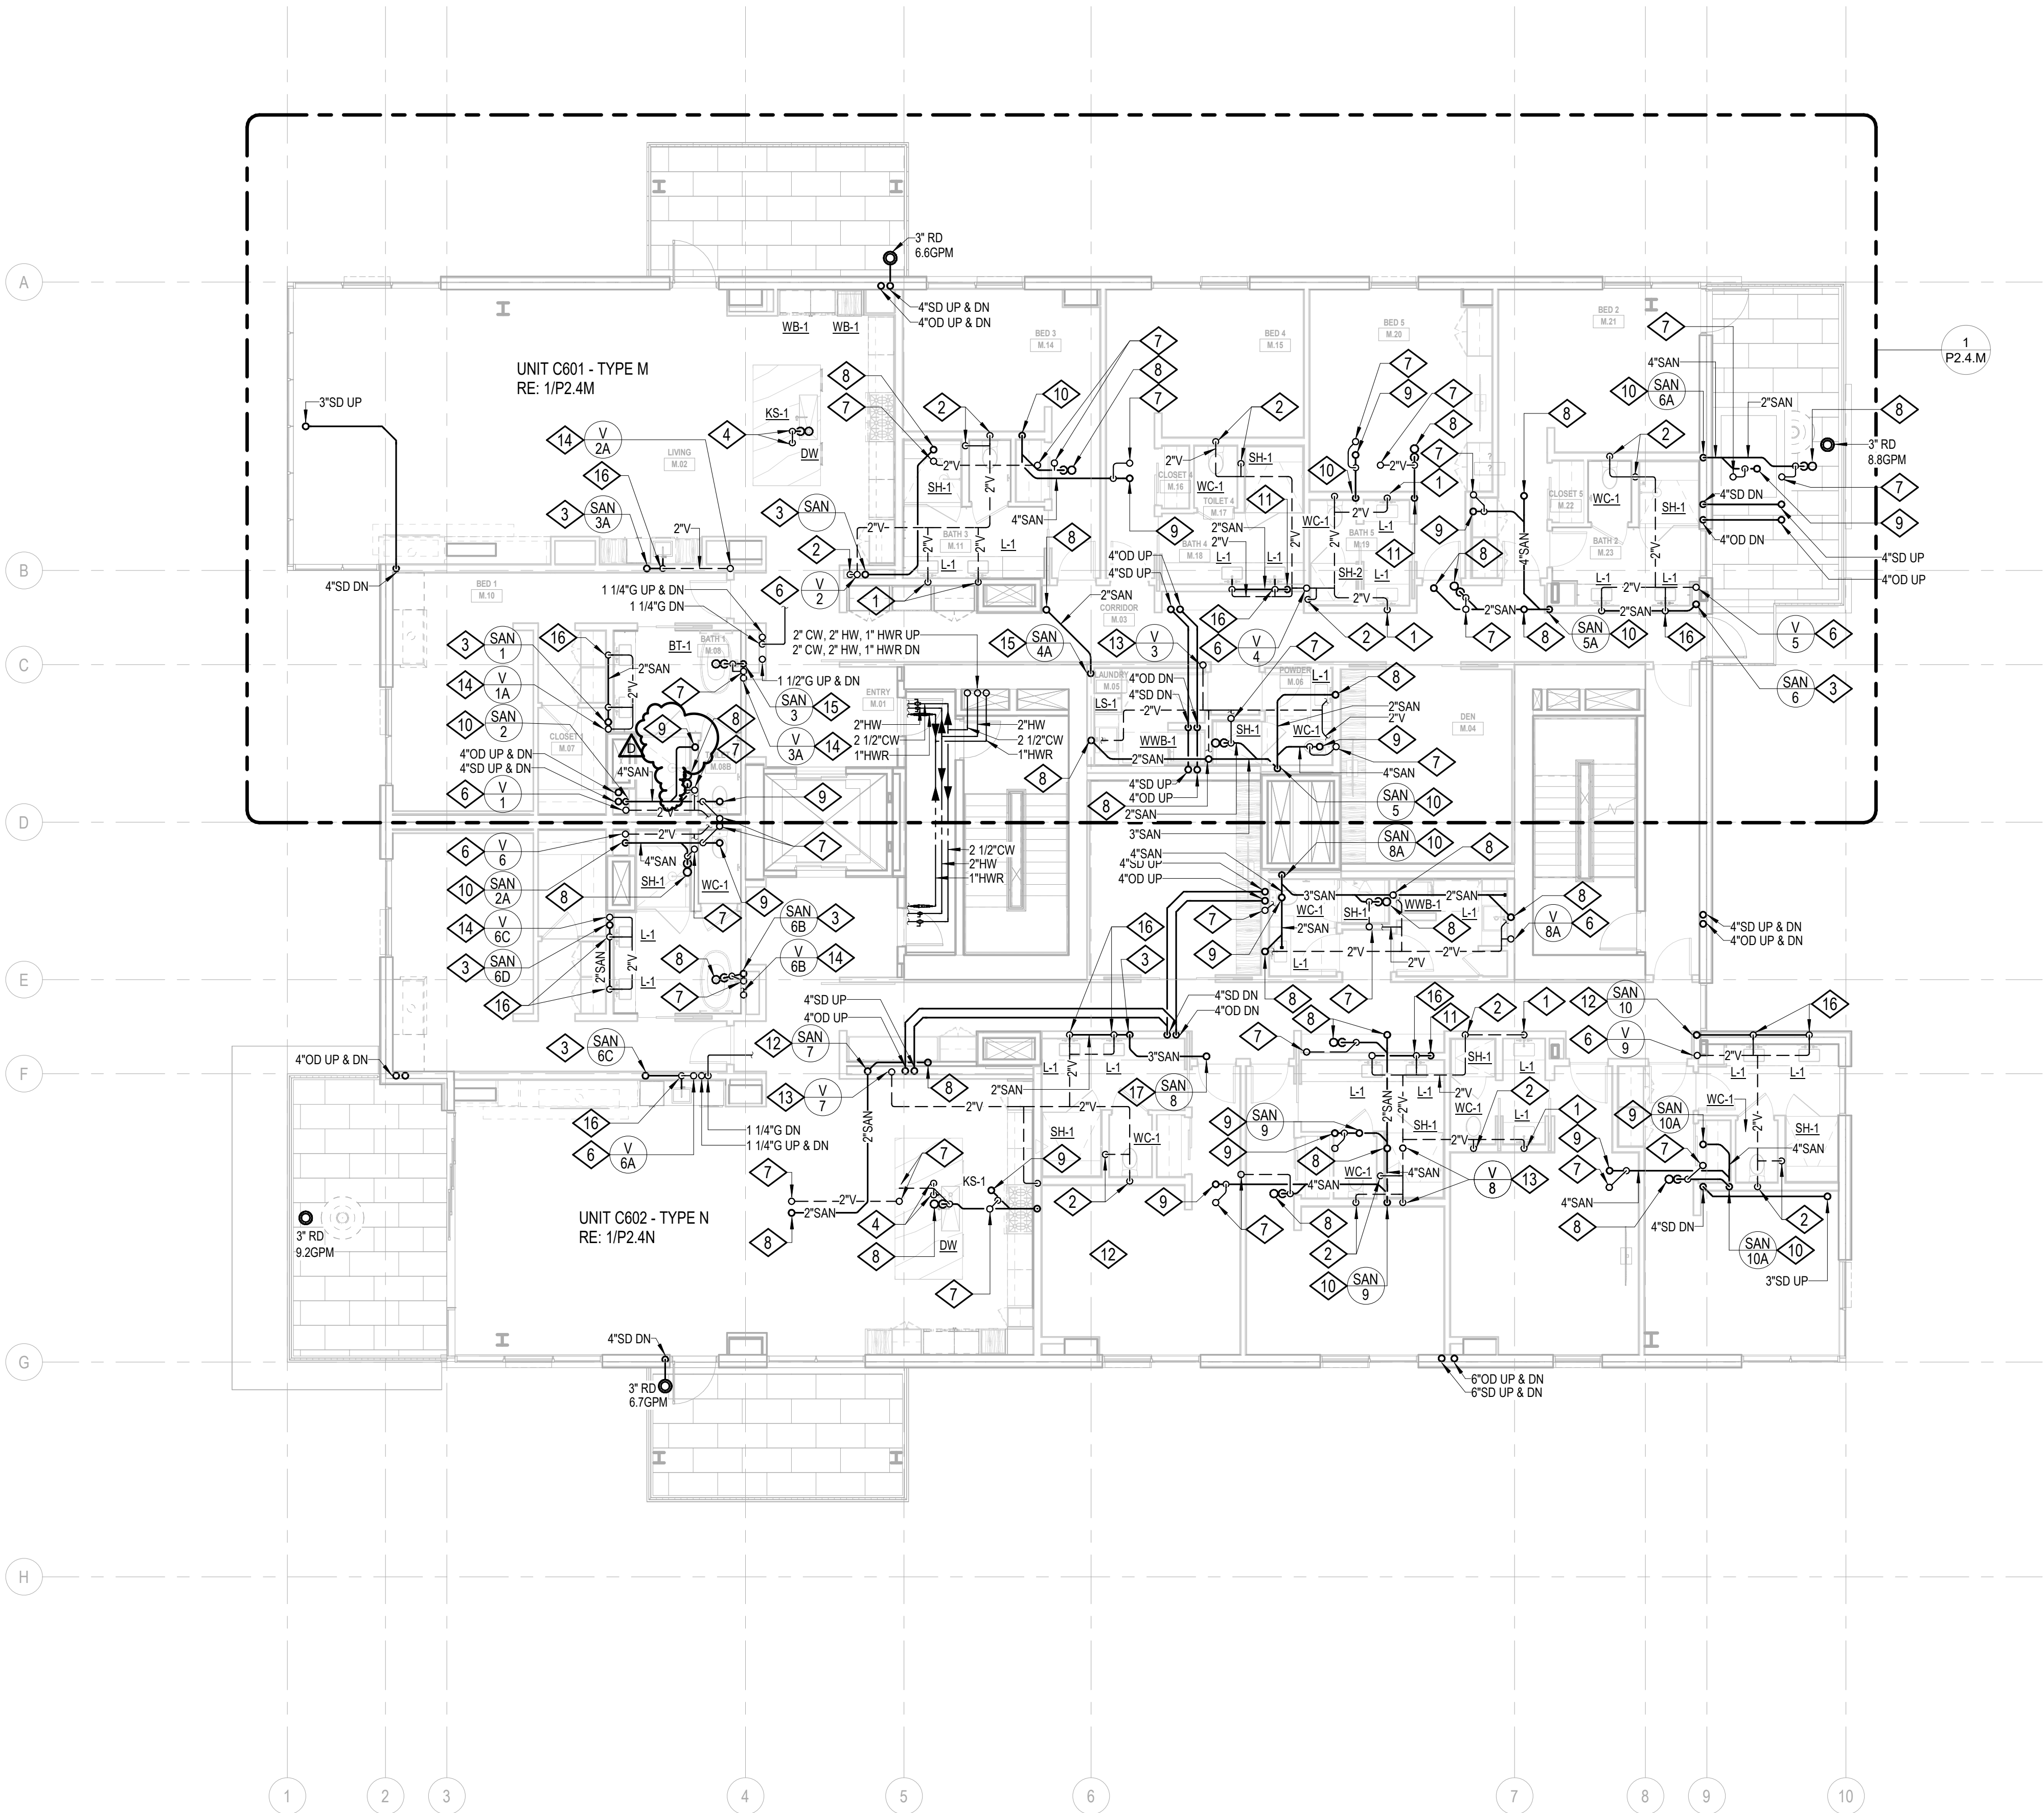

 
1 PLAN - TOWER C - LVL 6
SCALE: 1/8" = 1'-0"



159 South Jackson St., Suite 600
Seattle, Washington 98104 USA
+1 206 624 5870 olsonkundig.com

Olson Kundig

Sommet Blanc -C
DEER VALLEY, UTAH

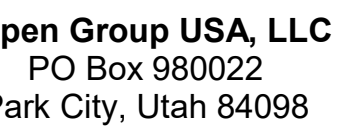

Howard H20
96 N University Ave, Suite 290
Provo, UT 84604

Landscape Architect
G Design
49 South High Tech Drive, Suite 100
Ivins, Utah 84047

Day Group
Mainelli Road
Middlebury, VT

de Consultant
Imes
101st Avenue, Suite 200A
Seattle, WA 98104

Protection Engineer
Jensen Hughes
Research Drive, Suite 305C
Westborough, MA 01581

Arch Bates
515 North Creek Parkway, Suite 304
Seattle, WA 98011

Structural Engineer
Ingusson Klemencic Associates
101 5th Ave, Suite 3200
Seattle, WA 98101

Lighting Designer
19 SE MLK Blvd, Suite 210
Portland, Oregon 97219

Building Envelope Consultant
PH
 101 N 34th St
 Seattle, WA 98103

Feasibility Consultant
Audlo Pacifica
44 Westlake Ave N, Suite F
Seattle, WA 98109

PE Engineer
SP USA
01 Fourth Ave., Suite 3100
Seattle, WA 98154

principal architect _____
project manager _____
drawn by _____
checked by GM _____
job no. 2021-0595
date 5/31/2024


08/23/2024 ASI 003

date	by
------	----

FC Set 3 of 3
5/31/2024

AN - TOWER C - I VI 7

P2.2C.17

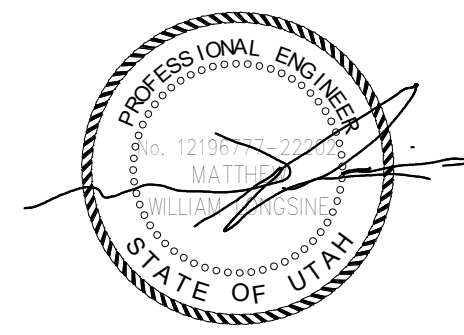

Reserved for permit stamp

103 South Jackson St., Suite 200
Seattle, Washington 98104 USA
+1 206 468 2070 olsonkundig.com

Olson Kundig

project
Sommet Blanc - C
DEER VALLEY, UTAH



Aspen Group USA, LLC
PO Box 980022
Park City, Utah 84098

Pool Consultant
Cloward H2O
2696 N University Ave., Suite 200
Provo, UT 84604

Landscape Architect
EPG Design
6940 South High Tech Drive, Suite 100
Midvale, Utah 84047

Specifications Writer
Friday Group
88 Mainelli Road
Middlebury, VT

Code Consultant
Holmes
600 1st Avenue, Suite 200A
Seattle, WA 98104

Fire Protection Engineer
Jensen Hughes
One Research Drive, Suite 305C
Westborough, MA 01581

Vertical Transportation Consultant
Lerch Bates
1615 North Creek Parkway, Suite 304
Bothell, WA 98011

Structural Engineer
Magnusson Klemencic Associates
1301 5th Ave., Suite 3200
Seattle, WA 98101

Lighting Designer
O
1319 SE MLK Blvd, Suite 210
Portland, Oregon 97219

Building Envelope Consultant
RDH
2101 N 34th St
Seattle, WA 98103

Accessibility Consultant
Studio Pacifica
2144 Westlake Ave N, Suite F
Seattle, WA 98109

MEP Engineer
WSP USA
1001 Fourth Ave., Suite 3100
Seattle, WA 98154


principal architect _____
project manager _____
drawn by _____
checked by _____
job no. 2021-0356
date 5/31/2024

revisions:


no. date by

IFC Set 3 of 3
5/31/2024

PLAN - TOWER C - LVL 8
P2.2C.19

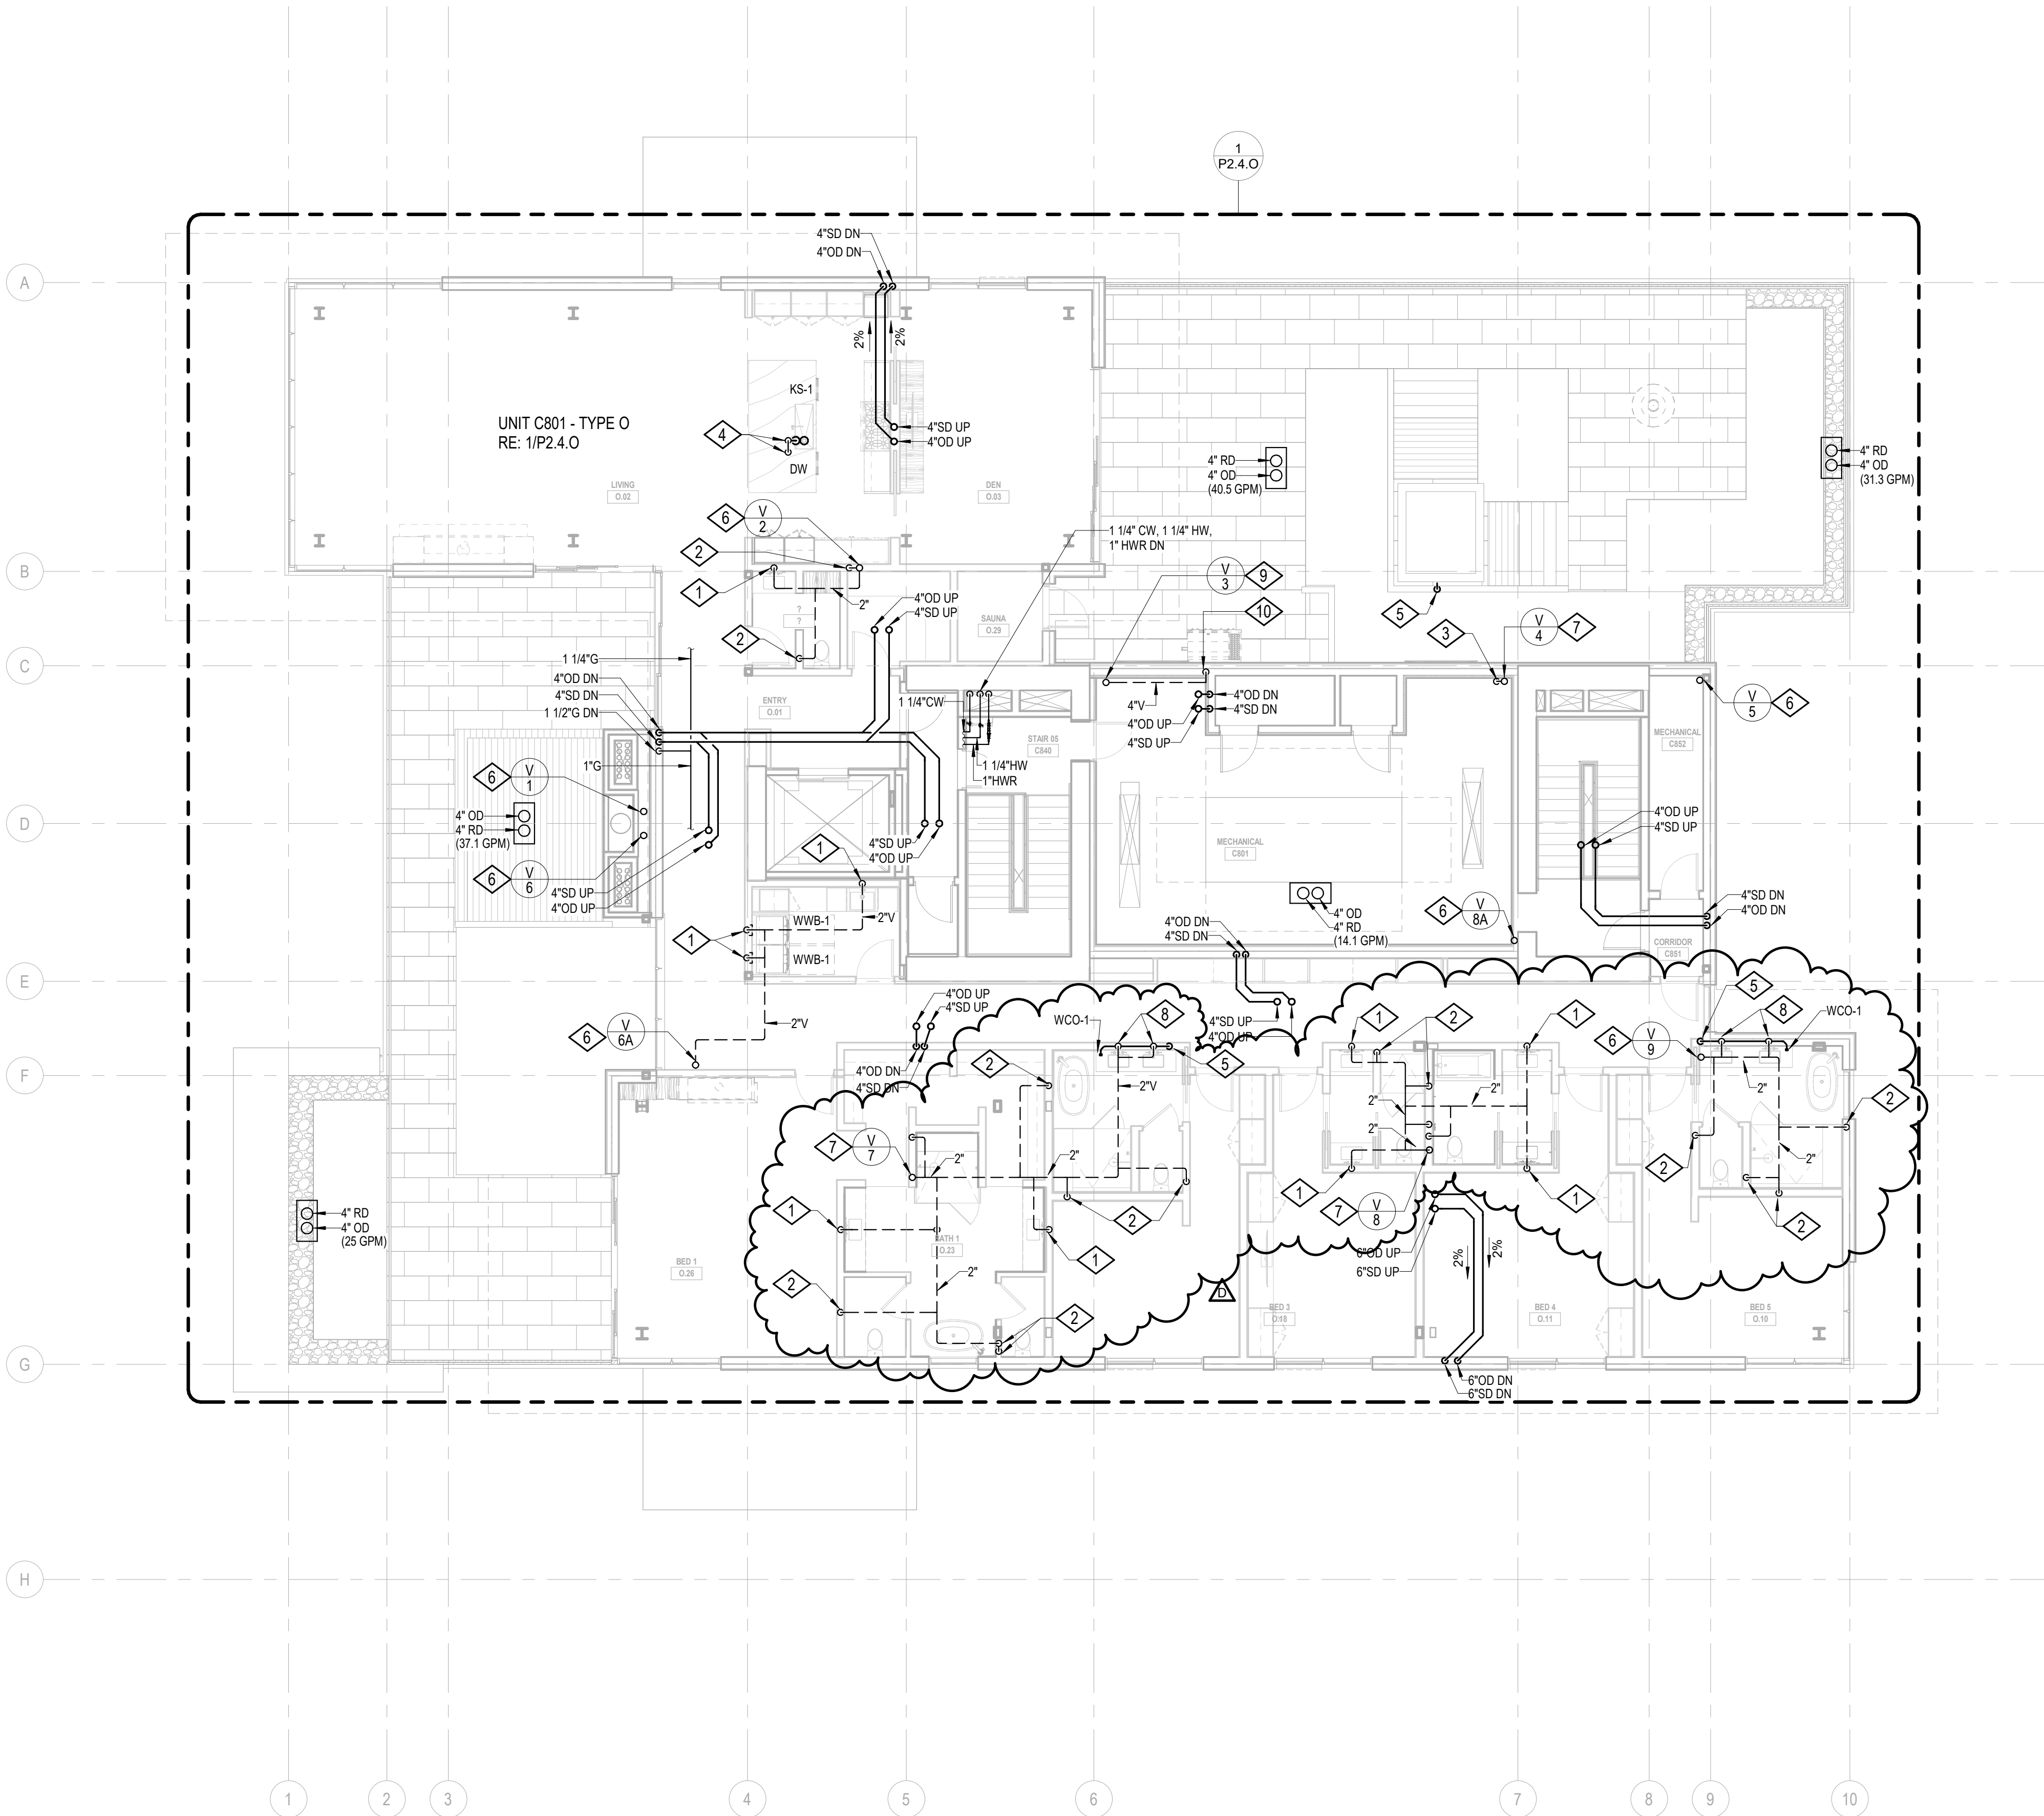


1 PLAN - TOWER C - LVL 8
SCALE: 1/8" = 1'-0"

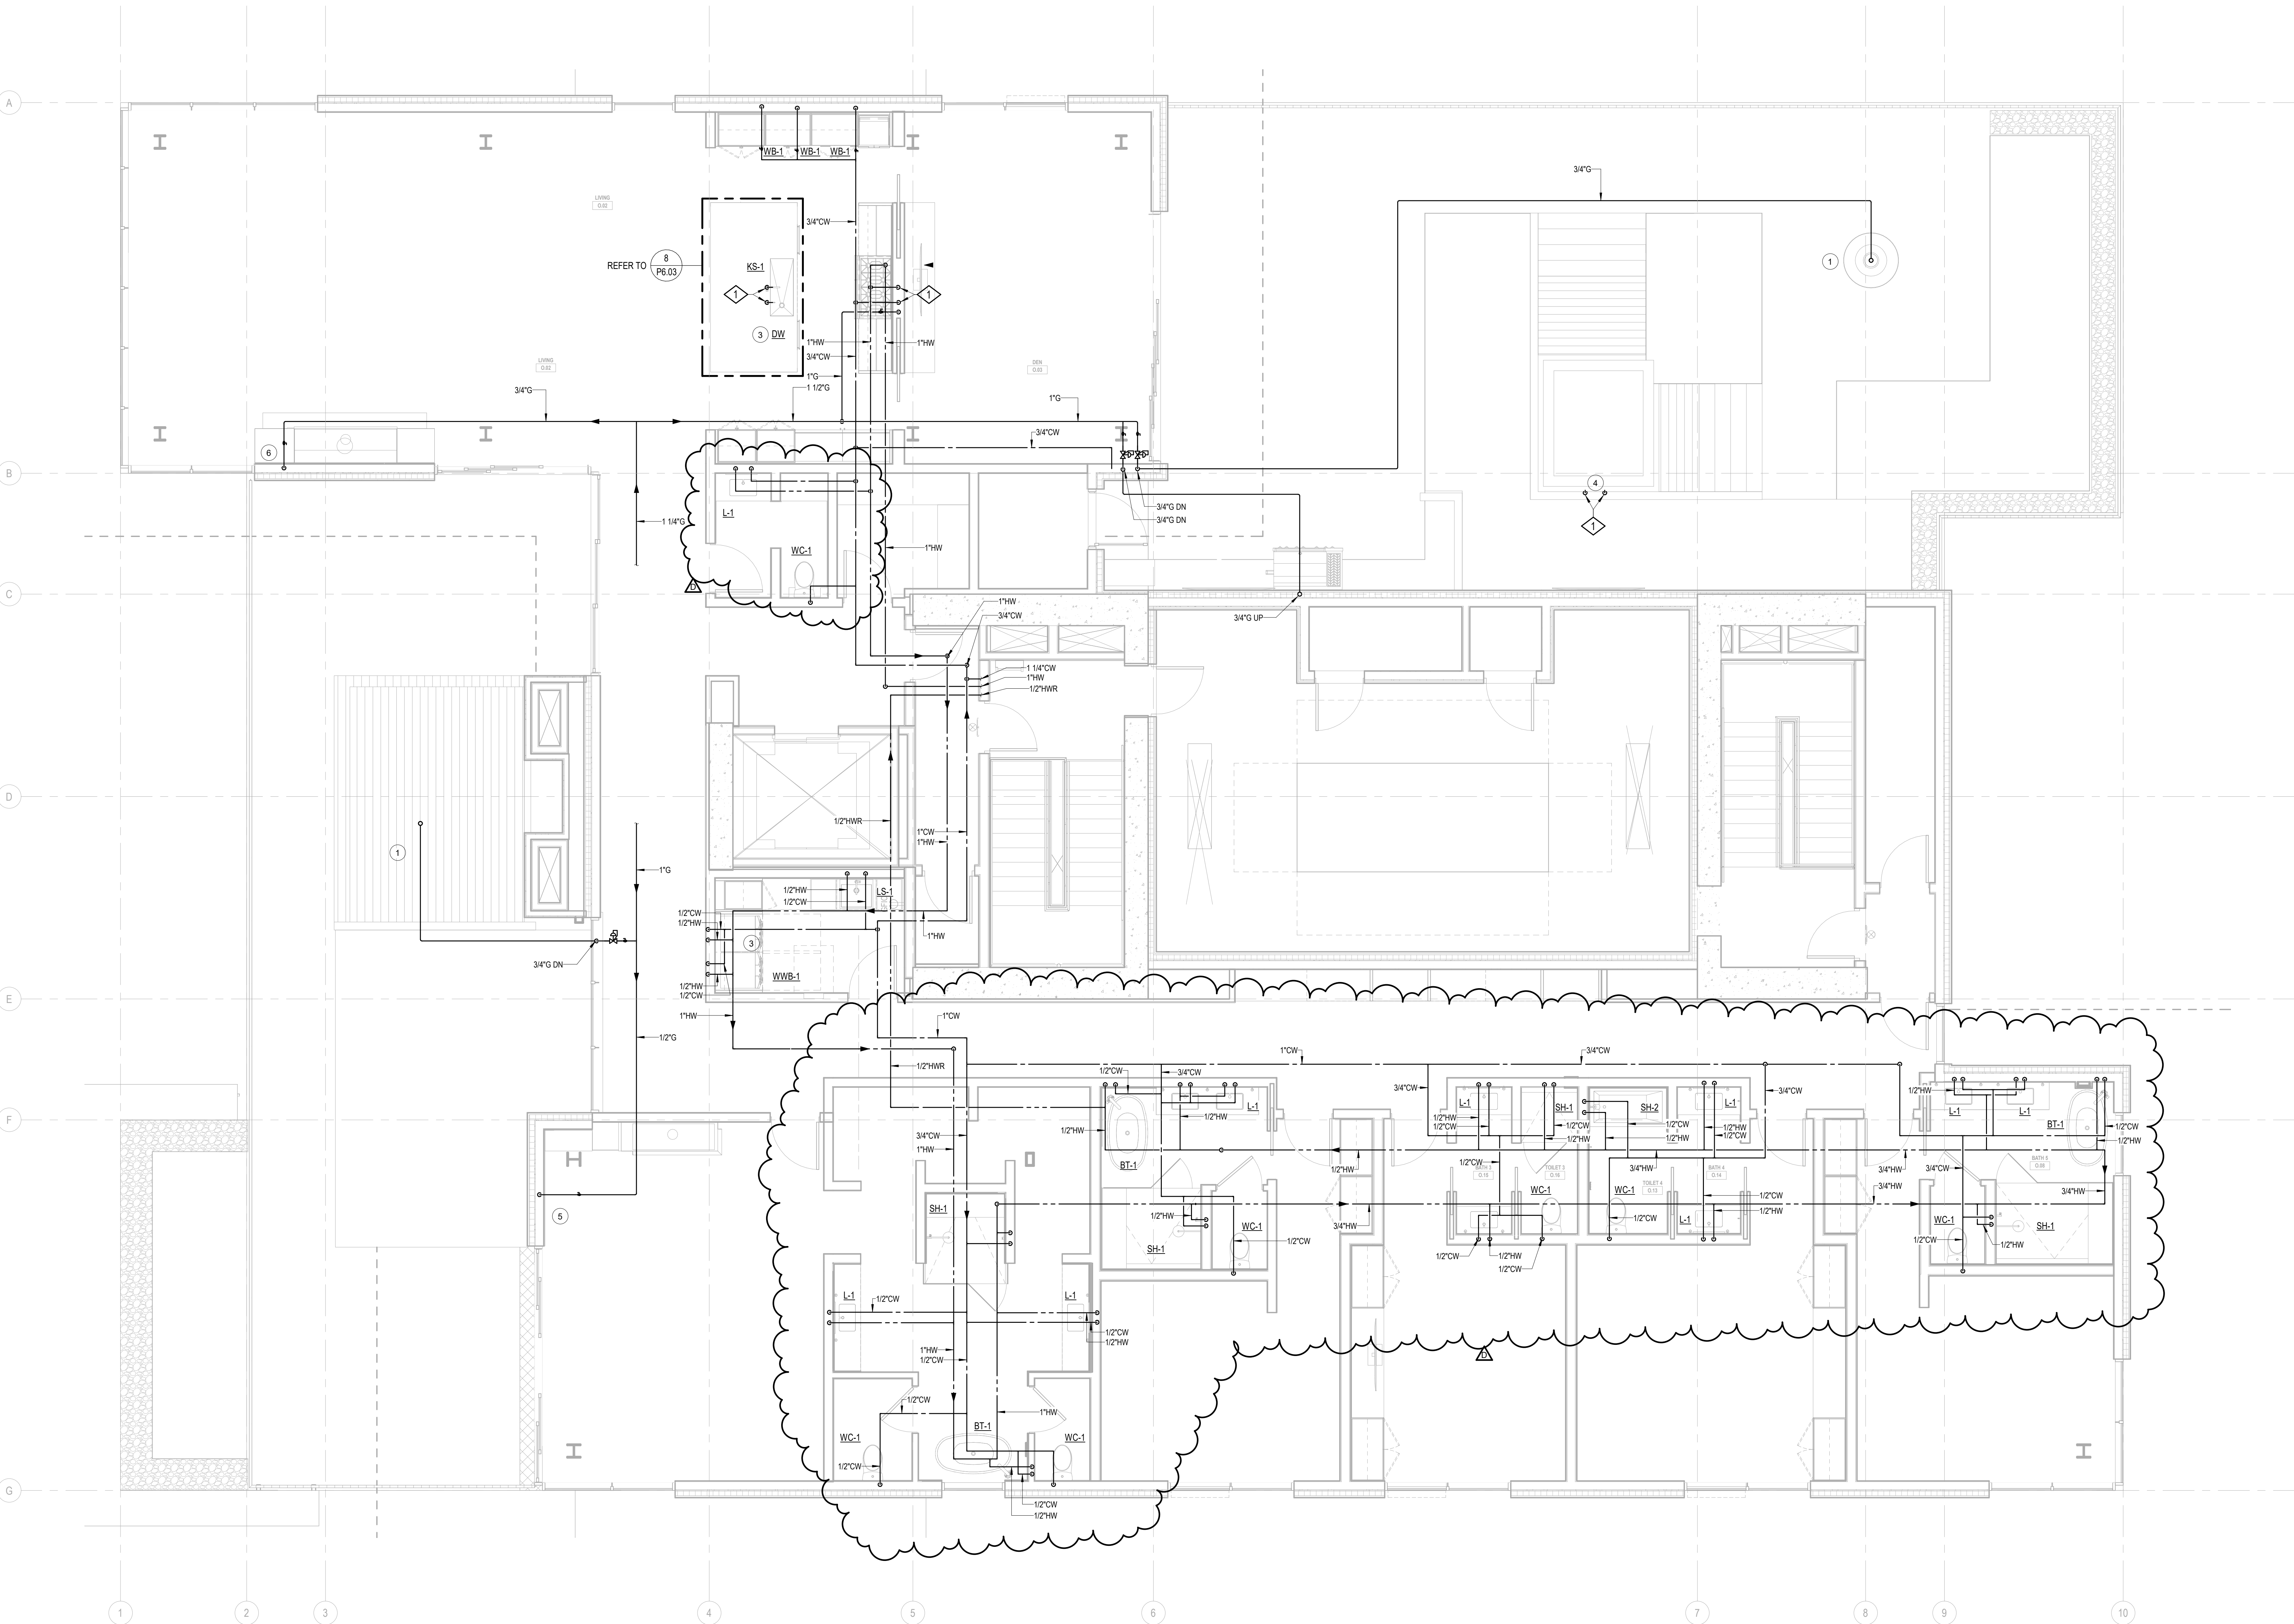

1 TOWER C-UNIT O
SCALE: 1/4" = 1'-0"

NUMBERED NOTES:
1 OPTION: PROVIDE 1/2" CW TO DUCT HUMIDIFIERS. SEE MECHANICAL PLANS FOR LOCATIONS. CONFIRM WITH OWNER PRIOR TO PROVIDING.

KEYNOTES:
1 1/2" CW & 1/2" HW DN

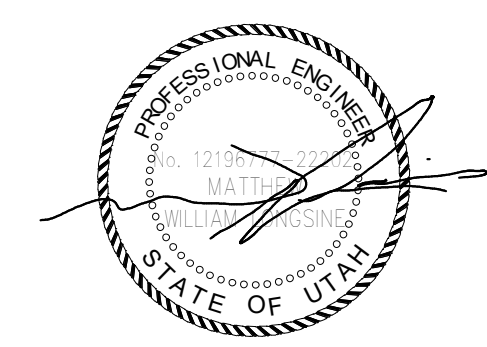

Reserved for permit stamp

103 South Jackson St., Suite 200
Seattle, Washington 98104 USA
+1 206 461 5970 olsonkundig.com

Olson Kundig

project: Sommet Blanc -C
DEER VALLEY, UTAH

ASPEN GROUP
Aspen Group USA, LLC
PO Box 980022
Park City, Utah 84098

Pool Consultant
Cloward H2O
2696 N University Ave., Suite 200
Provo, UT 84604

Landscape Architect
EPG Design
6948 South High Tech Drive, Suite 100
Midvale, Utah 84047

Specifications Writer
Friday Group
85 Mainelli Road
Middlebury, VT

Code Consultant
Holmes
600 1st Avenue, Suite 200A
Seattle, WA 98104

Fire Protection Engineer
Jensen Hughes
One Research Drive, Suite 305C
Westborough, MA 01581

Vertical Transportation Consultant
Lerch Bates
19515 North Creek Parkway, Suite 304
Bothell, WA 98011

Structural Engineer
Magnusson Klemencic Associates
1301 5th Ave., Suite 3200
Seattle, WA 98101

Lighting Designer
O
319 SE MLK Blvd., Suite 210
Portland, Oregon 97219

Building Envelope Consultant
RDH
2101 N 34th St
Seattle, WA 98103

Accessibility Consultant
Studio Pacifica
2144 Westlake Ave N, Suite F
Seattle, WA 98109


MEP Engineer
WSP USA
1001 Fourth Ave., Suite 3100
Seattle, WA 98154

principal architect _____
project manager _____
drawn by _____
checked by _____
job no. 2021-0356
date 5/31/2024

revisions:
D 08/23/2024 AS/003
no. date by

IFC Set 3 of 3
5/31/2024

UNIT PLAN - TOWER
C-UNIT O
P2.4.O

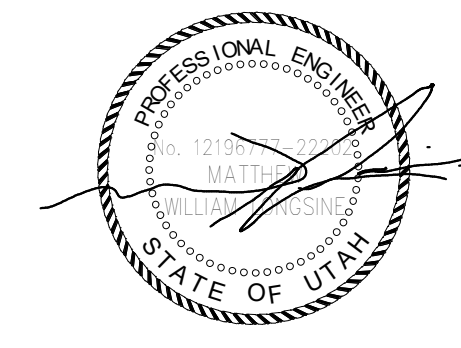

Reserved for permit stamp

100 South Jackson St., Suite 200
Seattle, Washington 98104 USA
+1 206 451 5070
aspen@aspen.com

Olson Kundig

project: **Sommet Blanc - Bldg AB**
DEER VALLEY, UTAH



Aspen Group USA, LLC
PO Box 980022
Park City, Utah 84098

Pool Consultant
Cloward H2O
2696 N University Ave., Suite 200
Provo, UT 84604

Landscape Architect
EPG Design
6940 South High Tech Drive, Suite 100
Midvale, Utah 84047

Specifications Writer
Friday Group
88 Mainell Road
Middlebury, VT

Code Consultant
Holmes
600 1st Avenue, Suite 200A
Seattle, WA 98104

Fire Protection Engineer
Jensen Hughes
One Research Drive, Suite 305C
Westborough, MA 01581

Vertical Transportation Consultant
Larch Bates
1915 North Creek Parkway, Suite 304
Bothell, WA 98011

Structural Engineer
Magnusson Klemencic Associates
1301 5th Ave., Suite 3200
Seattle, WA 98101

Lighting Designer
O-
1319 SE MLK Blvd., Suite 210
Portland, Oregon 97219

Building Envelope Consultant
RDH
2101 N 34th St
Seattle, WA 98103

Accessibility Consultant
Studio Pacifica
2144 Westlake Ave N, Suite F
Seattle, WA 98109

MEP Engineer
WSP USA
1001 Fourth Ave., Suite 3100
Seattle, WA 98154

principal architect _____
project manager _____
drawn by _____
checked by _____
job no. 2021-0395
date 5/31/2024


revisions:

D 1/10/2025 ASI 6
no. date by

IFC Set 3 of 3
5/31/2024

GAS RISER DIAGRAM

P7.05

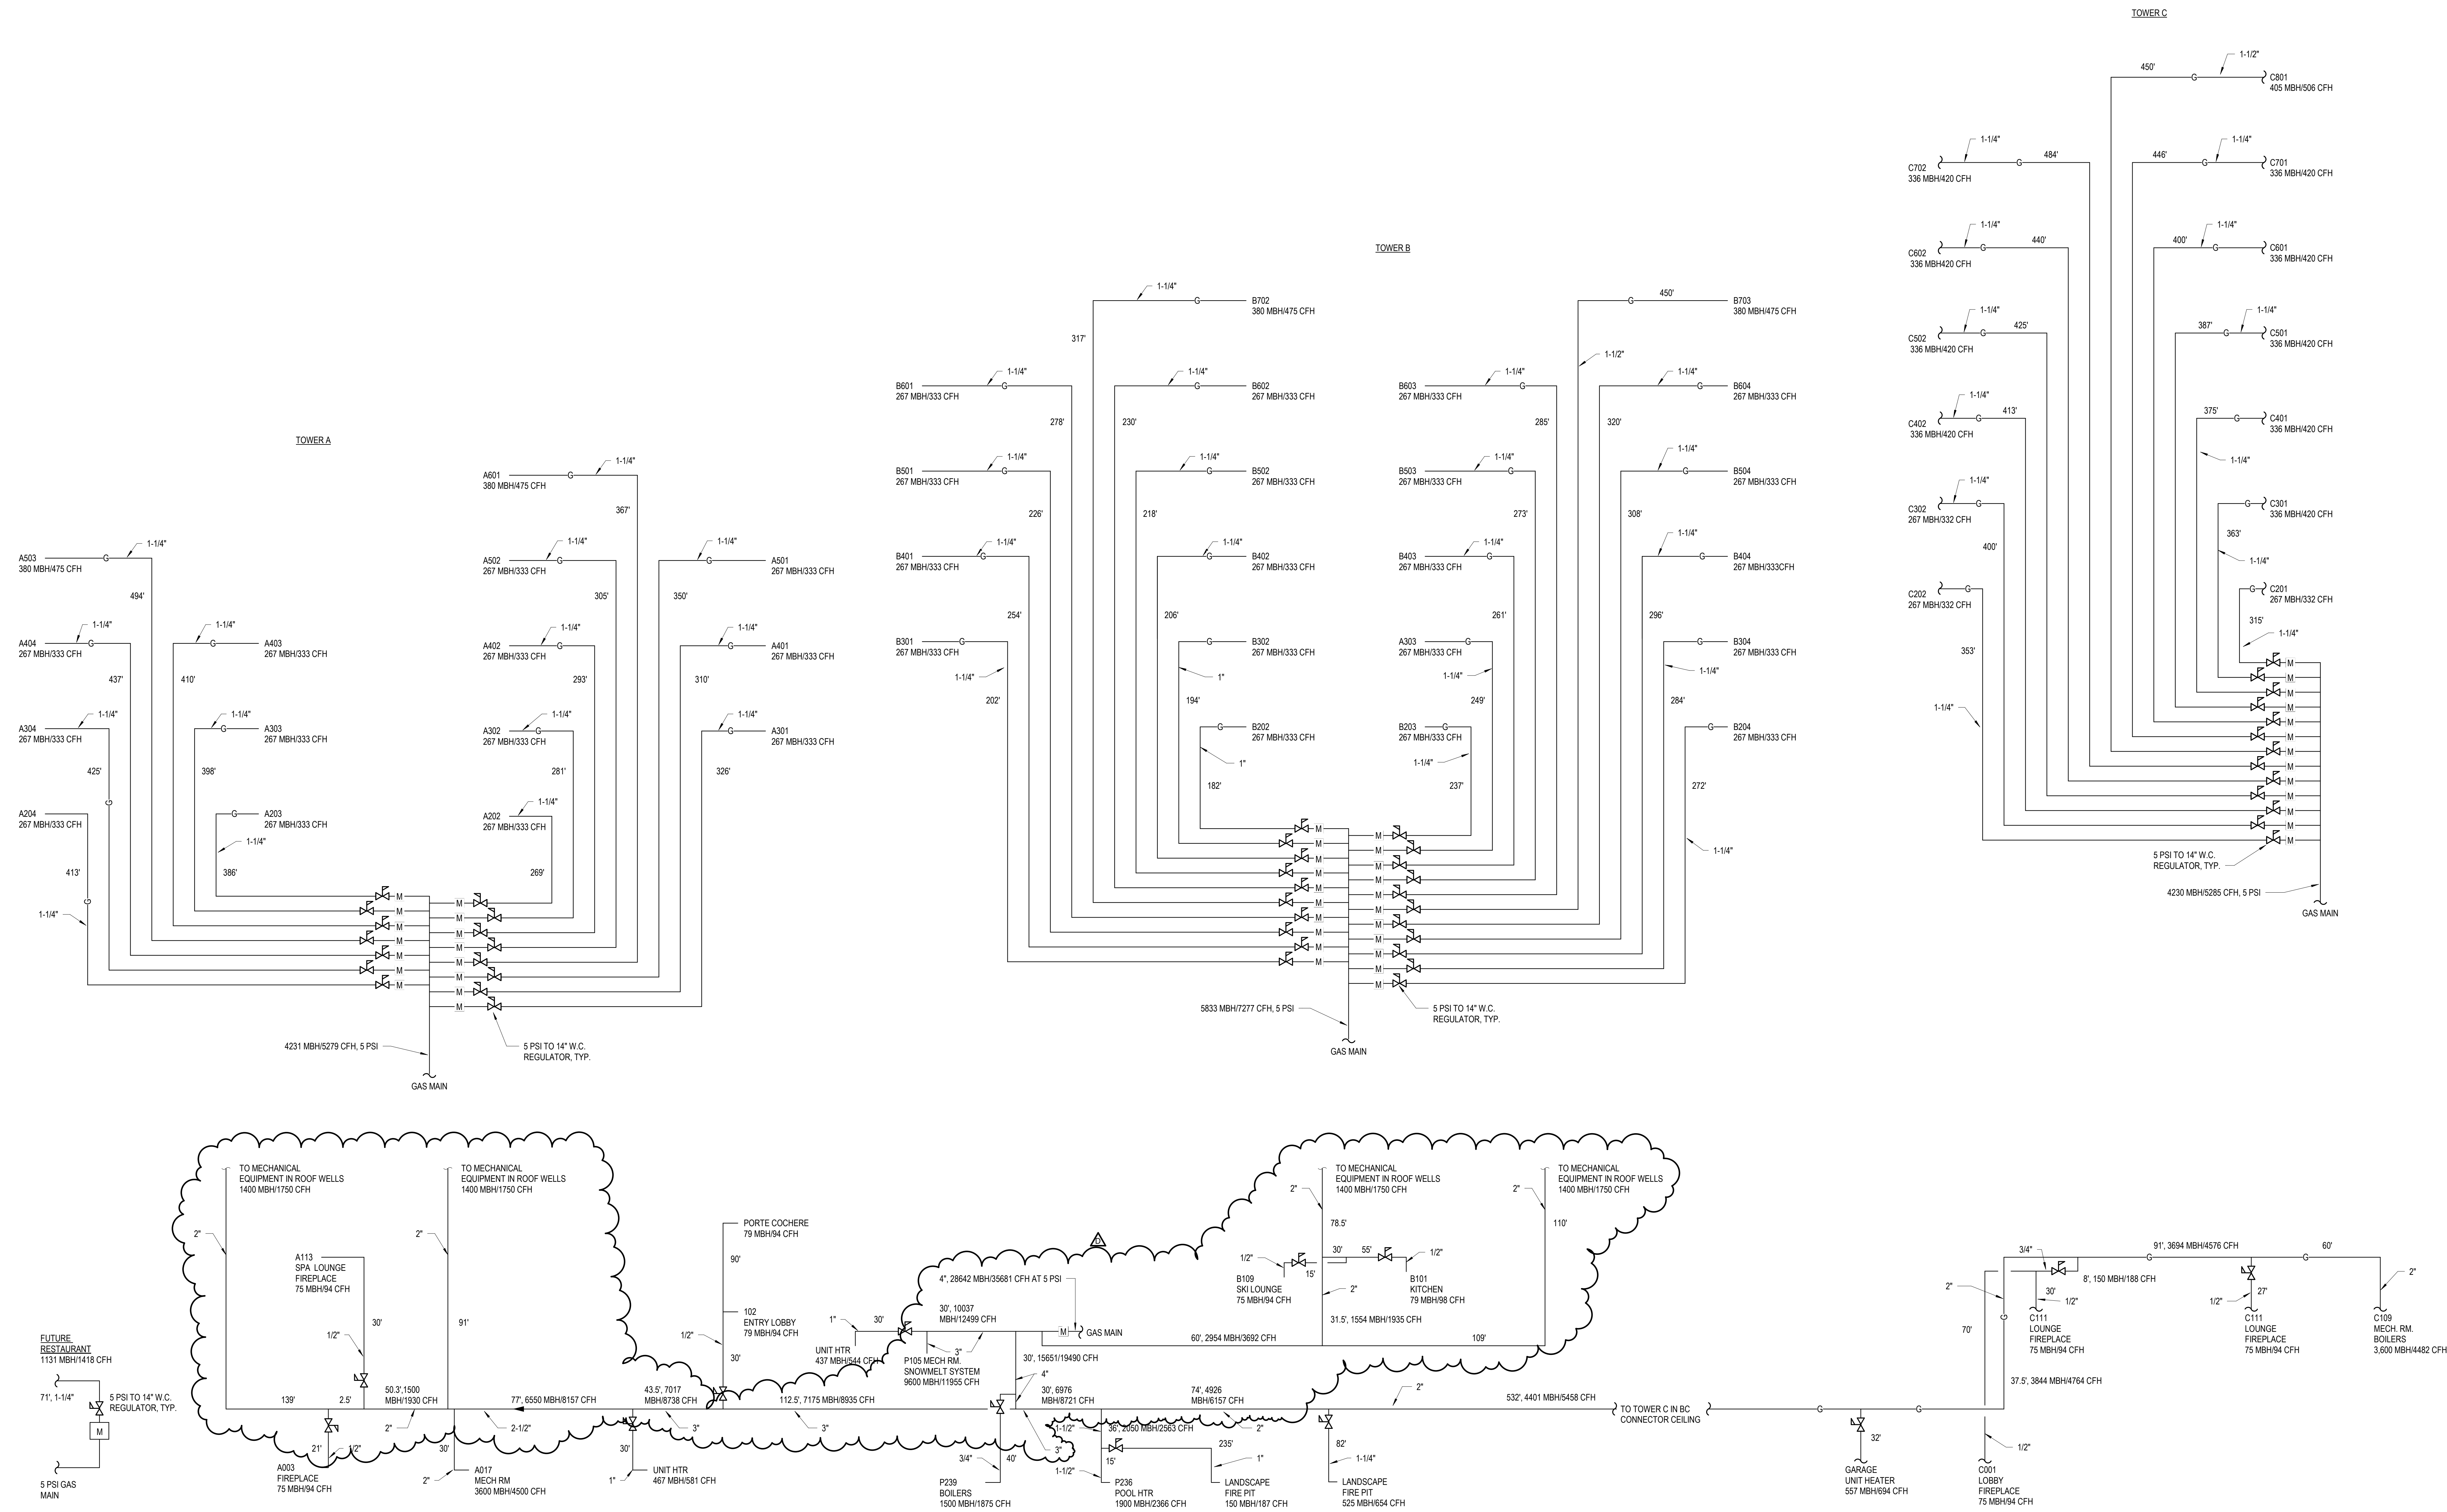

1 GAS RISER
SCALE: NTS