


Reserved for permit stamp

159 South Jackson St, Suite 800
Seattle, Washington 98104 USA
1 206 624 5670 olsonkundig.com

Olson Kundig

Project:
SOMMET BLANC
300 Marsac Ave (B2 East Parcel)

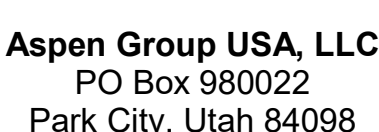

principal architect _____
project manager _____
drawn by _____
checked by Checker
job no. _____
date 05/31/2024

[illegible]

date

FC Set 3 of 3
05/31/2024


TOWER C - LVL 1
ELECTRICAL LIGHTING
PLAN

E3.3C.11

SHEET NOTES:

- A. DRAWINGS ARE INTENDED TO SHOW GENERAL ARRANGEMENT, DESIGN, EXIST OF WORK AND ARE DIAGRAMMATIC. DRAWINGS ARE NOT INTENDED TO SHOW EXACT LOCATIONS EXCEPT WHERE DIMENSIONS ARE SHOWN. ELECTRICAL WORK IS SHOWN ON A BASIS OF STANDARDS AND CONVENTIONS. THE CONTRACTOR SHALL BE RESPONSIBLE FOR COMMENCEMENT WITH WORK. VERIFY MEASUREMENTS PERTAINING THERETO AND ASSUME RESPONSIBILITY THEREFOR. ANY SUBSTANTIAL DIFFERENCES BETWEEN THE DRAWINGS AND THE ACTUAL FIELD CONDITIONS SHALL BE REPORTED TO THE CONSTRUCTION MANAGER FOR CONSIDERATION BEFORE PROCEEDING WITH WORK.
- B. WORK ITEMS INCLUDED INCLUDE, BUT ARE NOT LIMITED TO, THE FOLLOWING: REQUIRED TO INSPECT AND COMPLETE ELECTRICAL SYSTEM AS INDICATED ON DRAWINGS AND SPECIFICATIONS; PROVIDE EXIST SIGNS AND CONTACT EXIST SIGNS AND LUMINAIRES NOTED AS EMERGENCY USE; EMERGENCY POWER SUPPLY; EMERGENCY LIGHTING; EMERGENCY PLANS.
- C. REFER TO LUMINAIRE SCHEDULE FOR INFORMATION.
- D. CATALOG NUMBERS ARE SUBJECT TO CHANGE BY MANUFACTURER. VERIFY WITH MANUFACTURER.
- E. VERIFY EQUIPMENT TYPES AND POWER REQUIREMENTS FOR EQUIPMENT PROVIDED BY OTHERS.
- F. ELECTRICAL CONDUITS IN FINISHED SPACES SHALL BE CONCEALED. COORDINATE WITH OTHER TRADES AND USE CHASES AND CEILING SPACES. LOCATIONS OF ELECTRICAL JUNCTION BOXES IN FINISHED SPACES SHALL BE APPROVED BY ARCHITECT PRIOR TO RISE.

NUMBERED NOTES:

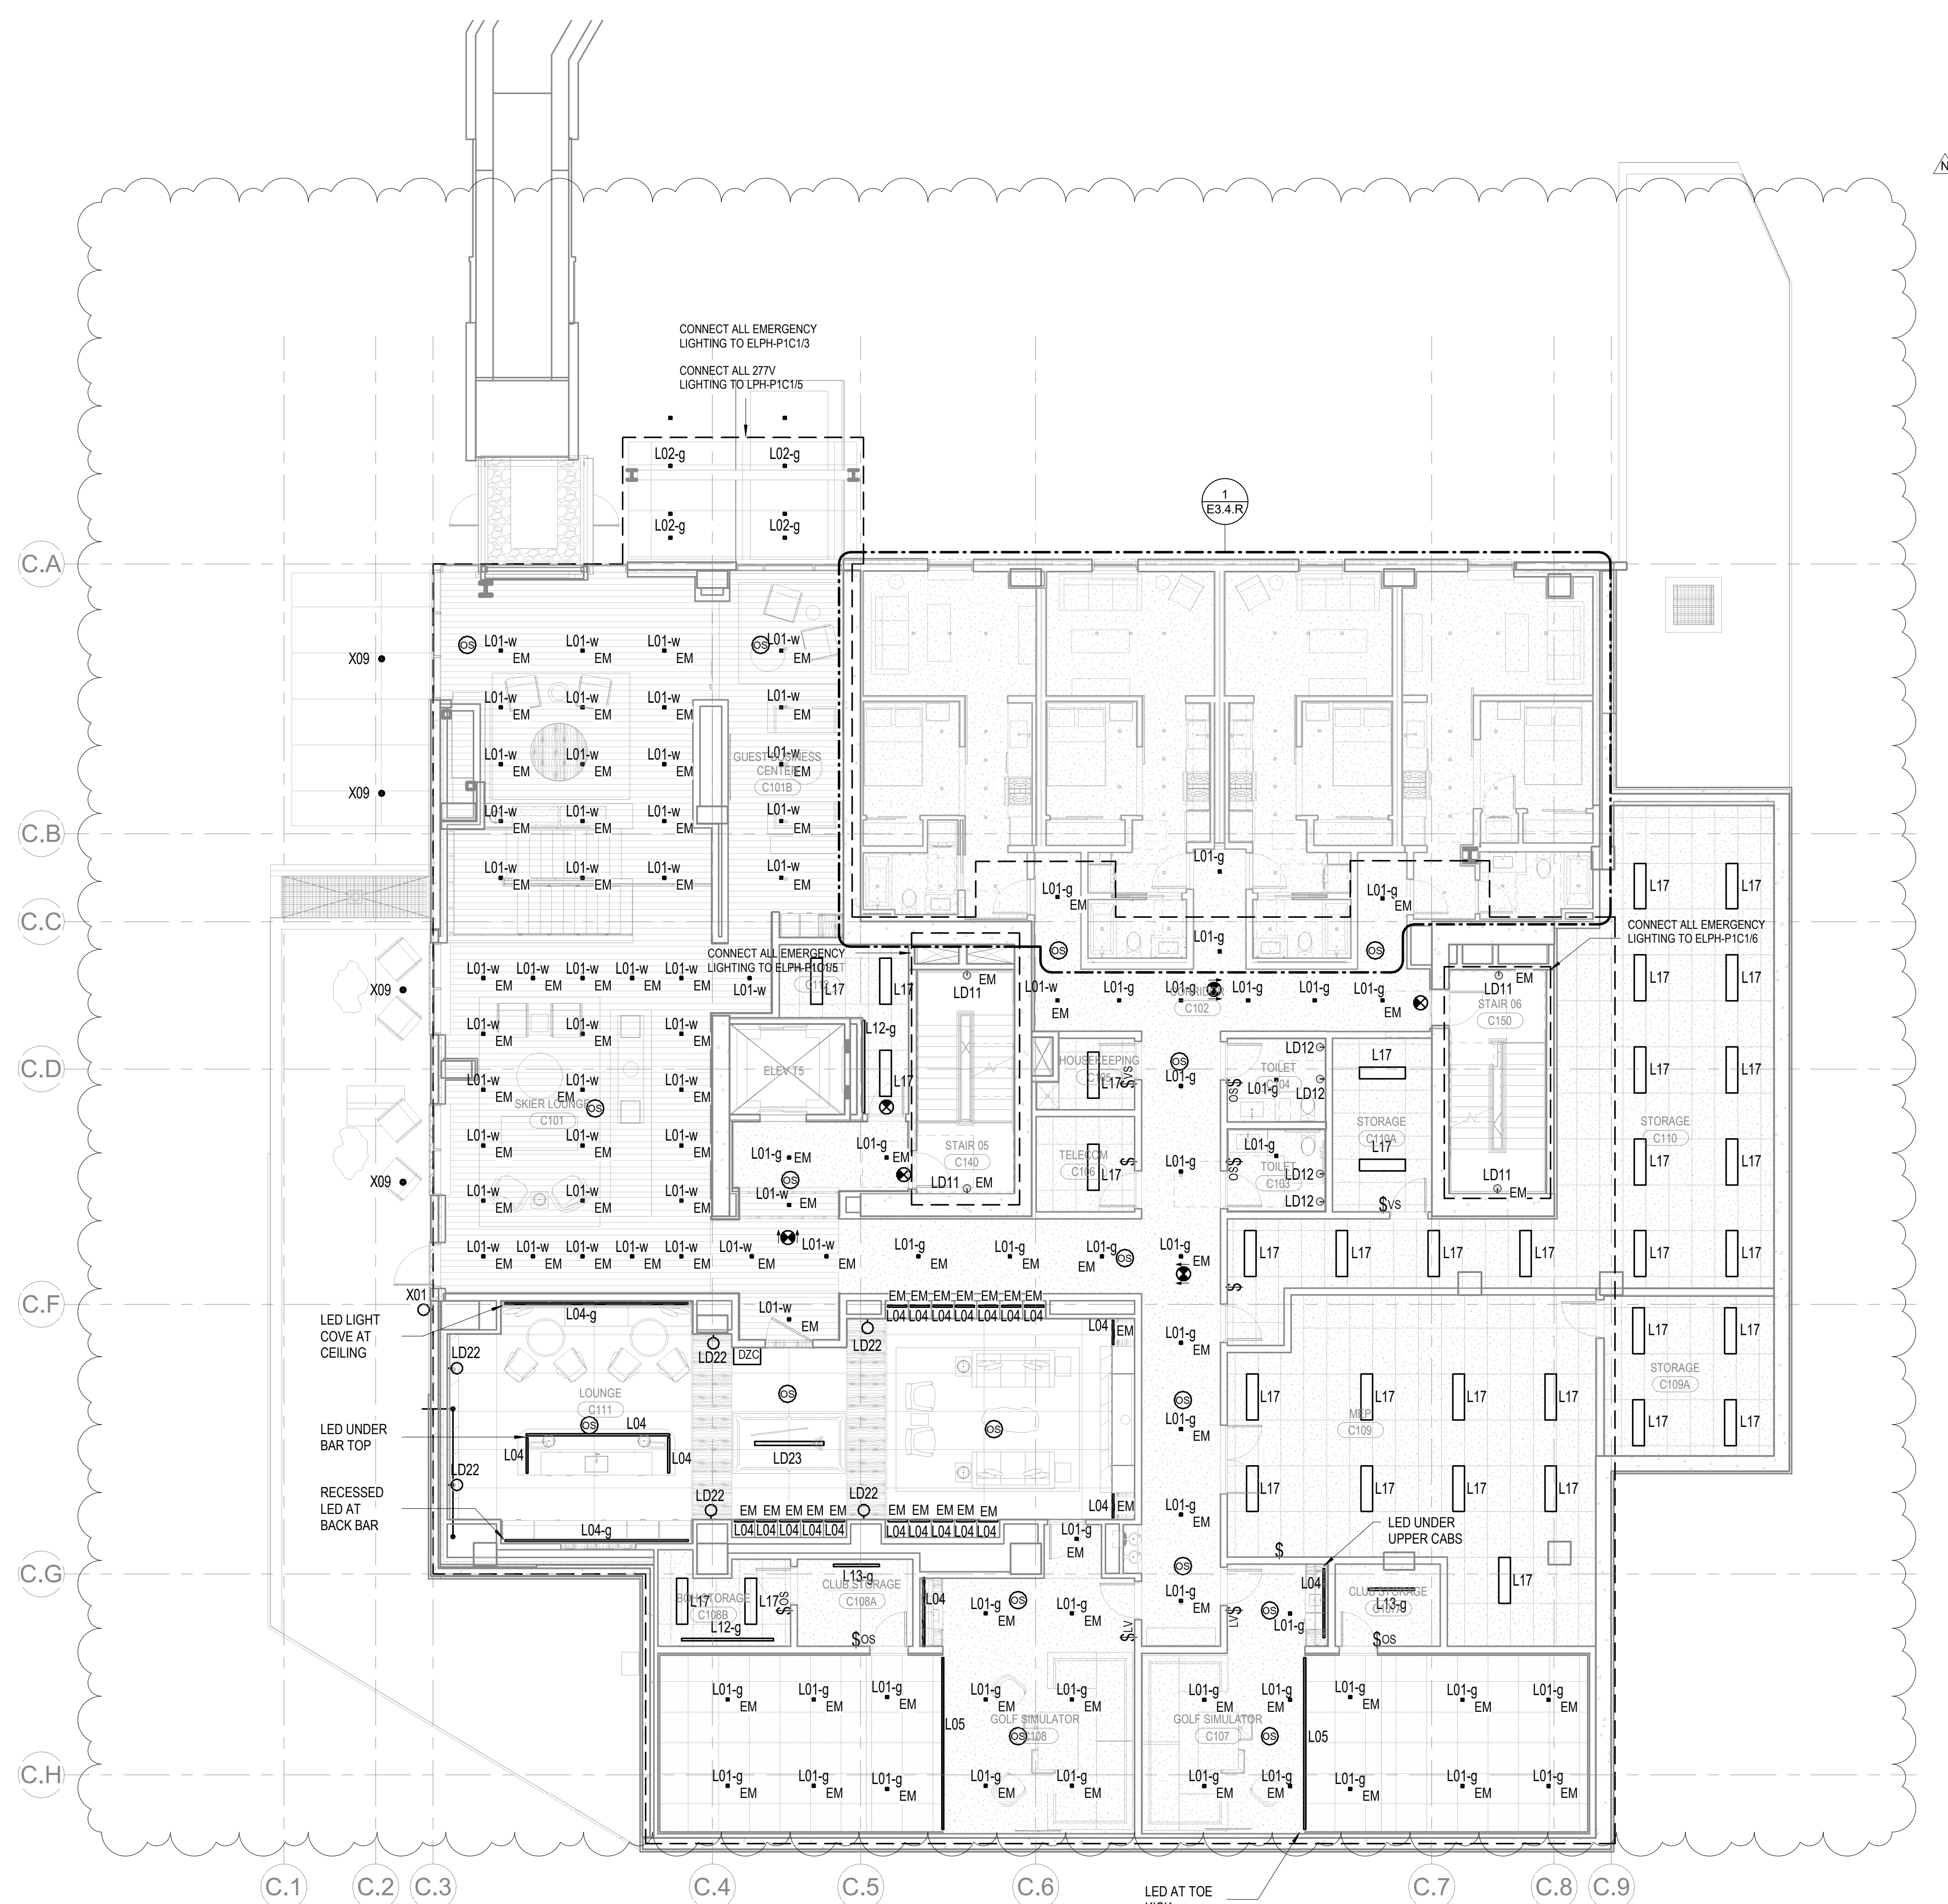

1 LEVEL 1 - LIGHTING PLAN
SCALE: 1/8" = 1'-0"

