


KEYNOTES:  
1 FIRE ALARM TERMINAL CABINET WITHIN 2-HR RATED SHUT ACCESSIBLE VIA 2-HR RATED ACCESS PANEL COORDINATE INSTALLATION AND ACCESS WITH DIVISION 26.

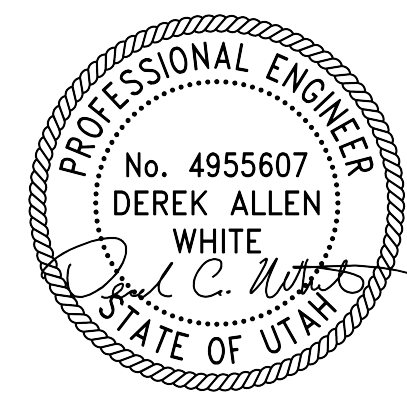

Reserved for permit stamp

139 South Jackson St., Suite 400  
Seattle, Washington 98104 USA  
+1 206 834 3870 olsonkunding.com

Olson Kunding

project  
SOMMET BLANC - AB  
DEER VALLEY, UTAH



Aspen Group USA, LLC  
PO Box 980022  
Park City, Utah 84098

Pool Consultant  
Cloward H2O  
2696 N University Ave., Suite 290  
Provo, UT 84604

Landscape Architect  
EPG Design  
6948 South High Tech Drive, Suite 100  
Midvale, Utah 84047

Specifications Writer  
Friday Group  
86 Mainelli Road  
Middlebury, VT

Code Consultant  
Holmes  
600 1st Avenue, Suite 200A  
Seattle, WA 98104

Fire Protection Engineer  
Jensen Hughes  
One Research Drive, Suite 305C  
Westborough, MA 01581

Vertical Transportation Consultant  
Larch Bates  
19515 North Creek Parkway, Suite 304  
Bothell, WA 98011

Structural Engineer  
Magnusson Klemencic Associates  
1301 5th Ave., Suite 3200  
Seattle, WA 98101

Lighting Designer  
O  
1319 SE MLK Blvd., Suite 210  
Portland, Oregon 97219

Building Envelope Consultant  
RDH  
2101 N 34th St  
Seattle, WA 98103

Accessibility Consultant  
Studio Pacifica  
2144 Westlake Ave N, Suite F  
Seattle, WA 98109

MEP Engineer  
WSP USA  
1001 Fourth Ave., Suite 3100  
Seattle, WA 98154

principal architect \_\_\_\_\_  
project manager \_\_\_\_\_ JCC  
drawn by \_\_\_\_\_ CRS, SMK  
checked by \_\_\_\_\_ Checker  
job no. \_\_\_\_\_ 2052  
date \_\_\_\_\_ 05/17/2024


revisions:  
\_\_\_\_\_  
\_\_\_\_\_  
A 05/08/25 ASI-012 - JH

no. \_\_\_\_\_ date \_\_\_\_\_ by \_\_\_\_\_

IFC Set 2 of 3  
05/17/2024

FIRE ALARM PLAN -  
TOWER A - LVL P2

FA2.2A.02

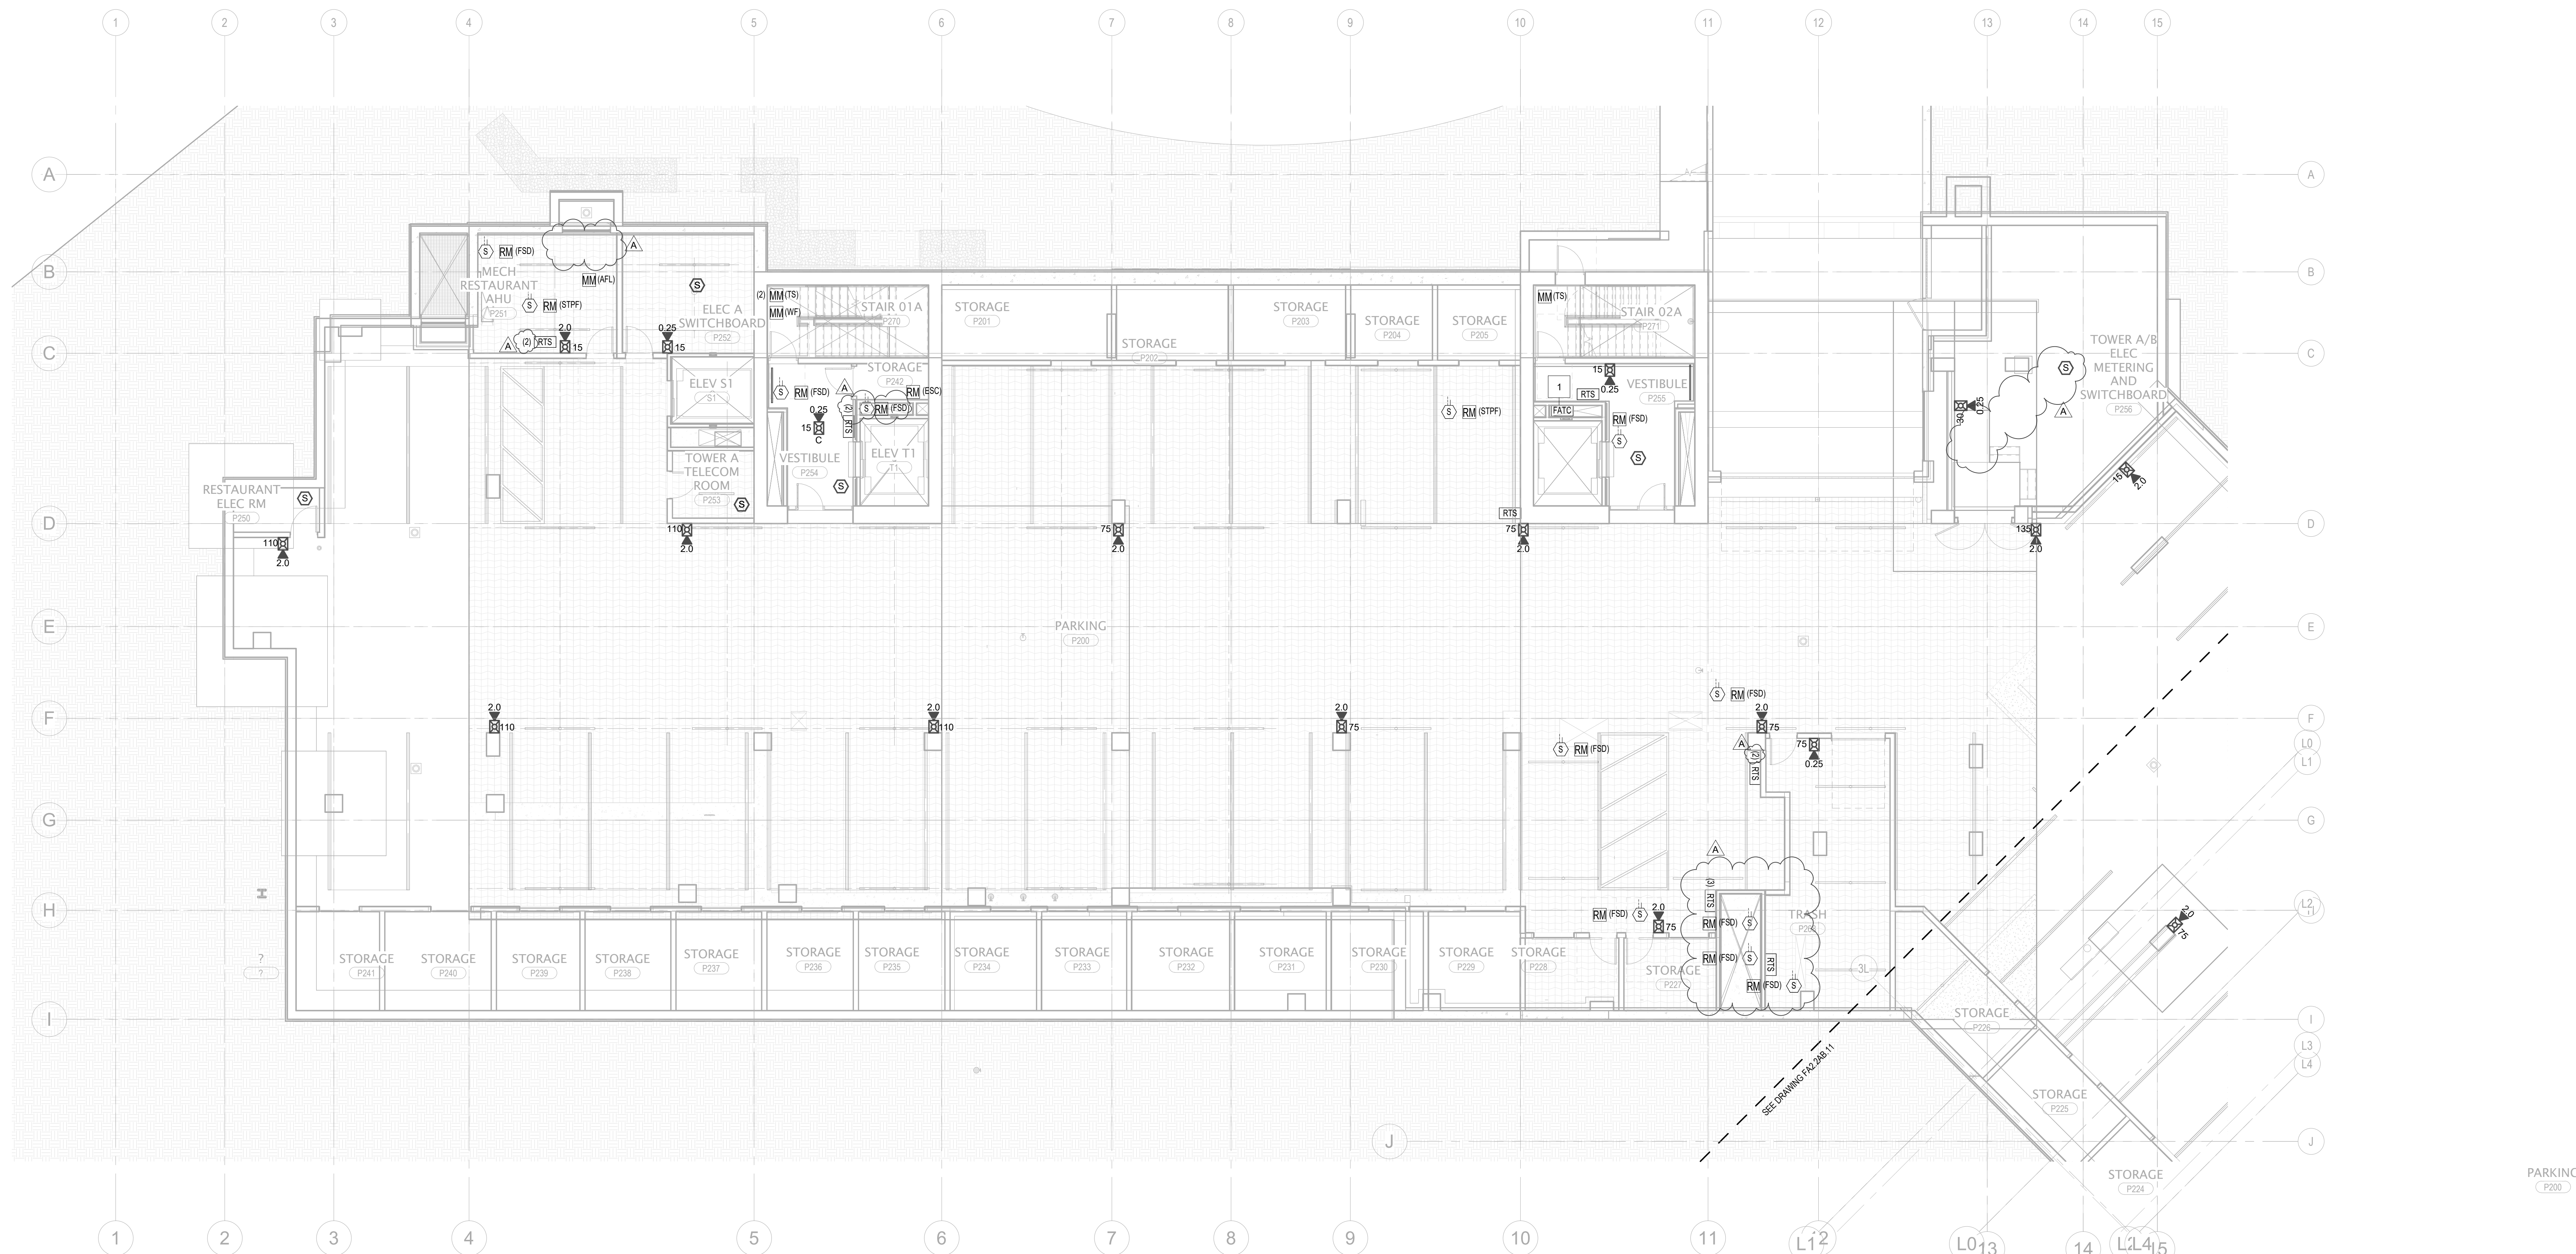

1 TOWER A - PARKING LEVEL 2A - FA  
1/8" = 1'-0"

