



Reserved for permit stamp

159 South Jackson St., Suite 600
Seattle, Washington 98104 USA
+1 206 834 3877 osoln@osoln.com

Olson Kundig

project
SOMMET BLANC - AB
DEER VALLEY, UTAH



Aspen Group USA, LLC
PO Box 980022
Park City, Utah 84098

Pool Consultant
Cloward H2O
2696 N University Ave., Suite 290
Provo, UT 84604

Landscape Architect
EPG Design
6948 South High Tech Drive, Suite 100
Midvale, Utah 84047

Specifications Writer
Friday Group
86 Marrett Road
Middletown, VT

Code Consultant
Holmes
600 1st Avenue, Suite 200A
Seattle, WA 98104

Fire Protection Engineer
Jensen Hughes
One Research Drive, Suite 305C
Westborough, MA 01581

Vertical Transportation Consultant
Larch Bates
19515 North Creek Parkway, Suite 304
Bothell, WA 98011

Structural Engineer
Magnusson Klemencic Associates
1301 5th Ave., Suite 3200
Seattle, WA 98101

Lighting Designer
O-
1319 SE MLK Blvd., Suite 210
Portland, Oregon 97219

Building Envelope Consultant
RDH
2101 N 34th St
Seattle, WA 98103

Accessibility Consultant
Studio Pacifica
2144 Westlake Ave N, Suite F
Seattle, WA 98109

MEP Engineer
WSP USA
1001 Fourth Ave., Suite 3100
Seattle, WA 98154

principal architect _____
project manager _____ JCC
drawn by _____ CRS, SMK
checked by _____ Checker
job no. _____ 2052
date _____ 05/17/2024

revisions:

A 05/08/25 ASI-012 - JH


no. _____ date _____ by _____

IFC Set 2 of 3
05/17/2024

FIRE ALARM PLAN -
TOWER A - LVL 1

FA2.2A.11

- KEYNOTES:
- 1 MULTIPLE CRITERIA DETECTOR PROGRAMMED FOR ALARM VERIFICATION
 - 2 FIRE ALARM TERMINAL CABINET WITH 2-HR RATED SHAFT ACCESSIBLE VIA 2-HR RATED ACCESS PANEL. COORDINATE INSTALLATION AND ACCESS WITH DIVISION 28. TRANSITION FROM 2-HR CC TO FPL CABLE IN EMT AT THIS POINT.
 - 3 2-HR CC SLC AND NAC FROM FGC TO 2-HR RATED SHAFT AND STAIRS. ROUTING SHOWN FOR CONCEPTUAL PURPOSES ONLY. MULTIPLE RACEWAYS MAY BE REQUIRED BASED UPON CONDUIT FILL REQUIREMENTS.
 - 4 PULL STATIONS FOR TOTAL BUILDING EVACUATION IN TOWERS AB AND TOWER C.
 - 5 DEDICATED SPEAKER CIRCUIT (2-HR CC) TO STAIR SPEAKERS. TRANSITION TO FPL IN EMT AT FIRST DEVICE.
 - 6 STAIR SPEAKER FOR MANUAL PAGING CONNECTED TO DEDICATED CIRCUIT.

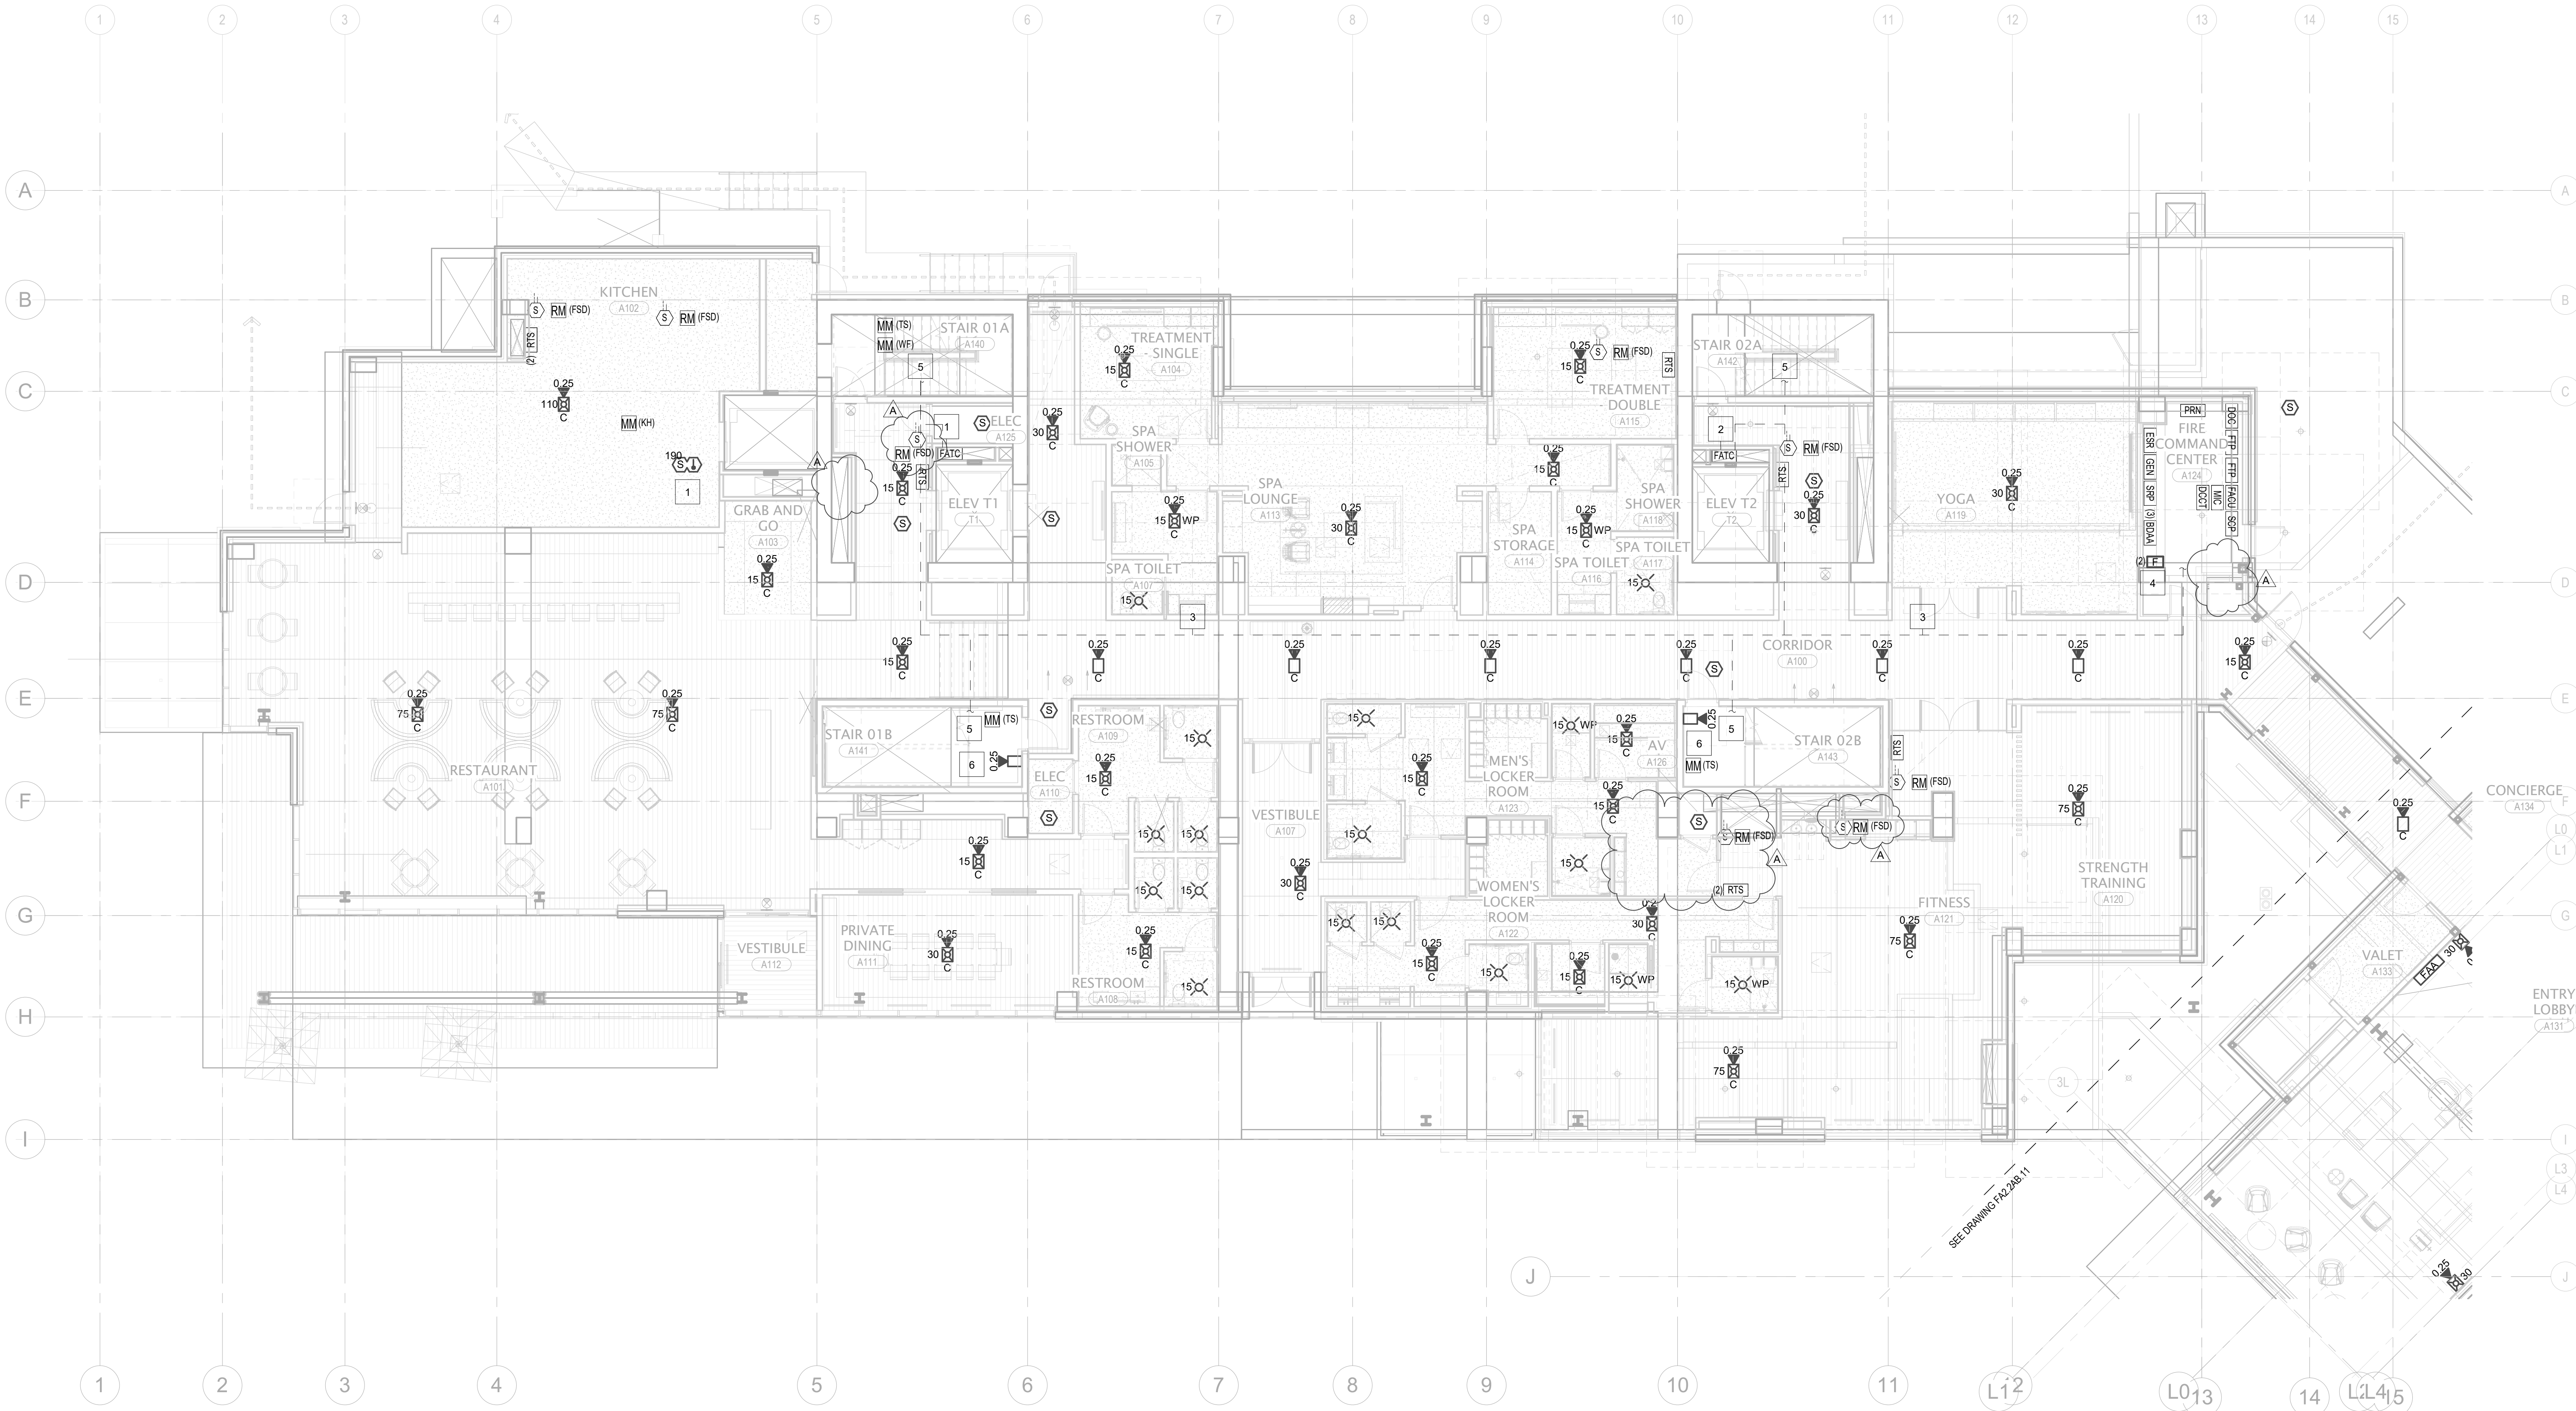

1 TOWER A - LEVEL 1A - FA
1/8" = 1'-0"

