


150 South Jackson St, Suite 600
Seattle, Washington 98104 USA
206.424.5670 olebrook.com

Olson Kundig

project:
SOMMET BLANC
33300 Marsac Ave (B2 East Parcel)
County: Webb, 84060

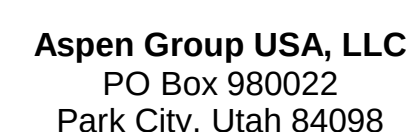

Pool Consultant
Cloward H2O
2696 N University Ave, Suite 290
Provo, UT 84604

Landscape Architect
EPG Design
6949 South High Tech Drive, Suite 100
Midvale, Utah 84047

Specifications Writer

Specifications Writer
Friday Group
88 Mainelli Road
Middlebury, VT

Corie Consultant
Holmes
600 1st Avenue, Suite 200A
Seattle, WA 98104

Fire Protection Engineer
Jensen Hughes
One Research Drive, Suite 305C
Westborough, MA 01581

Vertical Transportation Consultant
Lerch Bates
19515 North Creek Parkway, Suite 300
Bothell, WA 98011

Structural Engineer
Magnusson Klemencic Associates
1301 5th Ave, Suite 3200
Seattle, WA 98101

Lighting Designer
O.
1319 SE MLK Blvd, Suite 210
Portland, Oregon 97214

Building Envelope Consultant
RDH
2101 N 34th St
Tulsa, OK 74103

Accessibility Consultant
Studio Pacifica
2144 Westlake Ave N, Suite F

MEP Engineer
WSP USA
1001 Fourth Ave., Suite 3100

principal architect_____

drawn by _____

checked by Checker

date 05/31/2024

revisions:

N 05/21/2025 ASI 011

10.1111/j.1365-2745.2012.02001.x

IFC Set 3 of 3

03/31/2024

TOWER C - LVL 1
ELECTRICAL LIGHTING


PLAN

E3.3C.11

SHEET NOTES:

- A. DRAWINGS ARE INTENDED TO SHOW GENERAL ARRANGEMENT, DESIGN, AND EXTENT OF WORK AND ARE DIAGRAMMATIC. DRAWINGS ARE NOT INTENDED TO SHOW EXACT LOCATIONS EXCEPT WHERE DIMENSIONS ARE SHOWN. ELECTRICAL WORK IS SHOWN ON PLANS USING STANDARD INDUSTRY SYMBOLS. BEFORE ORDERING MATERIALS OR COMMENCEMENT WITH WORK, VERIFY MEASUREMENTS PERTAINING THERETO AND ASSUME RESPONSIBILITY THEREFOR. ANY SUBSTANTIAL DIFFERENCES BETWEEN DRAWINGS AND CONDITIONS IN THE FIELD SHALL BE SUBMITTED TO THE CONSTRUCTION MANAGER FOR CONSIDERATION.
- B. WORK PERFORMED INCLUDES LABOR, MATERIALS, AND EQUIPMENT REQUIRED TO INSTALL COMPLETE ELECTRICAL SYSTEM AS INDICATED ON DRAWINGS AND SPECIFICATIONS.
- C. ALL TYPES AND SIZES OF ELECTRICAL WIRING AND MINIMUMS USED AS EMERGENCY TO EMERGENCY POWER SOURCE AS INDICATED ON PLANS.
- D. REFER TO LUMINAIRE SCHEDULE FOR INFORMATION.
- E. FUTURE FLOOR NUMBER, LEVEL, AND MAJOR CHANGE BY MANUFACTURER. VERIFY FUTURE CATEGORY NUMBERS FOR ACCURACY.
- F. VERIFY EQUIPMENT SIZES AND POWER REQUIREMENTS FOR EQUIPMENT PROVIDED BY OTHERS.
- G. ELECTRICAL CONDUTS IN FINISHED SPACES SHALL BE CONCEALED. COORDINATE WITH OTHER TRADES AND USE CHASES AND CEILING SPACES. LOCATIONS OF ELECTRICAL JUNCTION BOXES IN FINISHED SPACES SHALL BE APPROVED BY ARCHITECT PRIOR TO ROUGH-IN.
- H.

 # NUMBERED NOTES:

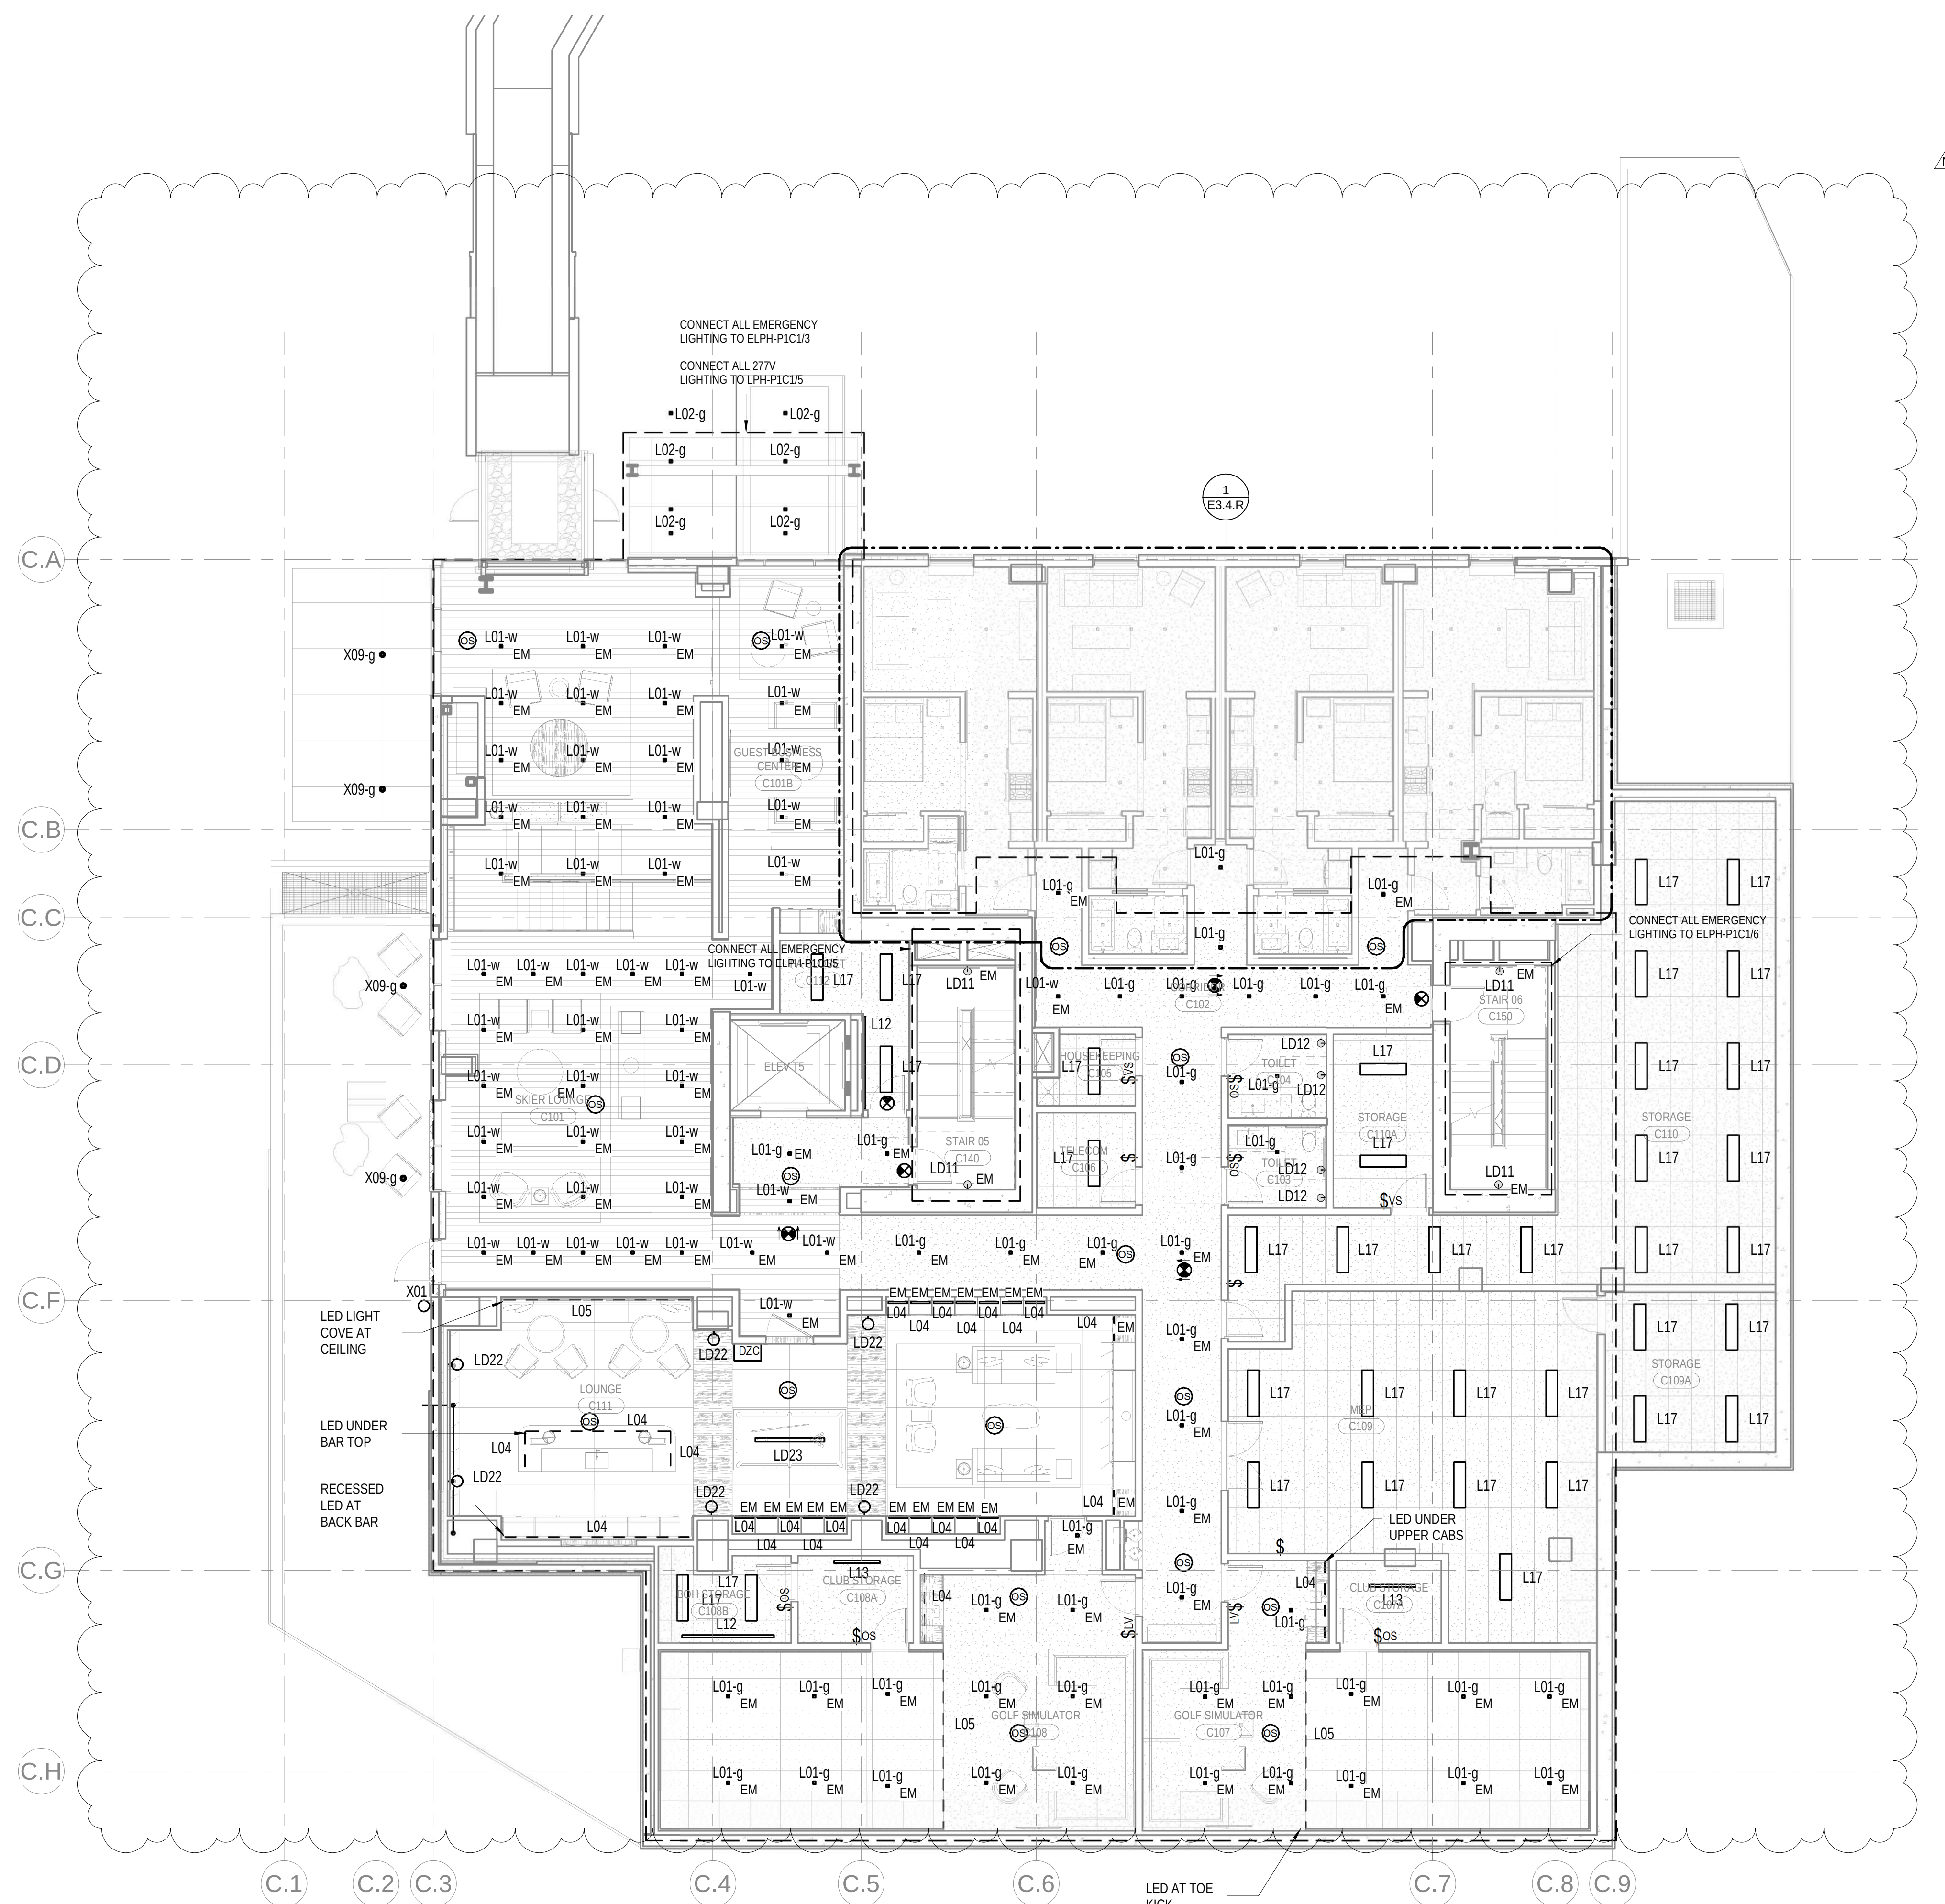

1 LEVEL 1 - LIGHTING PLAN
SCALE: 1/8" = 1'-0"

