


150 South Jackson St, Suite 800
Seattle, Washington 98104 USA
+1 206 624 5670 olsonkundig.com

project:
SOMMET BLANC
9300 Marsac Ave (B2 East Parcel)
Park City, Utah 84060

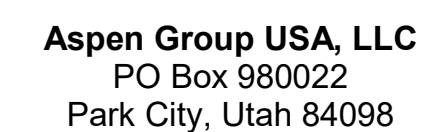

EPG Design
949 South High Tech Drive, Suite 100
Midvale, Utah 84047

Code Consultant
Holmes
100 1st Avenue,
Seattle, WA 98101

**Vertical Transport
Arch Bates**
9515 North Crest
Clothell, WA 98011

Lighting Designers
319 SE MLK BL
Portland, Oregon

Accessibility Coordinator
Studio Pacifica
144 Westlake Ave
Seattle, WA 98110

principal arch

check
jo

 
 
 
 
 
 
 
 
 
IS:
CONS


ELECTRIC
AND ABBE

E

[illegible]

RACEWAY LEGEND


	CONDUIT CONCEALED ABOVE CEILING OR WITHIN WALL
	CONDUIT BELOW GRADE OR EMBEDDED WITHIN SLAB
	CONDUIT UP
	CONDUIT DOWN
	CONDUIT STUBBED OUT WITH BUSHING NOTE: PROVIDE PULLSTRING IN EACH EMPTY RACEWAY
	CONDUIT STUBBED OUT AND CAPPED NOTE: PROVIDE PULLSTRING IN EACH EMPTY RACEWAY
	AUDIO/VISUAL SYSTEM RACEWAY
	CABLE TRAY
	GROUNDING SYSTEM RACEWAY
	TELECOM SYSTEM RACEWAY NOTE: PROVIDE PULLSTRING IN EACH EMPTY RACEWAY
	CONDUIT HOMERUN NOTE: MAXIMUM OF THREE BRANCH CIRCUITS FOR EACH HOMERUN, UON
	PHASE CONDUCTOR(S)
	GROUNDING CONDUCTOR
	ISOLATED GROUNDING CONDUCTOR
	NEUTRAL CONDUCTOR

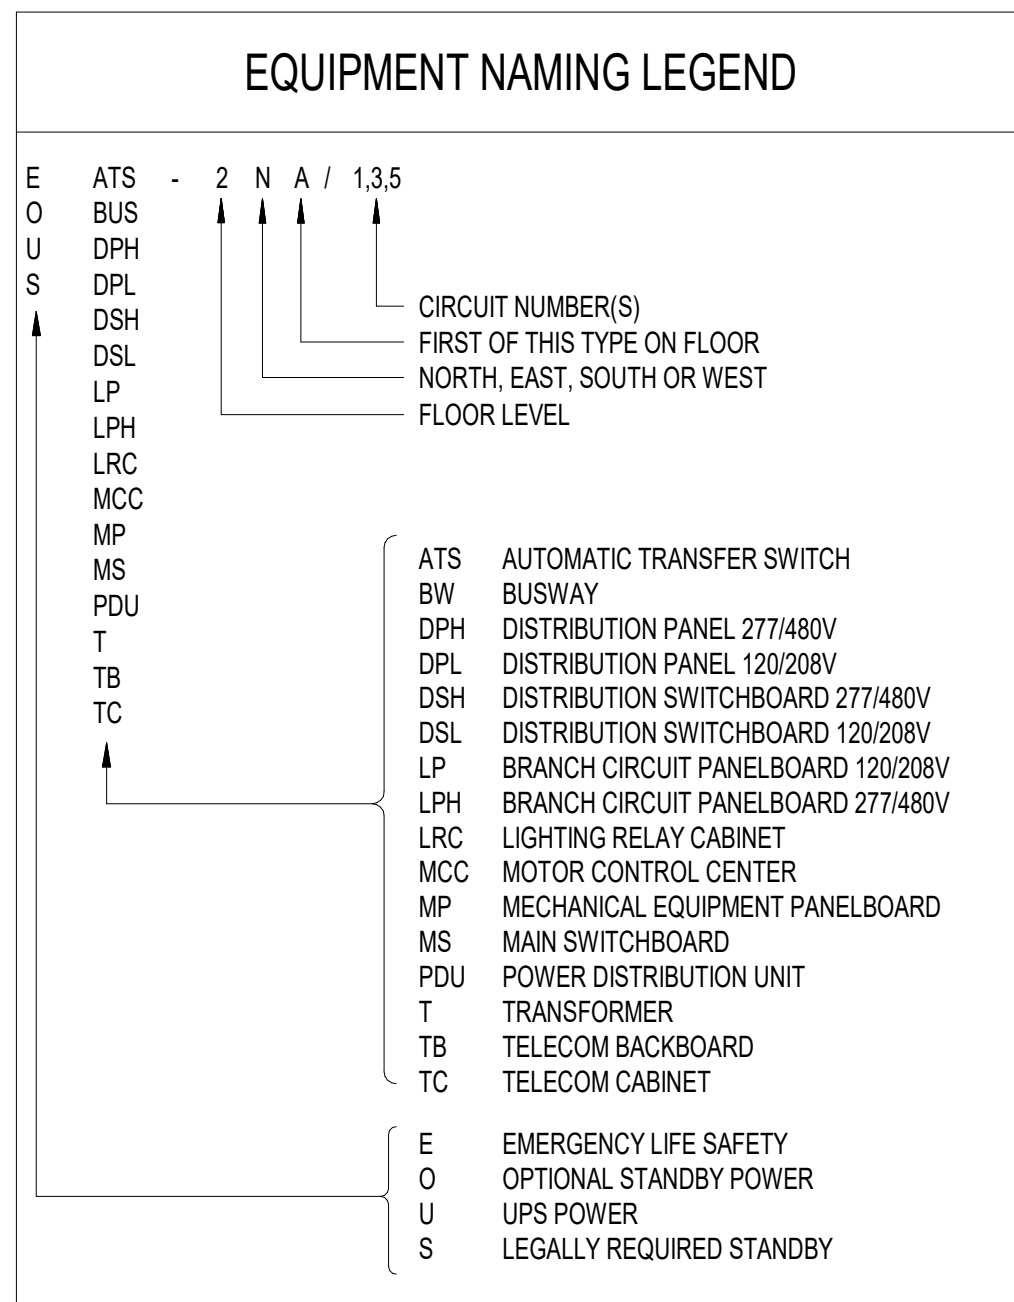

159 South Jackson St, Suite 800
Seattle, Washington 98104 USA
+1 206 624 5670 olsonkundig.com

Olson Kundig

SOMMET BLANC
9300 Marsac Ave (B2 East Parcel)
Park City, Utah 84060

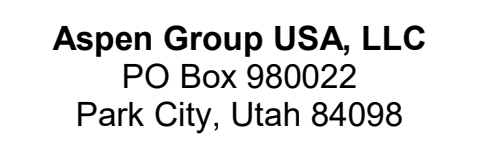

principal architect _____
project manager _____
drawn by _____
checked by Checker _____
job no. _____
date 11/18/2022




[illegible]

no.	date	by
-----	------	----

ISSUE FOR
CONSTRUCTION
11/18/2022


EGRESS LIGHTING LEVEL CALCULATION - TOWER A CORES

E0.03

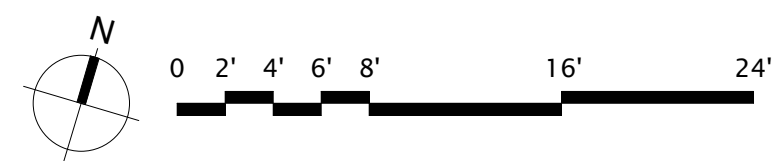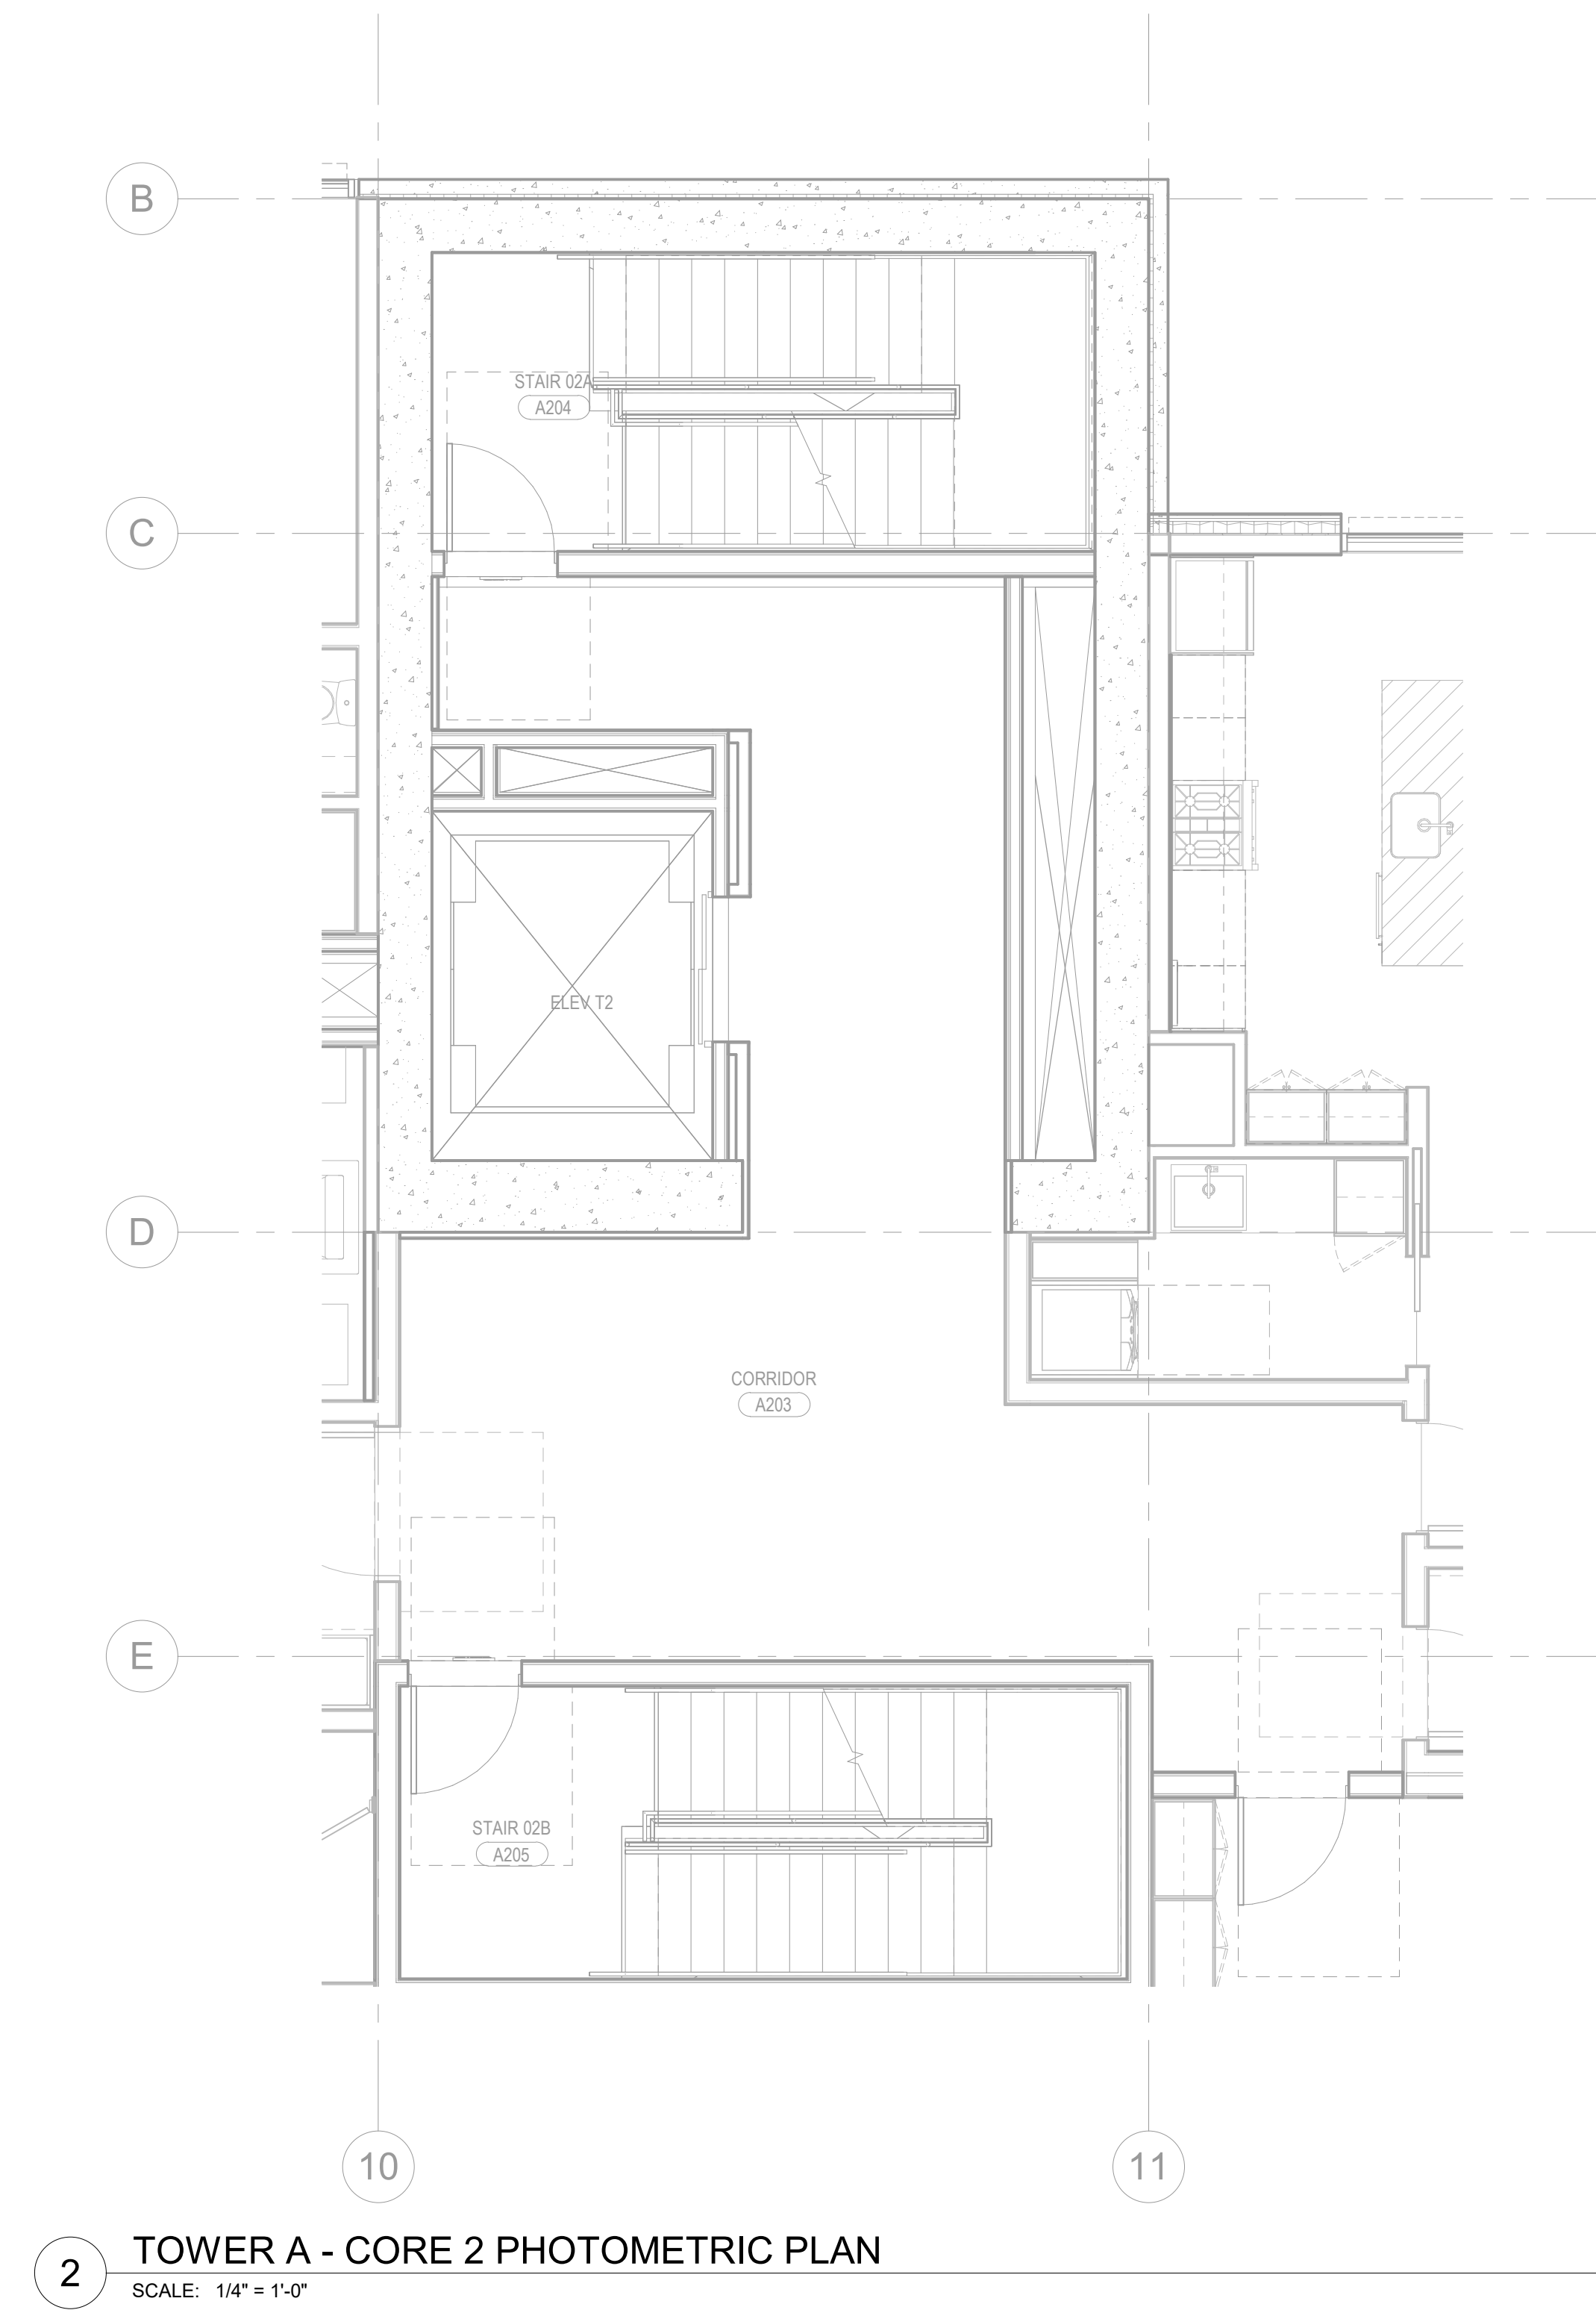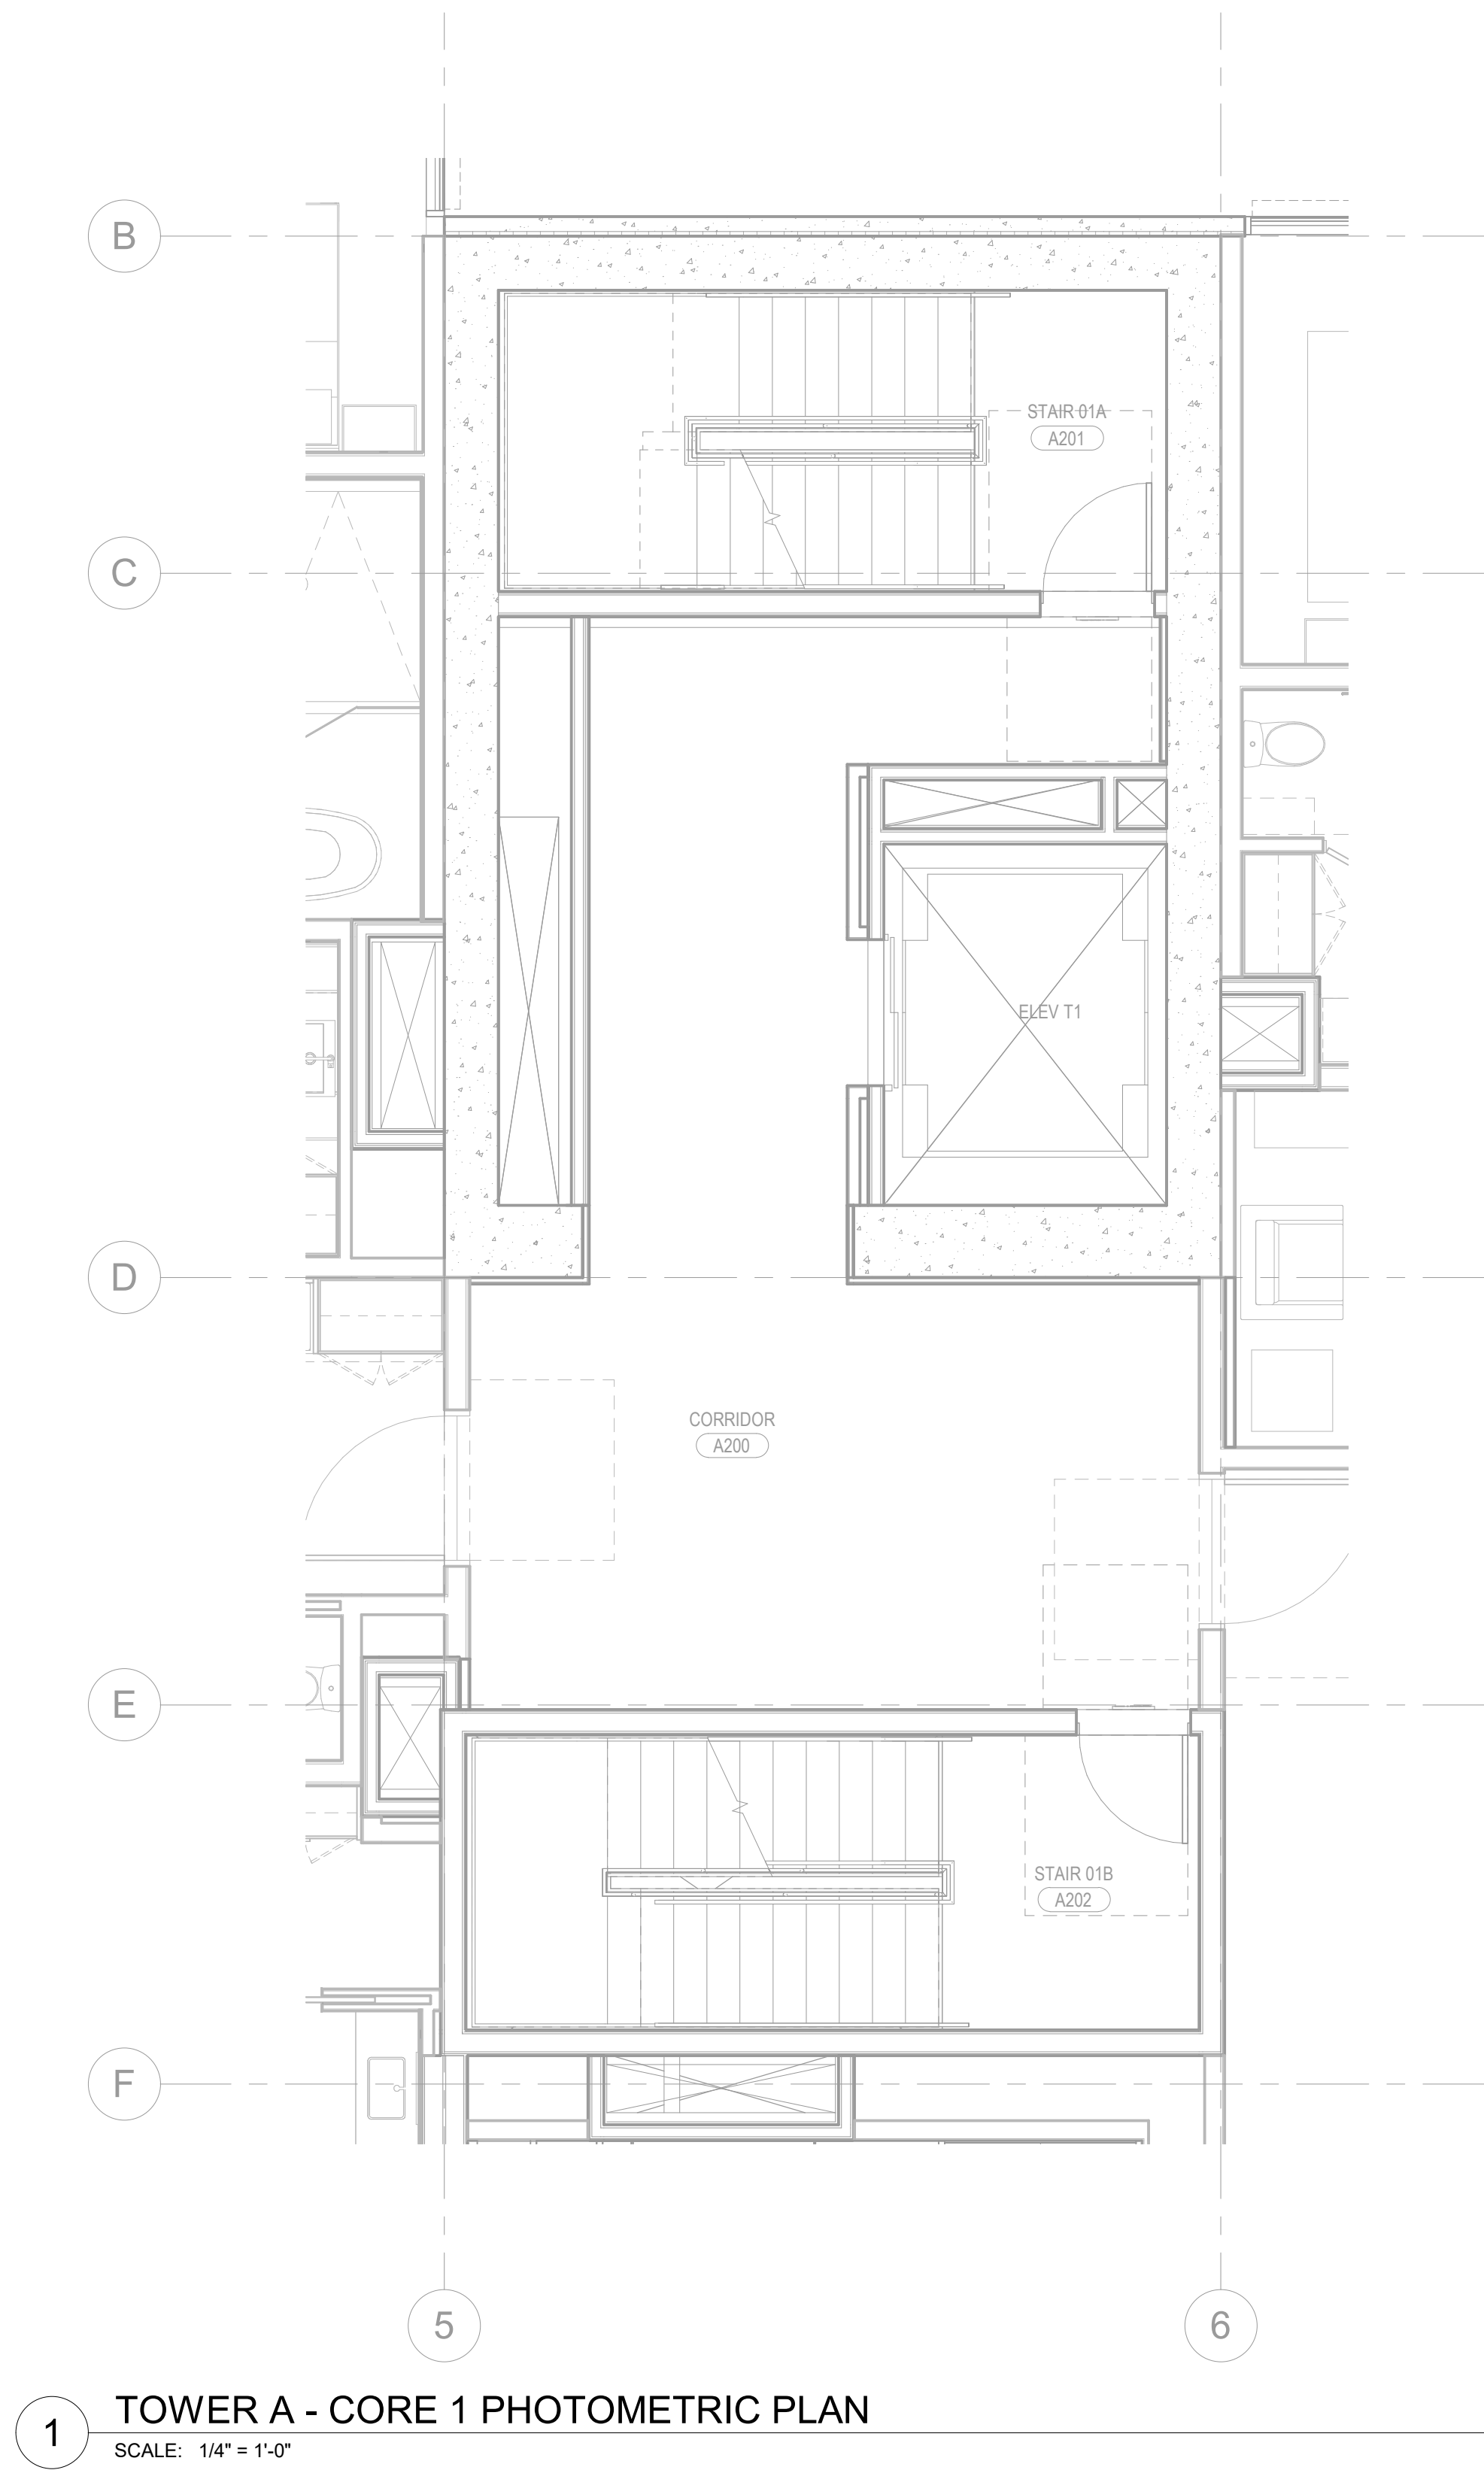

159 South Jackson St, Suite 800
Seattle, Washington 98104 USA
+1 206 624 5670 disontkundig.com

project:
SOMMET BLANC
9300 Marsac Ave (B2 East Parcel)
Redd, Calif. 94068

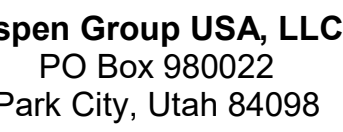

Edward H2O
6 N University Ave, Suite 290
Provo, UT 84604

dscape Architects
G Design
 9 South High Tech Drive, Suite 10
 Layton, Utah 84047

Day Group
Mainelli Road
Dalebury, VT

Life Consultant
James
1st Avenue, Suite 200A
Seattle, WA 98104

John Hughes
Research Drive, Suite 305C
Westborough, MA 01581

Michael Bates
15 North Creek Parkway, Suite 300
Bellevue, WA 98011

Structural Engineer
Ingnesson Klemencic Associates
115th Ave, Suite 3200
Seattle, WA 98101

9 SE MLK Blvd, Suite 210
Portland, Oregon 97219

H
1 N 34th St
Seattle, WA 98103

Feasibility Consultant
Radio Pacifica
4 Westlake Ave N, Suite F
Seattle, WA 98109

P Engineer
P USA
1 Fourth Ave., Suite 3100
Seattle, WA 98154



ons:

date	b

11/18/2022

GRESS LIGHTING LEVEL CALCULATION - POWER A LEVEL B1

E0.04

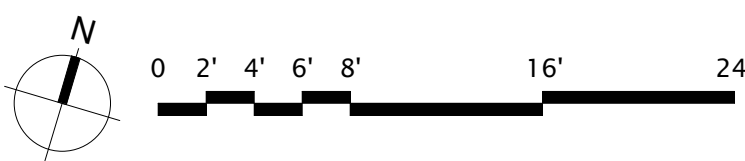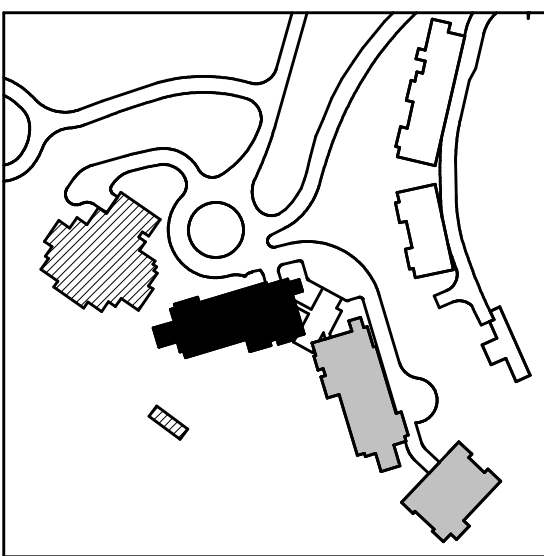

159 South Jackson St., Suite 600
Seattle, Washington 98104 USA
+1 206 624 5670 olsonkundig.com

Olson Kundig

project:
SOMMET BLANC
9300 Marsac Ave (B2 East Parcel)
Oak Creek, WI 53090



Aspen Group USA, LLC
PO Box 980022
Park City, Utah 84098

Pool Consultant
Cloward H2O
2696 N University Ave, Suite 290
Provo, UT 84604

Landscape Architect
EPG Design
6949 South High Tech Drive, Suite 100
Midvale, Utah 84047

Specifications Writer
Friday Group
88 Mainelli Road
Middlebury, VT

Code Consultant
Holmes
600 1st Avenue, Suite 200A
Seattle, WA 98104

Fire Protection Engineer
Jensen Hughes
One Research Drive, Suite 305C
Westborough, MA 01581

Vertical Transportation Consultant
Lerch Bates
19515 North Creek Parkway, Suite 3
Bothell, WA 98011

Structural Engineer
Magnusson Klemencic Associates
1301 5th Ave, Suite 3200
Seattle, WA 98101

Lighting Designer
O-
1319 SE MLK Blvd, Suite 210
Portland, Oregon 97219

Building Envelope Consultant
RDH
2101 N 34th St
Seattle, WA 98103

Accessibility Consultant
Studio Pacifica
2144 Westlake Ave N, Suite F
Seattle, WA 98109

MEP Engineer
WSP USA
1001 Fourth Ave., Suite 3100
Seattle, WA 98154

principal architect_____

drawn by _____

checked by Checker
job no.

date 11/18/2022

no.	date	
-----	------	--

ISSUE FOR
CONSTRUCTION

11/18/2022



EGRESS LIGHTING LEVEL CALCULATION


TOWER A LEVEL 1

E0.03





1 TOWER A - LEVEL 1 PHOTOMETRIC PLAN
SCALE: 1/8" = 1'-0"

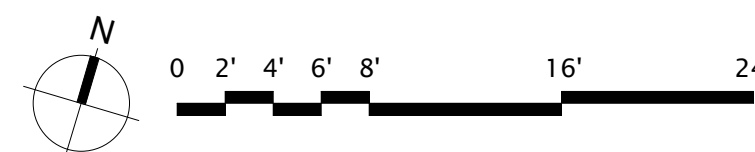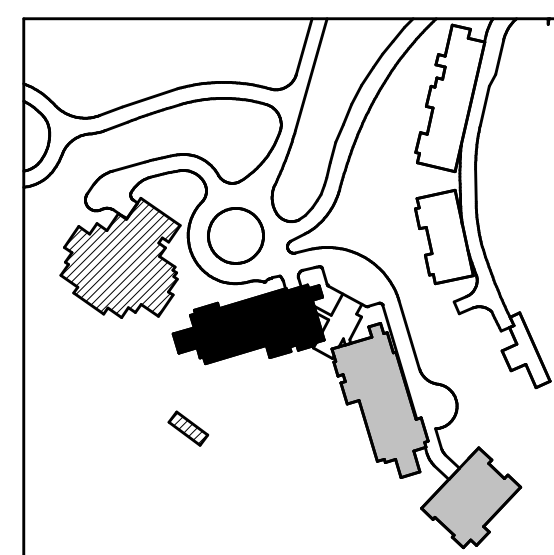

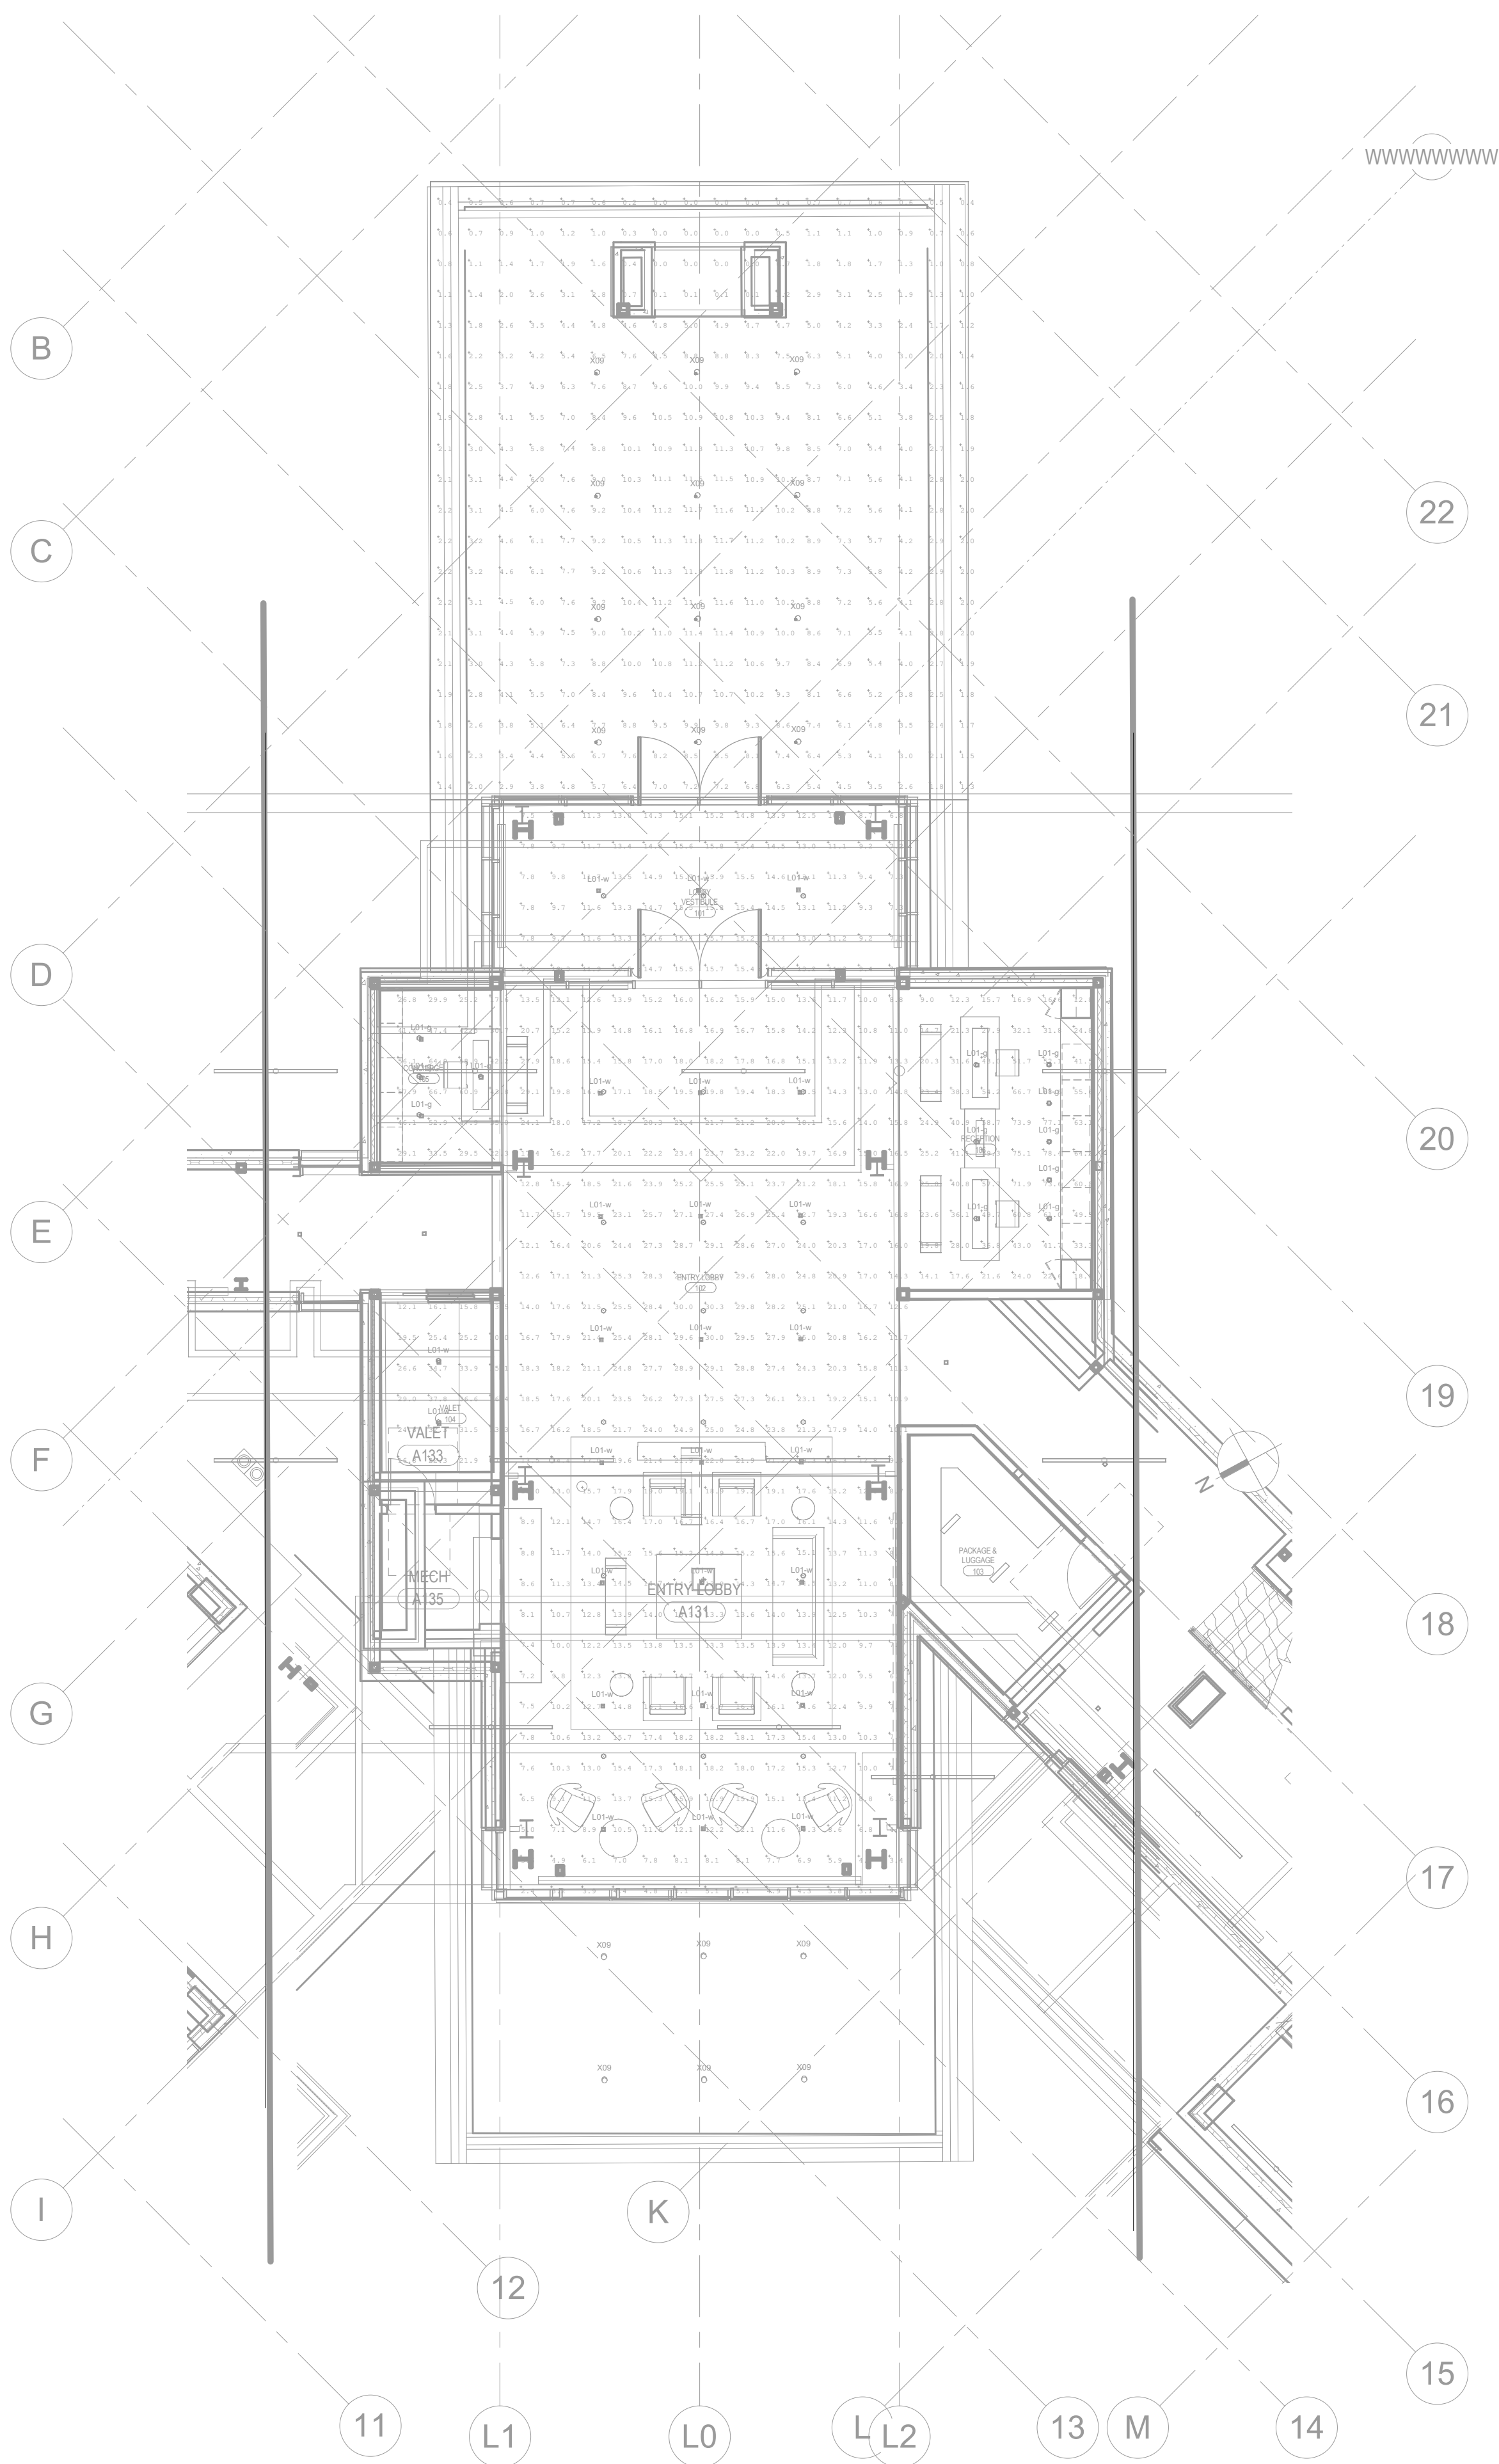

1 TOWER A/B - LEVEL 1 LOBBY PHOTOMETRIC PLAN
SCALE: 1/8" = 1'-0"

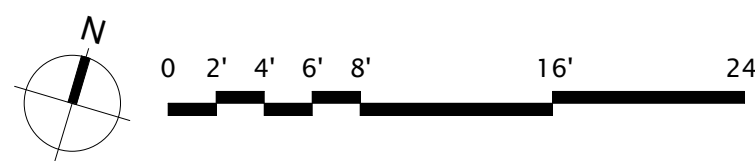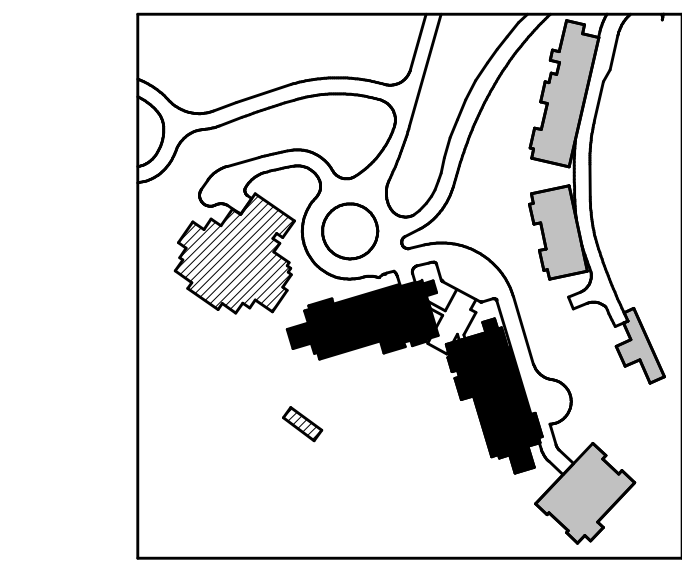

Reserved for permit stamp

100 South Jackson St, Suite 600
Seattle, Washington 98104 USA
+1 206 834 2870 olsonkunding.com

Olson Kunding

project
SOMMET BLANC
8900 Marsac Ave (B2 East Parcel)
Park City, Utah 84060



Aspen Group USA, LLC
PO Box 980022
Park City, Utah 84098

Pool Consultant
Cloward H2O
2698 N University Ave, Suite 290
Provo, UT 84604

Landscape Architect
EPG Design
6948 South High Tech Drive, Suite 100
Midvale, Utah 84047

Specifications Writer
Friday Group
86 Mainelli Road
Middlebury, VT

Code Consultant
Holmes
600 1st Avenue, Suite 200A
Seattle, WA 98104

Fire Protection Engineer
Jensen Hughes
One Research Drive, Suite 305C
Westborough, MA 01581

Vertical Transportation Consultant
Larch Bates
19515 North Creek Parkway, Suite 304
Bothell, WA 98011

Structural Engineer
Magnusson Klemencic Associates
1301 5th Ave, Suite 3200
Seattle, WA 98101

Lighting Designer
O
1319 SE MLK Blvd, Suite 210
Portland, Oregon 97219

Building Envelope Consultant
RDH
2101 N 34th St
Seattle, WA 98103

Accessibility Consultant
Studio Pacifica
2144 Westlake Ave N, Suite F
Seattle, WA 98109

MEP Engineer
WSP USA
1001 Fourth Ave., Suite 3100
Seattle, WA 98154

principal architect _____
project manager _____
drawn by _____
checked by _____
job no. _____
date 11/18/2022

revisions:

no. date by


ISSUE FOR
CONSTRUCTION
11/18/2022

EGRESS LIGHTING
LEVEL CALCULATION -
TOWER AB LOBBY

E0.06



1 TOWER B - PARKING LEVEL 1 PHOTOMETRIC PLAN
SCALE: 1/8" = 1'-0"

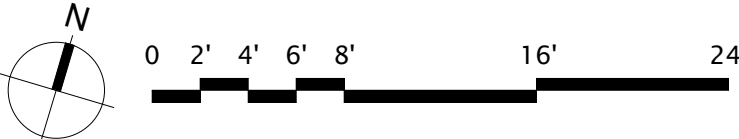

NUMBERED NOTES:

Reserved for permit stamp

109 South Jackson St., Suite 600
Seattle, Washington 98104 USA
+1 206 834 2670 olsonkundig.com

Olson Kundig

project
SOMMET BLANC
8900 Marzac Ave (B2 East Parcel)
Park City, Utah 84060



Aspen Group USA, LLC
PO Box 980022
Park City, Utah 84098

Pool Consultant
Cloward M20
2696 N University Ave, Suite 290
Provo, UT 84604

Landscape Architect
EPG Design
6948 South High Tech Drive, Suite 100
Midvale, Utah 84047

Specifications Writer
Friday Group
86 Mainelli Road
Middletown, VT

Code Consultant
Holmes
600 1st Avenue, Suite 200A
Seattle, WA 98104

Fire Protection Engineer
Jensen Hughes
One Research Drive, Suite 305C
Westborough, MA 01581

Vertical Transportation Consultant
Larch Bates
19515 North Creek Parkway, Suite 304
Bothell, WA 98011

Structural Engineer
Magnusson Klemencic Associates
1301 5th Ave, Suite 3200
Seattle, WA 98101

Lighting Designer
O
1319 SE MLK Blvd, Suite 210
Portland, Oregon 97219

Building Envelope Consultant
RDH
2101 N 34th St
Seattle, WA 98103

Accessibility Consultant
Studio Pacifica
2144 Westlake Ave N, Suite F
Seattle, WA 98109

MEP Engineer
WSP USA
1001 Fourth Ave., Suite 3100
Seattle, WA 98154

principal architect _____
project manager _____
drawn by _____
checked by: Checker _____
job no. _____
date: 11/18/2022

revisions:

no. date by

ISSUE FOR
CONSTRUCTION
11/18/2022


EGRESS LIGHTING
LEVEL CALCULATION -
TOWER B LEVEL P1

E0.07

159 South Jackson St, Suite 800
Seattle, Washington 98104 USA
+1 206 624 5670 olsonkundig.com

Olson Kundig

SOMMET BLANC
9300 Marsac Ave (B2 East Parcel)
Bucks City, IL 62530 84080

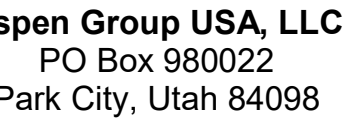

Edward H20
6 N University Ave, Suite 290
Provo, UT 84604

3 Design
9 South High Tech Drive, Suite 10
Provo, Utah 84047

Day Group
Mainelli Road
Middlebury, VT

James
1st Avenue, Suite 200A
Seattle, WA 98104

John Hughes
Research Drive, Suite 305C
Westborough, MA 01581

Michael Bates
15 North Creek Parkway, Suite 300
Bellevue, WA 98011

Structural Engineer
Ingusson Klemencic Associates
1151 5th Ave, Suite 3200
Seattle, WA 98101

9 SE MLK Blvd, Suite 210
Portland, Oregon 97219

H
1 N 34th St
ttle, WA 98103

Radio Pacifica
4 Westlake Ave N, Suite F
Seattle, WA 98109

P Engineer
P USA
1 Fourth Ave., Suite 3100
Seattle, WA 98154

Principal architect _____

project manager _____
drawn by _____

Drawn by _____

job no.

date 11/18/2022

ons:

date

Date	By

ISSUE FOR
CONSTRUCTION

11/18/2022



11/10/2022

LESS LIGHTING CALCULATION


FR B LEVEL 1

1000

E0.08

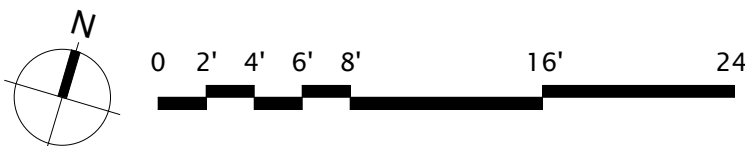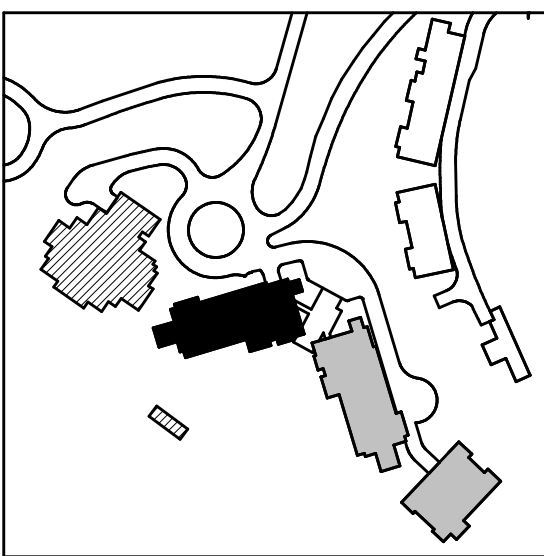

 1 TOWER B - LEVEL 1 PHOTOMETRIC PLAN
SCALE: 1/8" = 1'-0"



159 South Jackson St, Suite 600
Seattle, Washington 98104 USA
+1 206 624 5670 olsonlundig.com

Olson Kundig

project: **SOMMET BLANC**
9300 Marsac Ave (B2 East Parcel)
Park City, Utah 84060



Aspen Group USA, LLC
PO Box 980022
Park City, Utah 84098

Pool Consultant
Cloward H2O
2696 N University Ave., Suite 290
Provo, UT 84604

Landscape Architect
EPG Design
6949 South High Tech Drive, Suite 100
Midvale, Utah 84047

Specifications Writer
Friday Group
88 Mainelli Road
Middlebury, VT

Code Consultant
Holmes
600 1st Avenue, Suite 200A
Seattle, WA 98104

Fire Protection Engineer
Jensen Hughes
One Research Drive, Suite 305C
Weymouth, MA 01981

Vertical Transportation Consultant
Lerch Bates
19515 North Creek Parkway, Suite 304
Bethell, WA 98011

Structural Engineer
Magnusson Klemencic Associates
1301 5th Ave, Suite 3200
Seattle, WA 98101

Lighting Designer
O.
1319 SE MLK Blvd, Suite 210
Portland, OR 97202

Building Envelope Consultant
RDH
2101 N 34th St
Suite 100
Phoenix, AZ 85018
602.998.8888
rdh@rdhaz.com

Accessibility Consultant
Studio Pacifica
2144 Westlake Ave N, Suite F

MEP Engineer
WSP USA
1001 Fourth Ave., Suite 3100

principal architect _____

project manager _____
drawn by _____

checked by Charles

job no. _____

revisions:

no	date	by
----	------	----



CONSTRUCTION

11/10/2022

GRESS LIGHTING

POWER C LEVEL 1

F0 09

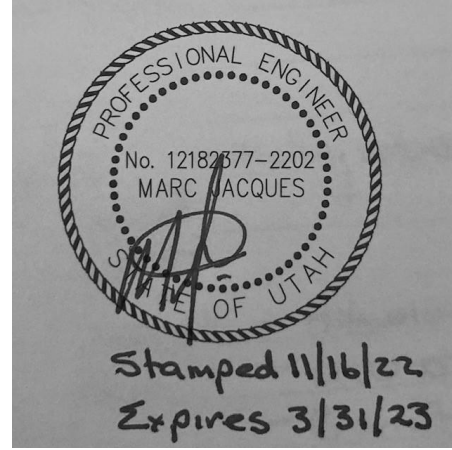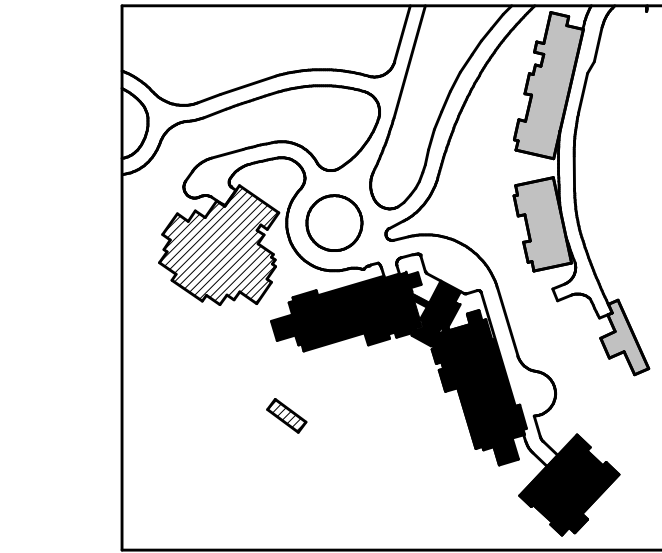

served for permit stamp

159 South Jackson St, Suite 800
Seattle, Washington 98104 USA
+1 206 624 5670 olsonkundig.com

Olson Kundig

project: **SOMMET BLANC**
9300 Marsac Ave (B2 East Parcel)



Aspen Group USA, LLC
PO Box 980022
Park City, Utah 84098

Pool Consultant
Cloward H2O
696 N University Ave, Suite 290
Provo, UT 84604

EPG Design
949 South High Tech Drive, Suite 100
Midvale, Utah 84047

Specifications Writer
Friday Group
8 Mainelli Road
Middlebury, VT

Code Consultant
Holmes
100 1st Avenue, Suite 200A
Seattle, WA 98104

Fire Protection Engineer
Jensen Hughes
One Research Drive, Suite 305C
Westborough, MA 01581

Vertical Transportation Consultant
Arch Bates
9515 North Creek Parkway, Suite 304
Bothell, WA 98011

Structural Engineer
Magnusson Klemencic Associates
301 5th Ave, Suite 3200
Seattle, WA 98101

Lighting Designer
319 SE MLK Blvd, Suite 210
Portland, Oregon 97219

Building Envelope Consultant
RDH
101 N 34th St
Seattle, WA 98103

Accessibility Consultant
Studio Pacifica
1144 Westlake Ave N, Ste 200
Seattle, WA 98109

MEP Engineer
WSP USA
1001 Fourth Ave., Suite 3100
Seattle, WA 98154

principal architect _____

project manager _____
drawn by _____

checked by Checker
job no.

date 11/18/2022

revisions:

no.	date	b.
-----	------	----

ISSUE FOR

 
ISSUE FOR
CONSTRUCTION

11/18/2022

ELECTRICAL SITE PLAN

■ 4.2.1


E1.01



159 South Jackson St, Suite 800
Seattle, Washington 98104 USA
206.624.5570 oleolefin.com

Olson Kundig

project;
SOMMET BLANC
33300 Marsac Ave (B2 East Parcel)
Grand, Calif. 94026

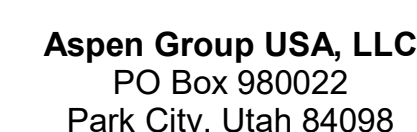

MEP Engineer
WSP USA
1001 Fourth Ave., Suite 3100
Seattle, WA 98154

revisions

no.	date	to	from	amount	balance
1	1/1/19				
2	1/1/19				
3	1/1/19				
86	1/1/19				

ISSUE FOR

11/18/2022

ELECTRICAL SITE LIGHTING DETAILS


E1.02

REFER TO BYLA SITE LIGHTING PLANS FOR AREAS THAT ARE NOT CONTROLLED BY BUILDING AUTOMATION SYSTEM. PROVIDE DEDICATED CONTROL PANEL FOR THESE AREAS.

Figure 1: Schematic diagram of the experimental setup. The diagram shows a subject sitting at a table, looking at a screen. The screen displays a 2D top-down view of a rectangular arena. The arena is divided into four quadrants by a central vertical line. The subject's head is positioned at the top left of the arena. The screen is labeled 'Screen' and the subject is labeled 'Subject'. The arena is labeled 'Arena'.


Figure 1 shows a schematic diagram of the experimental setup. It depicts a horizontal beam supported by a central pivot. A weight of 40.00 N is applied downwards at the center of the beam. The beam is divided into two sections, each 10.00 cm long, with a total length of 20.00 cm. The beam is supported by a central pivot, and the weight is applied downwards at the center. The beam is divided into two sections, each 10.00 cm long, with a total length of 20.00 cm.

 Figure 1 is a schematic diagram of a three-span continuous beam bridge. The bridge has three spans, each 30.0 m long, supported by three piers. The total length is 90.0 m. The diagram shows the bridge deck, piers, and the distribution of various loads. The top row of numbers represents dead load (kN/m), the middle row represents live load (kN/m), and the bottom row represents wind load (kN/m). The wind load is applied as a point load on the deck. The diagram also shows the bridge's cross-section with a height of 10.0 m and a width of 5.0 m.



Olson Kundig

project: **SOMMET BLANC**
9300 Marsac Ave (B2 East Parcel)
Park City, Utah 84060

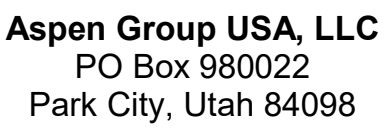


MEP Engineer
WSP USA
1001 Fourth Ave., Suite 3100
Seattle, WA 98154

visions:

date	b
------	---

 E1.03



7

ASPEN GROUP

Engineer
SA
North Ave., Suite 3100
WA 98154

ns:


date b7c

TRICAL SITE TING DETAILS

DARK SKY COMPLIANT RECESSED 4" DOWNLIGHT- 25 DEGREE OPTIC



A tall, black, modern street lamp stands in a snowy landscape. The lamp has a curved arm and a single light fixture. It is surrounded by snow-covered ground with sparse, low-lying vegetation. In the background, there are bare trees and a building with a dark roof. The sky is overcast.

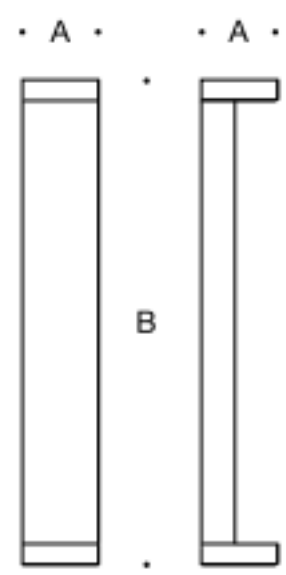

Shielded LED bollard · asymmetric				
	LED	A	B	Anchorage
99058	11.6W	7 1/2	39 3/8	79817

